



INTERSTATE HIGHWAY 45
(380' RIGHT-OF-WAY)

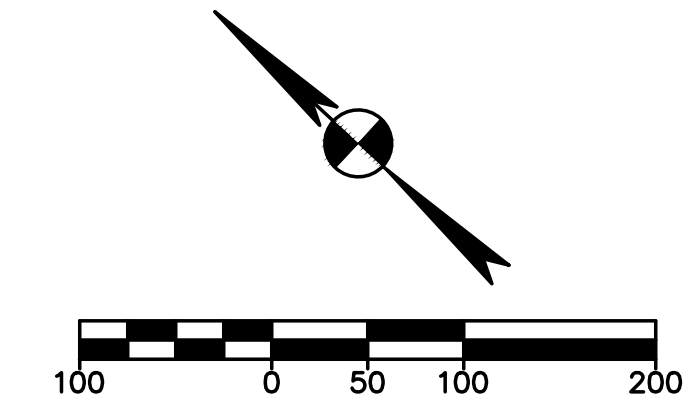

LEGEND

EXISTING	PROPOSED	DESCRIPTION
0000		PROPERTY (R.O.W.) LINE
XX	XX	RECORD INFORMATION
⊕	⊕	LIGHT POLE
⊕	⊕	POWER POLE
⊕	⊕	DOWN GUY
⊕	⊕	TRANSFORMER (SIZE VARIES)
⊕	⊕	FIRE HYDRANT
⊕	⊕	WATER VALVE
⊕	⊕	WATER METER
⊕	⊕	WATER METER VAULT
⊕	⊕	WATER MANHOLE
⊕	⊕	TELEPHONE RISER
⊕	⊕	CABLE TV RISER
⊕	⊕	ELECTRIC BOX
⊕	⊕	ELECTRIC METER
⊕	⊕	GAS METER
⊕	⊕	GAS VALVE
⊕	⊕	TRAFFIC CONTROL BOX
⊕	⊕	TRAFFIC SIGNAL POST
⊕	⊕	GRATE INLET
⊕	⊕	CURB INLET (SIZE VARIES)
⊕	⊕	GREASE TRAP (SIZE VARIES)
SS	SS	STORMSEWER LINE
W	W	WATER LINE
FL	FL	FIRE LINE
WW	WW	WASTEWATER LINE
G	G	FIRE LINE
E	E	GAS LINE
XX*OE	XX*OE	ELECTRIC LINE
XX*UT	XX*UT	OVERHEAD ELECTRIC
XX*UC	XX*UC	UNDERGROUND TELEPHONE
UC	UC	UNDERGROUND CABLE AND INTERNET
TC	TC	TELECOMMUNICATIONS LINE
EMH	EMH	ELECTRIC MANHOLE (SIZE VARIES)
WWMH	WWMH	WASTEWATER MANHOLE (SIZE VARIES)
SSMH	SSMH	STORMSEWER MANHOLE (SIZE VARIES)
TMH	TMH	TELEPHONE MANHOLE (SIZE VARIES)
CO	CO	WASTEWATER CLEANOUT
SW	SW	SAMPLE WELL
		CURB & CUTTER
		EDGE OF PAVEMENT
		DUMPSTER
		CONCRETE SIDEWALKS
		WALL
		FINISH FLOOR ELEVATION
678	678	CONTOUR

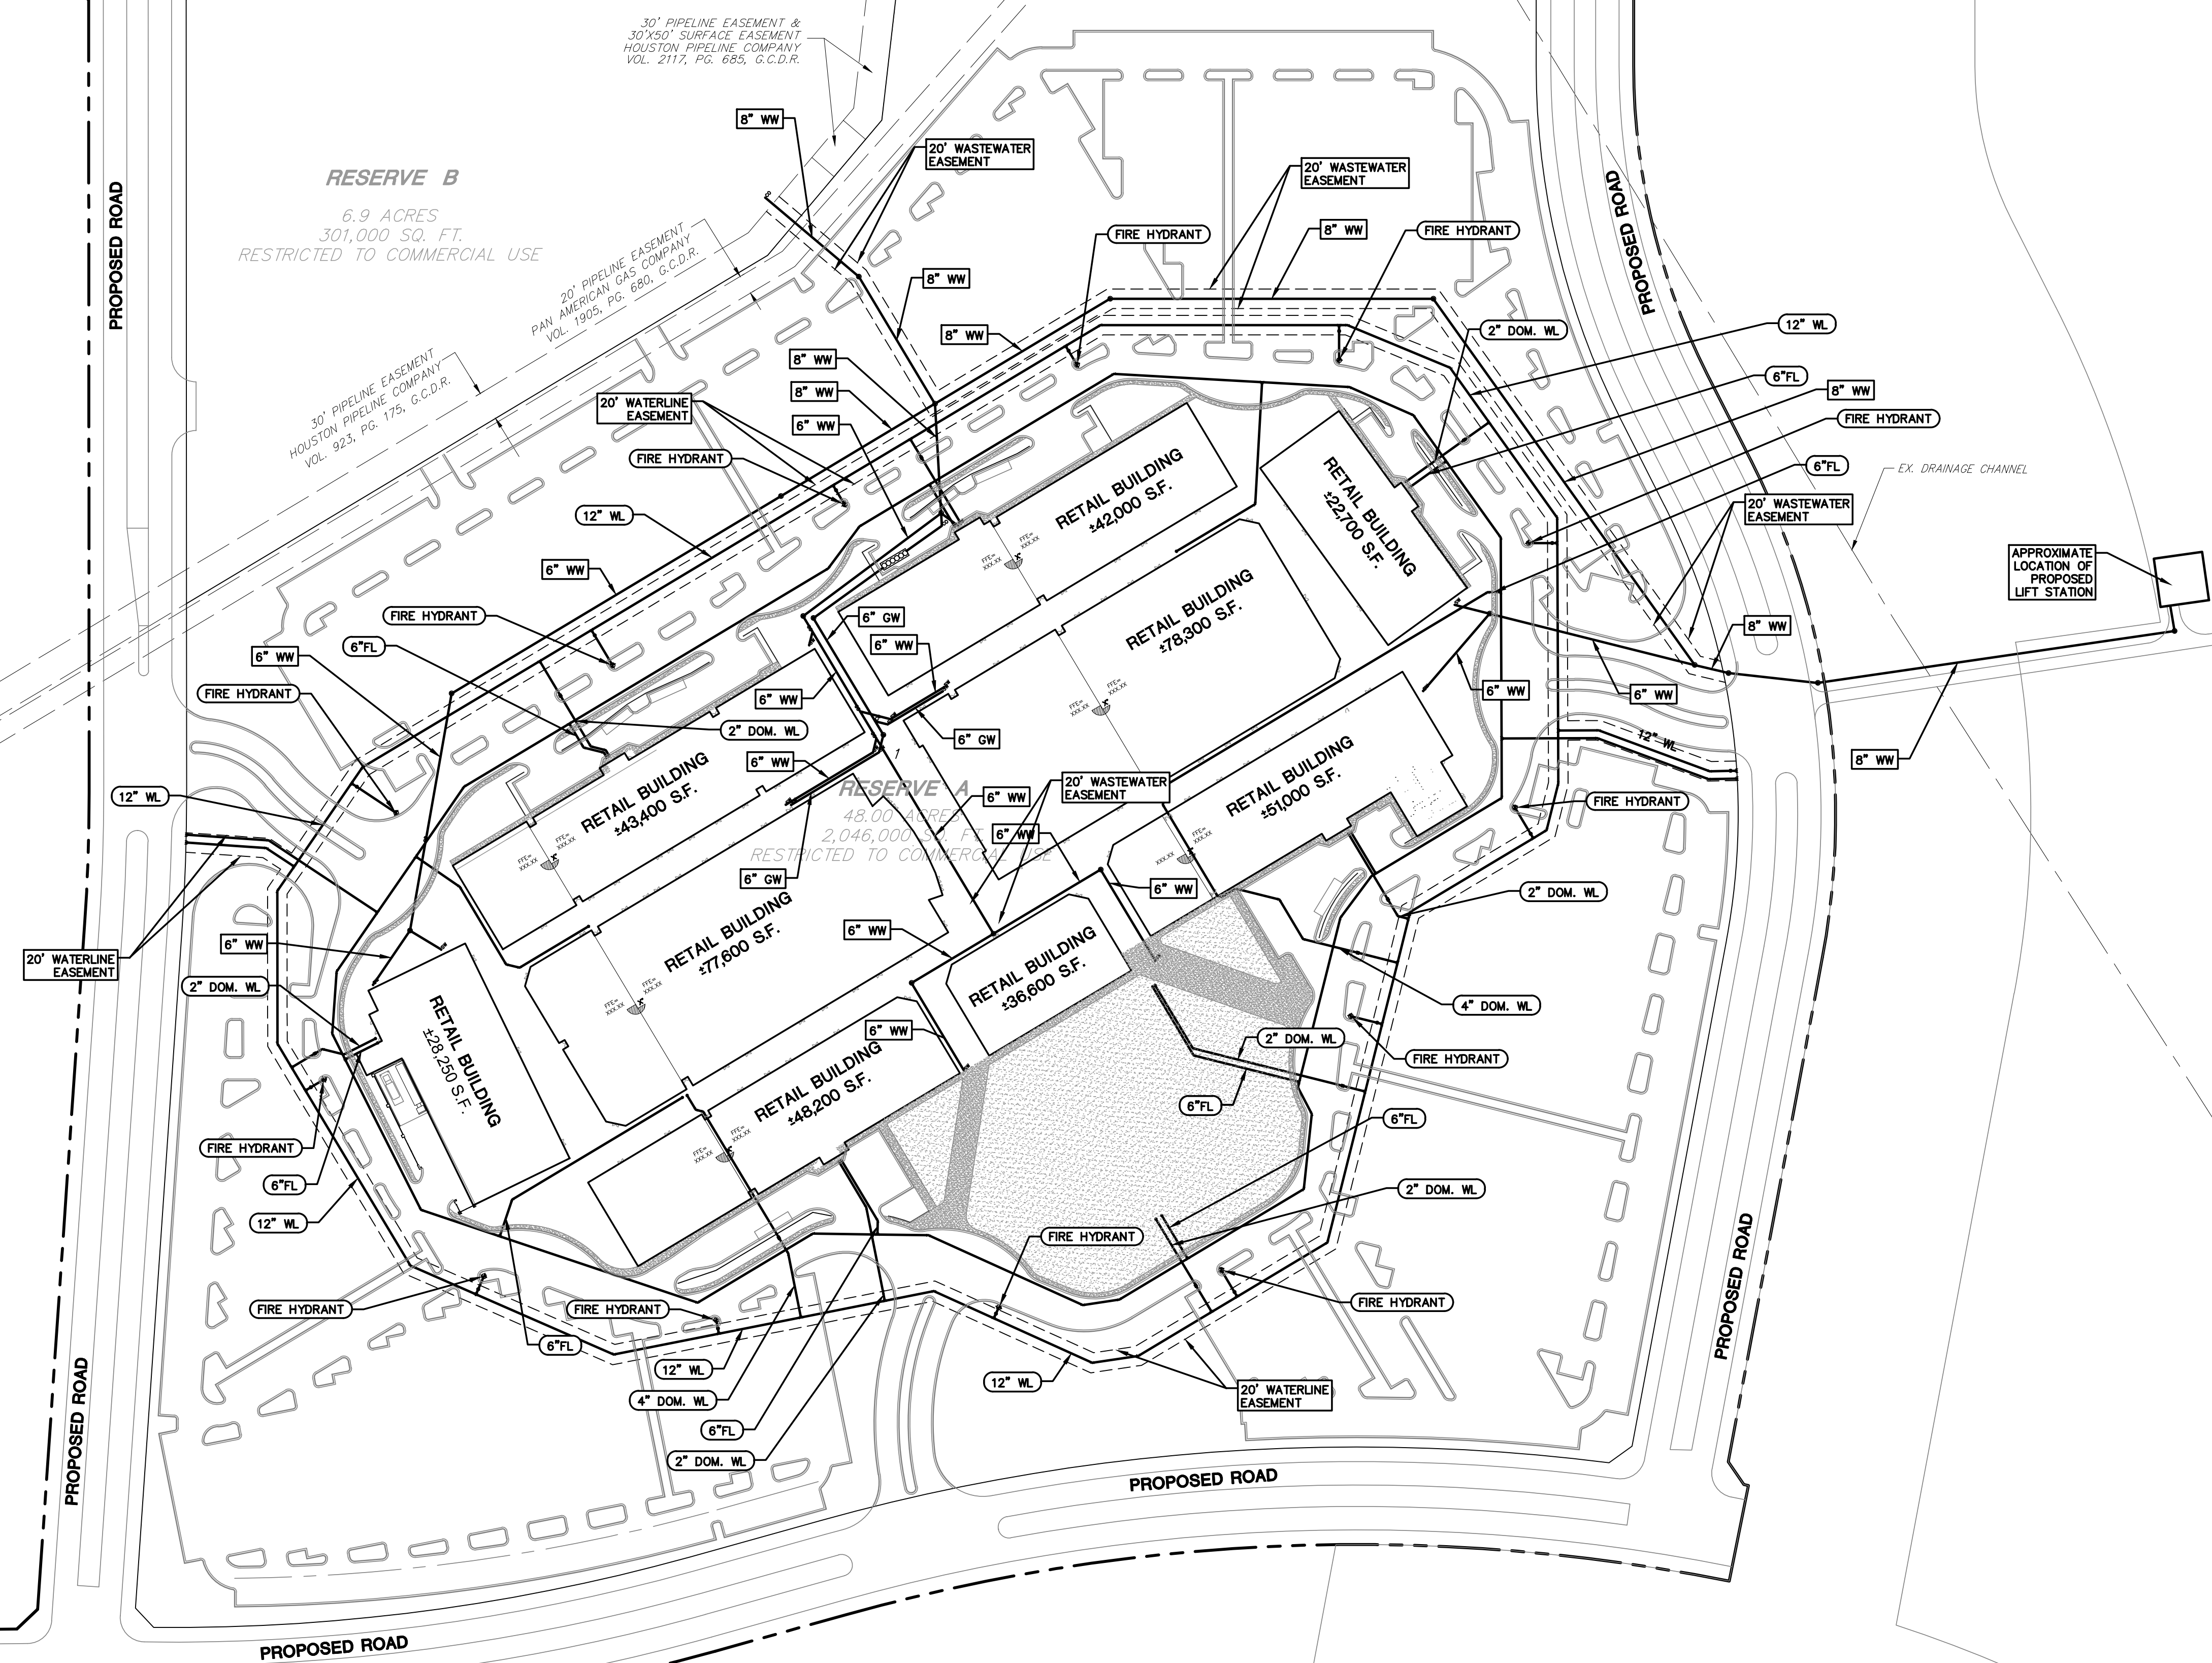

Bury+Partners
ENGINEERING SOLUTIONS
221 West 53rd Street, Suite 600
Austin, Texas 78701
Tel: (512) 938-0825
Fax: (512) 938-0811
TBB Registration Number F-1048
Bury+Partners, Inc. ©Copyright 2011

MASTER UTILITY PLAN

GALVESTON PREMIUM OUTLETS
TEXAS CITY, GALVESTON COUNTY, TEXAS
TBD GALVESTON PREMIUM OUTLETS, LLC

DRAWN BY: ML
DESIGNED BY: JAL/ML
REVIEWED BY: JAI
PROJECT NO.: 100716-70002.00

SHEET
29
OF 45

811
Know what's below.
Call before you dig.

THE LOCATION OF EXISTING UNDERGROUND UTILITIES ARE SHOWN IN AN APPROXIMATE WAY ONLY. THE CONTRACTOR SHALL DETERMINE THE EXACT LOCATION OF ALL EXISTING UTILITIES BEFORE COMMENCING WORK. HE AGREES TO BE FULLY RESPONSIBLE FOR ANY AND ALL DAMAGES WHICH MIGHT BE OCCASIONED BY HIS FAILURE TO EXACTLY LOCATE AND PRESERVE ANY AND ALL UNDERGROUND UTILITIES.

G:\100716\70002\100716002MUP01.dwg modified by ml@engr on Mar 16, 11 7:46 AM