



SCALE
 PLAN : 1" = 30'
 PROFILE
 HORIZ. : 1" = 30'
 VERT. : 1" = 10'

NOTE:
 -EXISTING UNDERGROUND INSTALLATIONS & PRIVATE UTILITIES SHOWN ARE INDICATED ACCORDING TO THE BEST INFORMATION AVAILABLE TO THE ENGINEER. THE ENGINEER DOES NOT GUARANTEE THE ACCURACY OF SUCH INFORMATION. SERVICE LINES (WATER, POWER, GAS, STORM, SEWER, TELEPHONE & TELEVISION) MAY NOT BE STRAIGHT LINES OR AS INDICATED ON THE PLANS. STATE LAW REQUIRES CONTRACTOR TO CALL ALL UTILITY COMPANIES BEFORE EXCAVATION FOR EXACT LOCATIONS.
 -ALL IMPROVEMENTS SHALL BE PERFORMED IN ACCORDANCE WITH MONTANA PUBLIC WORKS STANDARD SPECIFICATIONS 6TH EDITION, APRIL, 2010, AND THE CITY OF BILLINGS STANDARD MODIFICATIONS MANUAL, DATED FEBRUARY, 2011.
 -UNLESS OTHERWISE SPECIFIED, ALL CONSTRUCTION LAYOUT AND STAKING SHALL BE PERFORMED UNDER THE RESPONSIBLE CHARGE OF A LAND SURVEYOR LICENSED IN THE STATE OF MONTANA AND BY A PARTY CHIEF OR ENGINEERING TECHNICIAN EXPERIENCED IN CONSTRUCTION LAYOUT AND STAKING TECHNIQUES AS ARE REQUIRED BY THE SPECIFIC TYPE OF WORK BEING PERFORMED.

"CONFORMS TO CONSTRUCTION RECORDS"
APRIL 2014

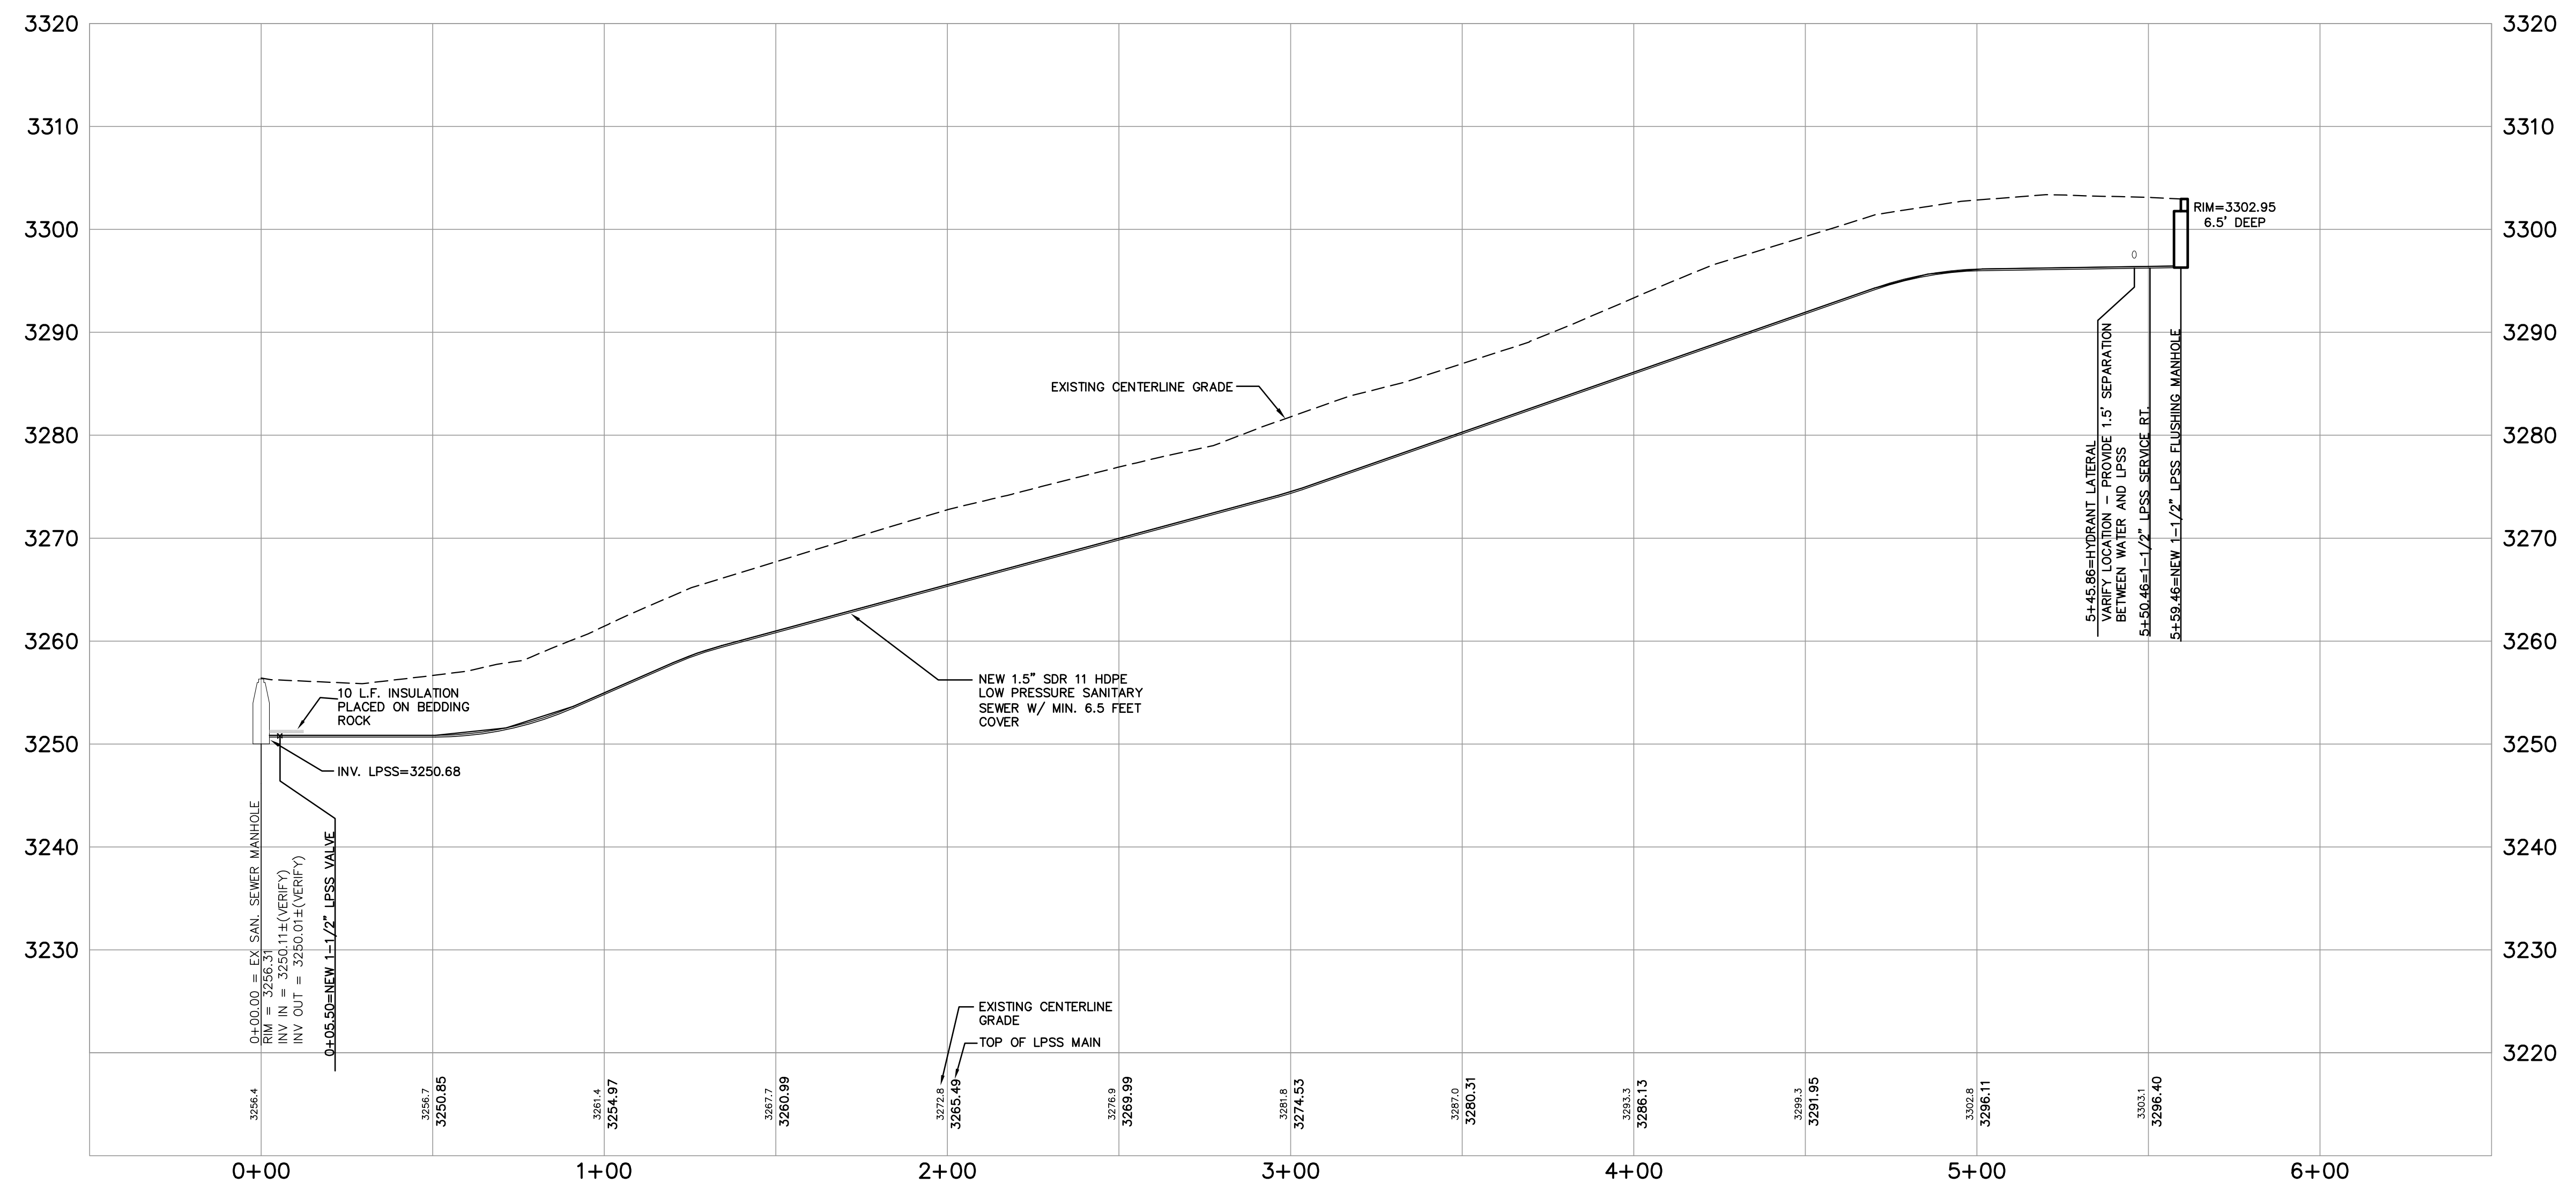

SANDERSON STEWART
 www.sandersonstewart.com

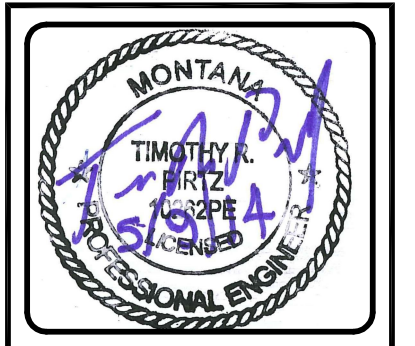

PRIVATE CONTRACT NO. 655
 TO PROVIDE SANITARY SEWER
 TO LOT 31-A, PANORAMIC HEIGHTS SUBDIVISION
 BILLINGS, MONTANA

LOW PRESSURE SANITARY SEWER PLAN AND PROFILE

C.A.D. TRP/LTS
 DATE: 2/13/13
 REVISIONS: 3/19/13
 5/9/14 A.B. BEG
 APPROVED BY: TRP
 QUALITY ASSURANCE:
 TB (2/19/13)
 SCALE: AS SHOWN
 FILE: POWELL_BASE
 PROJECT NO.: 10046
 SHEET 2 OF 3