


# Site Plan

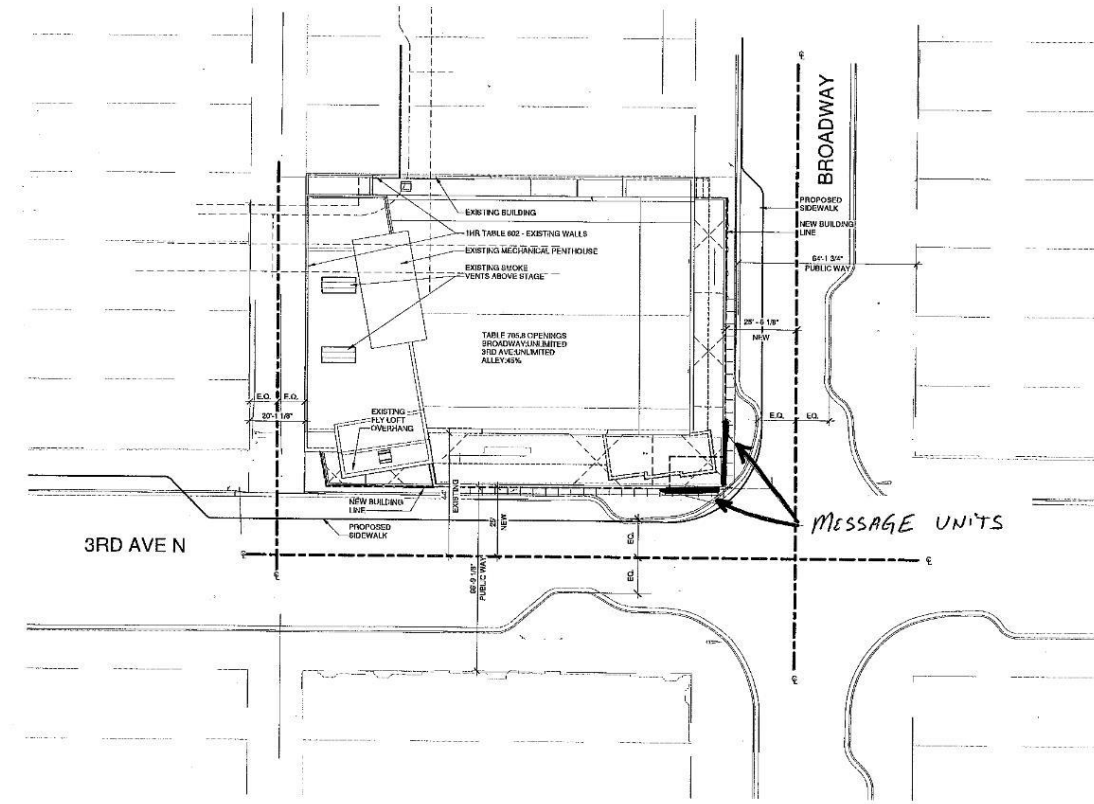

1 SITE PLAN  
1" = 20'-0"



# Photo Rendering

18'-0" 2' x 17' VIEWING AREA 57"

35"

**JAN 21 JIM BRICKMAN Pure Piano with the Allentown Symphony Orchestra**

ELECTRONIC MESSAGE UNITS SCALE: 1/8" = 1'-0"

**A** PROVIDE AND INSTALL TWO(2) ELECTRONIC MESSAGE UNITS, TIME-O-MATIC WATCHFIRE SERIES FULL COLOR LED UNITS, 10MM PIXEL PITCH WITH A 60 X 810 LAMP MATRIX, CAPABLE OF 7 LINES OF 3" CHARACTERS AND FULL ANIMATED GRAPHICS, DELL LAPTOP CONTROLLING COMPUTER, IGNIPE OPX CONTROLLING SOFTWARE, 4G WIRELESS MODEM WITH LIFE OF SIGN CELLULAR CONTRACT COMMUNICATIONS, TEMP SENSOR WITH 100 STEP PHOTO CELL, AND WEB BASED TRAINING ALL INCLUDED. MOUNT SIGNS TO CORNER OF BUILDING. FABRICATE BLACK METAL CORNER SECTION FILLER TO JOIN UNITS.

**DESIGN**  As Designed  With Changes

DATE: \_\_\_\_\_

BY: \_\_\_\_\_

PARTIAL SOUTH BUILDING ELEVATION SCALE: 3/16" = 1'-0"

PARTIAL EAST BUILDING ELEVATION SCALE: 3/16" = 1'-0"

This design is the property of SIGN PRODUCTS, INC. and is not to be reproduced or used in any form without the written permission of SIGN PRODUCTS, INC.

CLIENT: ALBERTA BAK THEATER, BELLEVILLE, MI  
 DATE: 09-19-20  
 SCALE: 1/8" = 1'-0"  
 DESIGN: TONY D.  
 DRAWN: TONY D.  
 CHECKED: TONY D.  
 APPROVED: TONY D.

**SIGN PRODUCTS, INC.**  
 ALBERTA BAK THEATER  
 1432 N. WINDY HILLS, MI 48106  
 PHONE: 313.281.1800