



EBI Consulting
environmental | engineering | due diligence

6876 Susquehanna Trail South
York, PA 17403
Tel: (717) 428-0401
www.ebiconsulting.com

August 16, 2019

Burnet County
c/o Janet Parker, County Clerk
220 S. Pierce Street
Burnet, Texas 78611
(512) 756-5406

Subject: Invitation to Comment
19-10371 / Bloomquist Tower
Approximately 0.5 miles east of FM 2342, Kingsland, Burnet County, TX
EBI Project # 6119003166

Dear Ms. Parker:

Pursuant to Section 106 of the National Historic Preservation Act, the regulations promulgated thereunder and interagency agreements developed thereto, EBI Consulting, Inc. on behalf of Interstate Wireless Inc. provides this notice of a proposed telecommunications facility installation at the address listed above.

EBI would like to inquire if you would be interested in commenting on this proposed project. Please refer to the attached project plans for complete details regarding this proposed project.


Please note that we are requesting your review of the attached information as part of the Section 106 process only and not as part of the local zoning process. We are only seeking comments related to the proposed project's potential effect to historic properties.

Please submit your comments regarding the proposed project's potential effect on historic properties to EBI Consulting, to my attention at 6876 Susquehanna Trail South, York, PA 17403 or contact me via telephone at the number listed below. Please reference the EBI project number. We would appreciate your comments as soon as possible within the next 30 days. Please do not hesitate to contact me if you have any questions or concerns about the proposed project.

Respectfully Submitted,

Sarah LeVaun Gaulty
Architectural Historian
srgaulty@ebiconsulting.com
T (802) 578-7030

Attachments - Drawings and Maps

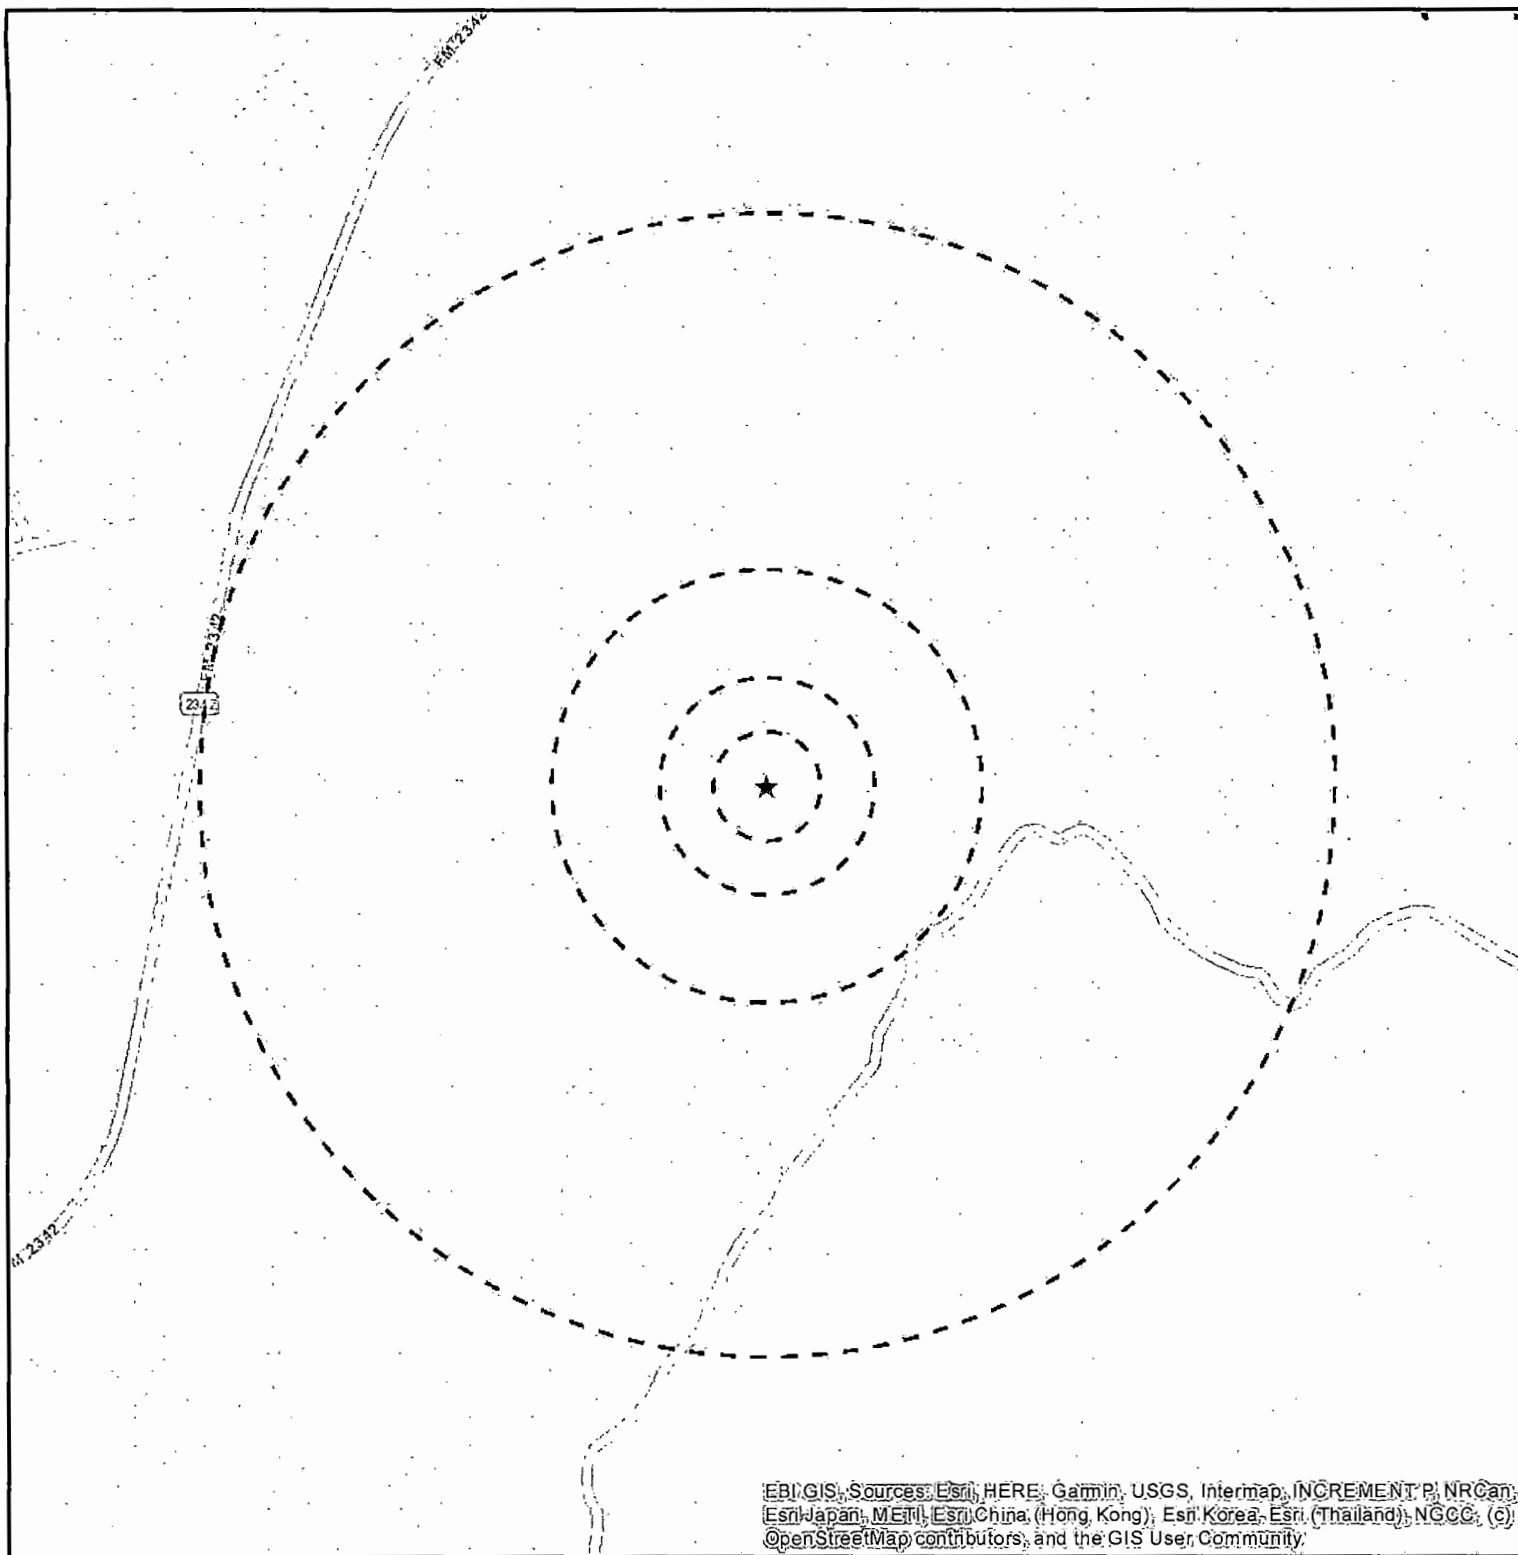

Legend

- ★ Project Site
- Site Radius at 250', 500', 1000' and 1/2 mile


Date: 8/2/2019

Figure 1: Site Location Map

19-10371 BLOOMQUIST TOWER

KINGSLAND, TX 78639



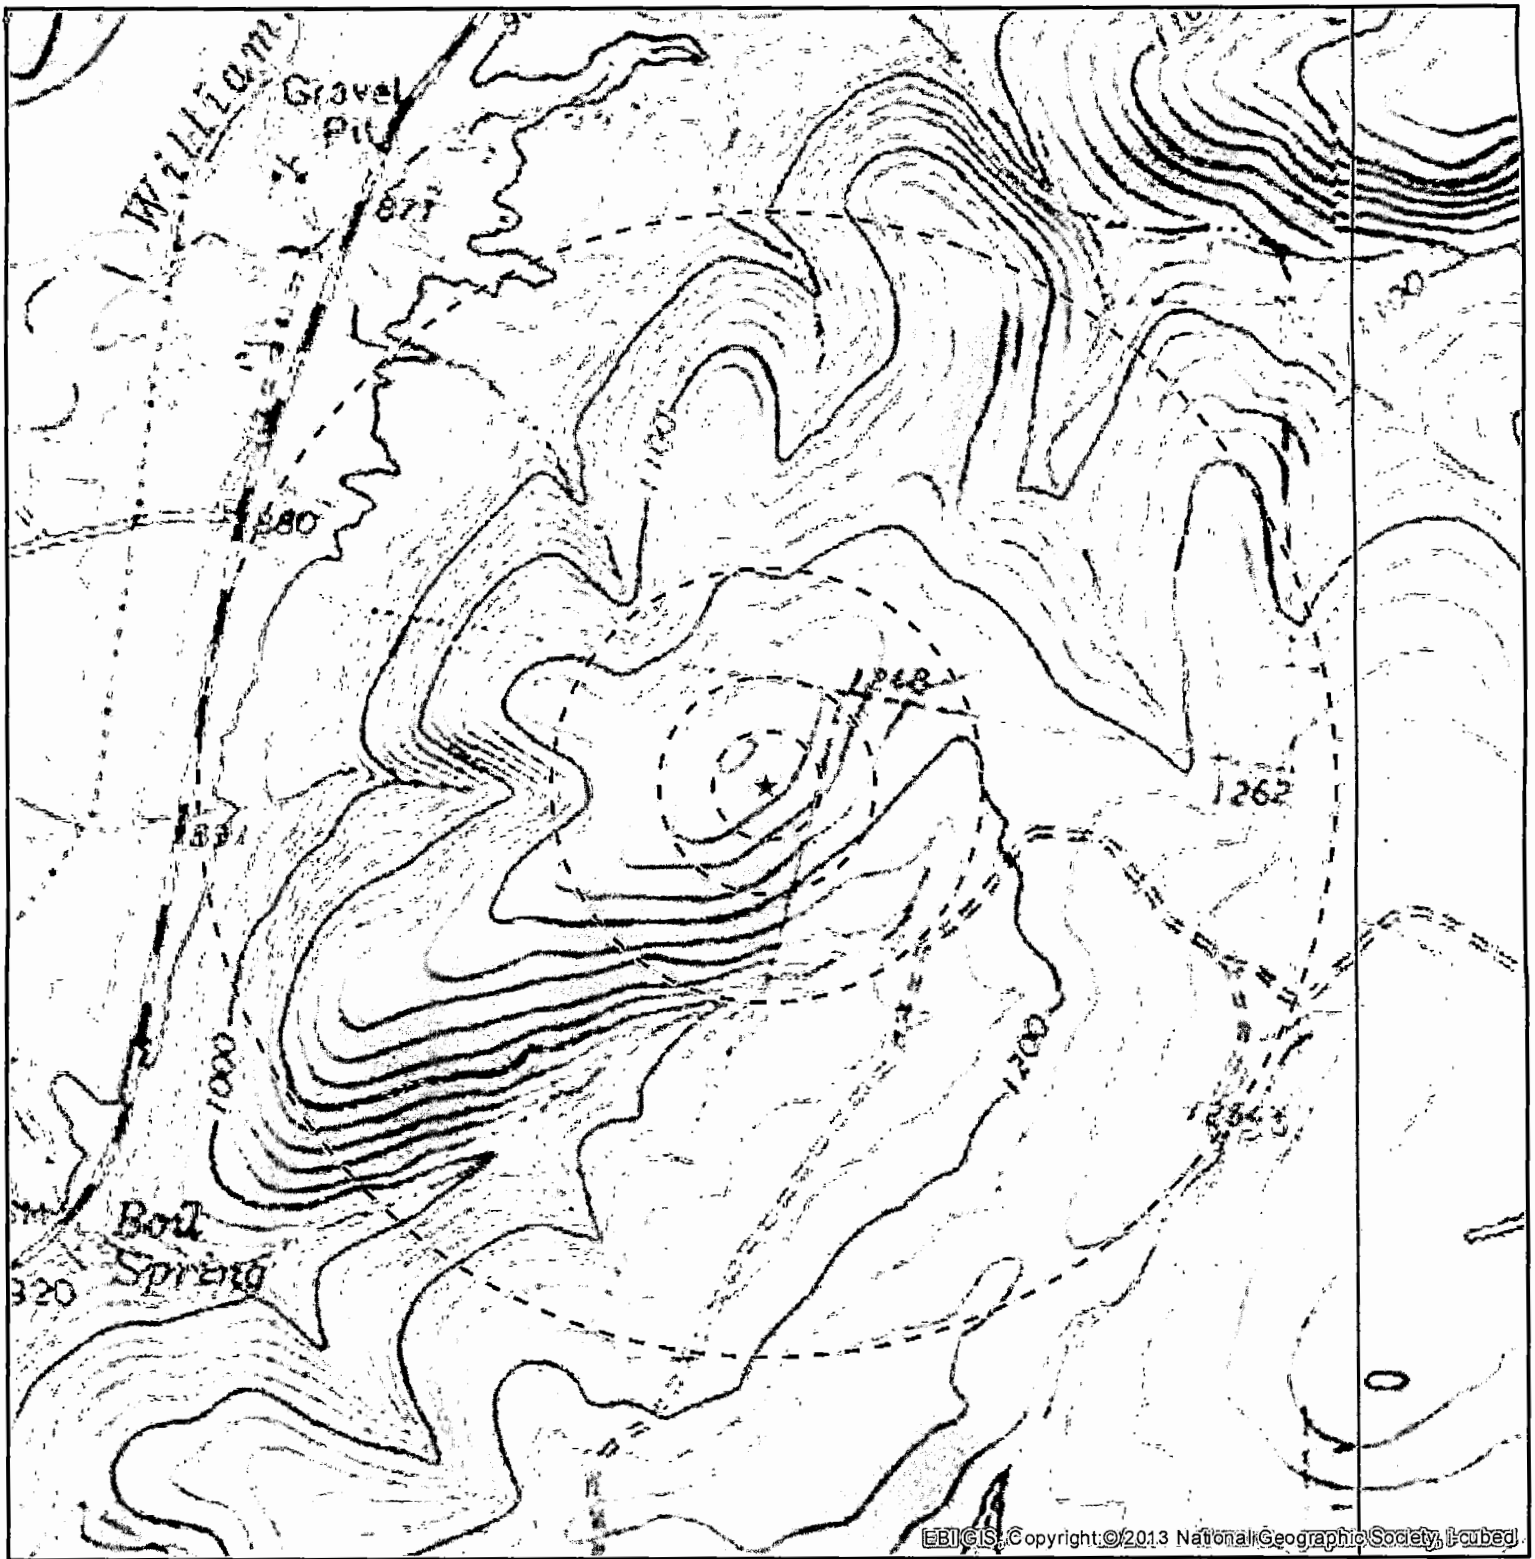

Legend

- ★ Project Site
- Site Radius at 250', 500', 1000' and 1/2 mile

USGS 24K Quad: Kingsland, TX 1982, Longhorn Cavern, TX 1986

Date: 8/13/2019

Figure 2 - Topographic Map

**19-10371 BLOOMQUIST TOWER
APPROX 0.5 MILES EAST OF FM 2342
KINGSLAND, TX 78639**

PN: 6119003166



NEW SITE BUILD

SITE NAME: BLOOMQUIST TOWER


SITE ADDRESS:

KINGSLAND, TX 78639
BURNET COUNTY COUNTY

SITE INFORMATION

SITE NAME: BLOOMQUIST TOWER
SITE ADDRESS: KINGSLAND, TX 78639
RFDS NAME: BLOOMQUIST TOWER
RFDS ID: NOT PROVIDED
RFDS DATE: NOT PROVIDED
RFDS VERSION: NOT PROVIDED
LATITUDE (NAD83): 30.678468° (N 30° 40' 42.483")
LONGITUDE (NAD83): -98.383689° (W -98° 23' 01.279")
ROUND ELEVATION: 207' (AMSL)
JURISDICTION: BURNET COUNTY
JURISDICTION CONTACT: CONTACT NAME:
PHONE: NOT PROVIDED
ZONING: NOT PROVIDED
TOWER OWNER:
CONTACT: NOT PROVIDED
PHONE: NOT PROVIDED
STRUCTURE TYPE: SELF SUPPORT TOWER
STRUCTURE HEIGHT: 190'-0" (AGL)
POWER SUPPLIER: POWER COMPANY:
TELCO PROVIDER: TELCO COMPANY:
NOT PROVIDED

VICINITY MAP

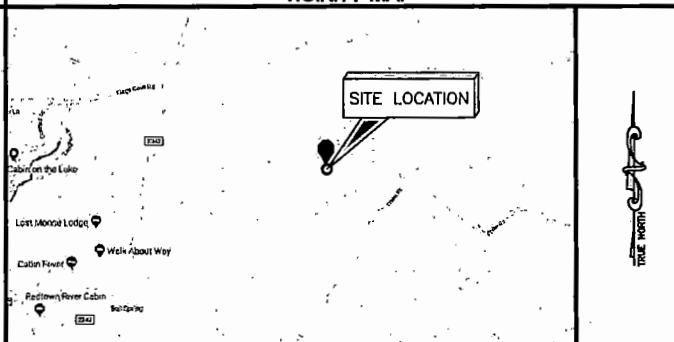

DIRECTIONS

MERGE ONTO TX-1 LOOP S AND TAKE THE EXIT TOWARD US 280/TX-71/SOUTHWEST PKWY. USE THE RIGHT LANE TO MERGE ONTO FRONTAGE RD/S MOPAC SERVICE RD, THEN TURN RIGHT ONTO SOUTHWEST PKWY. TURN RIGHT ONTO TX-71 W AND USE THE RIGHT LANE TO TAKE THE RAMP ONTO US-281 N. TURN LEFT ONTO RANCH RD 1431 W/10TH ST, THEN TURN RIGHT ONTO FM1880. CONTINUE ONTO CO RD 1980/FARM TO MARKET RD 1980, THEN CONTINUE ONTO FM1880. CONTINUE ONTO TOBYVILLE CEMETERY RD THEN TAKE SHARP RIGHT ONTO FAIRLAND RD. TURN LEFT ONTO CRIDER RD THEN SITE WILL BE LOCATED ON LEFT.

CODE COMPLIANCE

ALL WORK AND MATERIALS SHALL BE PERFORMED AND INSTALLED IN ACCORDANCE WITH THE CURRENT EDITIONS OF THE FOLLOWING CODES AS ADOPTED BY THE LOCAL GOVERNING AUTHORITIES. NOTHING IN THESE PLANS IS TO BE CONSTRUED TO PERMIT WORK NOT CONFORMING TO THE LATEST EDITIONS OF THE FOLLOWING CODES.

PROJECT TEAM

APPLICANT: EASTEX TOWER, LLC
3537 GUM SPRINGS ROAD
LONGVIEW, TX 75602
CONTACT: KEITH MATHENY
PHONE: (903) 234-9370
A&E FIRM: SMW ENGINEERING GROUP, INC.
158 BUSINESS CENTER DRIVE
BIRMINGHAM, AL 35244
PHONE: (205) 252-6885
ENGINEER: JEREMY D. SHARIT, PE 158
BUSINESS CENTER DRIVE
BIRMINGHAM, AL 35244
PHONE: (205) 252-6885

DRAWING INDEX

T-1	TITLE SHEET & PROJECT INFORMATION
GN-1	GENERAL NOTES
C-1	OVERALL SITE PLAN
C-2	DETAILED SITE PLAN
C-3	TOWER ELEVATION
C-4	EROSION CONTROL AND EXIT DETAILS
C-5	SITE SIGNAGE
C-6	FENCE DETAILS
C-6.1	FENCE DETAILS
C-7	GRAVEL ACCESS ROAD DETAILS
S-1	PAD DETAILS
E-1	ELECTRICAL NOTES
E-2	UTILITY SITE PLAN
E-3	OVERALL GROUNDING PLAN
E-4	GROUNDING DETAILS
E-4.1	GROUNDING DETAILS
E-5	COMMUNITY H-FRAME DETAILS

SCOPE OF WORK

THIS PROJECT CONSISTS OF:

- INSTALLATION OF UTILITIES TO SITE (IF REQUIRED)
- INSTALLATION OF H-FRAME FOR POWER PANEL AND METER/DISCONNECT
- INSTALLATION OF EQUIPMENT FOR UNMANNED TELECOMMUNICATIONS FACILITY
- INSTALLATION OF NEW SELF SUPPORT TOWER

DRAWING SCALE

THESE DRAWINGS ARE SCALED TO FULL SIZE AT 22"x34" AND HALF SIZE AT 11"x17". CONTRACTOR SHALL VERIFY ALL PLANS AND EXISTING DIMENSIONS AND CONDITIONS ON THE JOB SITE AND SHALL IMMEDIATELY NOTIFY THE DESIGNER / ENGINEER IN WRITING OF ANY DISCREPANCIES BEFORE PROCEEDING WITH THE WORK OR MATERIAL ORDERS OR BE RESPONSIBLE FOR THE SAME.

CA#: TX F-9617

**PRELIMINARY
DRAWING**
(NOT VALID UNLESS
STAMPED AND SIGNED)



TEXAS ONE-CALL
STATE WIDE: 811
CALL BEFORE YOU DIG



DATE: 07/29/19
DESCRIPTION: ISSUED FOR CLIENT REVIEW

BLOOMQUIST TOWER
TITLE SHEET &
PROJECT INFORMATION

DESIGNER: CM
CHECKED BY: SM
ENGINEER: JDS
SMW #19-10371
SHEET NO.:

T-1

GENERAL NOTES:

1. THE CONTRACTOR MUST VERIFY ALL DIMENSIONS, CONDITIONS AND ELEVATIONS BEFORE STARTING WORK. ALL DISCREPANCIES SHALL BE CALLED TO THE ATTENTION OF THE ENGINEER AND SHALL BE RESOLVED BEFORE PROCEEDING WITH THE WORK. ALL WORK SHALL BE PERFORMED IN A WORKMANLIKE MANNER IN ACCORDANCE WITH ACCEPTED CONSTRUCTION PRACTICES.
2. IT IS THE INTENTION OF THESE DRAWINGS TO SHOW COMPLETED INSTALLATION. THE CONTRACTOR SHALL BE RESPONSIBLE FOR ALL TEMPORARY BRACING, SHORING, TIES, FORM WORK, ETC. IN ACCORDANCE WITH ALL NATIONAL, STATE, AND LOCAL ORDINANCES, TO SAFELY EXECUTE ALL WORK AND SHALL BE RESPONSIBLE FOR SAME. ALL WORK SHALL BE IN ACCORDANCE WITH LOCAL ORDERS.
3. THE CONTRACTOR SHALL USE ADEQUATE NUMBER OF SKILLED WORKMEN WHO ARE THOROUGHLY TRAINED AND EXPERIENCED IN THE NECESSARY CRAFTS AND WHO ARE COMPLETELY FAMILIAR WITH THE SPECIFIED REQUIREMENTS AND METHOD NEEDED FOR PROPER PERFORMANCE OF THE WORK.
4. CONSTRUCTION CONTRACTOR AGREES THAT IN ACCORDANCE WITH GENERALLY ACCEPTED CONSTRUCTION PRACTICES, CONSTRUCTION CONTRACTOR WILL BE REQUIRED TO ASSUME SOLE AND COMPLETE RESPONSIBILITY FOR JOB SITE CONDITIONS DURING THE COURSE OF CONSTRUCTION OF THE PROJECT, INCLUDING THE SAFETY OF ALL PERSONS AND PROPERTY. THIS REQUIREMENT SHALL BE MADE TO APPLY CONTINUOUSLY AND NOT BE LIMITED TO NORMAL WORKING HOURS. CONSTRUCTION CONTRACTOR FURTHER AGREES TO INDEMNIFY AND HOLD DESIGN ENGINEER HARMLESS FROM ANY AND ALL LIABILITY, REAL OR ALLEGED, IN CONNECTION WITH PERFORMANCE OF WORK ON THIS PROJECT.
5. SITE GROUNDING SHALL COMPLY WITH TOWER OWNER GROUNDING STANDARDS, LATEST EDITION. WHEN NATIONAL AND LOCAL GROUNDING CODES ARE MORE STRINGENT THEY SHALL GOVERN. GROUNDING SHALL BE COMPLETED BEFORE ERECTION OF THE TOWER.
6. ALL WORK SHALL COMPLY WITH OSHA AND STATE SAFETY REQUIREMENTS. PROCEDURES FOR THE PROTECTION OF EXCAVATIONS, EXISTING CONSTRUCTION AND UTILITIES SHALL BE ESTABLISHED PRIOR TO FOUNDATION INSTALLATION. IF TEMPORARY LIGHTING AND MARKING IS REQUIRED BY THE FEDERAL AVIATION ADMINISTRATION (FAA), IT IS THE CONTRACTOR'S RESPONSIBILITY TO MAINTAIN THE NECESSARY LIGHTS AND NOTIFY THE PROPER AUTHORITIES IN THE EVENT OF A PROBLEM.
7. ALL WORK SHALL BE ACCOMPLISHED IN ACCORDANCE WITH ALL LOCAL, STATE, AND FEDERAL CODES AND ORDINANCES. THE MOST STRINGENT CODE WILL APPLY IN THE CASE OF DISCREPANCIES OR DIFFERENCES IN THE CODE REQUIREMENTS.
8. ANY DAMAGE TO ADJACENT PROPERTIES SHALL BE CORRECTED AT THE CONTRACTOR'S EXPENSE.
9. THE CONTRACTOR IS RESPONSIBLE FOR PROVIDING AMPLE NOTICE TO THE BUILDING INSPECTION DEPARTMENT TO SCHEDULE THE REQUIRED INSPECTIONS. A MINIMUM OF 24 HOURS OF NOTICE SHALL BE GIVEN AND THE BUILDING INSPECTION DEPARTMENTS HAVE REQUESTED THAT GROUPS OF TWO OR THREE SITES BE SCHEDULED AT ONE TIME IF POSSIBLE.
10. CONSTRUCTION MANAGER WILL CONFIRM FAA APPROVAL OF TOWER LOCATION BY ISSUING TOWER RELEASE FORM. NO TOWER SHALL BE CONSTRUCTED UNTIL THE TOWER RELEASE FORM IS ISSUED TO THE CONTRACTOR.
11. THE COMPLETE BID PACKAGE INCLUDES THESE CONSTRUCTION DRAWINGS ALONG WITH THE SPECIFICATIONS AND TOWER DRAWINGS. CONTRACTOR IS RESPONSIBLE FOR REVIEW OF TOTAL BID PACKAGE PRIOR TO BID SUBMITTAL.
12. CONTRACTOR SHALL VERIFY LOCATION OF ALL EXISTING UTILITIES WITHIN CONSTRUCTION LIMITS PRIOR TO CONSTRUCTION.
13. THE CONTRACTOR IS RESPONSIBLE FOR MAINTAINING POSITIVE DRAINAGE ON THE SITE AT ALL TIMES. SILT AND EROSION CONTROL SHALL BE MAINTAINED ON THE DOWNSTREAM SIDE OF THE SITE AT ALL TIMES. ANY DAMAGE TO ADJACENT PROPERTIES SHALL BE CORRECTED AT THE CONTRACTOR'S EXPENSE.
14. CLEARING OF TREES AND VEGETATION ON THE SITE SHOULD BE HELD TO A MINIMUM. ONLY THE TREES NECESSARY FOR CONSTRUCTION OF THE FACILITIES SHALL BE REMOVED. ANY DAMAGE TO PROPERTY OUTSIDE THE LEASE PROPERTY PROPERTIES SHALL BE CORRECTED AT THE CONTRACTOR'S EXPENSE.
15. ALL SUITABLE BORROW MATERIAL FOR BACK FILL OF THE SITE SHALL BE INCLUDED IN THE BID. EXCESS TOPSOIL AND UNSUITABLE MATERIAL SHALL BE DISPOSED OF OFF SITE AT LOCATIONS APPROVED BY GOVERNING AGENCIES PRIOR TO DISPOSAL.
16. SEEDING AND MULCHING OF THE SITE SHALL BE ACCOMPLISHED AS SOON AS POSSIBLE AFTER COMPLETION OF THE SITE DEVELOPMENT. THE CONTRACTOR IS RESPONSIBLE FOR PROVIDING AND MAINTAINING AN ADEQUATE COVER OF VEGETATION OVER THE SITE FOR A ONE YEAR PERIOD.
17. FOR ITEM THAT SHALL BE PROVIDED BY THE OWNER & INSTALLED BY THE CONTRACTOR, REF "OWNER SUPPLIED MATERIAL LIST" INSERTED IN THIS DRAWINGS PACKAGE.
18. OBTAIN AND PAY FOR REQUIRED PERMITS, LICENSES, FEES IN SECTIONS, ETC.
19. RECORD DRAWINGS: MAINTAIN A RECORD OF ALL CHANGES, SUBSTITUTIONS BETWEEN WORK AS SPECIFIED AND INSTALLED. RECORD CHANGES ON A CLEAN SET OF CONTRACT DRAWINGS WHICH SHALL BE TURNED OVER TO THE CONSTRUCTION MANAGER UPON COMPLETION OF THE PROJECT.
20. THE CONTRACTOR SHALL VISIT THE SITE BEFORE BIDDING ON THE WORK CONTAINED IN THIS DESIGN PACKAGE.

EXCAVATION & GRADING NOTES

1. ALL CUT & FILL SLOPES SHALL BE 3:1 MAXIMUM (UNLESS NOTED ON GRADING PLAN)
2. ALL EXCAVATIONS ON WHICH CONCRETE IS TO BE PLACED SHALL BE SUBSTANTIALLY HORIZONTAL ON UNDISTURBED AND UNFROZEN SOIL AND BE FREE FROM LOOSE MATERIAL AND EXCESS GROUND WATER. DEWATERING FOR EXCESS GROUND WATER SHALL BE PROVIDED IF REQUIRED.
3. CONCRETE FOUNDATIONS SHALL NOT BE PLACED ON ORGANIC MATERIAL. IF SOUND SOIL IS NOT REACHED AT THE DESIGNATED EXCAVATION DEPTH, THE UNSATISFACTORY SOIL SHALL BE EXCAVATED TO ITS FULL DEPTH AND EITHER BE REPLACED WITH MECHANICALLY COMPACTED GRANULAR MATERIAL OR THE EXCAVATION BE FILLED WITH CONCRETE OF THE SAME QUALITY SPECIFIED FOR THE FOUNDATION.
4. ANY EXCAVATION OVER THE REQUIRED DEPTH SHALL BE FILLED WITH EITHER MECHANICALLY COMPACTED GRANULAR MATERIAL OF CONCRETE OF THE SAME QUALITY SPECIFIED FOR THE FOUNDATION. CRUSHED STONE MAY BE USED TO STABILIZE THE BOTTOM OF THE EXCAVATION. STONE, IF USED, SHALL NOT BE USED AS COMPLYING CONCRETE THICKNESS.
5. AFTER COMPLETION OF THE FOUNDATION AND OTHER CONSTRUCTION BELOW GRADE, AND BEFORE BACK FILLING, ALL EXCAVATIONS SHALL BE CLEAN OF UNSUITABLE MATERIAL SUCH AS VEGETATION, TRASH, DEBRIS AND SO FORTH.
6. BACK FILL SHALL BE:
 - APPROVED MATERIALS CONSISTING OF EARTH, LOAMY, SANDY, CLAY SAND, GRAVEL OR SOFT SHALL;
 - FREE FROM CLODS OR STONES OVER 2" MAXIMUM DIMENSIONS;
 - IN LAYERS AND COMPACTED
7. SITE FILL MATERIAL AND FOUNDATION BACK FILL SHALL BE PLACED IN LAYERS, MAXIMUM 6" DEEP BEFORE COMPACTION. EACH LAYER SHALL BE SPRINKLED IF REQUIRED AND COMPACTED BY HAND OPERATED OR MACHINE TAMPERS TO 95% OF MAXIMUM DENSITY. AT THE OPTIMUM MOISTURE CONTENT $\pm 2\%$ AS DETERMINED BY ATM DESIGNATION D-698, UNLESS OTHERWISE APPROVED. SUCH BACK FILL SHALL NOT BE PLACED BEFORE 3 DAYS AFTER PLACEMENT OF CONCRETE.
8. THE FOUNDATION AREA SHALL BE GRADED TO PROVIDE WATER RUNOFF AND PREVENT WATER FROM STANDING. THE FINAL GRADE SHALL SLOPE AWAY IN ALL DIRECTIONS FROM THE FOUNDATION AND SHALL THEN BE COVERED WITH 4" DEEP COMPACTED STONE OR GRAVEL.
9. CONTRACTOR SHALL PROVIDE ALL EROSION AND SEDIMENTATION CONTROL MEASURES AS REQUIRED BY LOCAL CITY, PARISH AND STATE CODES AND ORDINANCES TO PROTECT EMBANKMENTS FROM SOIL LOSS AND TO PREVENT ACCUMULATION OF SOIL AND SILT IN STREAMS AND DRAINAGE PATHS LEAVING THE CONSTRUCTION AREA. THIS MAY INCLUDE SUCH MEASURES AS SILT FENCES, STRAW BALE SEDIMENT BARRIERS AND CHECK DAMS.
10. FILL PREPARATION: REMOVE ALL VEGETATION, TOPSOIL, DEBRIS, WET AND UNSATISFACTORY SOIL MATERIALS, OBSTRUCTIONS, AND DELETERIOUS MATERIALS FROM GROUND SURFACE PRIOR TO PLACING FILLS. FLOW STRIP OR BREAK UP SLOPED SURFACES STEEPER THAN 1 VERTICAL TO 4 HORIZONTAL SO FILL MATERIAL WILL BOND WITH EXISTING SURFACE. WHEN SUBGRADE OR EXISTING GROUND SURFACE TO RECEIVE FILL HAS A DENSITY LESS THAN THAT REQUIRED FOR FILL, BREAK UP GROUND SURFACE TO DEPTH REQUIRED, PULVERIZE, MOISTURE-CONDITION OR AERATE SOIL AND RECOMPACT TO REQUIRED DENSITY.
11. REPLACE THE EXISTING WEARING SURFACE ON AREAS WHICH HAVE BEEN DAMAGED OR REMOVED DURING CONSTRUCTION OPERATIONS. SURFACE SHALL BE REPLACE TO MATCH EXISTING ADJACENT SURFACING AND SHALL BE OF THE SAME THICKNESS. NEW SURFACE SHALL BE FREE FROM CORRUGATIONS AND WAVES. EXISTING SURFACING MAY BE EXCAVATED SEPARATELY AND REUSED IF INJURIOUS AMOUNTS OF EARTH, ORGANIC MATERIAL, OF OTHER DELETERIOUS MATERIALS ARE REMOVED PRIOR TO REUSE. FURNISH ALL ADDITIONAL RESURFACING MATERIAL AS REQUIRED. BEFORE SURFACING IS REPLACED, SUBGRADE SHALL BE GRADED TO CONFORM TO REQUIRED SUBGRADE ELEVATIONS, AND LOOSE OR DISTURBED MATERIALS SHALL BE THOROUGHLY COMPACTED. DEPRESSIONS IN THE SUBGRADE SHALL BE FILLED AND COMPACTED WITH APPROVED SELECTED MATERIAL. SURFACING SHALL NOT BE USED FOR FILLING DEPRESSIONS IN THE SUBGRADE.
12. PROTECT EXISTING SURFACING AND SUBGRADE IN AREAS WHERE EQUIPMENT LOADS WILL OPERATE. USE PLANKING OR OTHER SUITABLE MATERIALS DESIGNED TO SPREAD EQUIPMENT LOADS. REPAIR DAMAGE TO EXISTING GRAVEL SURFACING OR SUBGRADE WHERE SUCH DAMAGE IS DUE TO THE CONTRACTOR'S OPERATIONS. DAMAGED GRAVEL SURFACING SHALL BE RESTORED TO MATCH THE ADJACENT UNDAUNTED GRAVEL SURFACING AND SHALL BE OF THE SAME THICKNESS.
13. DAMAGE TO EXISTING STRUCTURES AND UTILITIES RESULTING FROM CONTRACTOR'S NEGLIGENCE SHALL BE REPAIRED / REPLACED TO OWNER'S SATISFACTION AT CONTRACTOR'S EXPENSE.
14. CONTRACTOR SHALL COORDINATE THE CONSTRUCTION SCHEDULE WITH PROPERTY OWNER SO AS TO AVOID INTERRUPTIONS TO PROPERTY OWNER'S OPERATIONS.
15. ENSURE POSITIVE DRAINAGE DURING AND AFTER COMPLETION OF CONSTRUCTION.
16. RIPRAP SHALL BE CLEAN, HARD, SOUND, DURABLE, UNIFORM IN QUALITY, AND FREE OF ANY DETRIMENTAL QUANTITY OF SOFT, FRAGILE, THIN, ELONGATED OR LAMINATED PIECES, DISINTEGRATED MATERIAL, ORGANIC

—X—	FENCE
—XXX—	CONTOUR LINE
----	PROPERTY LINE/ROW
----	LEASE AREA
----	EASEMENT
□	DISCONNECT SWITCH
⊖	METER
⊕	CIRCUIT BREAKER
⊖	CODED NOTE NUMBER
⊕	CHEMICAL GROUND ROD
⊖	GROUND ROD
⊕	GROUND ROD W/ INSPECTION SLEEVE
⊖	EXOTHERMIC WELD (COWELD) CONNECTION
⊕	MECHANICAL CONNECTION
⊖	COMPRESSION CONNECTION
—G—	GROUND WIRE



S.W. Engineering, Inc.
1117 East Spring Road
Suite 100
Fort Worth, TX 76102
Phone: 817-334-1070



DATE	DESCRIPTION
07/29/19	ISSUED FOR CLIENT REVIEW

DATE	DESCRIPTION
07/29/19	ISSUED FOR CLIENT REVIEW


DESIGNED BY:	CM
CHECKED BY:	SM
ENGINEER:	JDS
DWG #	19-10371
SHEET NO.	

GN-1

CA#: TX F-9617

**PRELIMINARY
DRAWING**
(NOT VALID UNLESS
STAMPED AND SIGNED)

SITE CLARENCE NOTE:
 CONTRACTOR SHALL CLEAR LEASE AREA OF ALL TREES, SHRUBS, ROCKS, SURFACE SOIL AND DEBRIS. EXCAVATE INTO SLOPES AND/OR ADD FILL DIRT WITH REQUIRED COMPACTION TO LEVEL THE COMPOUND. SITE SHALL BE GRADED TO ALLOW NATURAL DRAINAGE FROM THE COMPOUND. CONTRACTOR WILL GRADE THE AREA AROUND COMPOUND TO PREVENT SOIL EROSION AND ADHERE TO ALL LOCAL, STATE AND FEDERAL REGULATIONS. RETAINING WALLS AND RUP-RAP ARE OUT OF SCOPE AND WILL REQUIRE A CHANGE ORDER UNLESS INCLUDED IN THE CONSTRUCTION PLANS OR ADDED TO SCOPE DURING BID WALKS.

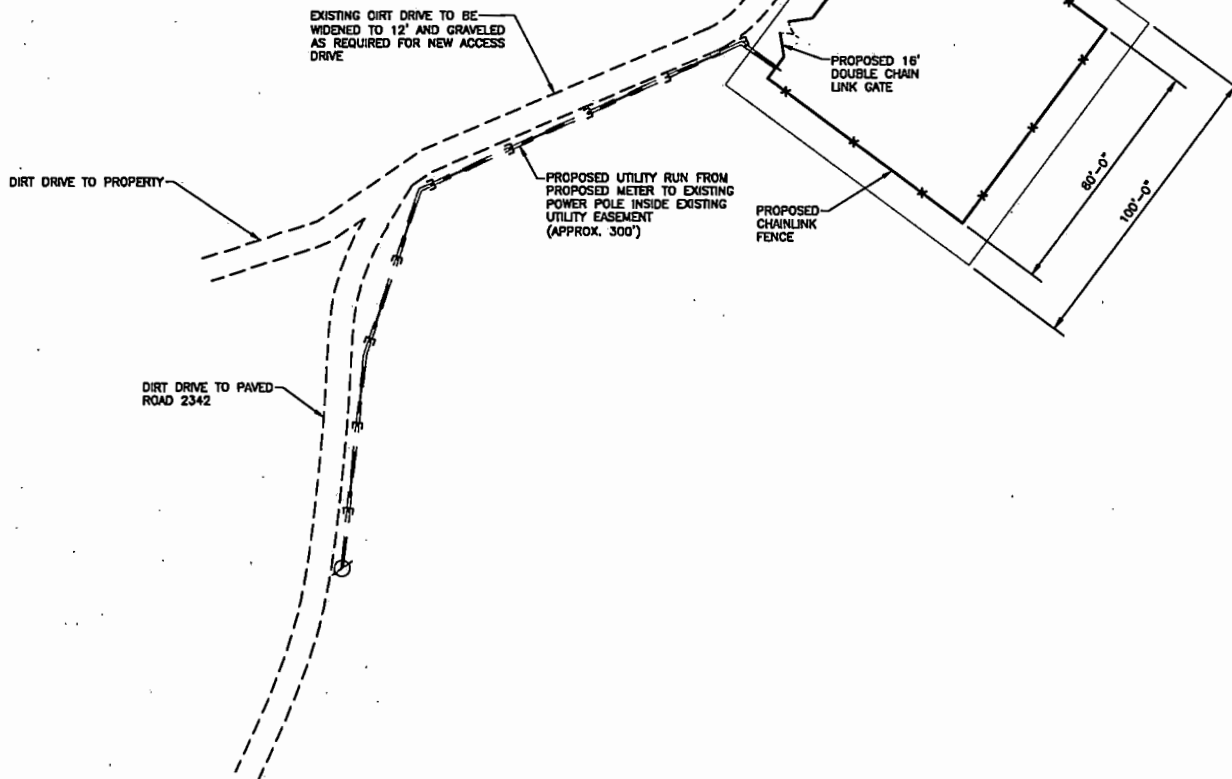

1 OVERALL SITE PLAN
 SCALE: 1" = 40'

CA#: TX F-9617

**PRELIMINARY
 DRAWING**
 (NOT VALID UNLESS
 STAMPED AND SIGNED)

DATE	DESCRIPTION:
07/28/19	ISSUED FOR CLIENT REVIEW

**BLOOMQUIST TOWER
 OVERALL SITE PLAN**

DESIGNER:	CM
CHECKED BY:	SM
ENGINEER:	JDS
SMW #:	19-10371

SHEET NO.:
C-1



Eastex Tower, Inc.
 10000 N. 10th Street, Suite 100
 Dallas, TX 75243
 Phone: 214-440-1100
 Fax: 214-440-1101

