


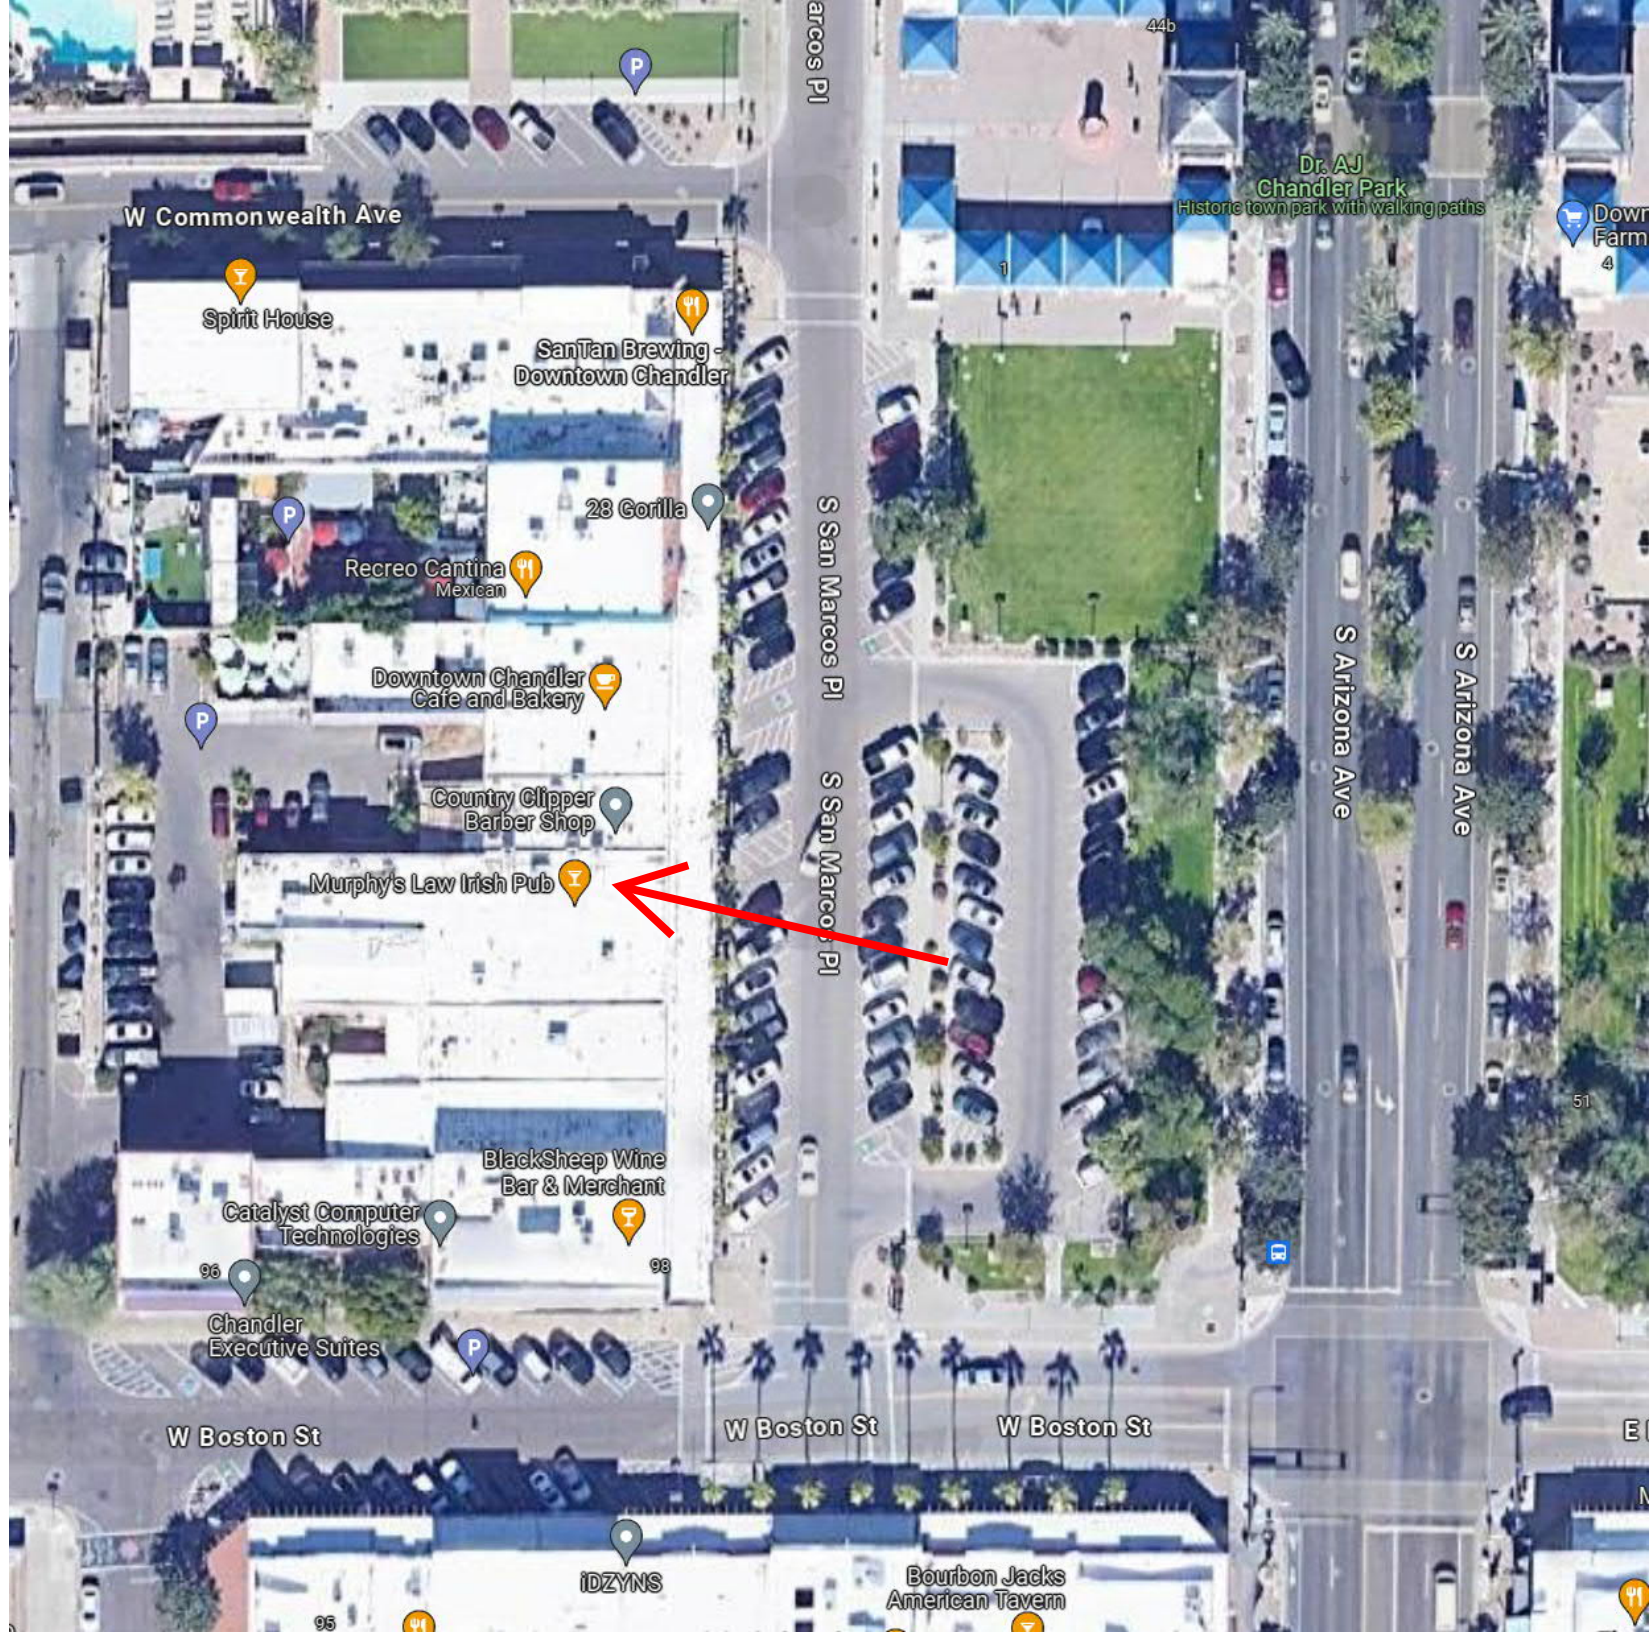

OCCUPANT LOAD: (203 IBC TABLE 1004.5)	
BAR - ASSEMBLY W/ FIXED SEATS - 90 LINEAR FEET x 15" PER LINEAR FOOT	50
RUNWAY BEHIND BAR - 195' x 200 CROSS	5
1 BOOTH	5
SEATING BOOTHS - 80 LINEAR FEET x 24" LINEAR FOOT	50
TOTAL OCCUPANT LOAD	102


REQUIRED PLUMBING FIXTURES (203 IBC TABLE 2902.1)	
MINIMUM REQUIREMENTS - ASSEMBLY	
DESCRIPTION	MALE FEMALE
COMBINED OIL & GREASE	1
WATER CLOSETS	1 PER 75 1 2
LAVATORIES	1 PER 200 1 2
SERVICE SINK	1

MEANS OF EGRESS (203 IBC SECTION 1005)	
REQUIRED PASSAGE WIDTH BASED ON A O/L OF 102 X 2" = 204"	
EGRESS WIDTH PROVIDED BASED ON COMBINED ENTRANCE 3 EXIT DOORS = 108"	
NUMBER OF EXITS REQUIRED (203 IBC TABLE 1006.3.3) = 2	
NUMBER OF EXITS PROVIDED = 2	
TRAVEL DISTANCES (203 IBC TABLE 1017.2 OCCUPANCY & W/ SPRINKLER SYSTEM = 250 FEET)	

REQUIRED PLUMBING FIXTURES (2021 IRC TABLE 2902.1)							
MINIMUM REQUIREMENTS - ASSEMBLY							
DESCRIPTION	MALE 5/8"	REQ'D	PROVIDED	FEMALE 5/8"	REQ'D	PROVIDED	
COMBINED OIL - 102							
WATER CLOSERS	1 PER 75	1	2	1 PER 75	1	2	
LAVATORIES	1 PER 200	1	2	1 PER 200	1	2	
SERVICE SINK						1	

MEANS OF EGRESS (2021 IBC SECTION 1005)

REQUIRED EGRESS WIDTH BASED ON A O/L OF 102 X 2" = 204"
EGRESS WIDTH PROVIDED BASED ON COMBINED EXTERIOR 3 EXIT DOORS = 108"
NUMBER OF EXITS REQUIRED (2021 IBC TABLE 1006.3.3) = 2
NUMBER OF EXITS PROVIDED = 2
TRAVEL DISTANCES (2021 IBC TABLE 1017.2) OCCUPANCY A W/ SPRINKLER SYSTEM = 250 FEET

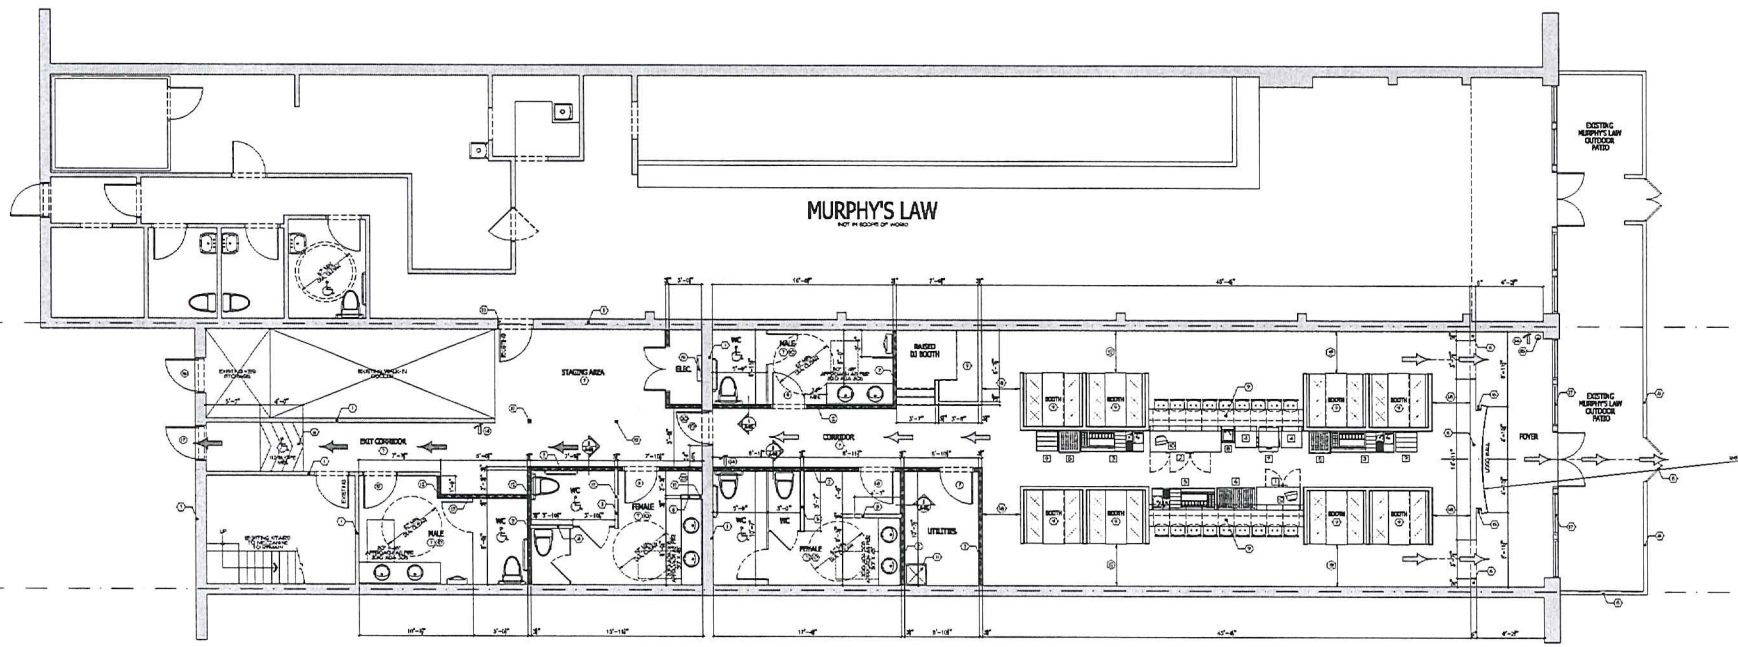[illegible]

TRINITY
EST. *Design* 2002
• ARCHITECTURE • INTERIORS •

Drawing Title	Date: January 2023	Drawn by: Noland J Horner	Project No:
Proposed Floor Plan Exit Corridor Plan Door Schedule			23-006
Client	LOUIE'S LIQUORS 678 S San Marcos Pl. Chattahoochee, AL 35925		
Scale:	3/16" = 1'-0"		
Prepared by: T. Wicks, LLC 60 E Main St., #2140 Tomball, TX 77375 (281) 428-3809 twicks@t-wicks.com			

KEYED NOTES													
1	EXISTING WALLS TO REMAIN	4	SNIP OFFSHOOT BOARD 1/2" GAUGE METAL STUDS + 2" O.C. SNIP OFFSHOOT BOARD	7	EXISTING CONCRETE SLAB FLOOR TO REMAIN	10	WALLS, FLOORS AND PARTITIONS TO COMPLY WITH LOCAL BUILDING DEPARTMENT REQUIREMENTS TO PROVIDE SOUND, NONRESIDENT TIE TO A HEIGHT OF NOT LESS THAN 4" WALLS ABOVE THE FLOOR.	13	EXISTING ACCESS BETWEEN MURPHY'S LAWN AND LOU'S LOGGIES TO REMAIN	16	LED RGB LIGHT COVE	19	EXISTING ELECTRICAL PANEL TO REMAIN
2	SNIP OFFSHOOT BOARD 1/2" GAUGE METAL STUDS + 2" O.C. SNIP OFFSHOOT BOARD SNIP OFFSHOOT BOARD	5	SNIP OFFSHOOT BOARD 1/2" GAUGE METAL STUDS + 2" O.C. SNIP OFFSHOOT BOARD SNIP OFFSHOOT BOARD	8	EXISTING OUTDOOR RAILING AND GATES TO REMAIN	11	CEILING COVE	14	WALL MOUNTED, RECESSED FIRE EXTINGUISHER	17	EXISTING WINDOW AND DOOR SYSTEM TO REMAIN	20	DOOR W/ AUTOMATIC OPENER FROM STAGED AREA
3	SNIP OFFSHOOT BOARD 1/2" GAUGE METAL STUDS + 2" O.C. SNIP OFFSHOOT BOARD	6	REMOVE AND REPLACE EXISTING DAMP WITH NEW SELF COMPACTING DAMP TIE IN SLIPS. HEIGHT MUST EXCEED 6" WITHOUT HAND RAILING	9	BAR MILLWORK BY OTHERS	12	EXISTING 4" X 4" WOOD POSTS TO REMAIN	15	EXISTING EXPOSED PIPE RISER TO REMAIN AS IS	18	MAINTAIN 42" MIN. CLEARANCE AROUND MILLWORK		