
 
 


GENERAL NOTES

- A. REFERENCE LOW VOLTAGE PLAN SHEET AND ELECTRICAL DRAWINGS.
- B. LEAVE TEN (10) ADDITIONAL CEILING TILES TO MATCH TILES SPECIFIED OR VERIFY QTY DESIRED BY OWNER.
- C. PROVIDE GROMMET AT ACOUSTIC CEILING PENETRATIONS FOR FIXTURES OF SUPPORTS.
- D. HEATING, VENTILATING AND AIR CONDITIONING SHOWN ON THIS PLAN PROVIDED FOR REFERENCE ONLY. SEE MECHANICAL DRAWINGS FOR ADDITIONAL INFORMATION.
- E. DIFFUSERS AND RETURNS IN ACOUSTICAL CEILING TILE TO BE CENTERED IN TILE AND PAINTED TO MATCH ADJACENT FINISHES (TYP.).
- F. PAINT ALL EXPOSED HVAC DUCTS, HVAC DIFFUSERS, LIGHT TRIM RINGS, PIPING, CONDUIT AND JUNCTION BOXES THE SAME COLOR AS SPECIFIED ON SURROUNDING CEILING OR SOFFIT UNLESS OTHERWISE NOTED. TYPICAL THROUGHOUT RETAIL AREA OF STORE.
- G. PAINT SUBSTITUTIONS ARE NOT ALLOWED.
- H. DATA CABLING ABOVE HEAD SHALL BE IN PLENUM WHEN AVAILABLE.
- I. DATA CABLING AT EXPOSED CEILING SHALL BE INSTALLED IN METAL CONDUIT OR PER LOCAL CODE REQUIREMENT.

GENERAL WALL LEGEND























SEE SHEET A0.30 FOR SPECIFIC WALL TYPES


-  EXISTING WALL, SEE INTERIOR ELEVATIONS FOR WALL FINISH
-  NEW FULL HEIGHT INTERIOR WALL
-  NEW PARTIAL HEIGHT WALL

KEYED NOTES

- 1 NEW GYP. BOARD CEILING WITH FINISH AS SCHEDULED THROUGHOUT.
- 2 NEW LIGHT FIXTURES AND LIGHT FIXTURE LOCATIONS THROUGHOUT. SEE ELECTRICAL DOCUMENTS FOR ADDITIONAL INFORMATION.
- 3 NEW SIGNAGE TO BE INSTALLED ON THE WALL. SEE INTERIOR ELEVATIONS AND DETAILS FOR ADDITIONAL INFORMATION.

REFLECTED CEILING PLAN LEGEND

-  ELEVATION DATUM
-  TRACK LIGHTING
-  STRIP LIGHTING
-  PENDANT LIGHT
-  SE ALCOVE FEATURE LIGHT - CEILING FLUSH MOUNT
-  RECESSED CAN LIGHT
-  ADJUSTABLE RECESSED CAN LIGHT
-  TROFFER
-  WALL SCONCE
-  SE SCONCE
-  ARTWORK LIGHT
-  DECORATIVE PENDANT LIGHT FIXTURE
-  DECORATIVE SCONCE
-  DECORATIVE SCONCE PDR
-  FEATURE BAKERY PENDANT LIGHT
-  MUSIC SYSTEM WALL MOUNTED SPEAKER
-  MUSIC SYSTEM PENDANT SPEAKER
-  WIFI ACCESS POINT (WAP)
-  360° SECURITY CAMERA
-  SUPPLY AIR
-  RETURN AIR
-  PIR MOTION SENSOR (WIRELESS)

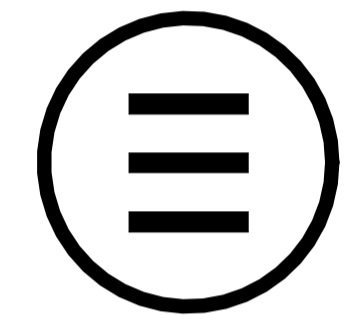

NOT FOR CONSTRUCTION

No.	Description	Date
1	DD ISSUANCE	09/29/2023


Project	101 N LEROUX
	101 N LEROUX ST, FLAGSTAFF

MAIN LEVEL RCP

Project Number	2021-11
Date	09/13/18
Drawn By	Author
Checked By	Checker

A1.52

Scale As indicated

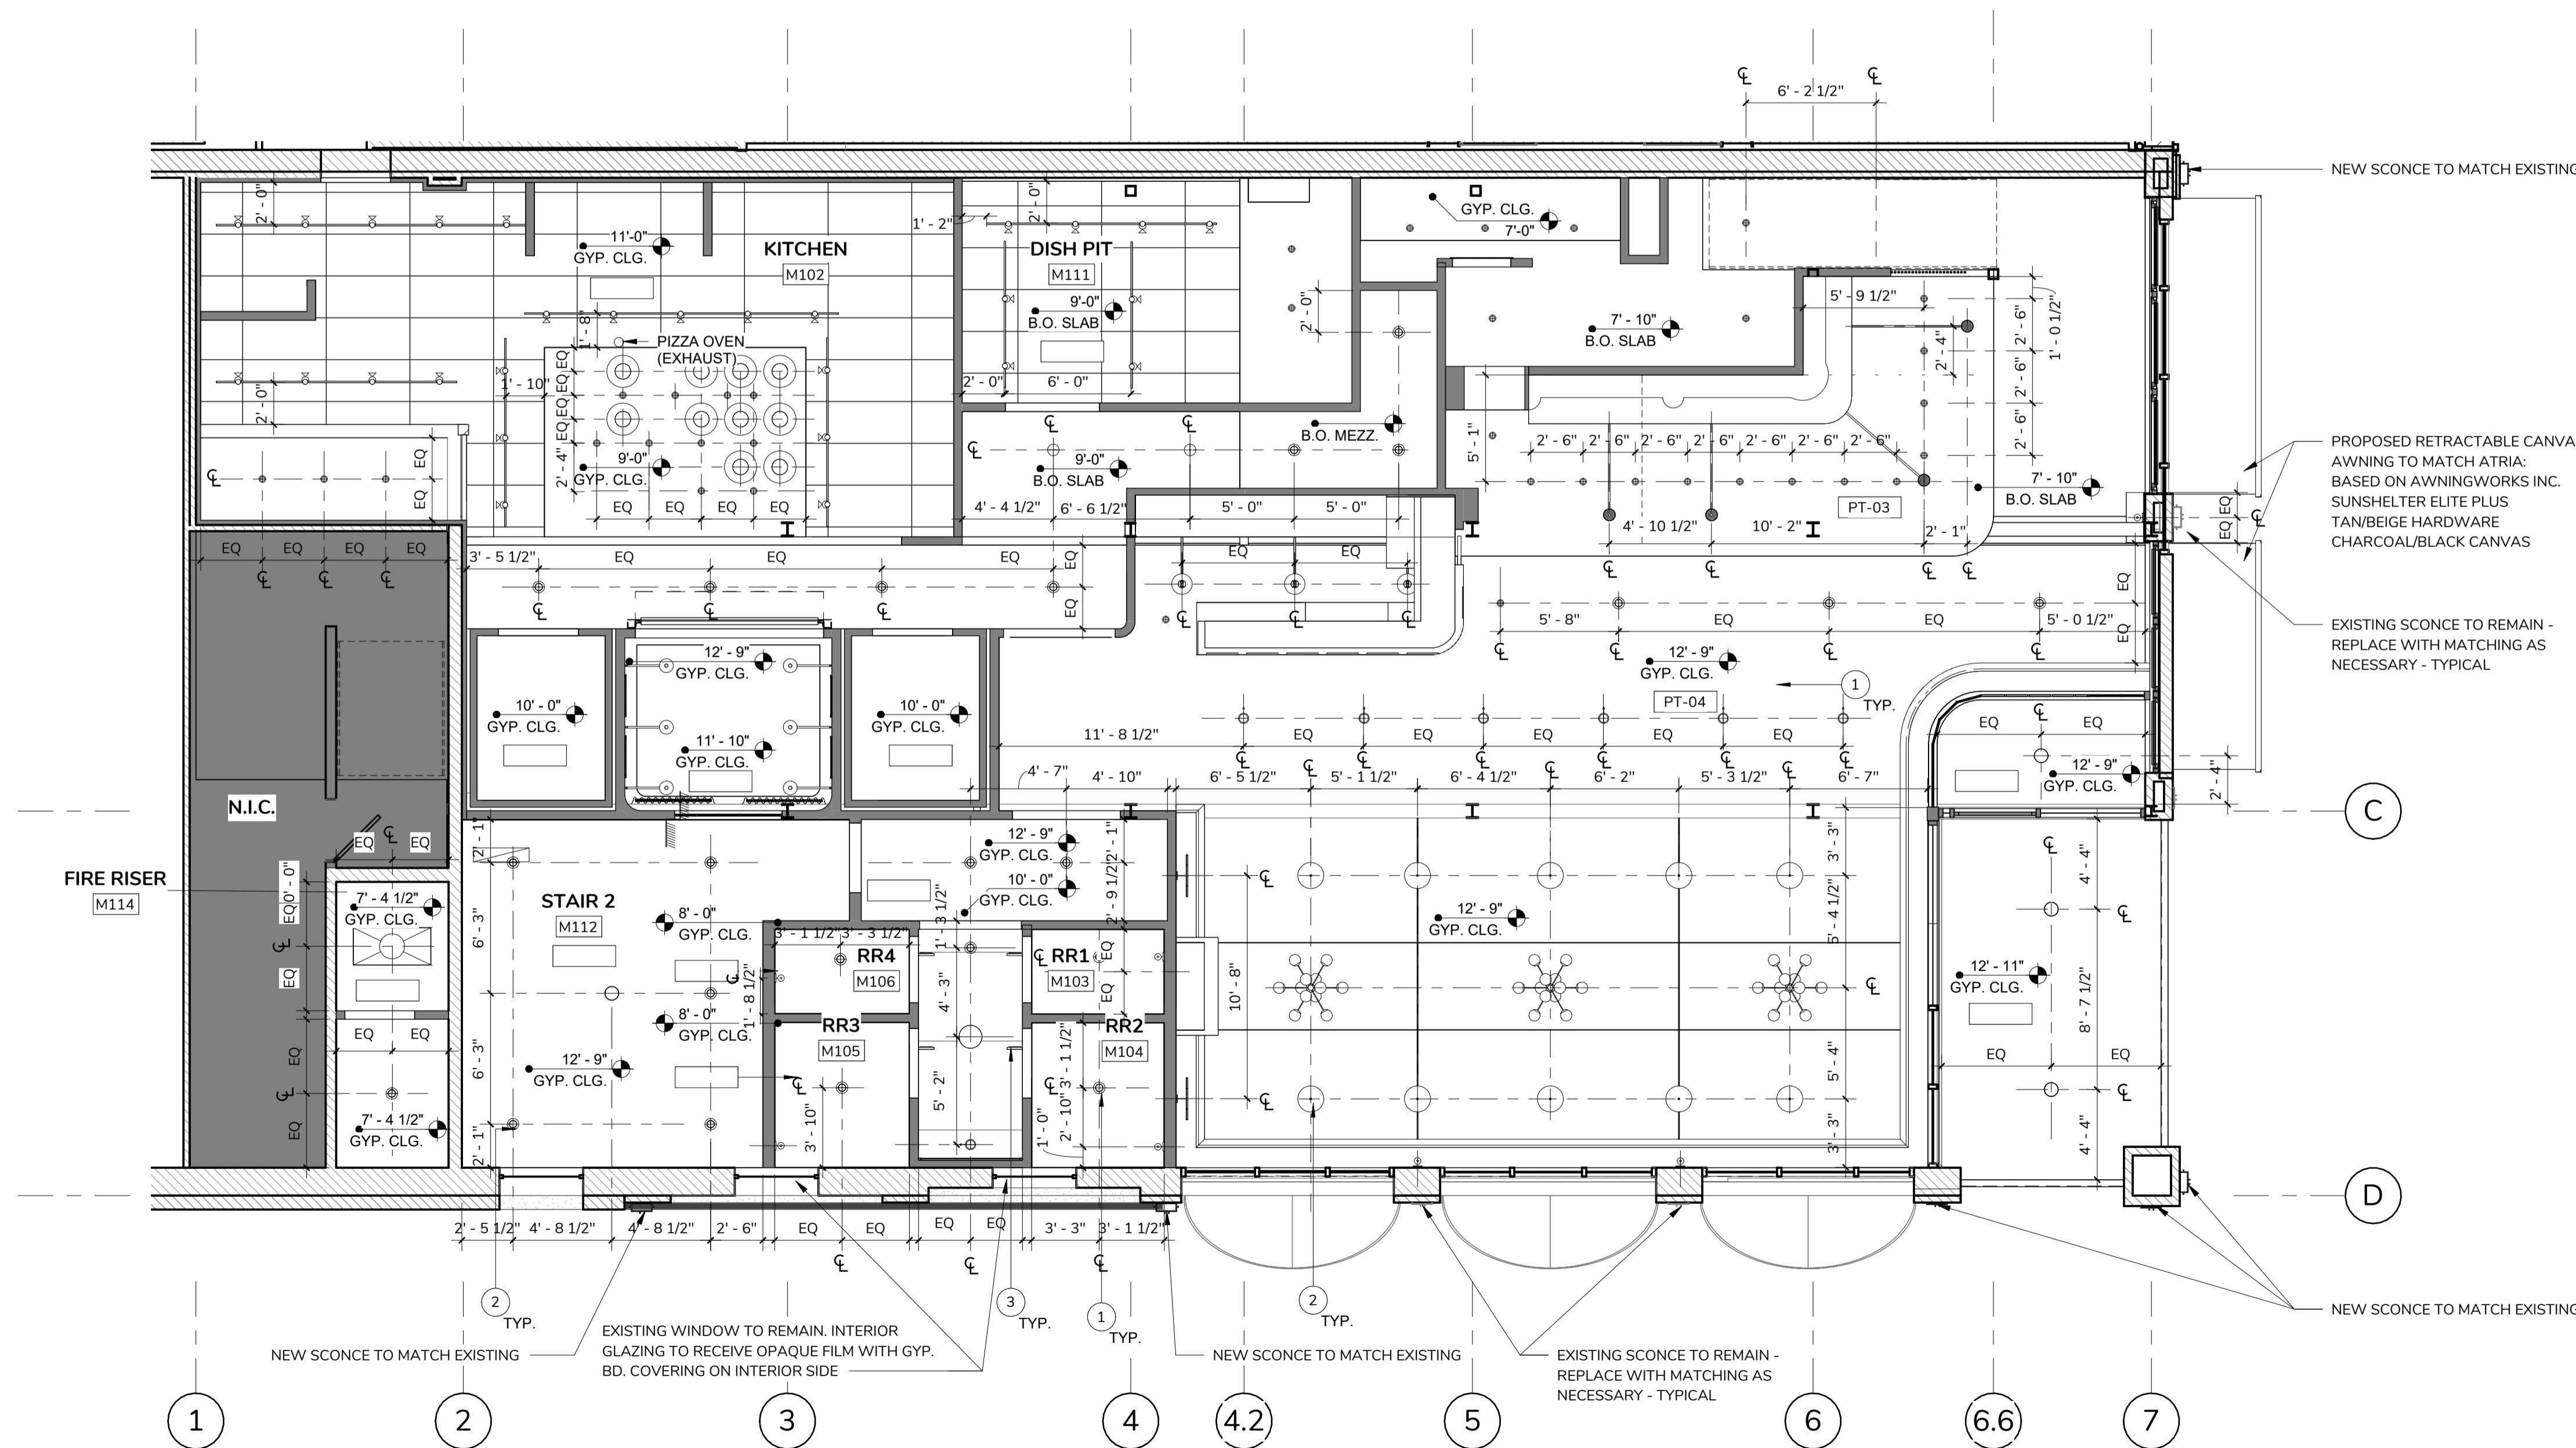

1 REFLECTED CEILING PLAN - MAIN LEVEL

3/16" = 1'-0"