


Project:  
 Proposed Improvements  
 for  
**St. Andrews  
 School**  
 FT. PIERCE, FLORIDA

Key Plan:

Issues:

No.:	Date:	Description:
A.	05/05/14	COA REVIEW
B.	06/16/14	PERMIT SET

Architect:

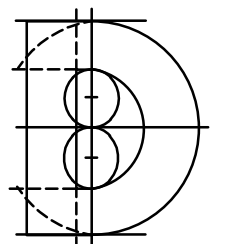


**DONADIO**  
 & Associates, Architects P.A.

609 17th Street  
 Vero Beach, FL 32960  
 Tel: 772 794 2629  
 Fax: 772 562 8800  
 License No. AA0002238  
 www.donadio-arch.com

Consultant:

Drawing Title:  
**PHOTOMETRIC PLAN**

Reference North

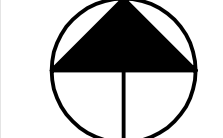


Drm: MT Dwg. File:  
 Chd: XREF File:  
 Project No.: 2014-21 Plot File:  
 Sheet No.:

Cert. No.: 12,456


Date Signed:

**E1.1**

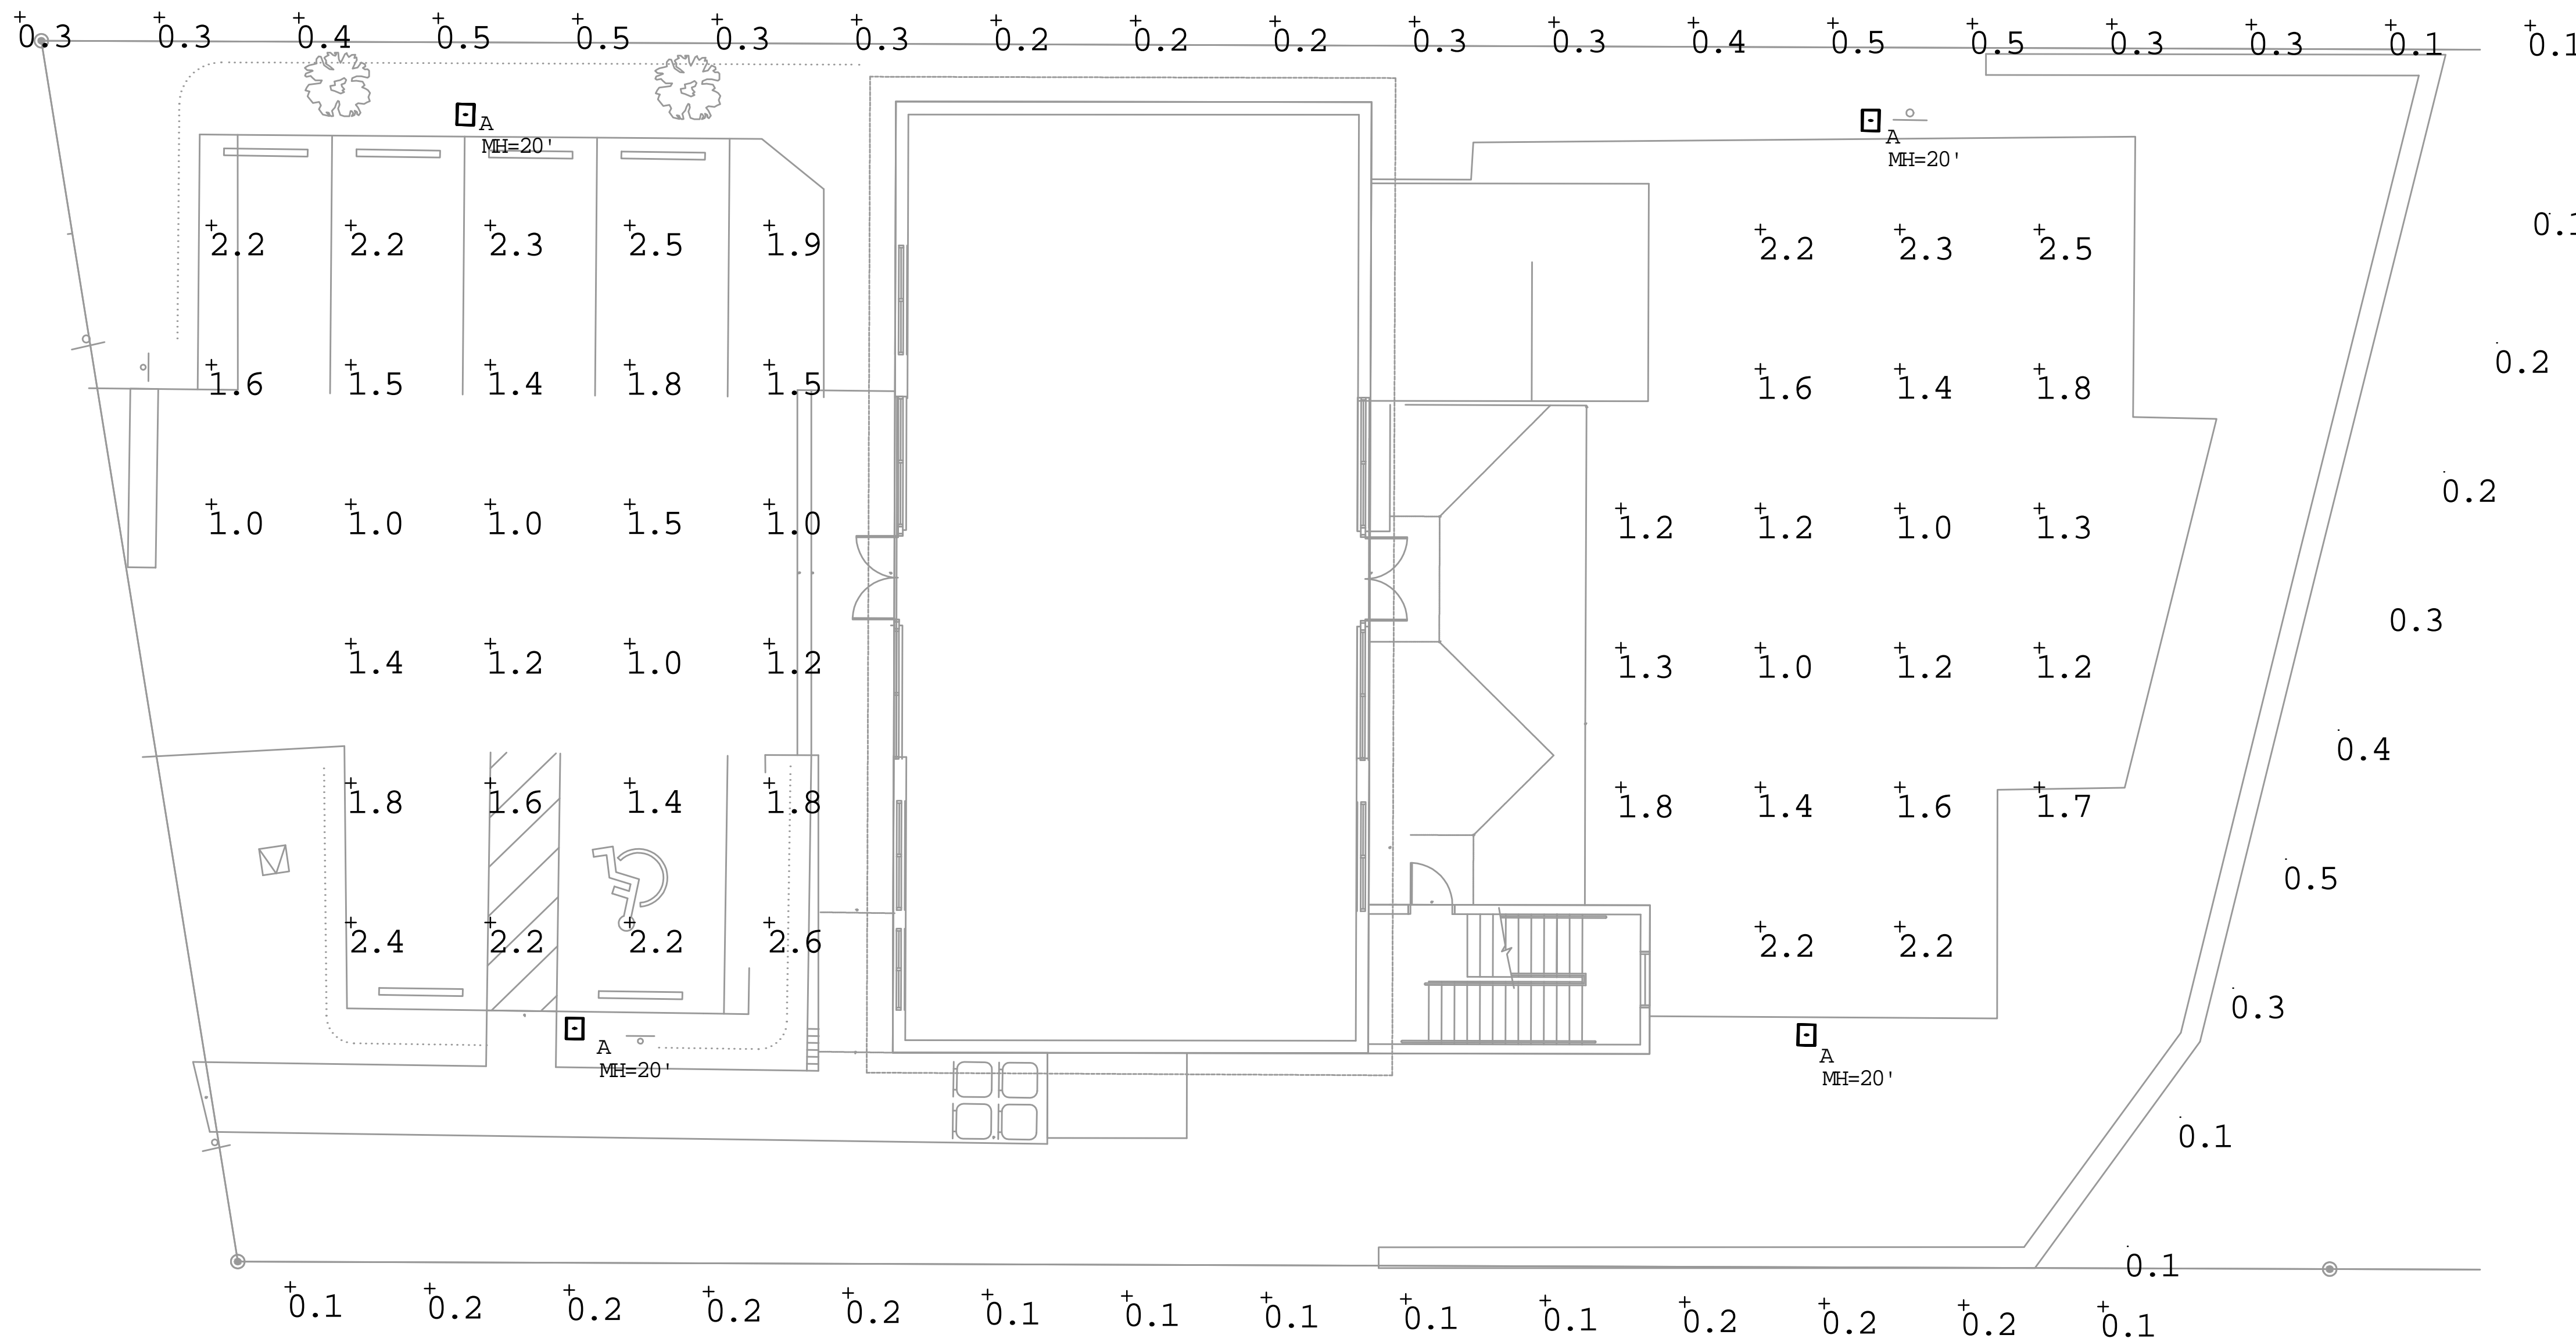

Luminaire Schedule						
Symbol	Qty	Label	Arrangement	Total Lamp Lumens	LLF	Description
A	4	A	SINGLE	12500	0.920	G18-4XL-150PSMH-HS
Calculation Summary						
Label	CalcType	Units	Avg	Max	Min	Avg/Min Max/Min
Back Parking Area	Illuminance	Fc	1.61	2.5	1.0	1.61 2.50
Front Parking Area	Illuminance	Fc	1.67	2.6	1.0	1.67 2.60

**PHOTOMETRIC PLAN**  
 1/8"=1'-0"

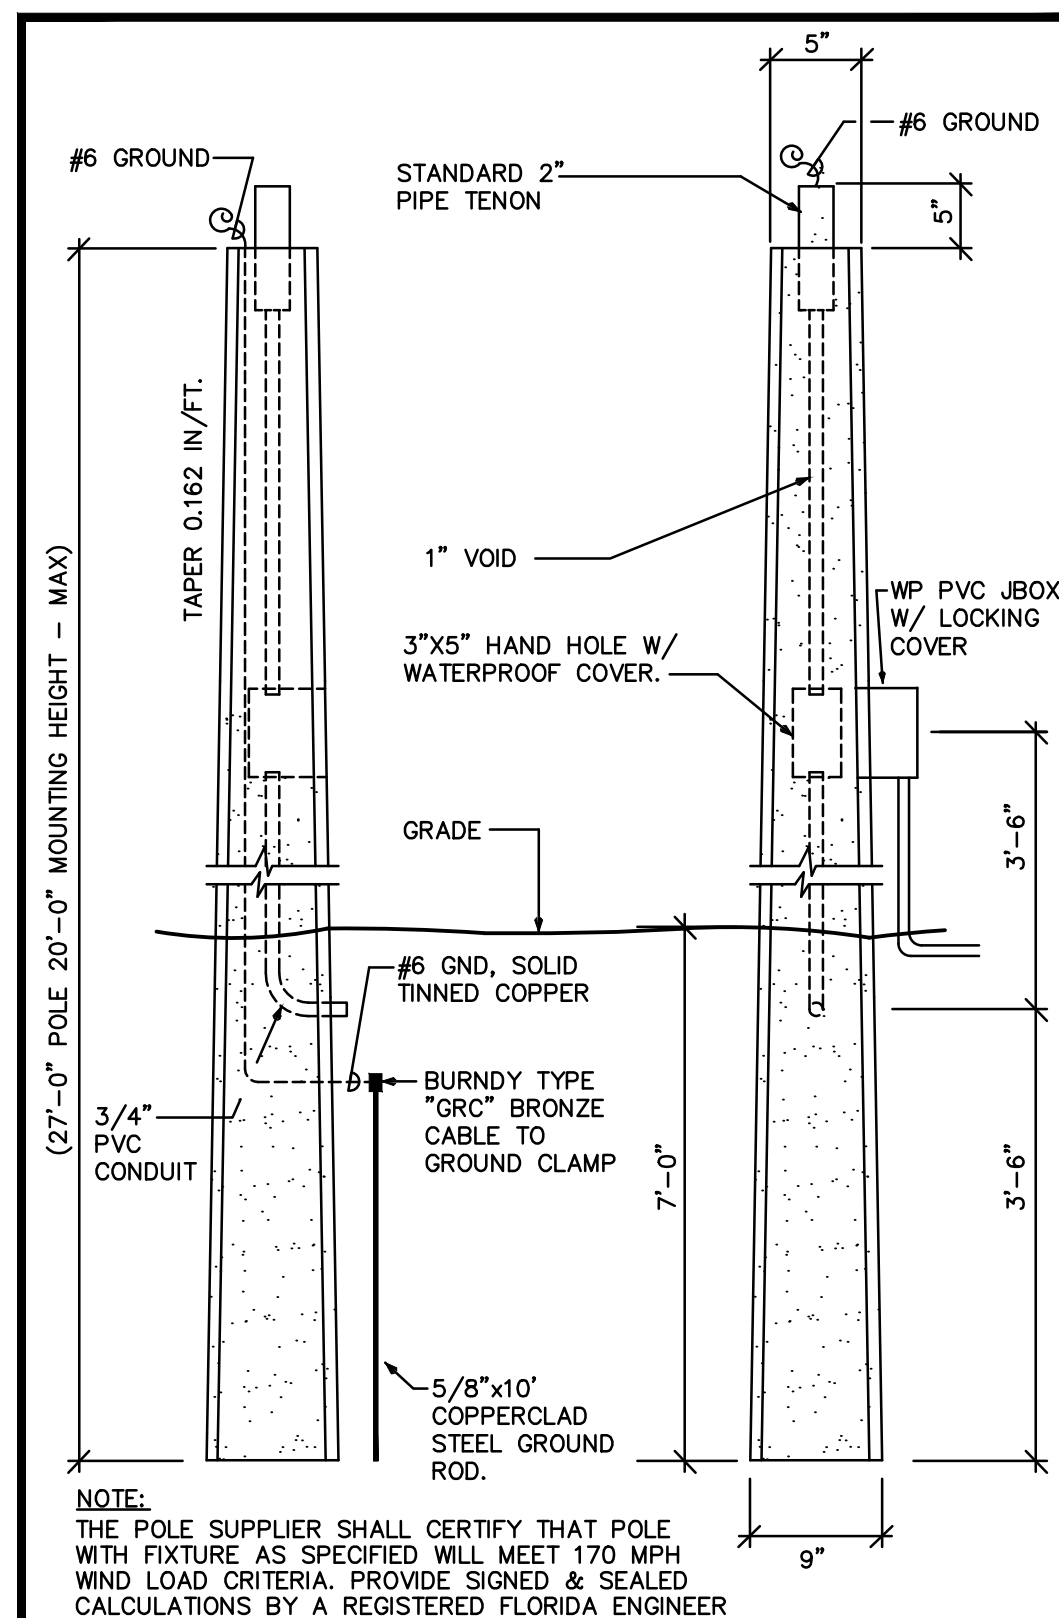

**CONCRETE  
 POLE DETAIL**  
 NOT TO SCALE



**GARDCO "GULLWING"**  
 NOT TO SCALE

ISSUED FOR PERMIT 06-16-14

KAMM CONSULTING PROJECT # 2014-0415  
 PROJECT MANAGER: DIANE MILLAR

**KAMM** Consulting  
 1408 Orange Avenue  
 Fort Pierce, Florida 34950  
 Phone 772-595-1744 Fax 772-595-1745  
 engineering@kammconsulting.com  
 Certification of Authorization #8189

PRINCIPAL  
 Brady L. Brown Florida License #58232

06-25-14  
 date  
 signed