


Ordering Number Logic
 Order # LED fixture area light fixture

Ordering Number Logic

Area	Fixture	Ordering Number
1-1000	1-1000	1-1000
1000-2000	1-1000	1000-1000
1000-2000	2-2000	1000-2000
2000-3000	1-1000	2000-1000
2000-3000	2-2000	2000-2000
3000-4000	1-1000	3000-1000
3000-4000	2-2000	3000-2000
4000-5000	1-1000	4000-1000
4000-5000	2-2000	4000-2000
5000-6000	1-1000	5000-1000
5000-6000	2-2000	5000-2000
6000-7000	1-1000	6000-1000
6000-7000	2-2000	6000-2000
7000-8000	1-1000	7000-1000
7000-8000	2-2000	7000-2000
8000-9000	1-1000	8000-1000
8000-9000	2-2000	8000-2000
9000-10000	1-1000	9000-1000
9000-10000	2-2000	9000-2000

TYPE 'S' LIGHT FIXTURE


TYPE 'L' LIGHT FIXTURE

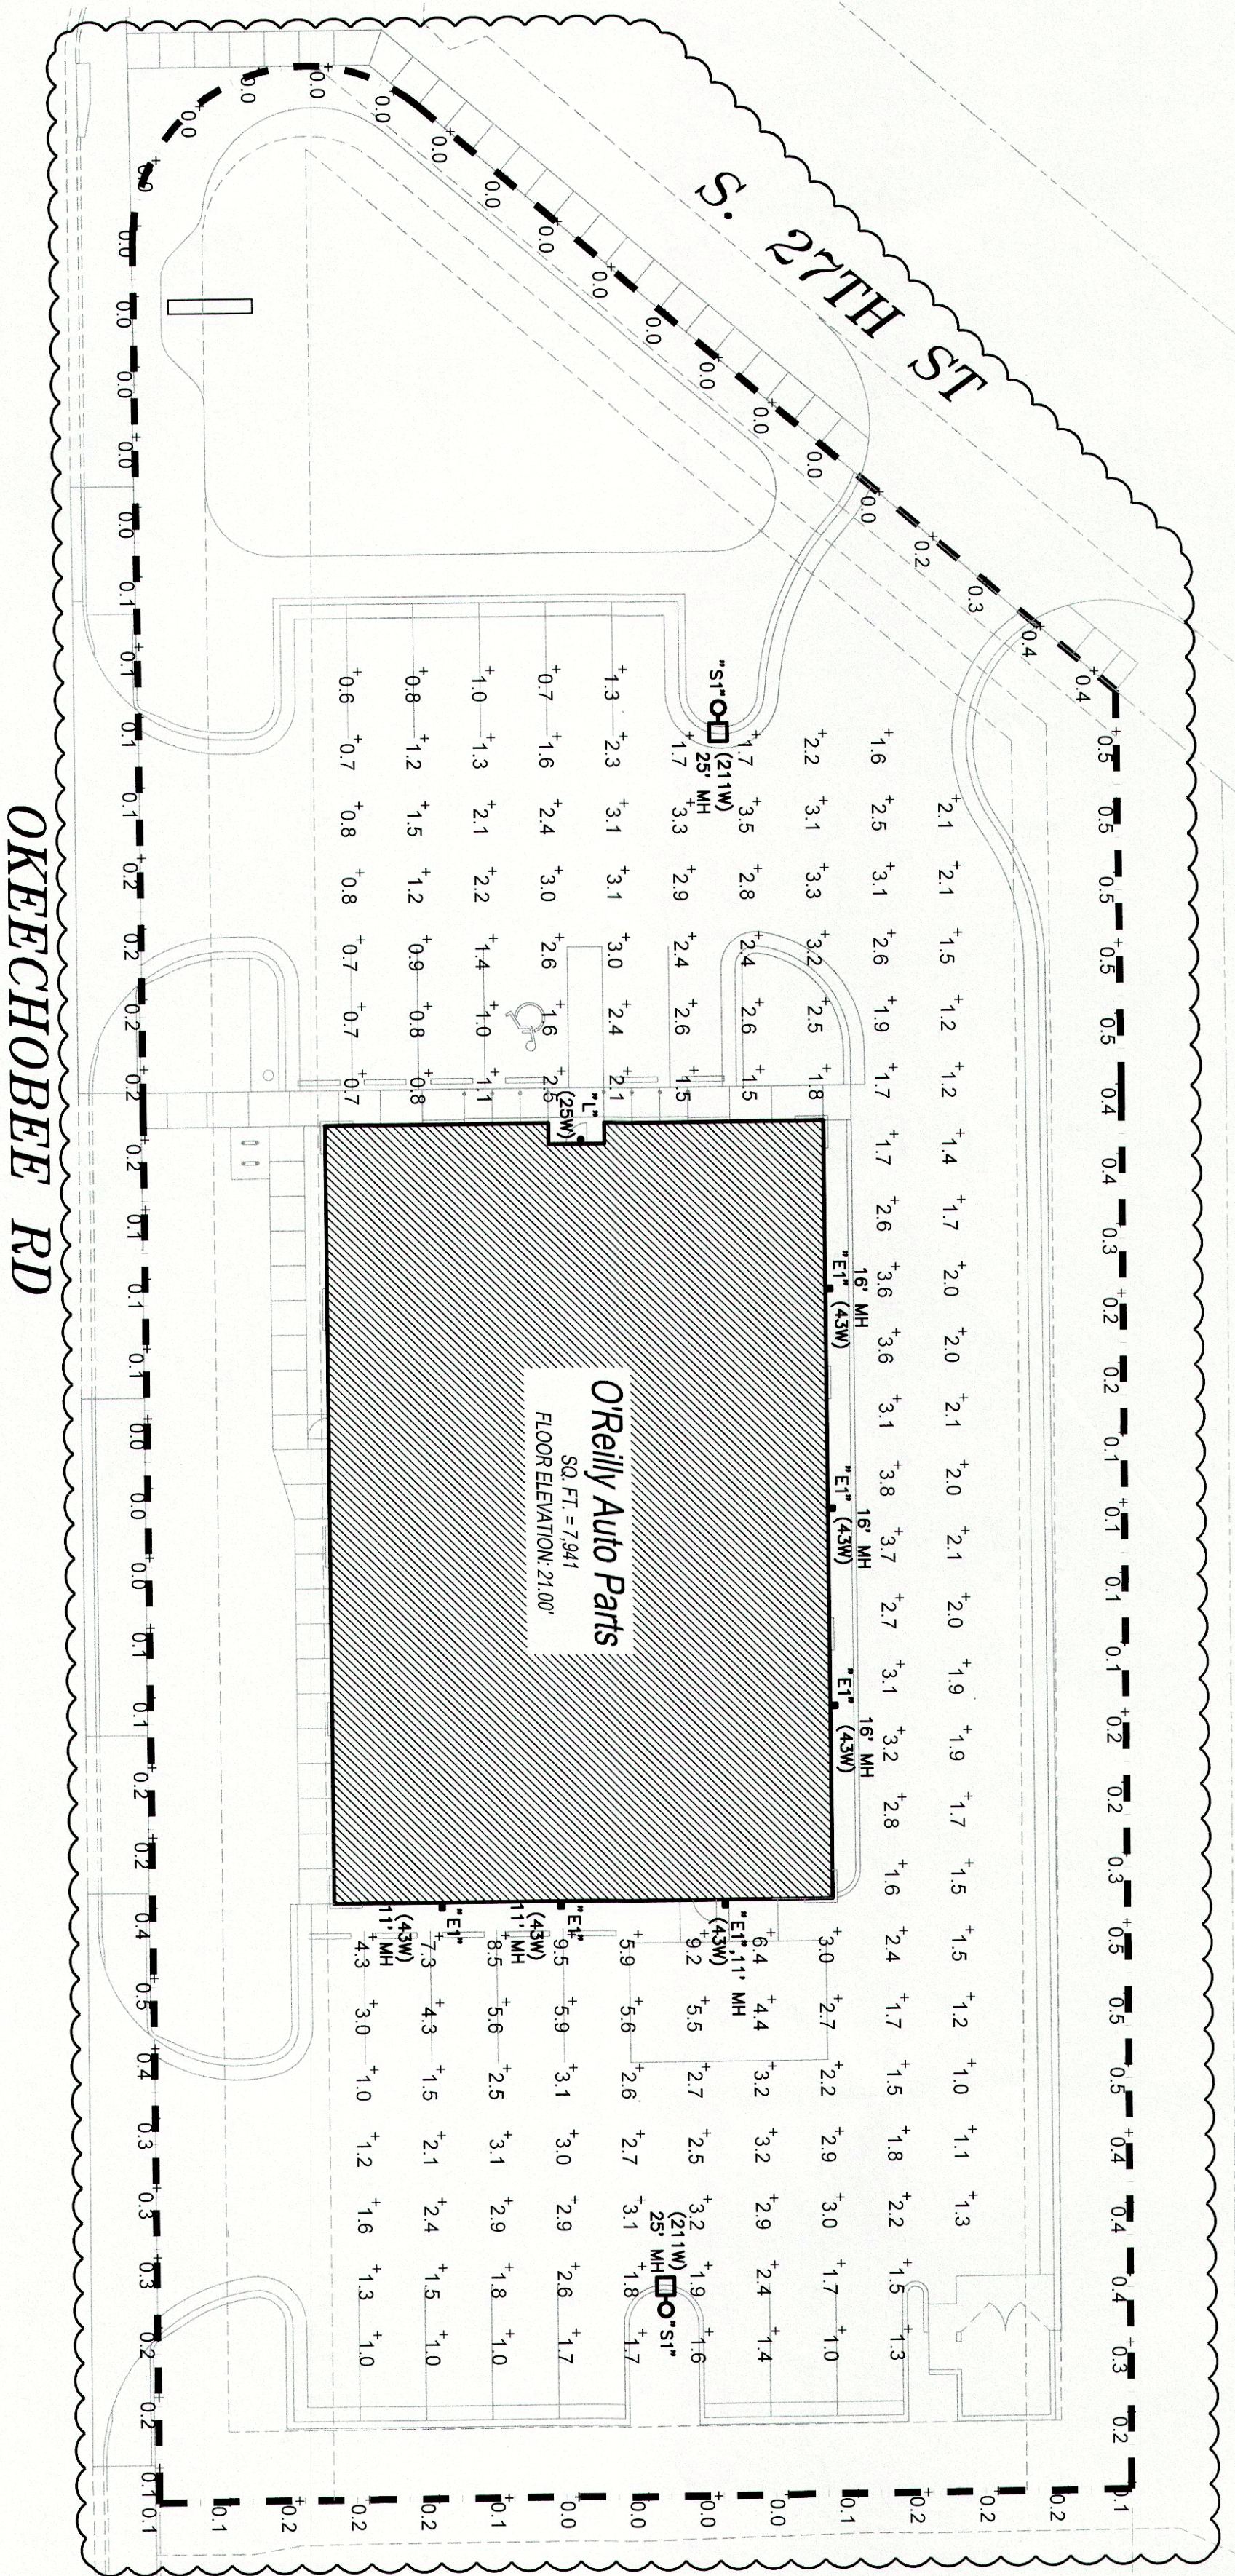

STATISTICS

DESCRIPTION	SYMBOL	AVG	MAX	MIN	MAX/MIN	AVG/MIN
PARKING AREA	+	2.4 fc	9.5 fc	0.6 fc	15.8:1	4.0:1
PROPERTY LINE	+	0.2 fc	0.7 fc	0.0 fc	N/A	N/A

1 SITE LIGHTING PLAN
 SCALE: 1"=20'

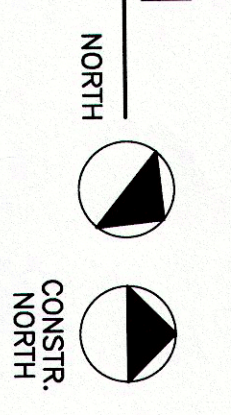

PORTFOLIO™

Project #	Project Name	Client	Date

DESCRIPTION
 Two-stage reflector system produces uniform distribution with excellent light control and low glare. High quality materials and construction provide superior performance. Available in all finishes.

Specifications:
 - 2" Recessed
 - 2" Recessed
 - 2" Recessed
 - 2" Recessed

LED LIGHTING

LED LIGHTING
 LED lighting offers a wide range of benefits, including energy efficiency, long life, and low maintenance. Our LED lighting solutions are designed to meet your specific needs and provide superior performance.

LED LIGHTING
 LED lighting offers a wide range of benefits, including energy efficiency, long life, and low maintenance. Our LED lighting solutions are designed to meet your specific needs and provide superior performance.

Cameron K. Collins, P.E. #62665
 3333 E. Battlefield Road, Suite 1000
 Springfield, Missouri 65804
 Phone: 417.862.3265
 Fax: 417.862.3265
 Email: architect@esterlyschneider.com

CAMERON K. COLLINS
 LICENSED PROFESSIONAL ENGINEER
 No. 82665
 STATE OF MISSOURI
 PROFESSIONAL ENGINEER

CRAIG A. SCHNEIDER, AIA
ARCHITECT
 1736 East Sunshine, Suite 417
 Springfield, Missouri 65804
 417.862.0558
 Fax: 417.862.3265
 e-mail: architect@esterlyschneider.com

New O'Reilly Auto Parts Store:
OKECHOBEE RD.
FORT PIERCE, FL
(FORT PIERCE #2)

O'Reilly AUTO PARTS
 233 SOUTH PATTERSON
 SPRINGFIELD, MISSOURI 65802
 417-862-2674 PHONE

CONN # 3607

DATE:	2.25.15
REVISION:	3.30.15
DATE:	

SI2 of 2