

SEAL:

PROJECT: ROCLA TIE PLANT

FOR: ROCLA CONCRETE TIE, INC.  
 600 SOUTH 3RD STREET  
 FORT PIERCE, FL 34950


NO. DATE REVISIONS

O MAY 15 2015


COMM. NO: IIO214VB  
 DATE: 28 MAY'15  
 BY: AD  
 CH'KD: PD

SHEET NO.

11

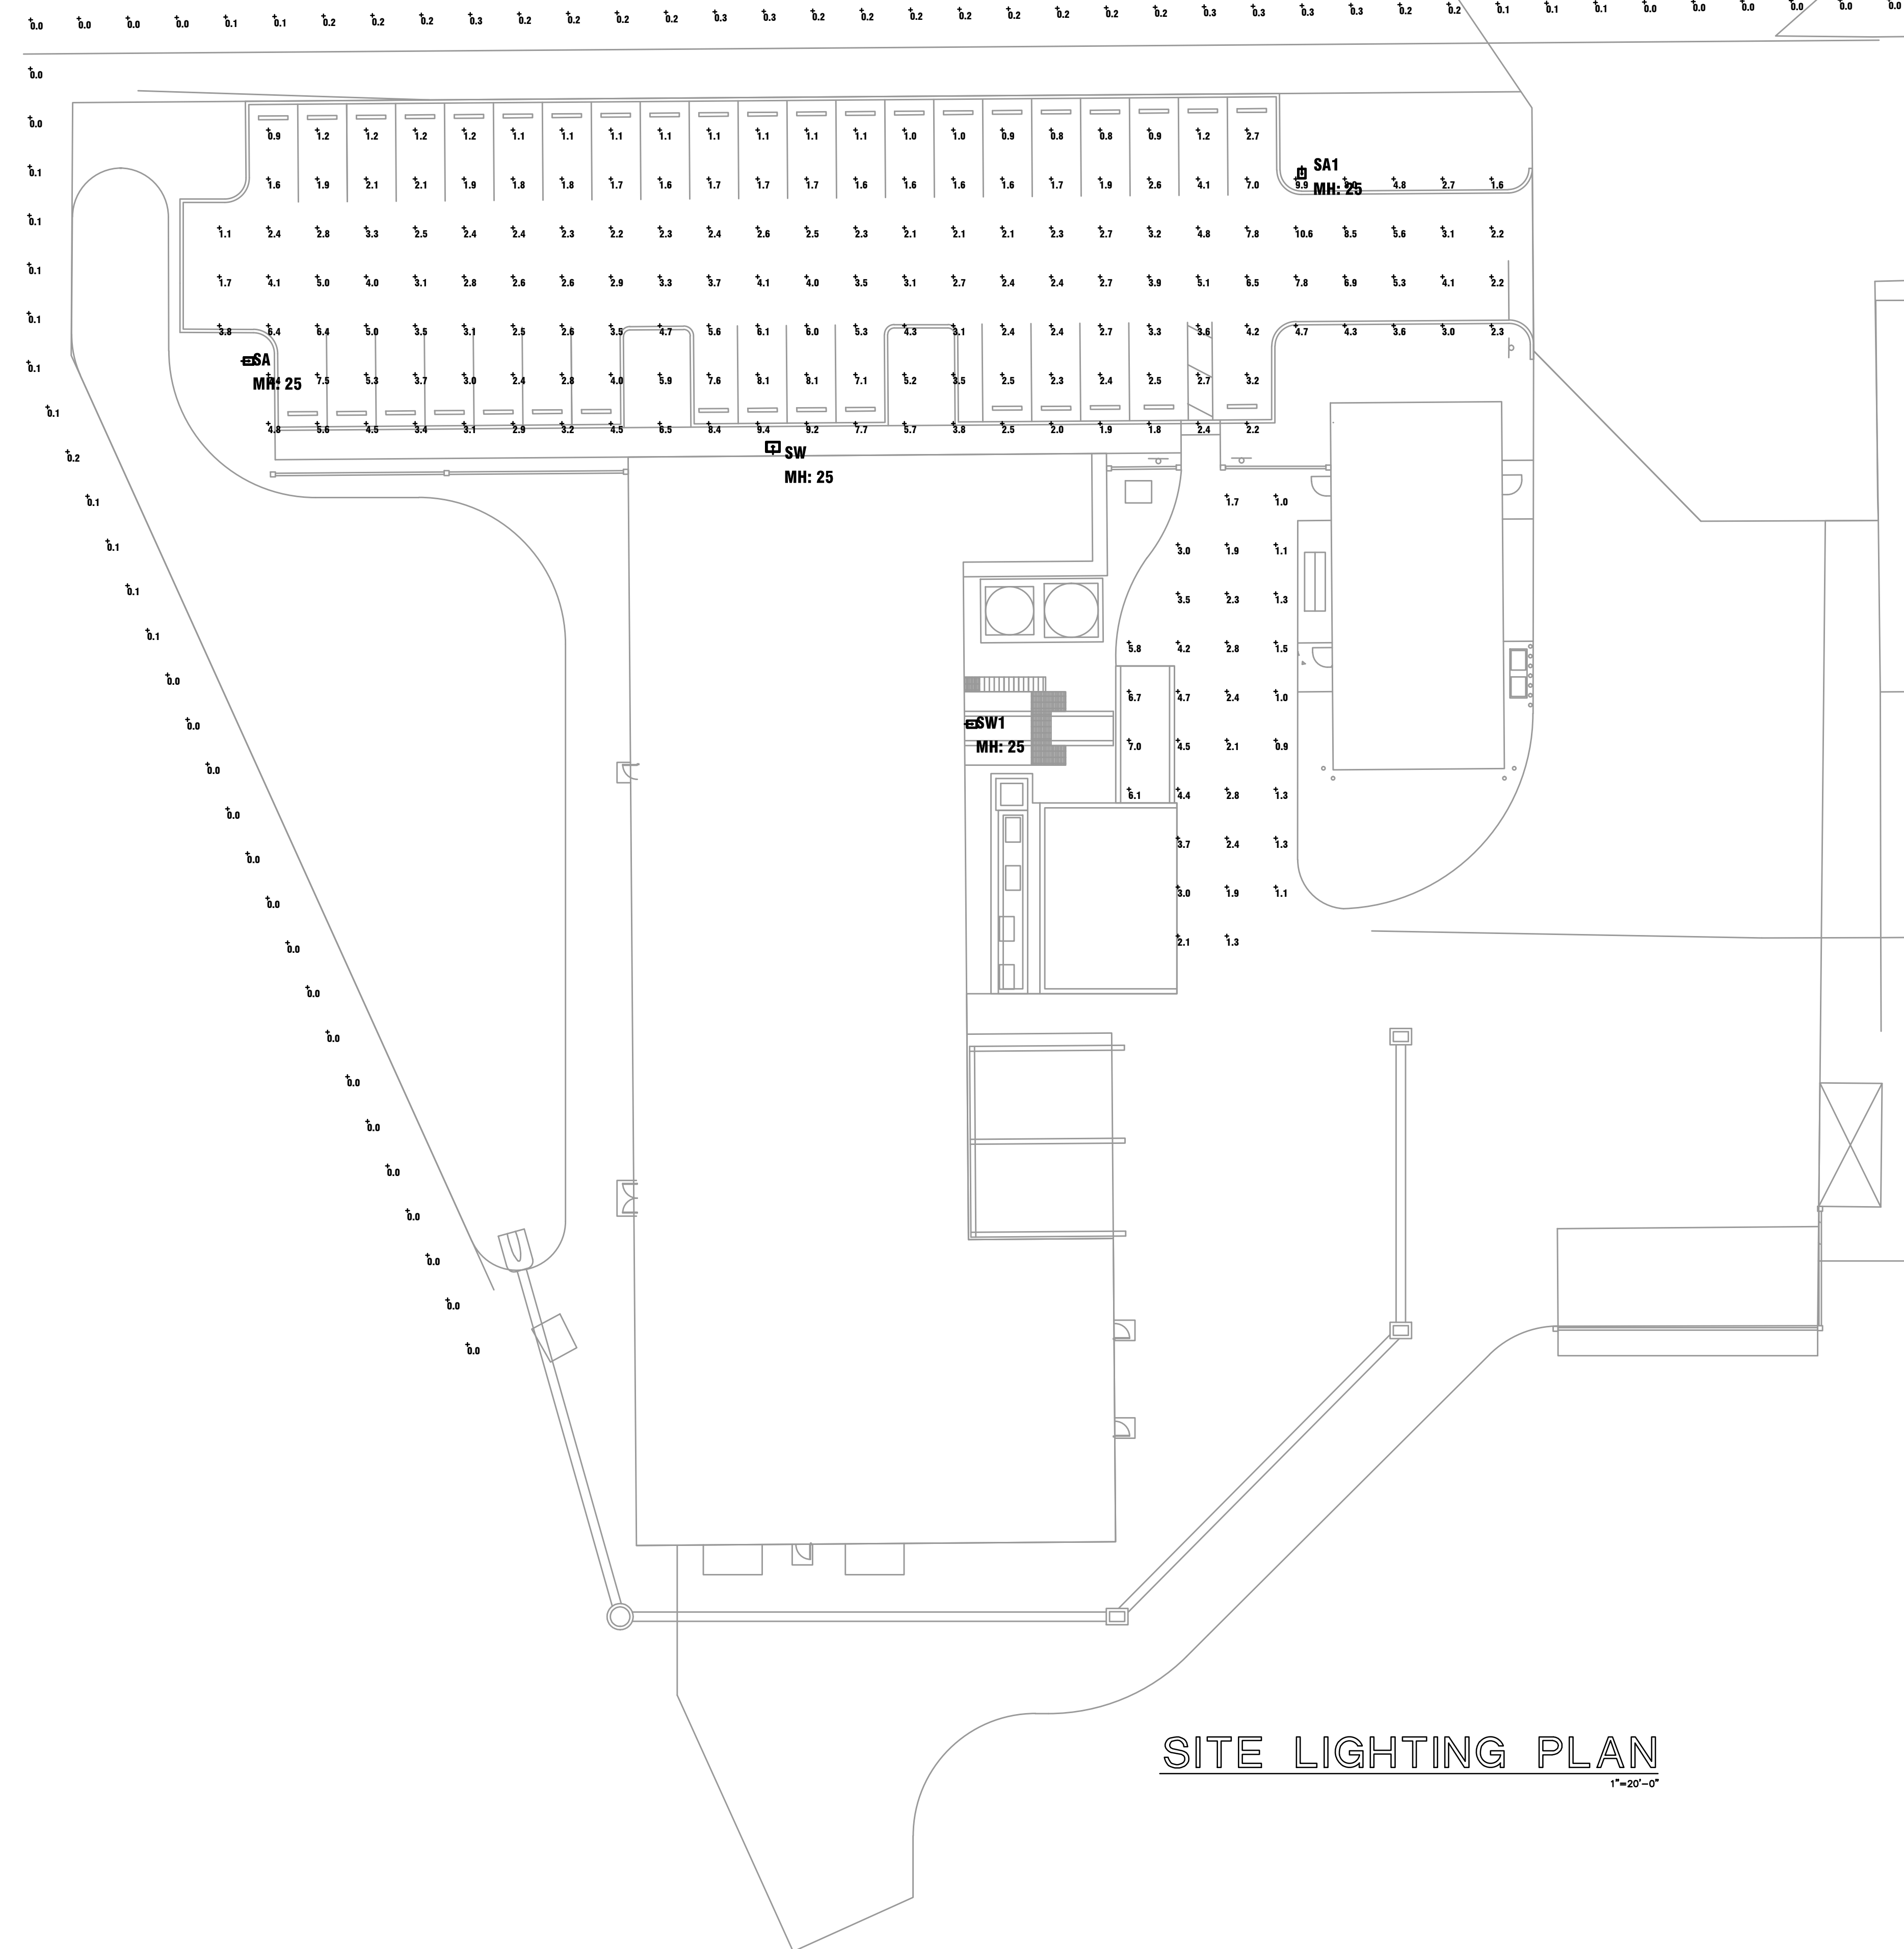

SITE LIGHTING PLAN  
 1"=20'-0"

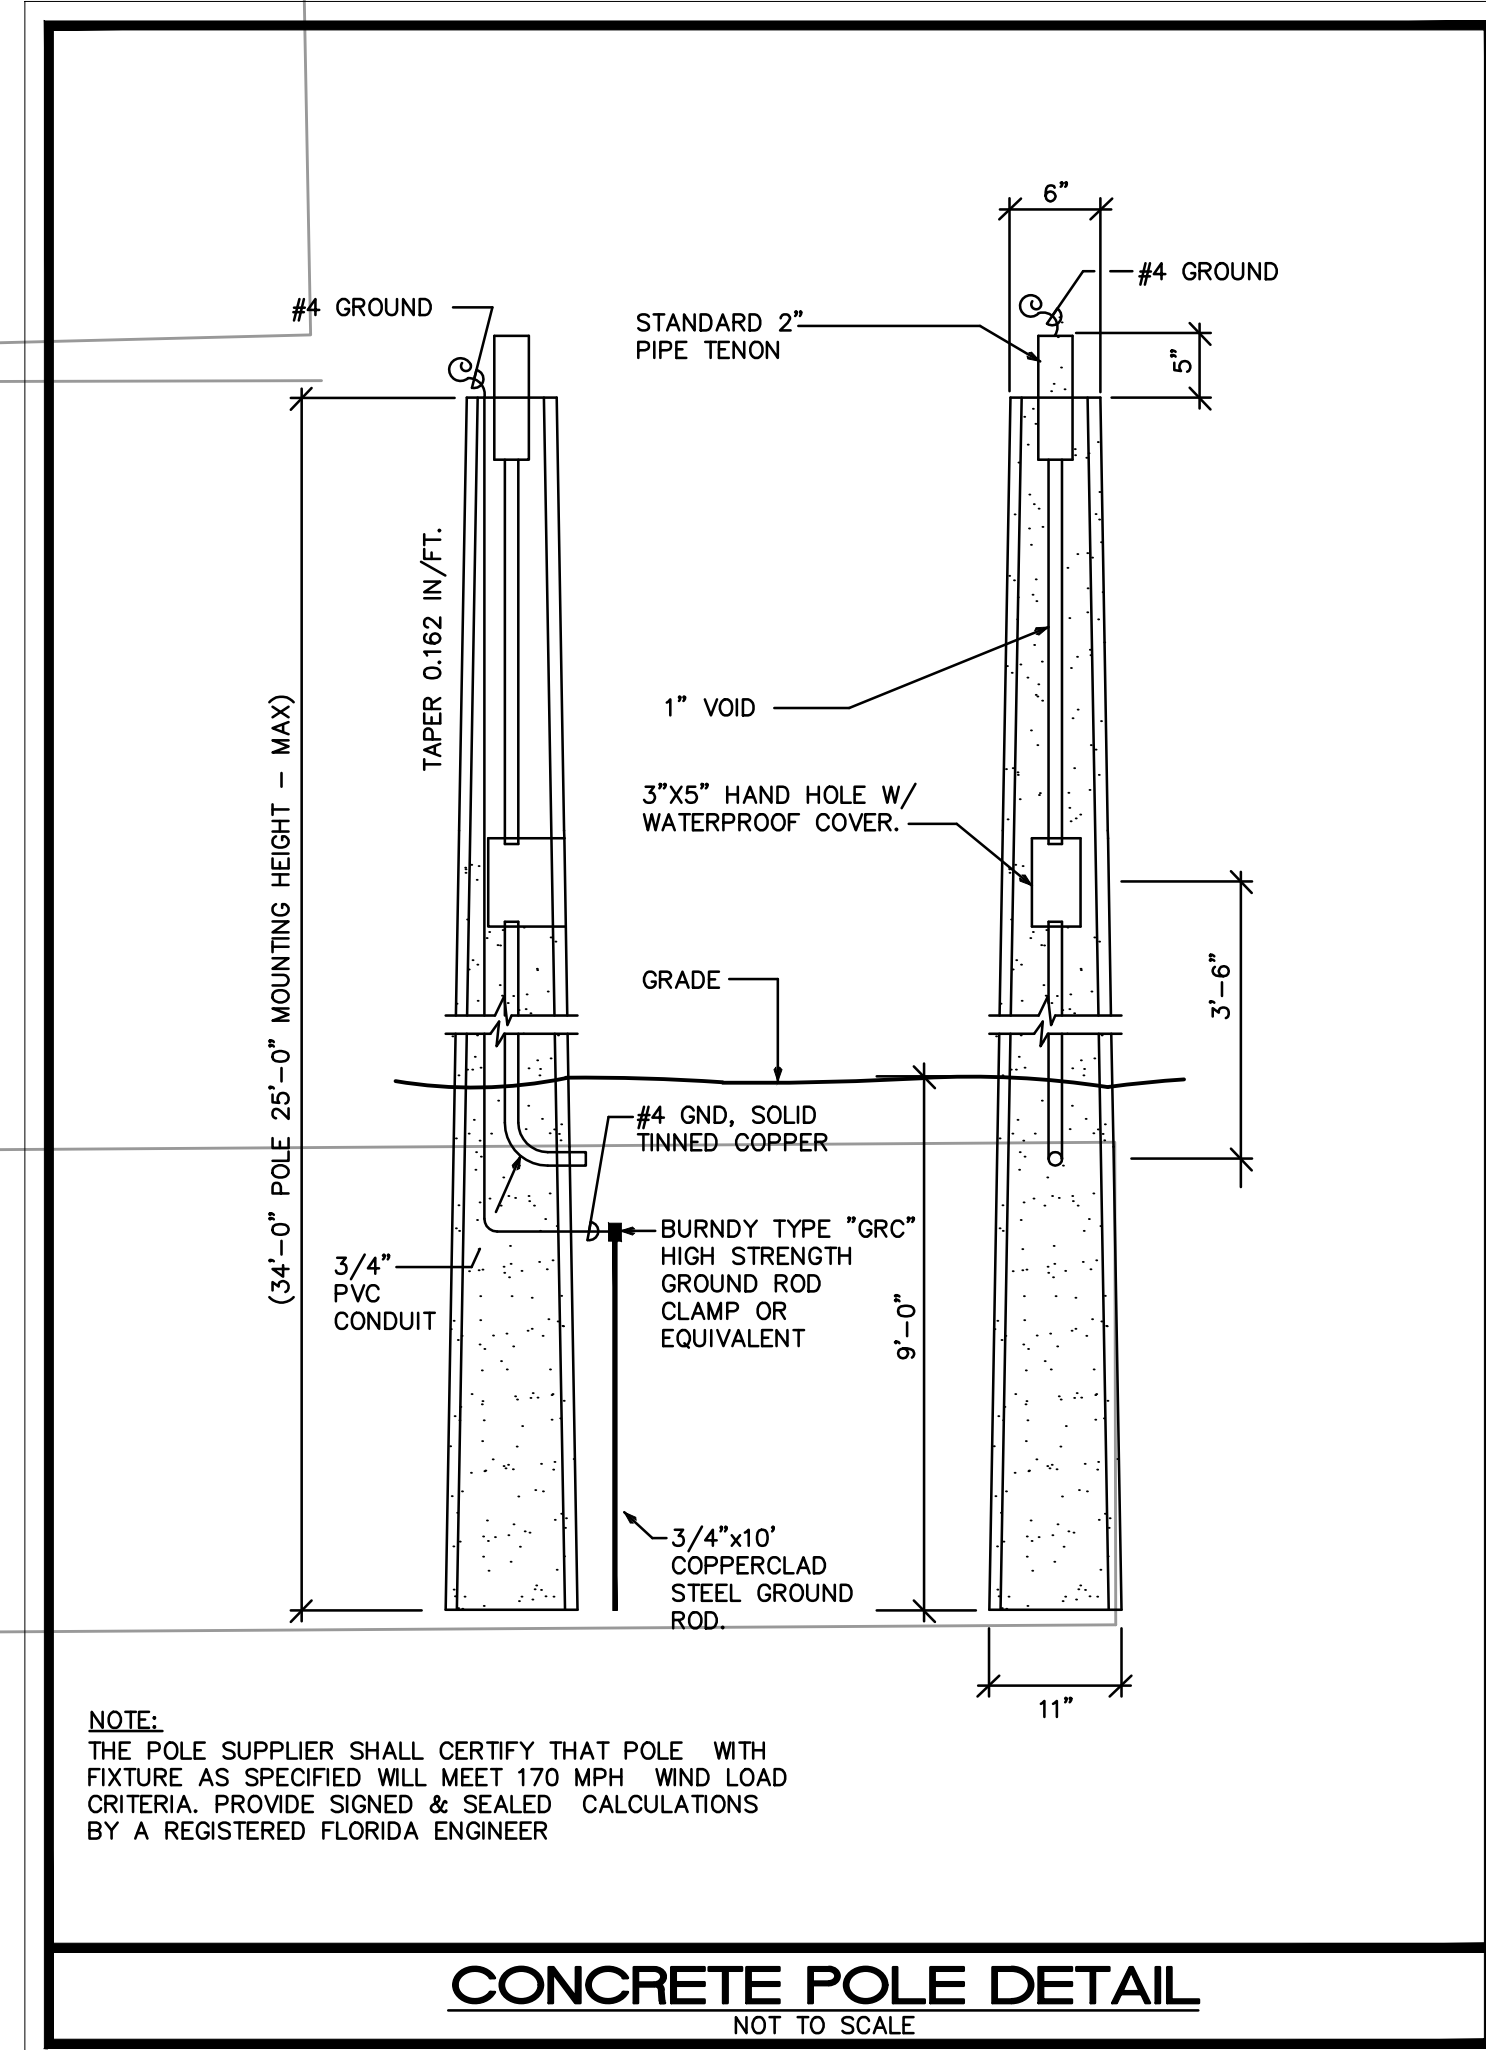

NOTE:  
 THE POLE SUPPLIER SHALL CERTIFY THAT POLE WITH  
 FIXTURE AS SPECIFIED WILL MEET 170 MPH WIND LOAD  
 CRITERIA. PROVIDE SIGNED & SEALED CALCULATIONS  
 BY A REGISTERED FLORIDA ENGINEER

CONCRETE POLE DETAIL  
 NOT TO SCALE

Symbol	Qty	Label	Description	Location	LF	Len. Wt.	Total Wt.
⊠	1	SA	VERIBARRE NOW-L3-6-T6-120C-7-0E POLE MOUNT 27'-0" AFF	N.A.	0.000	270	270
⊠	1	SA1	VERIBARRE NOW-L3-6-T6-120C-10-0E POLE MOUNT 27'-0" AFF	N.A.	0.000	437	437
⊠	1	SW	VERIBARRE NOW-L3-6-T6W-120C-10-0E WALL MOUNT 27'-0" AFF	N.A.	0.000	864	864
⊠	1	SW1	VERIBARRE NOW-L3-6-T6-120C-10-0E WALL MOUNT 27'-0" AFF	N.A.	0.000	914	914

Label	Ang	Min	Max	Ang Min	Max Min
LOADING	2.04	7.0	0.0	2.10	2.70
PARING	0.07	10.0	0.0	4.24	13.25
SPILL	0.11	0.0	0.0	N.A.	N.A.

ISSUED FOR REVIEW

KAMM CONSULTING PROJECT #: 2015-0166  
 PROJECT MANAGER: DUANE MILLAR

**KAMM Consulting**  
 1408 Orange Avenue  
 Fort Pierce, Florida 34950  
 Phone 772.595.1744 Fax 772.595.1745  
 engineering@kammconsulting.com  
 Certification of Authorization #8189

PRINCIPAL: Brady L. Brown Florida License #58232  
 date: 5-28-15  
 signed: \_\_\_\_\_