

### Introduction

The modern styling of the D-Series features a high performance, high efficiency long life LED Area Luminaire. The D-Series offers the best of both worlds: a modern, sleek design and a high performance, high efficiency long life LED Area Luminaire. The D-Series offers the best of both worlds: a modern, sleek design and a high performance, high efficiency long life LED Area Luminaire.

### Specifications

EPA: 0.4-1.1  
 Length: 36.1" (915 mm)  
 Width: 19.5" (495 mm)  
 Height: 11.1" (282 mm)  
 Weight: 2.6 lb (1.2 kg)

### Ordering Information

Order ID	Part Number	Notes
0000	0000	0000

### Specifications

Beam DDI: 15°  
 Height: 11.1"  
 Weight: 2.6 lb

### Ordering Information

Order ID	Part Number	Notes
0000	0000	0000

### LIGHTING FIXTURE SCHEDULE

NO.	DESCRIPTION	QTY	UNIT	MANUFACTURER	REMARKS
1	150W LED-44-30K-800R-TM-INT-FC	1200	EA	OSRAM	
2	150W LED-44-30K-800R-TM-INT-FC	1200	EA	OSRAM	
3	150W LED-44-30K-800R-TM-INT-FC	1200	EA	OSRAM	
4	150W LED-44-30K-800R-TM-INT-FC	1200	EA	OSRAM	


### LEGACY CONSORTIUM PARKING PHOTOMETRICS

510 ORANGE AVE, FORT PIERCE, FL 34950

DATE: 08-19-25  
 SCALE: AS NOTED  
 PROJECT NO: 250204  
 DESIGNED BY: BUB  
 DRAWN BY: BUB  
 CHECKED BY: DEB  
 DRAWING NO: SP1

### STATISTICS

RECEPTION SYMBOL	AVG	MAX	MIN	MAX	AVG/AM	AVG/AM
PROPERTY LINE	±	0.1	12.6	0.0	0.4	N/A
PARALLEL PATH	±	1.5	13.6	0.4	2.5	1.1
PARALLEL PATH	±	1.0	11.5	0.0	1.1	1.1

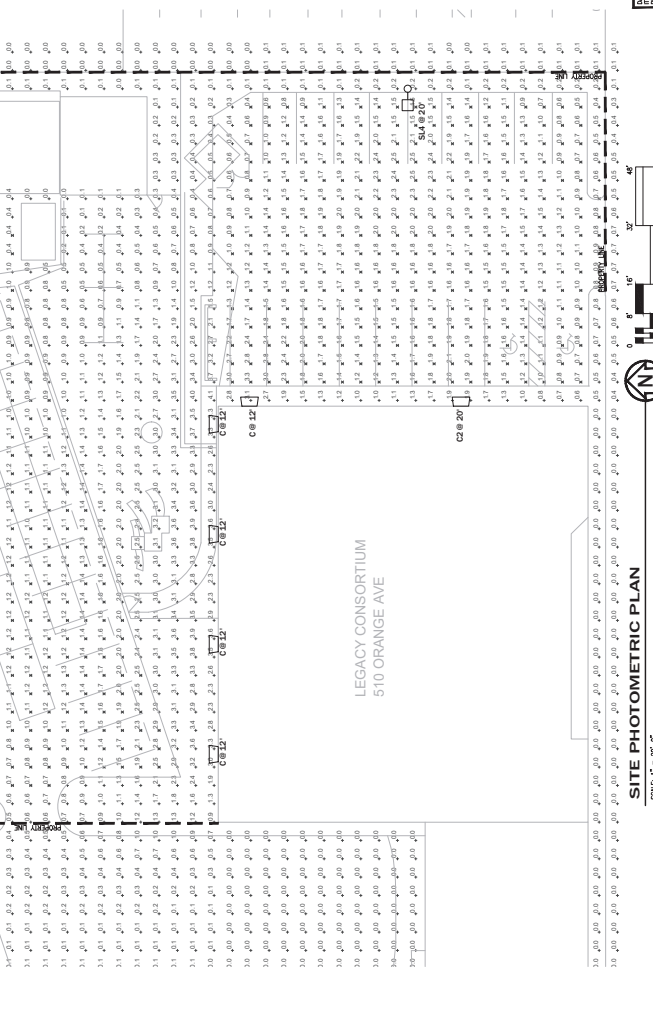

### LEGACY CONSORTIUM PARKING PHOTOMETRICS

510 ORANGE AVE, FORT PIERCE, FL 34950


DATE: 08-19-25  
 SCALE: AS NOTED  
 PROJECT NO: 250204  
 DESIGNED BY: BUB  
 DRAWN BY: BUB  
 CHECKED BY: DEB  
 DRAWING NO: SP1



### LEGACY CONSORTIUM PARKING PHOTOMETRICS

510 ORANGE AVE, FORT PIERCE, FL 34950

DATE: 08-19-25  
 SCALE: AS NOTED  
 PROJECT NO: 250204  
 DESIGNED BY: BUB  
 DRAWN BY: BUB  
 CHECKED BY: DEB  
 DRAWING NO: SP1

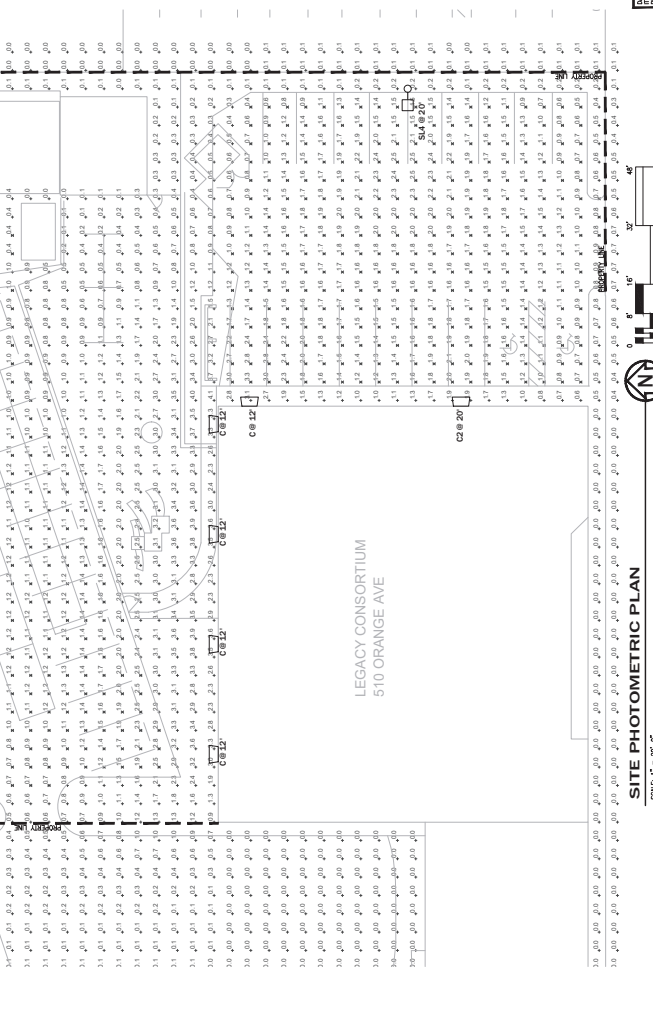

### LEGACY CONSORTIUM PARKING PHOTOMETRICS

510 ORANGE AVE, FORT PIERCE, FL 34950

DATE: 08-19-25  
 SCALE: AS NOTED  
 PROJECT NO: 250204  
 DESIGNED BY: BUB  
 DRAWN BY: BUB  
 CHECKED BY: DEB  
 DRAWING NO: SP1

