


Doctor Shareef Site Plan V2

Proposed Lighting Layout

SHEET L01 : LIGHTING SCHEDULE/SUMMARY PAGE

SHEET L02 : PHOTOTMETRIC STUDY

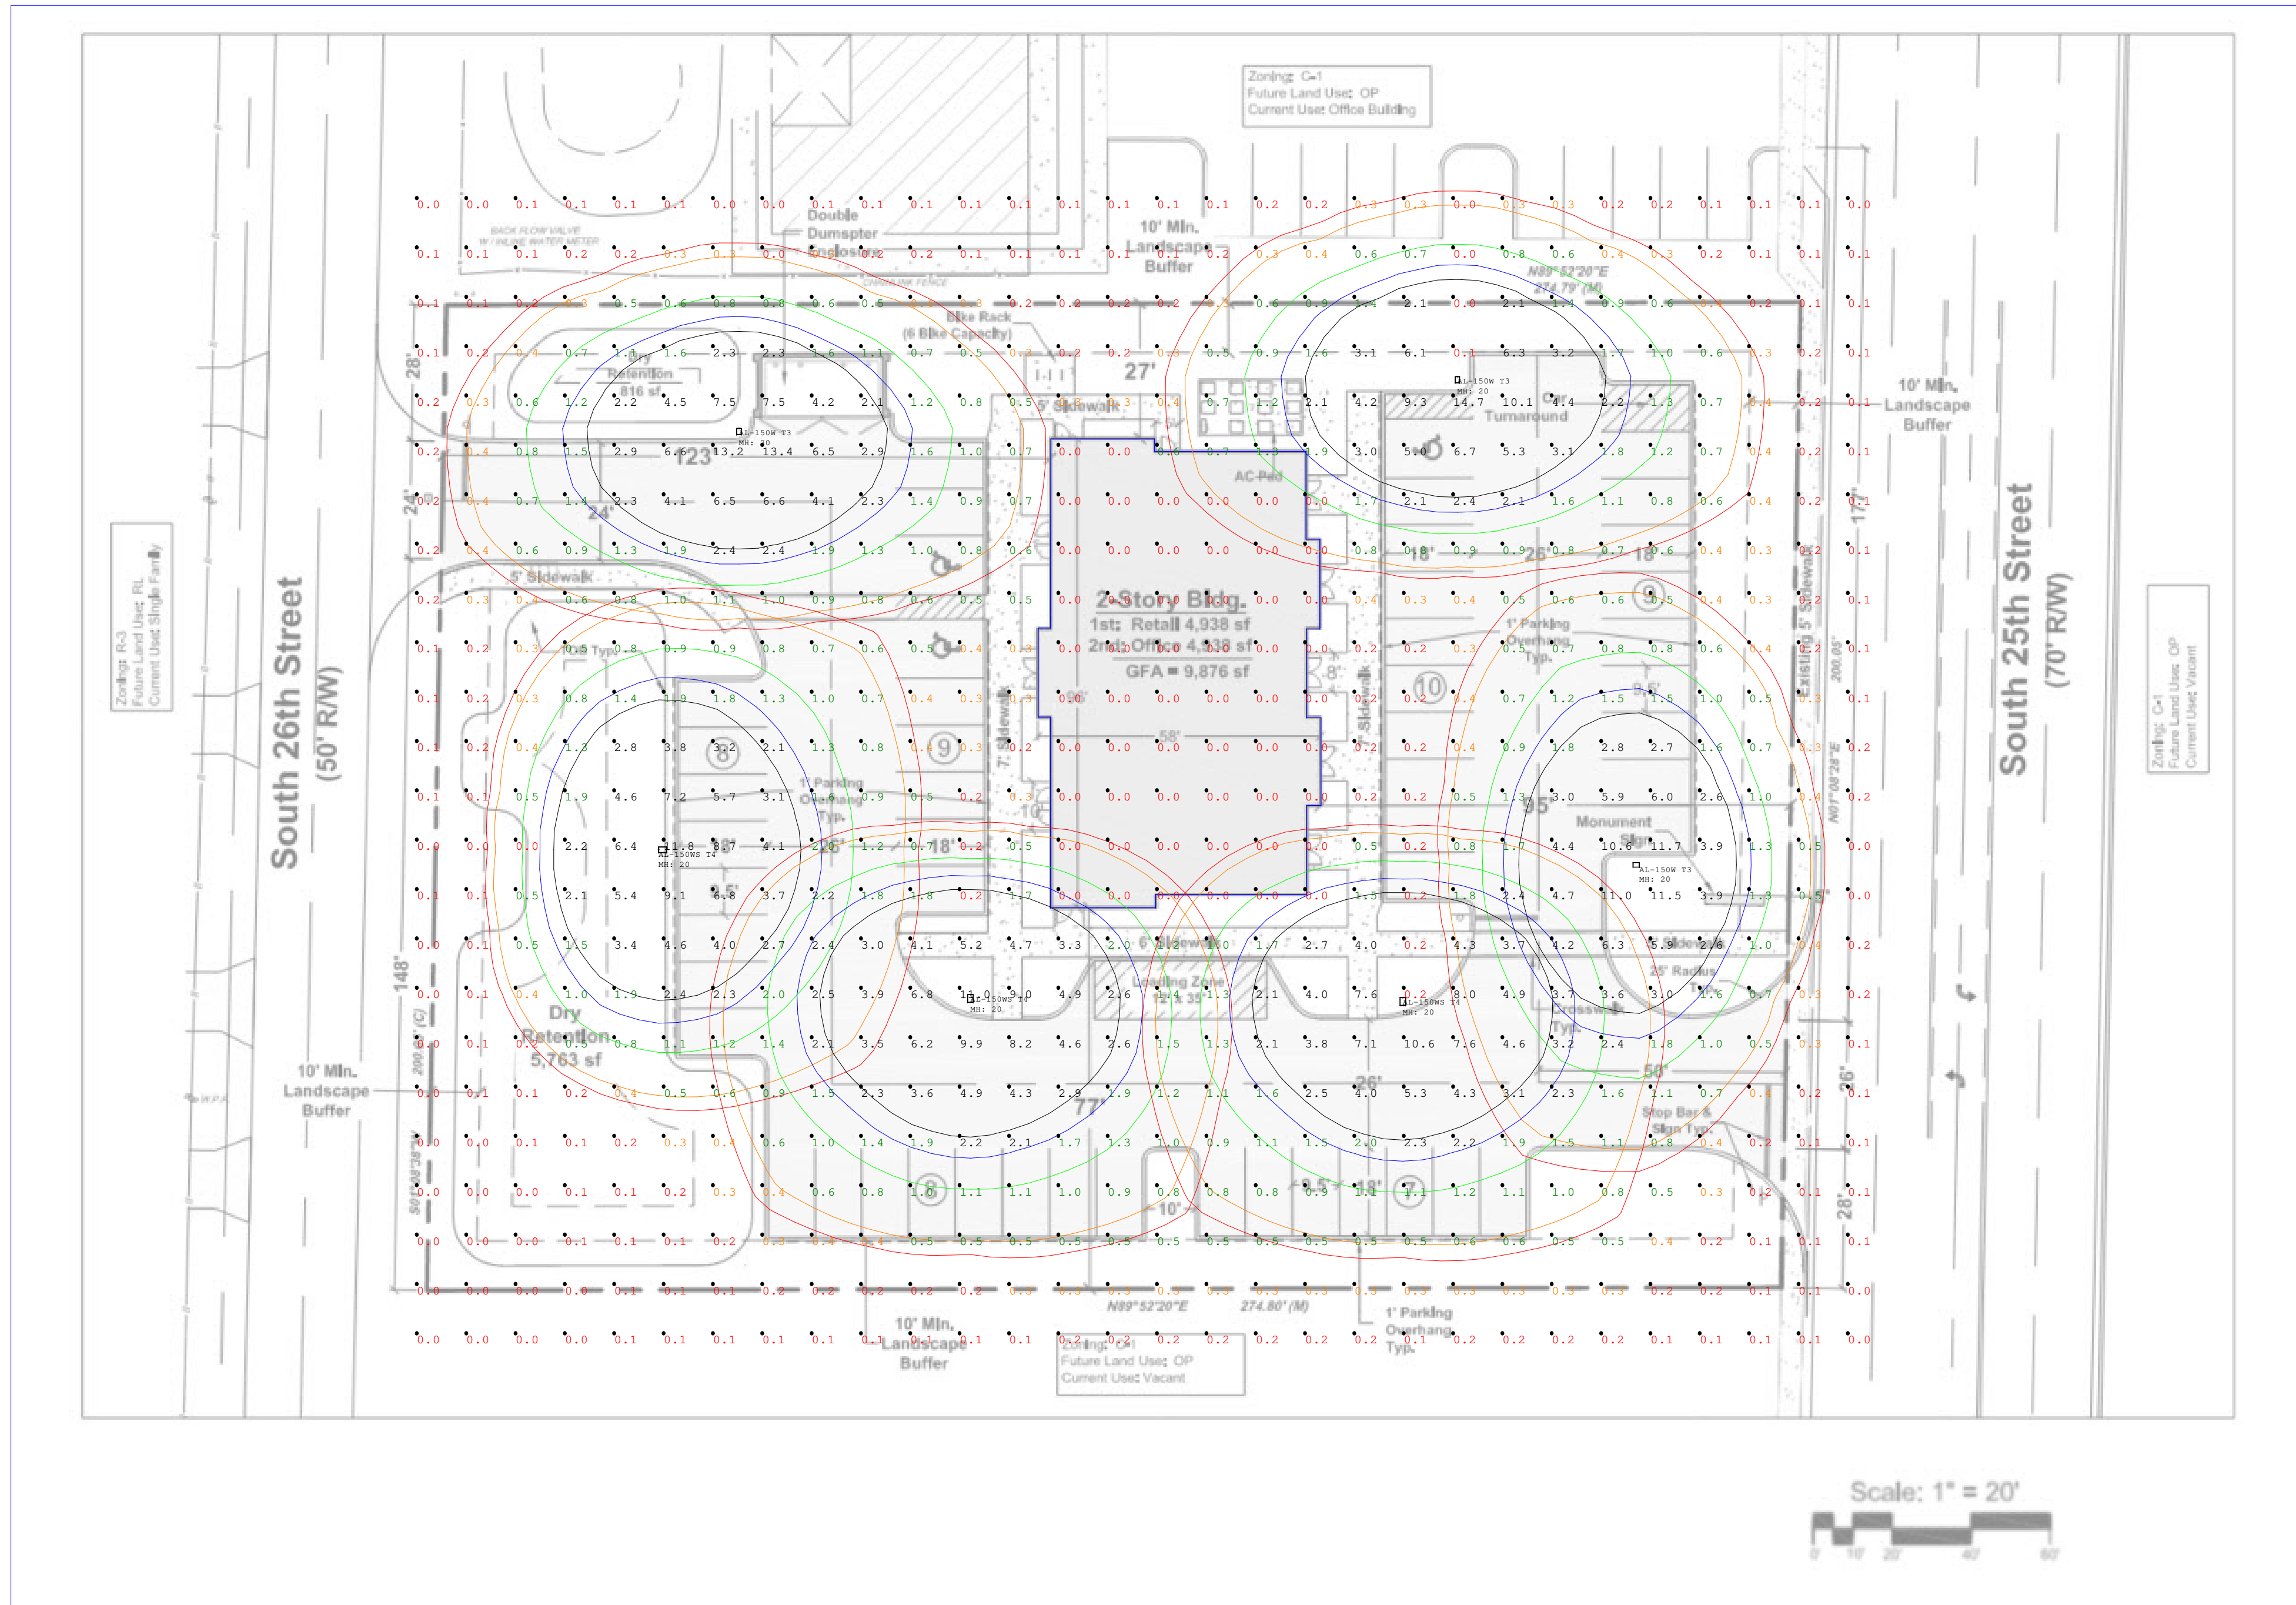

Photometric Layout

SHEET

CLIENT

ADDRESS

STATISTICAL SUMMARY

LPD Area Summary			
Label	Area	Total Watts	LPD
LPDArea_1	151148	849.678	0.006

Calculation Summary							
Label	CalcType	Units	Avg	Max	Min	Avg/Min	Max/Min
CalcPts_1	Illuminance	Fc	1.33	14.7	0.0	N.A.	N.A.

FIXTURE SCHEDULE

Luminaire Schedule								
Qty	Symbol	Label	Arrangement	Lum. Watts	Total Watts	Lum. Lumens	LLF	Description
3	☐	AL-150W T3	Single	141.666	424.998	18448	0.930	AL-150WS-3CS-U-SO-NM-BZ(150W)-SK-T3
3	☐	AL-150WS T4	Single	141.56	424.68	18535	0.930	AL-150WS-3CS-U-SO-NM-BZ

DESIGNER: SG

DATE: 11.05.25

REV: 1

SCALE: NTS

L01


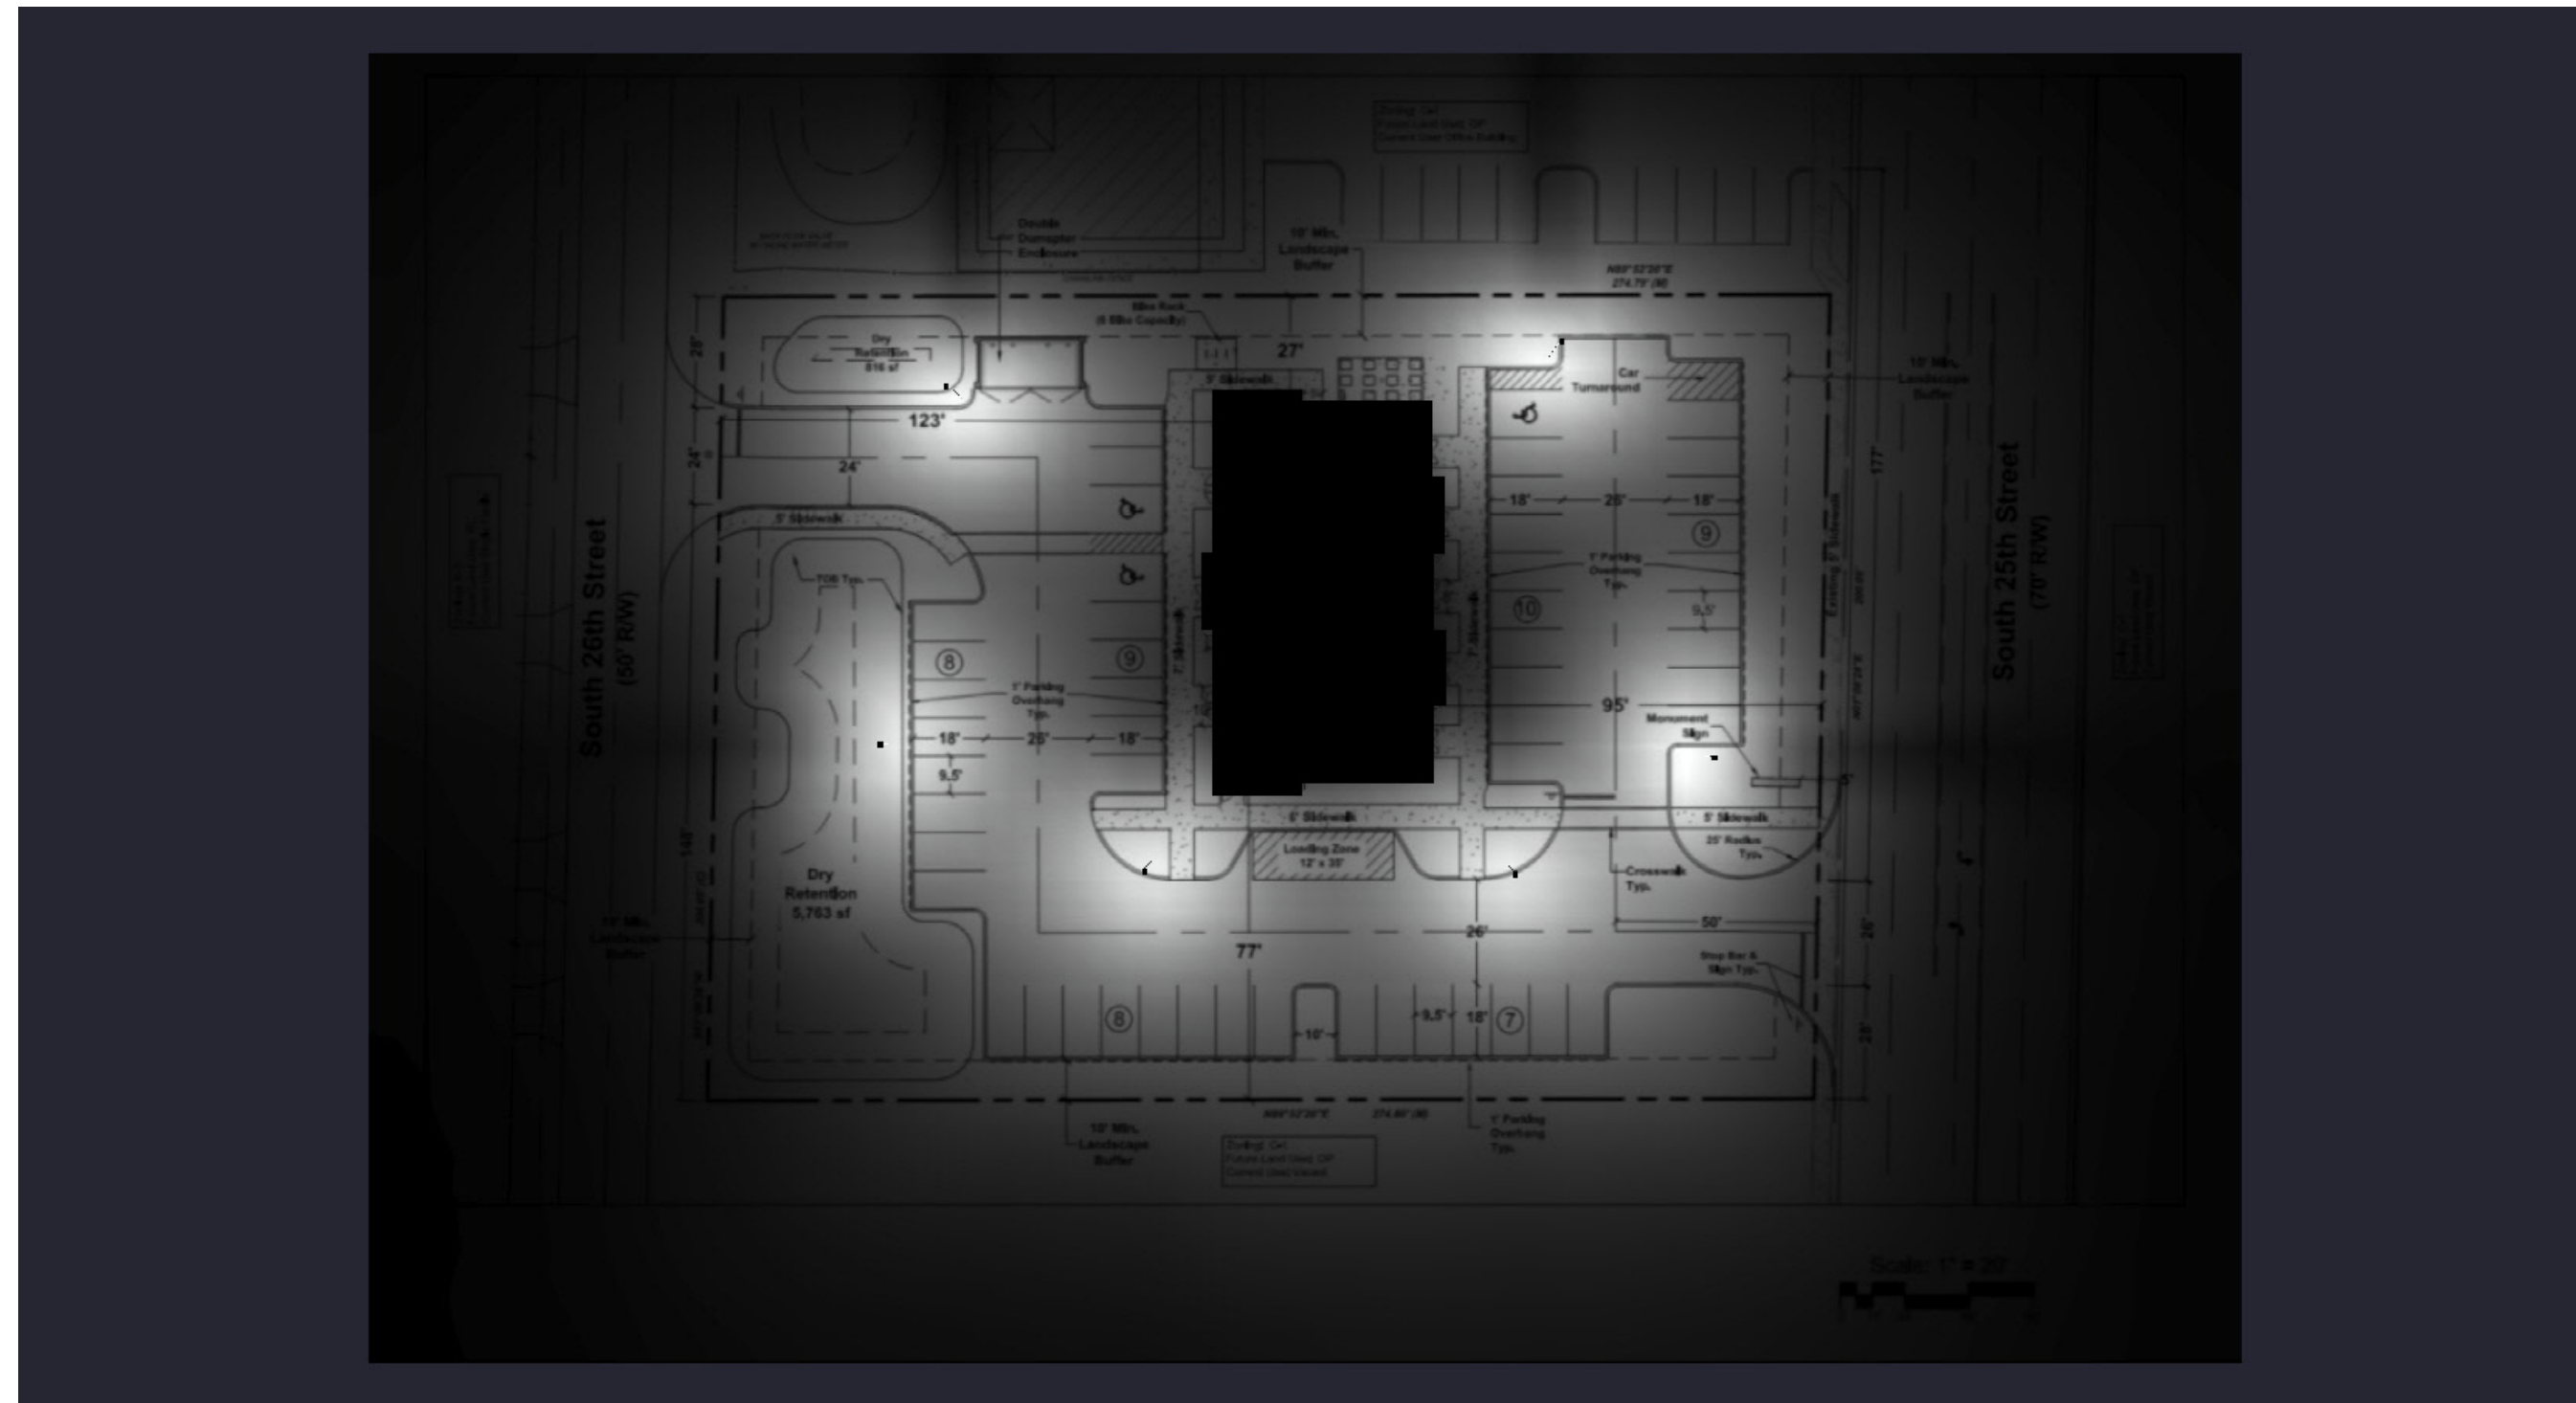


Image File : RenderViewpoint_1

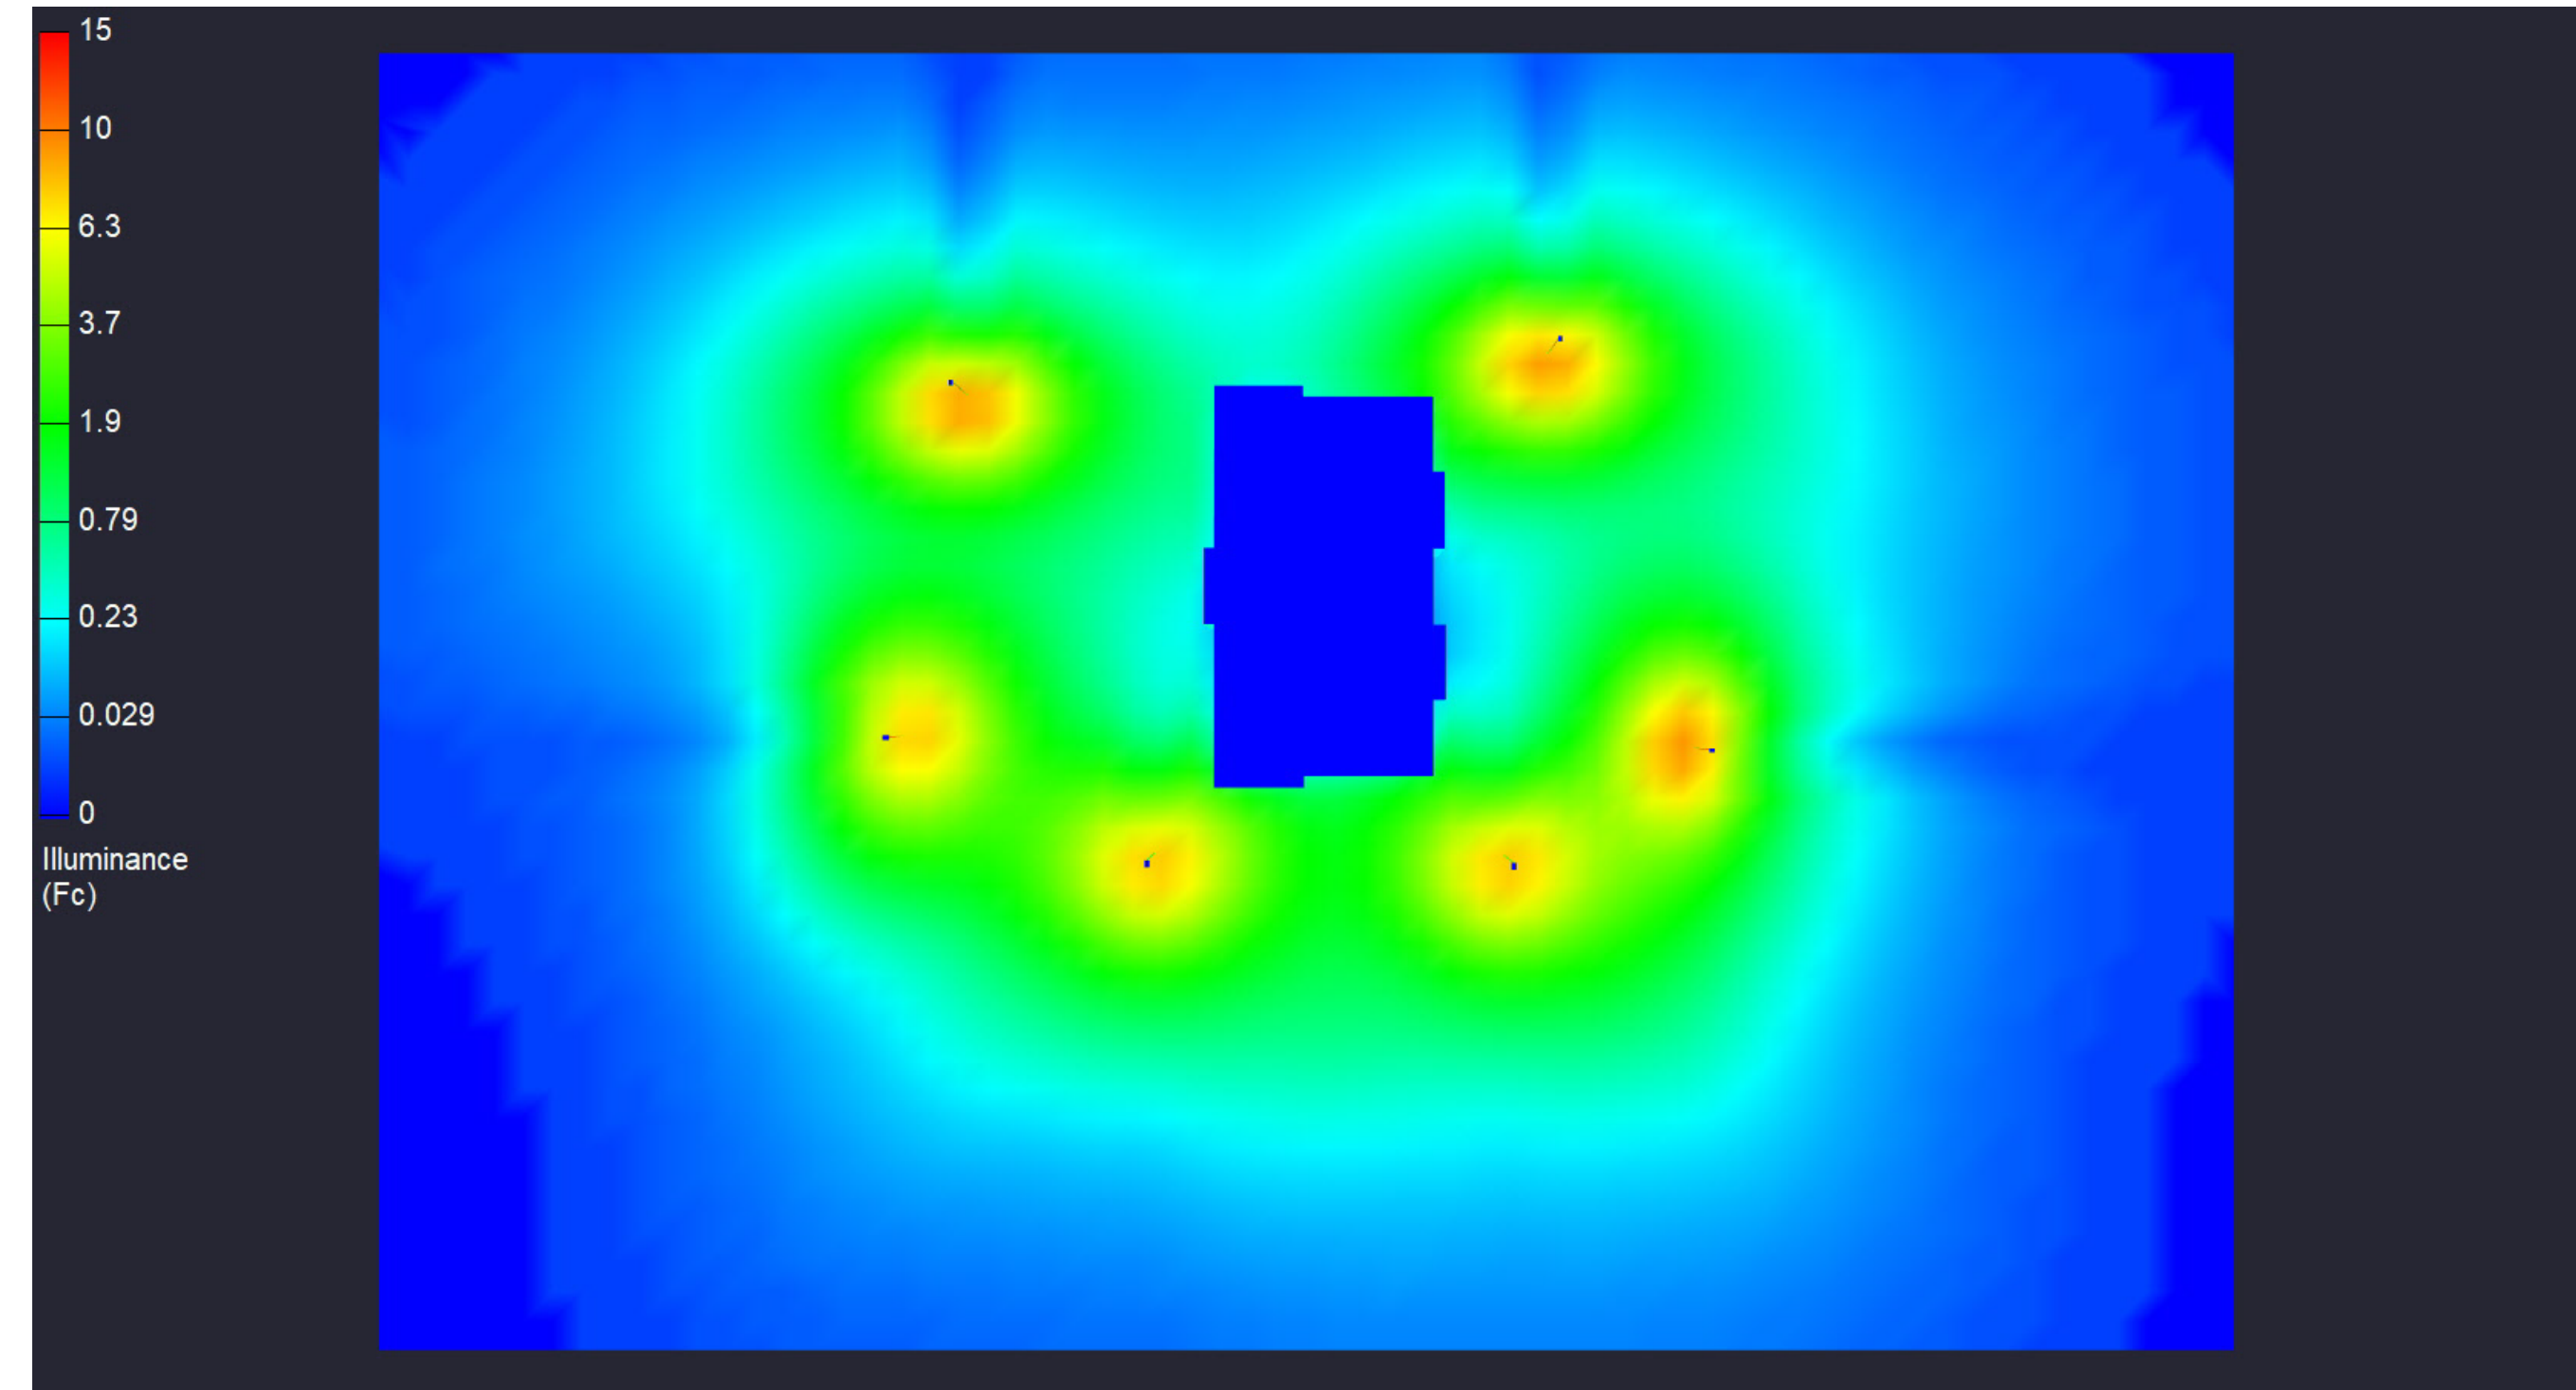

Render Image - View Name : RenderViewpoint_2

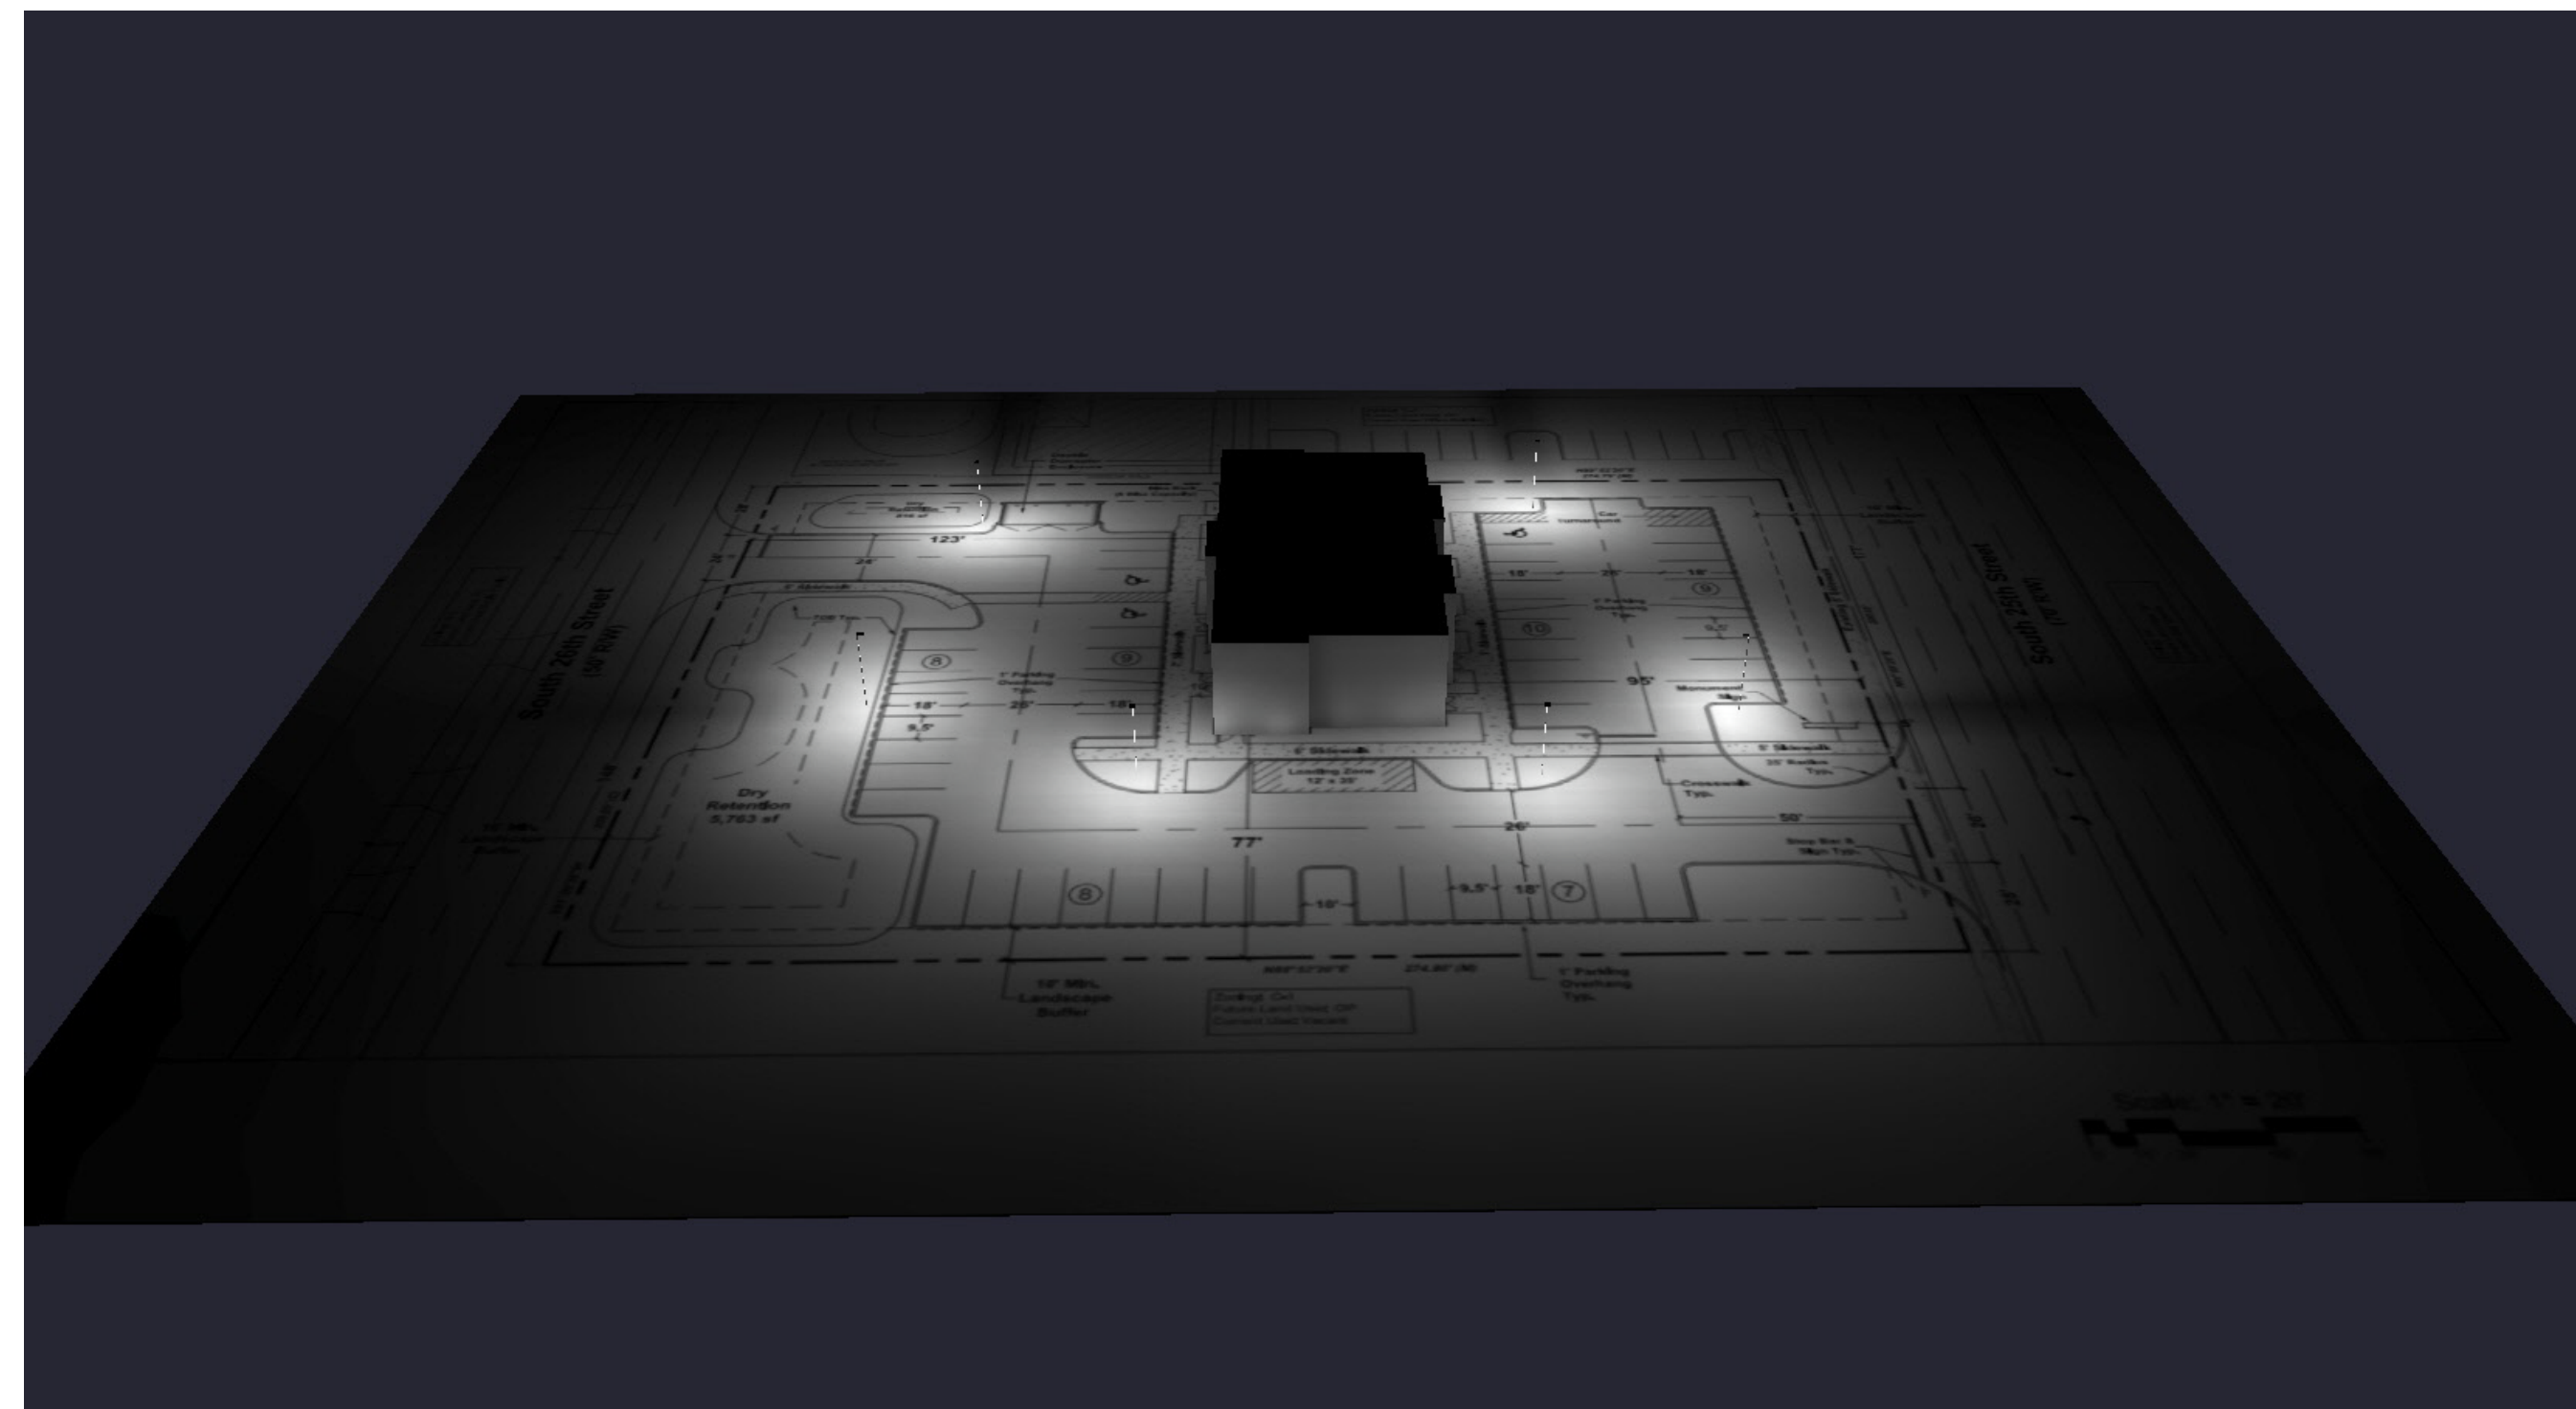


Image File : RenderViewpoint_3

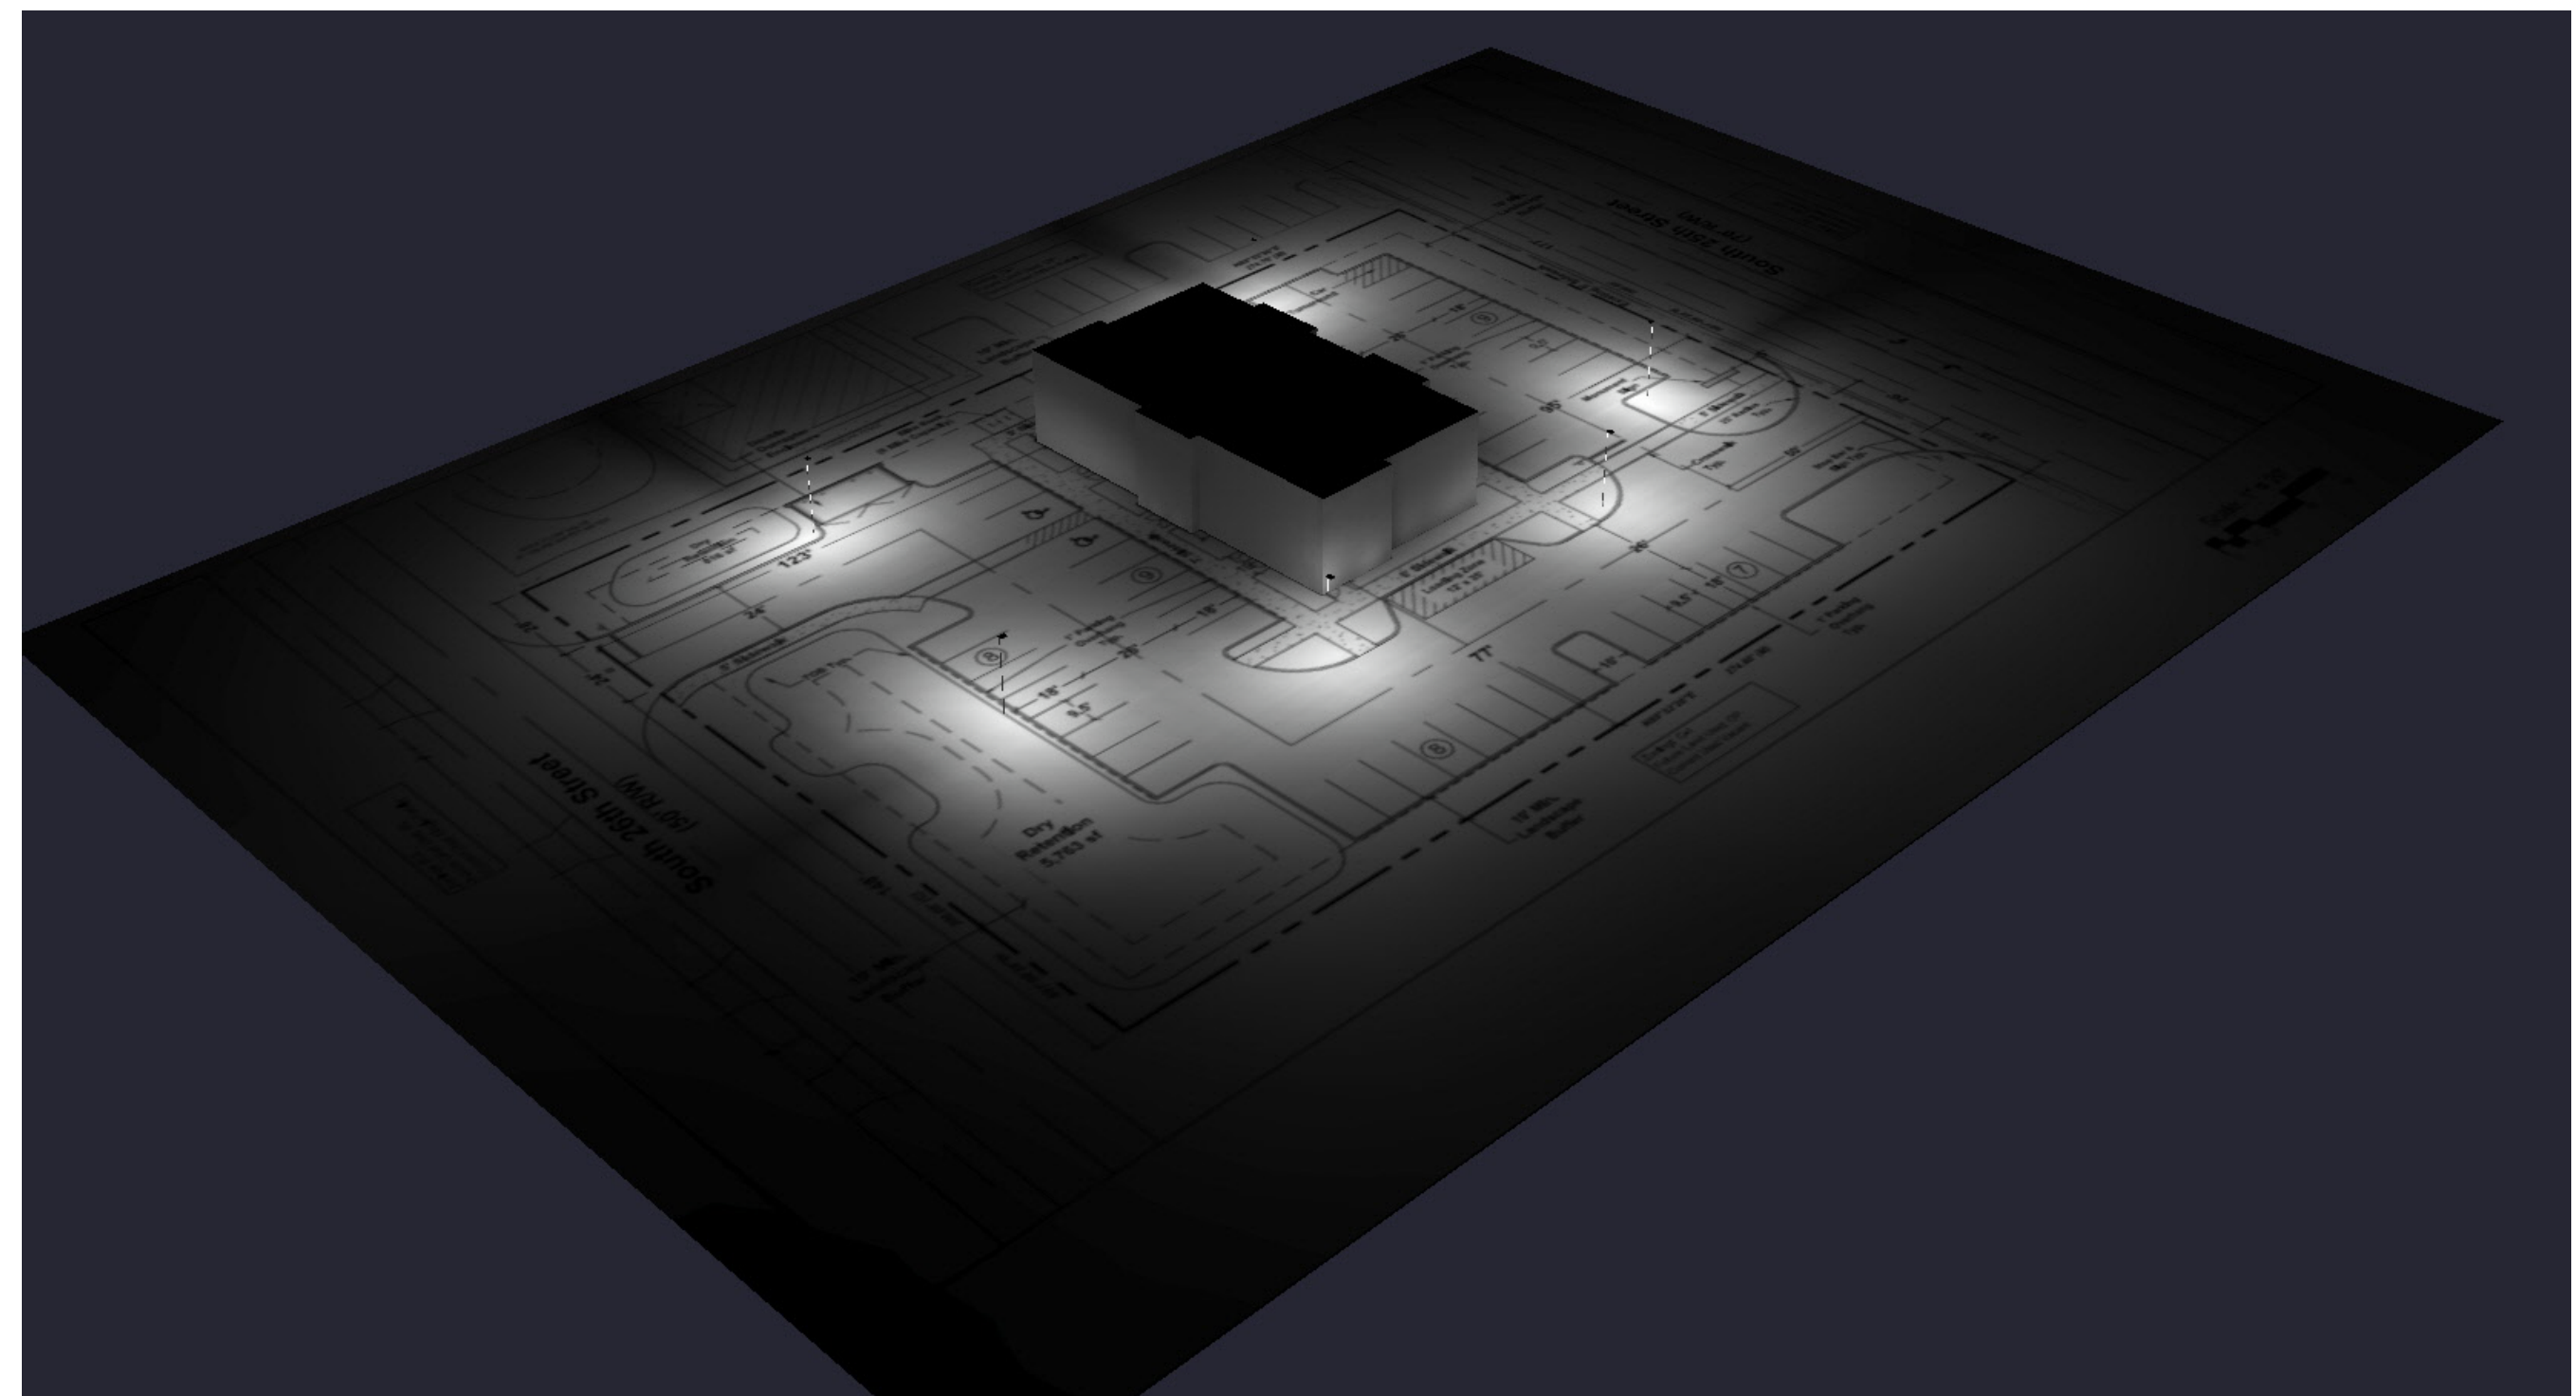


Image File : RenderViewpoint_4

Photometric Layout

SHEET

CLIENT

ADDRESS

DESIGNER: SG

DATE: 11.05.25

REV: 1

SCALE: NTS