


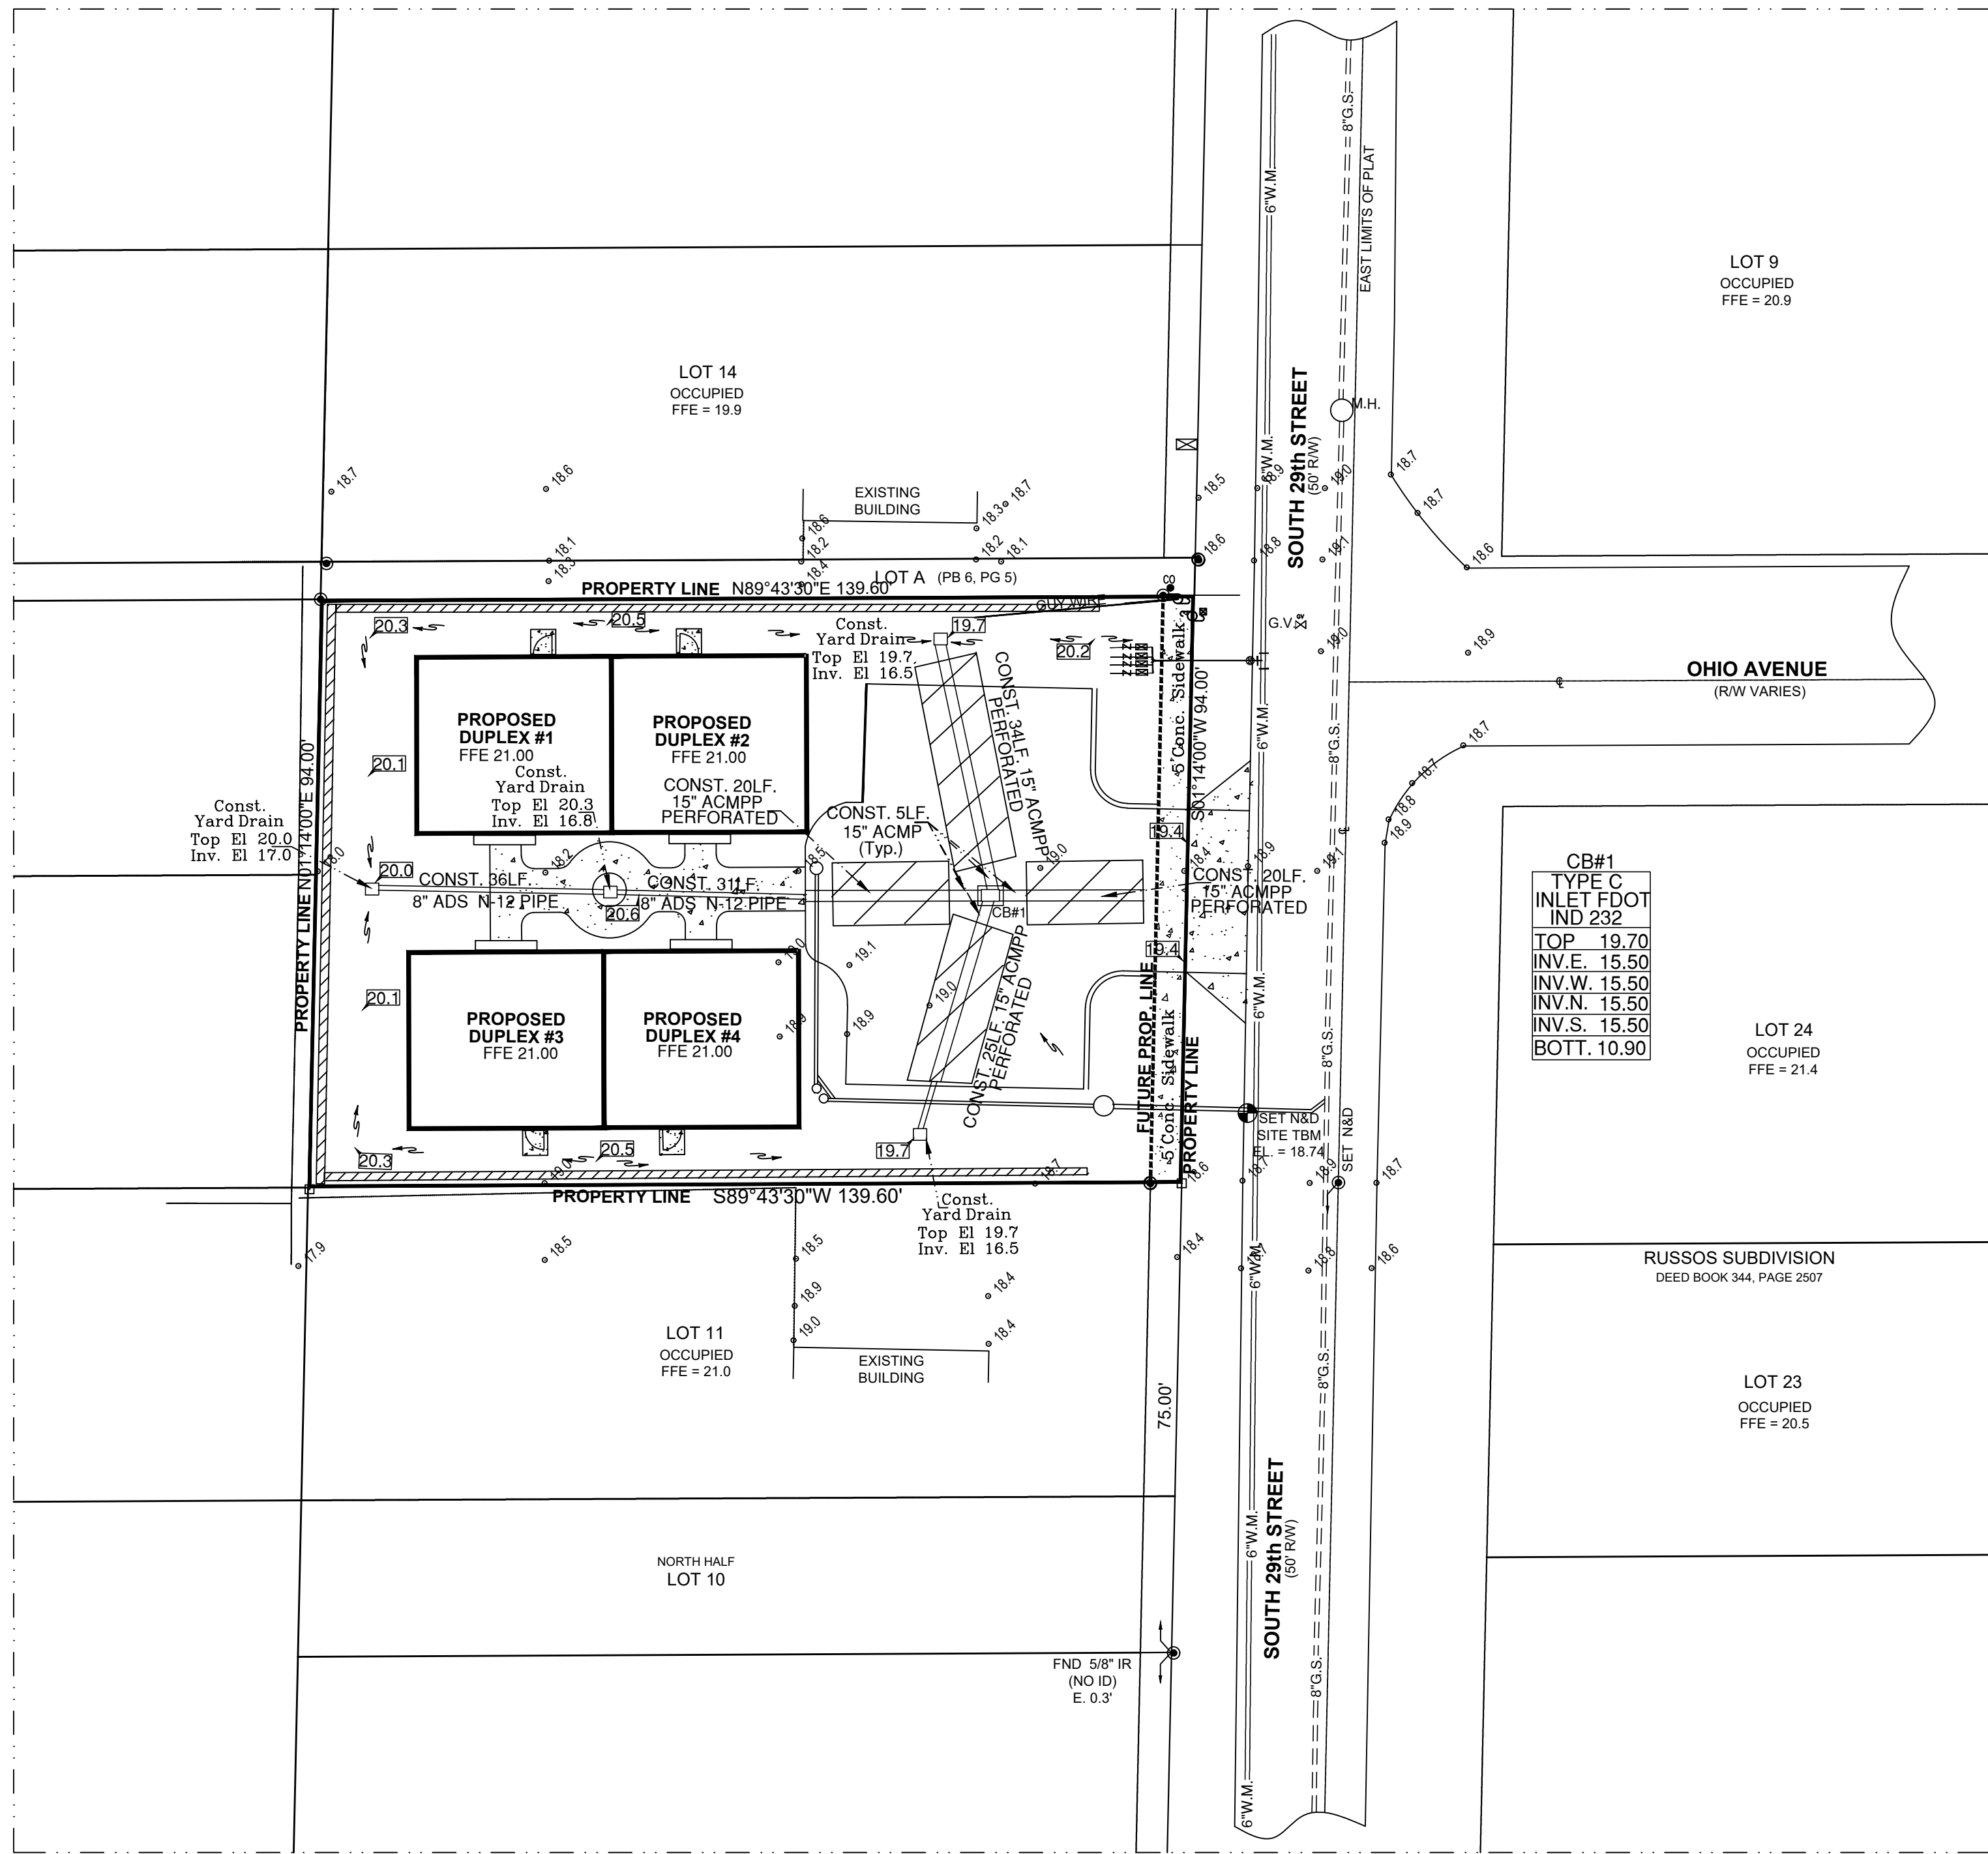


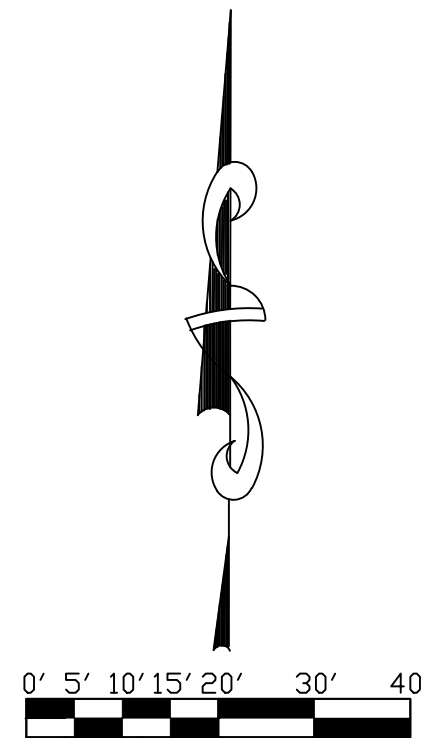

LEGEND	
	EXISTING GRADE ELEVATION
	HIGH POINT
	PROPOSED ELEVATION
	RUNOFF FLOW DIRECTION
	FDOT MITERED END SECTION
	PIPE INVERT
	CORRUGATED POLYETHYLENE PIPE (N12) MANUF. BY ADS
	CORRUGATED POLYETHYLENE PIPE, PERFORATED (N12) MANUF. BY ADS

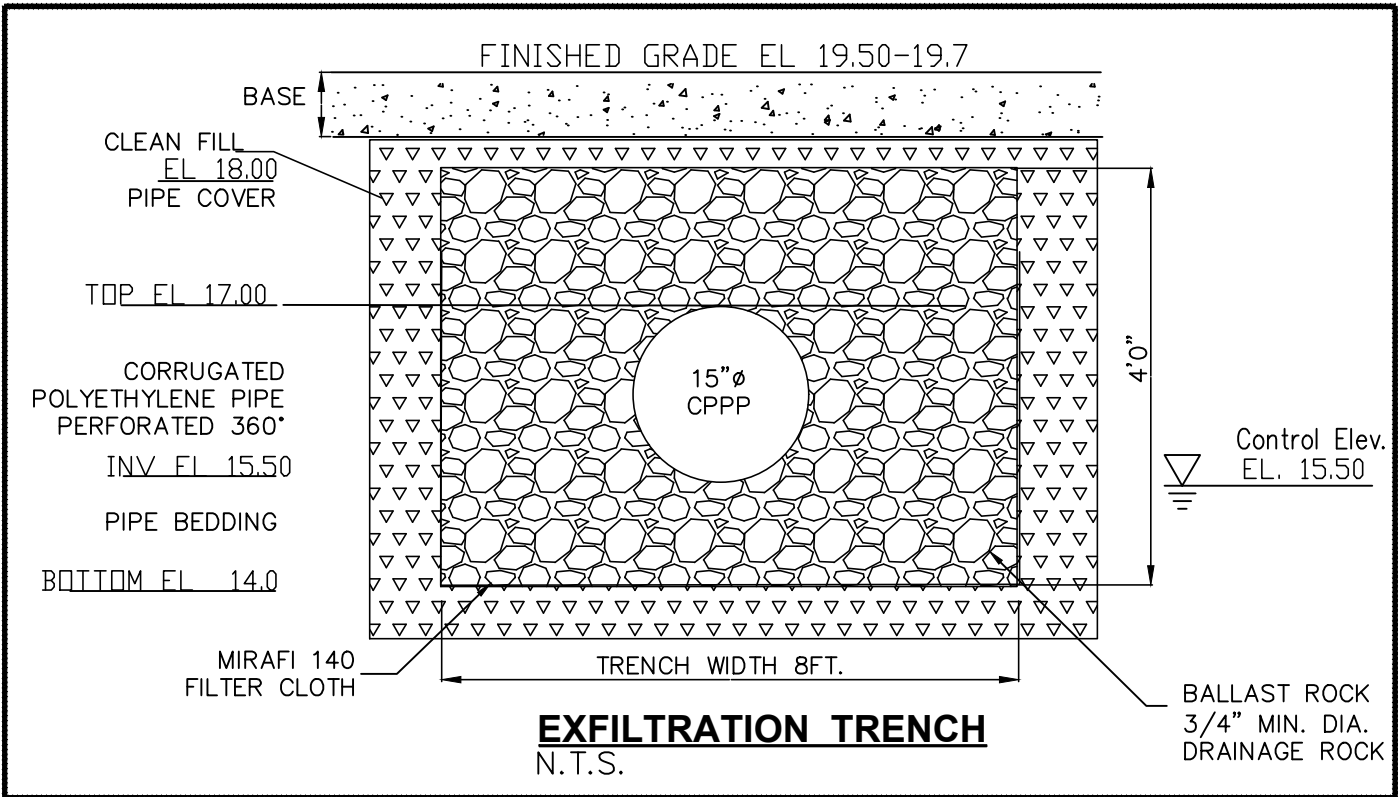

This item has been digitally signed & sealed by **Abraham Chabab, PE**





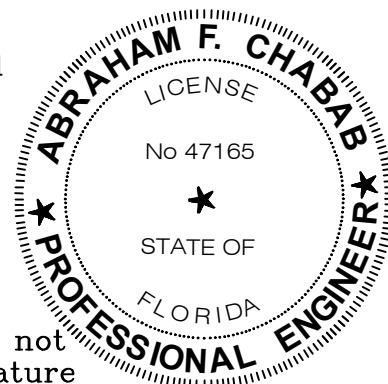


Printed copies of this document are not considered signed & sealed & the signature must be verified on any electronic copies



48 HOURS BEFORE DIGGING
CALL TOLL-FREE
1-800-432-4770
SUNSHINE STATE ONE CALL
OF FLORIDA, INC
UNDERGROUND UTILITIES NOTIFICATION CENTER

ABRAHAM CHABAB, Inc.
FL. BOARD OF PROF. ENG. AUTH.#26790
5019 NW Rugby Drive
PORT ST. LUCIE FL. 34983
Email: agchabab1@msn.com
Ph: 772-475-6630


29 th STREET DUPLEX	DESIGNED BY AC	REVISIONS		DATE
STORM SEWER PLAN	DRAWN BY AC			
	DATE Jun 12, 2026			
	SHEET 2 OF 4			

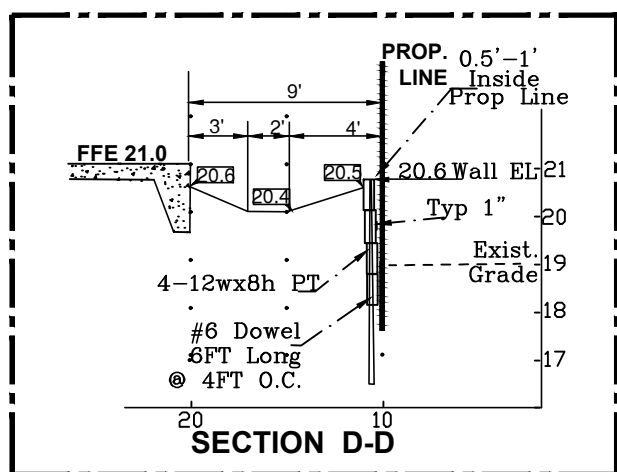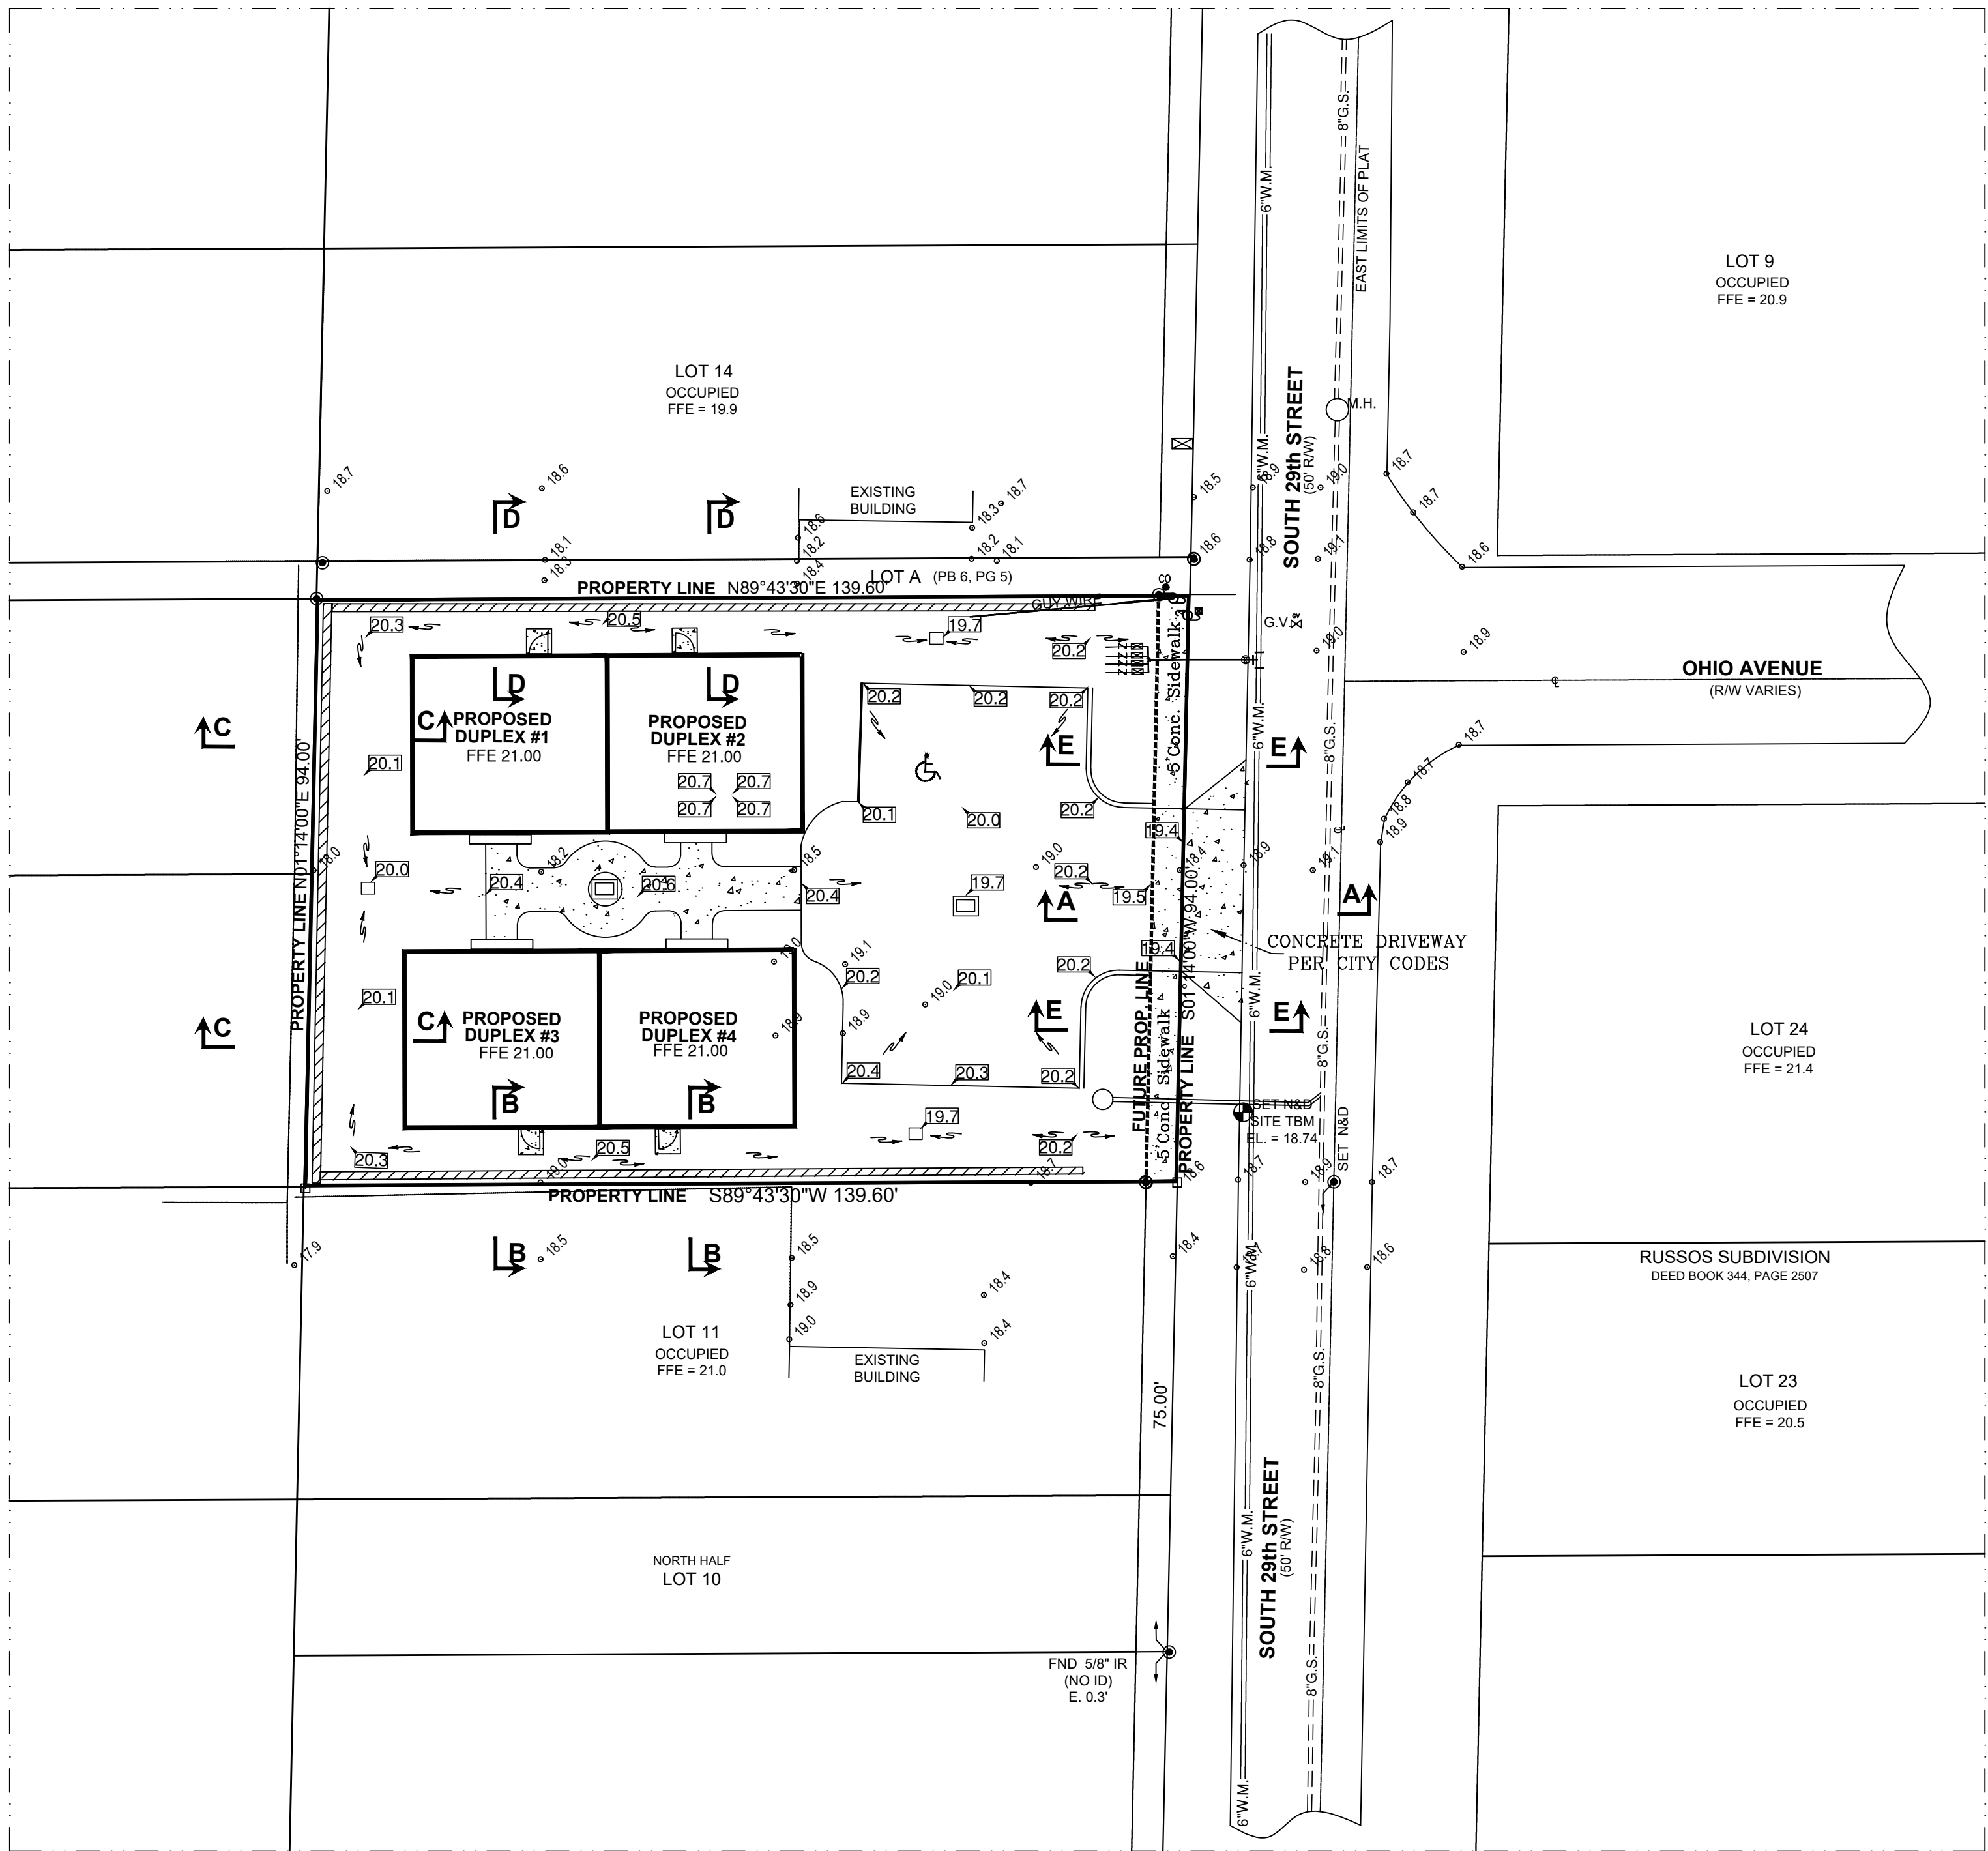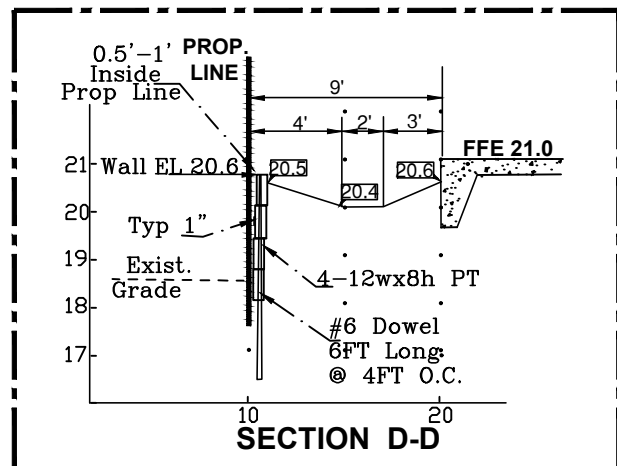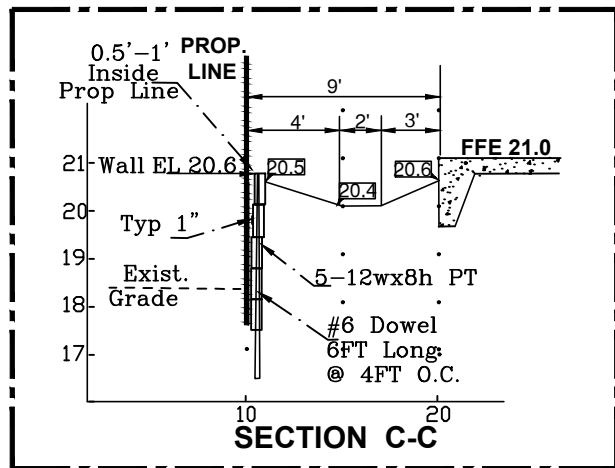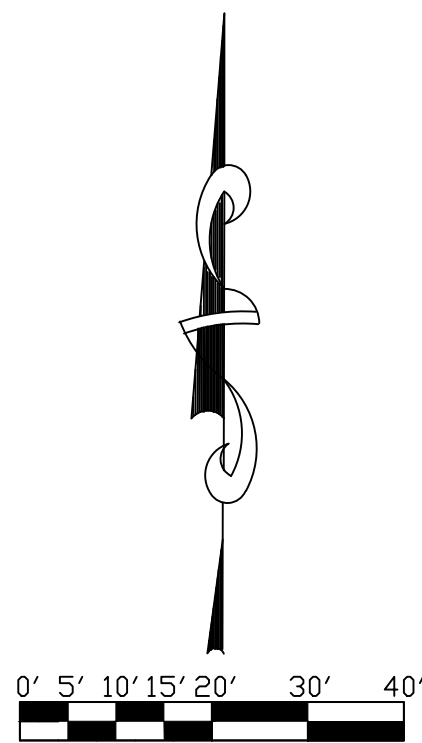

LEGEND	
	EXISTING GRADE ELEVATION
	HIGH POINT
	PROPOSED ELEVATION
	RUNOFF FLOW DIRECTION
	FDOT MITERED END SECTION
	PIPE INVERT
	CORRUGATED POLYETHYLENE PIPE (N12) MANUF. BY ADS
	CORRUGATED POLYETHYLENE PIPE PERFORATED (N12) MANUF. BY ADS

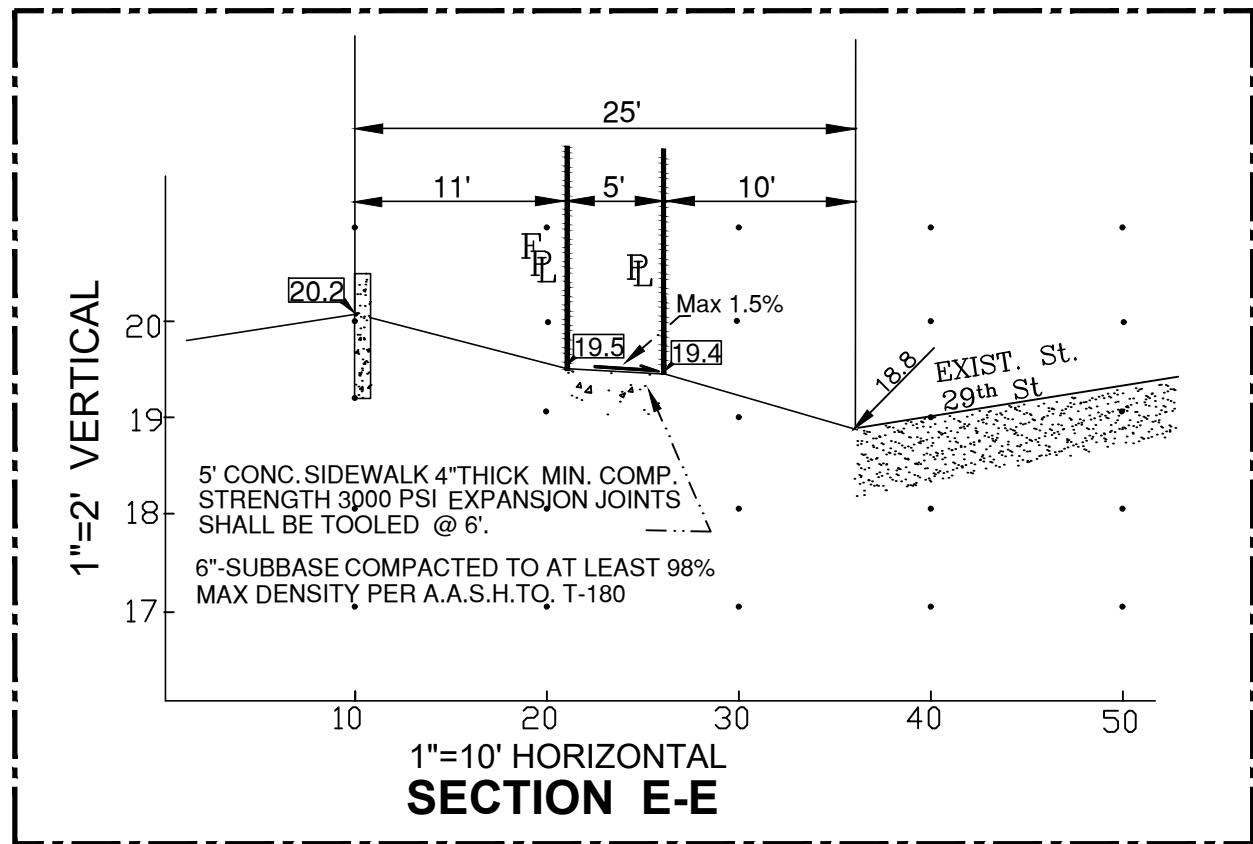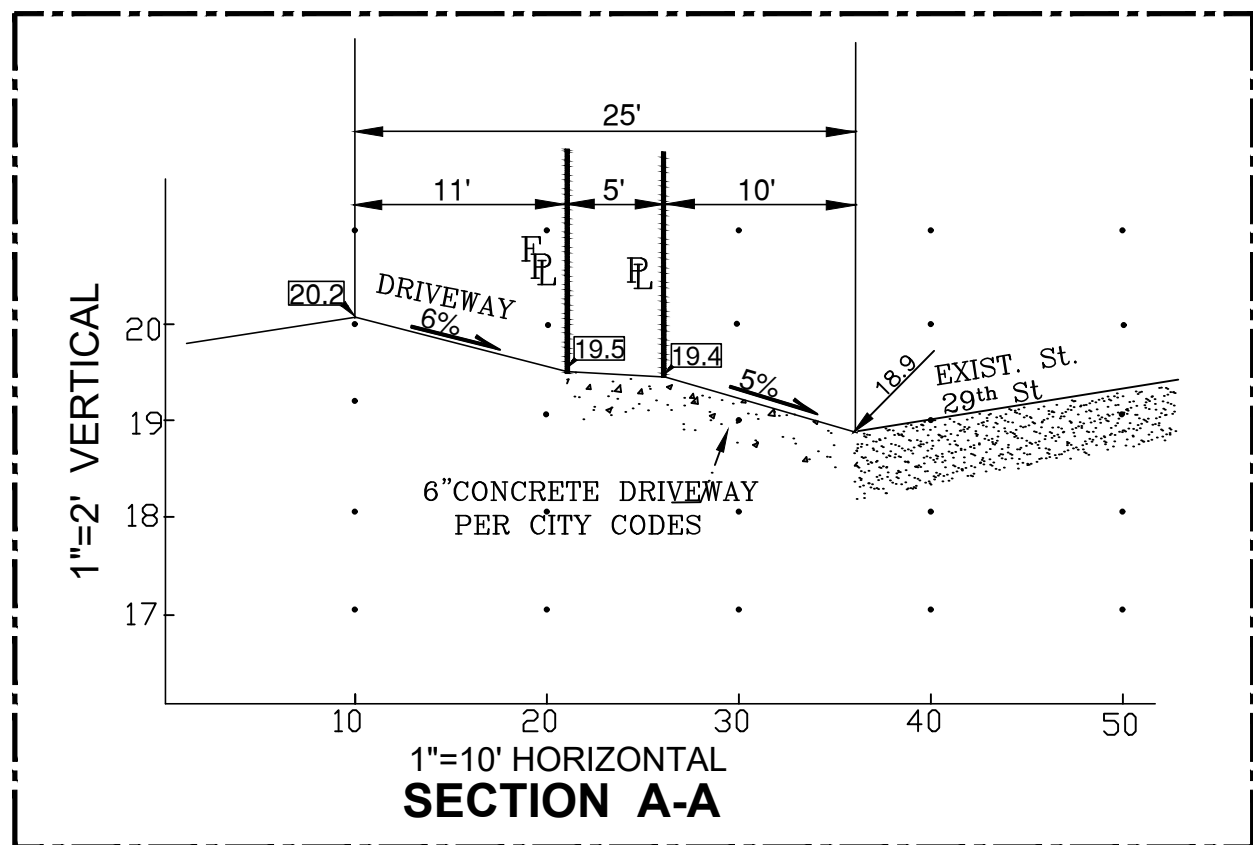

This item has been digitally signed and sealed by **Abraham Chabab, PE**


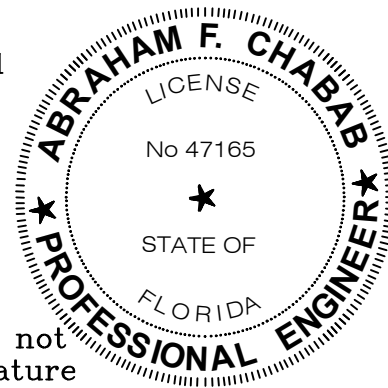


Printed copies of this document are not considered signed & sealed & the signature must be verified on any electronic copies

48 HOURS BEFORE DIGGING
CALL TOLL-FREE
1-800-432-4770
SUNSHINE STATE ONE CALL
OF FLORIDA, INC
UNDERGROUND UTILITIES NOTIFICATION CENTER

ABRAHAM CHABAB, Inc.
FL. BOARD OF PROF. ENG. AUTH.#26790
5019 NW Rugby Drive
PORT ST. LUCIE FL. 34983
Email: agchabab1@msn.com
Ph: 772-475-6630

29 th STREET DUPLEX	DESIGNED BY AC	REVISIONS	DATE
	DRAWN BY AC		
GRADING & PAVING PLAN	DATE Jun 12, 2026		
	SHEET 3 OF 4		

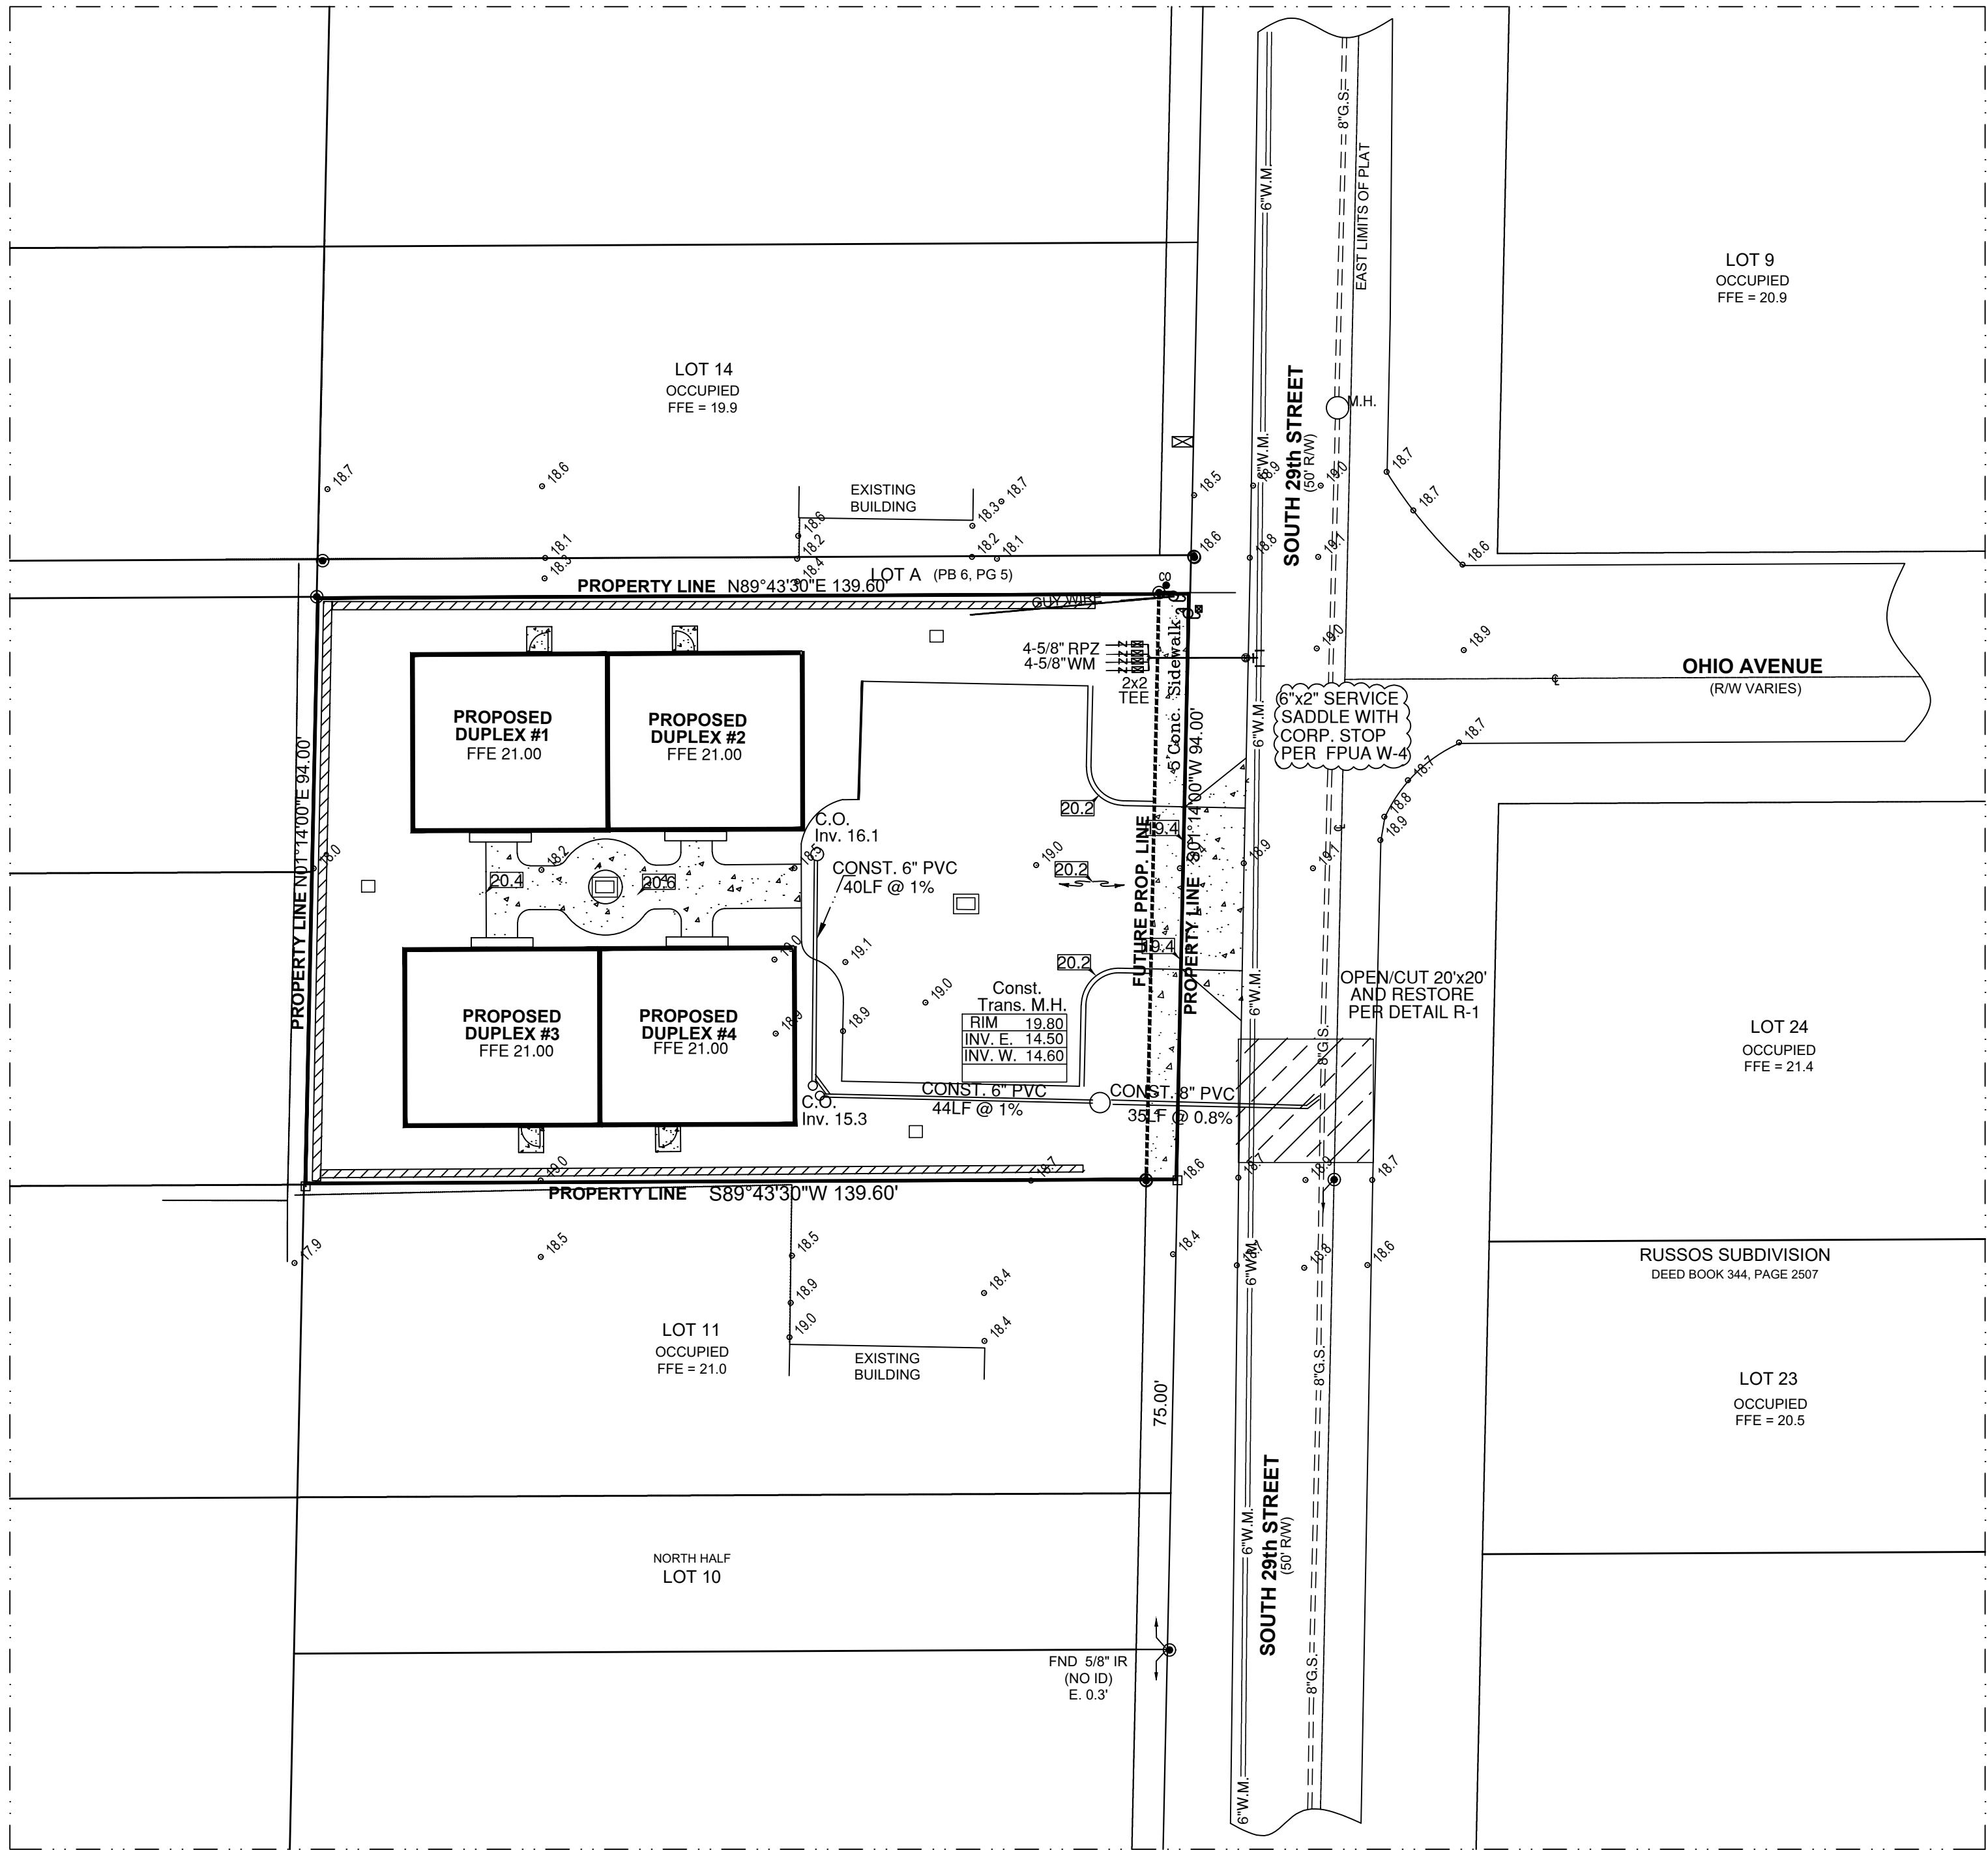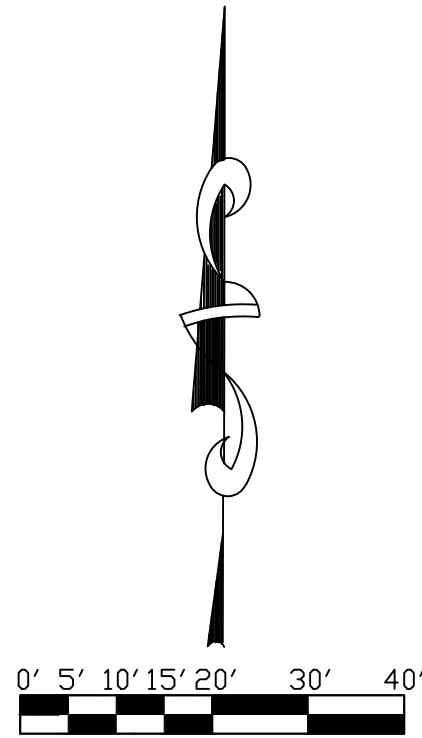


NOTE :


- All existing water, sewer lines and force mains must be field verified prior to the commencement of any construction activity.
- Any discrepancy that is discovered during the construction phase shall be reported and resolved prior to the installation of affected line.
- Tie-in connection points for water and sewer are based on as-built information that is provided by a third party and may not completely reflect the actual location and depth of the lines. It is the responsibility of the Contractor/Owner to verify and notify the engineer of record of item that must be resolved prior to installation.
- All shop drawings must be reviewed by the utility agency and the engineer of record.
- Must contact the engineer of record to schedule a pre-construction meeting prior to the start of any construction activity.

LEGEND

	EXISTING GRADE ELEVATION
	HIGH POINT
	RUNOFF FLOW DIRECTION
	FDOT MITERED END SECTION
	PIPE INVERT
	CORRUGATED POLYETHYLENE PIPE (N12) MANUF. BY ADS
	CORRUGATED POLYETHYLENE PIPE PERFORATED (N12) MANUF. BY ADS

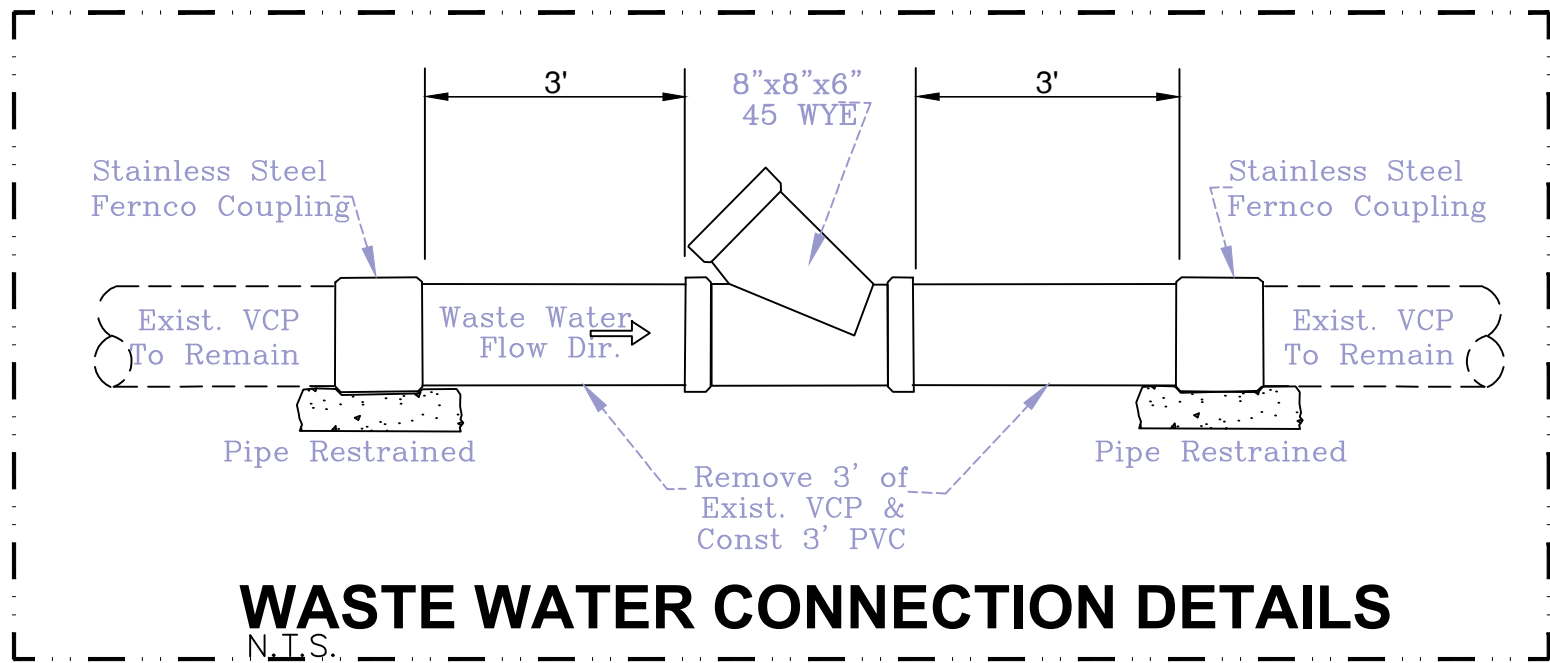

This item has been digitally signed
& sealed by **Abraham Chabab, PE**

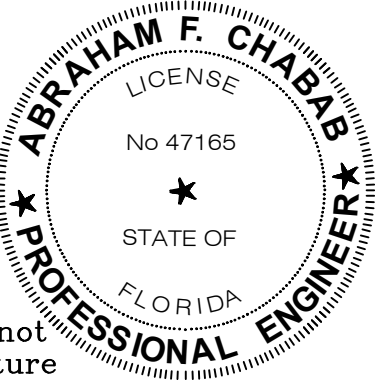

Printed copies of this document are not
considered signed & sealed & the signature
must be verified on any electronic copies

48 HOURS BEFORE DIGGING
CALL TOLL-FREE
1-800-432-4770
SUNSHINE STATE ONE CALL
OF FLORIDA, INC
UNDERGROUND UTILITIES NOTIFICATION CENTER

 ABRAHAM CHABAB, Inc. FL. BOARD OF PROF. ENG. AUTH.#26790		29th STREET DUPLEX	DESIGNED BY AC	<table><tr><th>REVISIONS</th><th>DATE</th></tr><tr><td> </td><td> </td></tr><tr><td> </td><td> </td></tr><tr><td> </td><td> </td></tr><tr><td> </td><td> </td></tr><tr><td> </td><td> </td></tr></table>	REVISIONS	DATE										
			REVISIONS	DATE												
5019 NW Rugby Drive PORT ST. LUCIE FL. 34983 Email agchabab1@msn.com Ph: 772-475-6630	WATER & SEWER PLAN	DATE Jun 12, 2026														
		SHEET 4 OF 4														