

SHOP EQUIPMENT SCHEDULE

XXX

ITEM	QTY	MANUFACTURER	MODEL #	ELECTRICAL REQUIREMENTS						PLUMBING REQUIREMENTS				LISTING/FIRE LABELING	
				TYPE	VOLTAGE	PH	AMPS	KW	HP	REMARKS	AIR	WATER	CONN.		DRAIN
001	2	WORKBENCH W/ GRINDER	MOHAWK	---	OUTLET	120	1	4.6							
002	1	TIRE CHANGER	COATS	7065AX								1/2"			
003	1	WHEEL BALANCER	COATS	12503DV	J.B.	220	1								
004	9	ABOVE GROUND LIFT	CHALLENGER	CL10	J.B.	208/230	1								
005	1	BRAKE LATHE	HUNTER	BL500	J.B.	208/230	1								
006	1	ALIGNMENT SYSTEM	HUNTER	WA141	OUTLET	120	1	2.6							
007	1	4 POST ALIGNMENT RACK	HUNTER	L441-PS	J.B.	115	1								
008	1	AIR COMPRESSOR	NAPA	---	J.B.	208/230	3					1"			
009	1	AIR DRYER (COMPRESSED AIR)	SERVICE CENTRAL	---	J.B.	120	1	9							
010	1	NEW BULK OIL TANK	LUBE CUBE	---								1/2"		UL 142, NFPA 30 STANDARD	
011	1	WASTE OIL TANK	LUBE CUBE	---								1/2"		UL 142, NFPA 30 STANDARD	
012	1	PARTS WASHER	SAFETY KLEEN	---	OUTLET	208	3	27							
013	1	TAILPIPE EXHAUST SYSTEM	HARVEY	HD-2-EK-3-WM-15	J.B.	120								WALL MTD., WALL DISCHARGE TUBE & HOSE HANGER	

NOTE:

OWNER WILL PROVIDE AND SET ALL SHOP EQUIPMENT. CONTRACTOR WILL CONNECT ALL SHOP EQUIPMENT TO POWER, AIR, WATER, AND DRAIN.

SPEC. SECTION	MINIMUM INSULATION VALUES AT CONDITIONED SPACE	
A6.2 / 07210	MASS WALLS	R-1 CONTINUOUS + FURRING
A6.2 / 07210	FRAMED WALLS	R-19 CONTINUOUS
A6.2 / 07210	ROOF	R-38 (ATTIC CONTINUOUS)
A6.2 / 08800	STOREFRONT GLASS	SHGC = 0.23


NOTE: NO SKYLIGHTS AT CONDITIONED SPACE

WALL TYPES


- 8" CMU EXTERIOR WALL INCLUDING INSULATED WALL FURRING @ 24" O.C. WHERE SHOWN
- 2x6 WOOD FRAMED PARTITION FULL HEIGHT TO ROOF DECK
- 2x4 WOOD FRAMED INTERIOR WALL 2x6 WHERE SHOWN

KEY NOTES

1. EXTERIOR UNDERGROUND SAND OIL INTERCEPTOR
2. ELEC. PANEL, CLOCKS + TELCO.
3. ELECTRICAL SERVICE ENTRANCE SECTION
4. FIRE RISER LOCATION, GYP. BD. CLG. @ 9'-0" AFF.
5. ROOF DRAIN / OVERFLOW DRAIN - LEADER IN CMU CELL BELOW 9'-0" AFF.
6. ROOF ACCESS LADDER
7. SHOP AIR COMPRESSORS / TANKS
8. HAND WASH
9. 48" HIGH FRP. THIS WALL FULL LENGTH
10. FLOOR DRAIN, SLOPE CONC. TO @ 1/8"/FT. TYP.
11. SHOP EXHAUST SYSTEM
12. EYE WASH
13. MILLWORK PROVIDED AND INSTALLED BY CONTRACTOR
14. NOT USED
15. DRINKING FOUNTAIN - SEE PLAN FOR SPOUT HEIGHT
16. 1/4-INCH INSULATED TEMPERED WINDOW WITH CLEAR WIRELITE GLASS IN PRE. FIN. MTL. FRAME, SIZE PER PLAN
17. GREEN SCREEN
18. 48" X 96" X 3/4" THK. PAINTED FLYWD. TELEPHONE MTG. BD.
19. WALL MOUNTED 10A2BC PORTABLE FIRE EXTINGUISHER
20. RECESSED IN WALL 'KNOX' KEY BOX
21. MOP SINK
22. RECESSED IN WALL, INSPECTOR'S TEST VALVE FIRE DEPARTMENT ACCESS PANEL
23. 18" DEEP PAINTED/EDGED 3/4" PLYWOOD SHELVES FOR 100# FT. LOAD (4)
24. STEEL AWNING ABOVE
25. SMALL REFRIGERATOR W/ MICROWAVE ABOVE, PROVIDED BY OWNER
26. WATER HEATER ABOVE CEILING
27. WALL MTD. TACTILE EXIT SIGNS 4 18" X 18" CLEAR FLOOR SPACE (PER SECTION 103 OF THE 2003 ICC/ANSI A-117.1). SIGN - BLACK PLASTIC BASE, 2" H WHITE RAISED LETTERS AND RAISED BRAILLE 'EXIT'
28. 1/4-INCH PLATE WINDOW WITH CLEAR TEMPERED GLASS IN PRE. FIN. MTL. FRAME, SIZE PER PLAN
29. PROVIDE 'FAMILY ASSISTED-USE' SIGNAGE COMPLYING WITH EXAMPLE BELOW

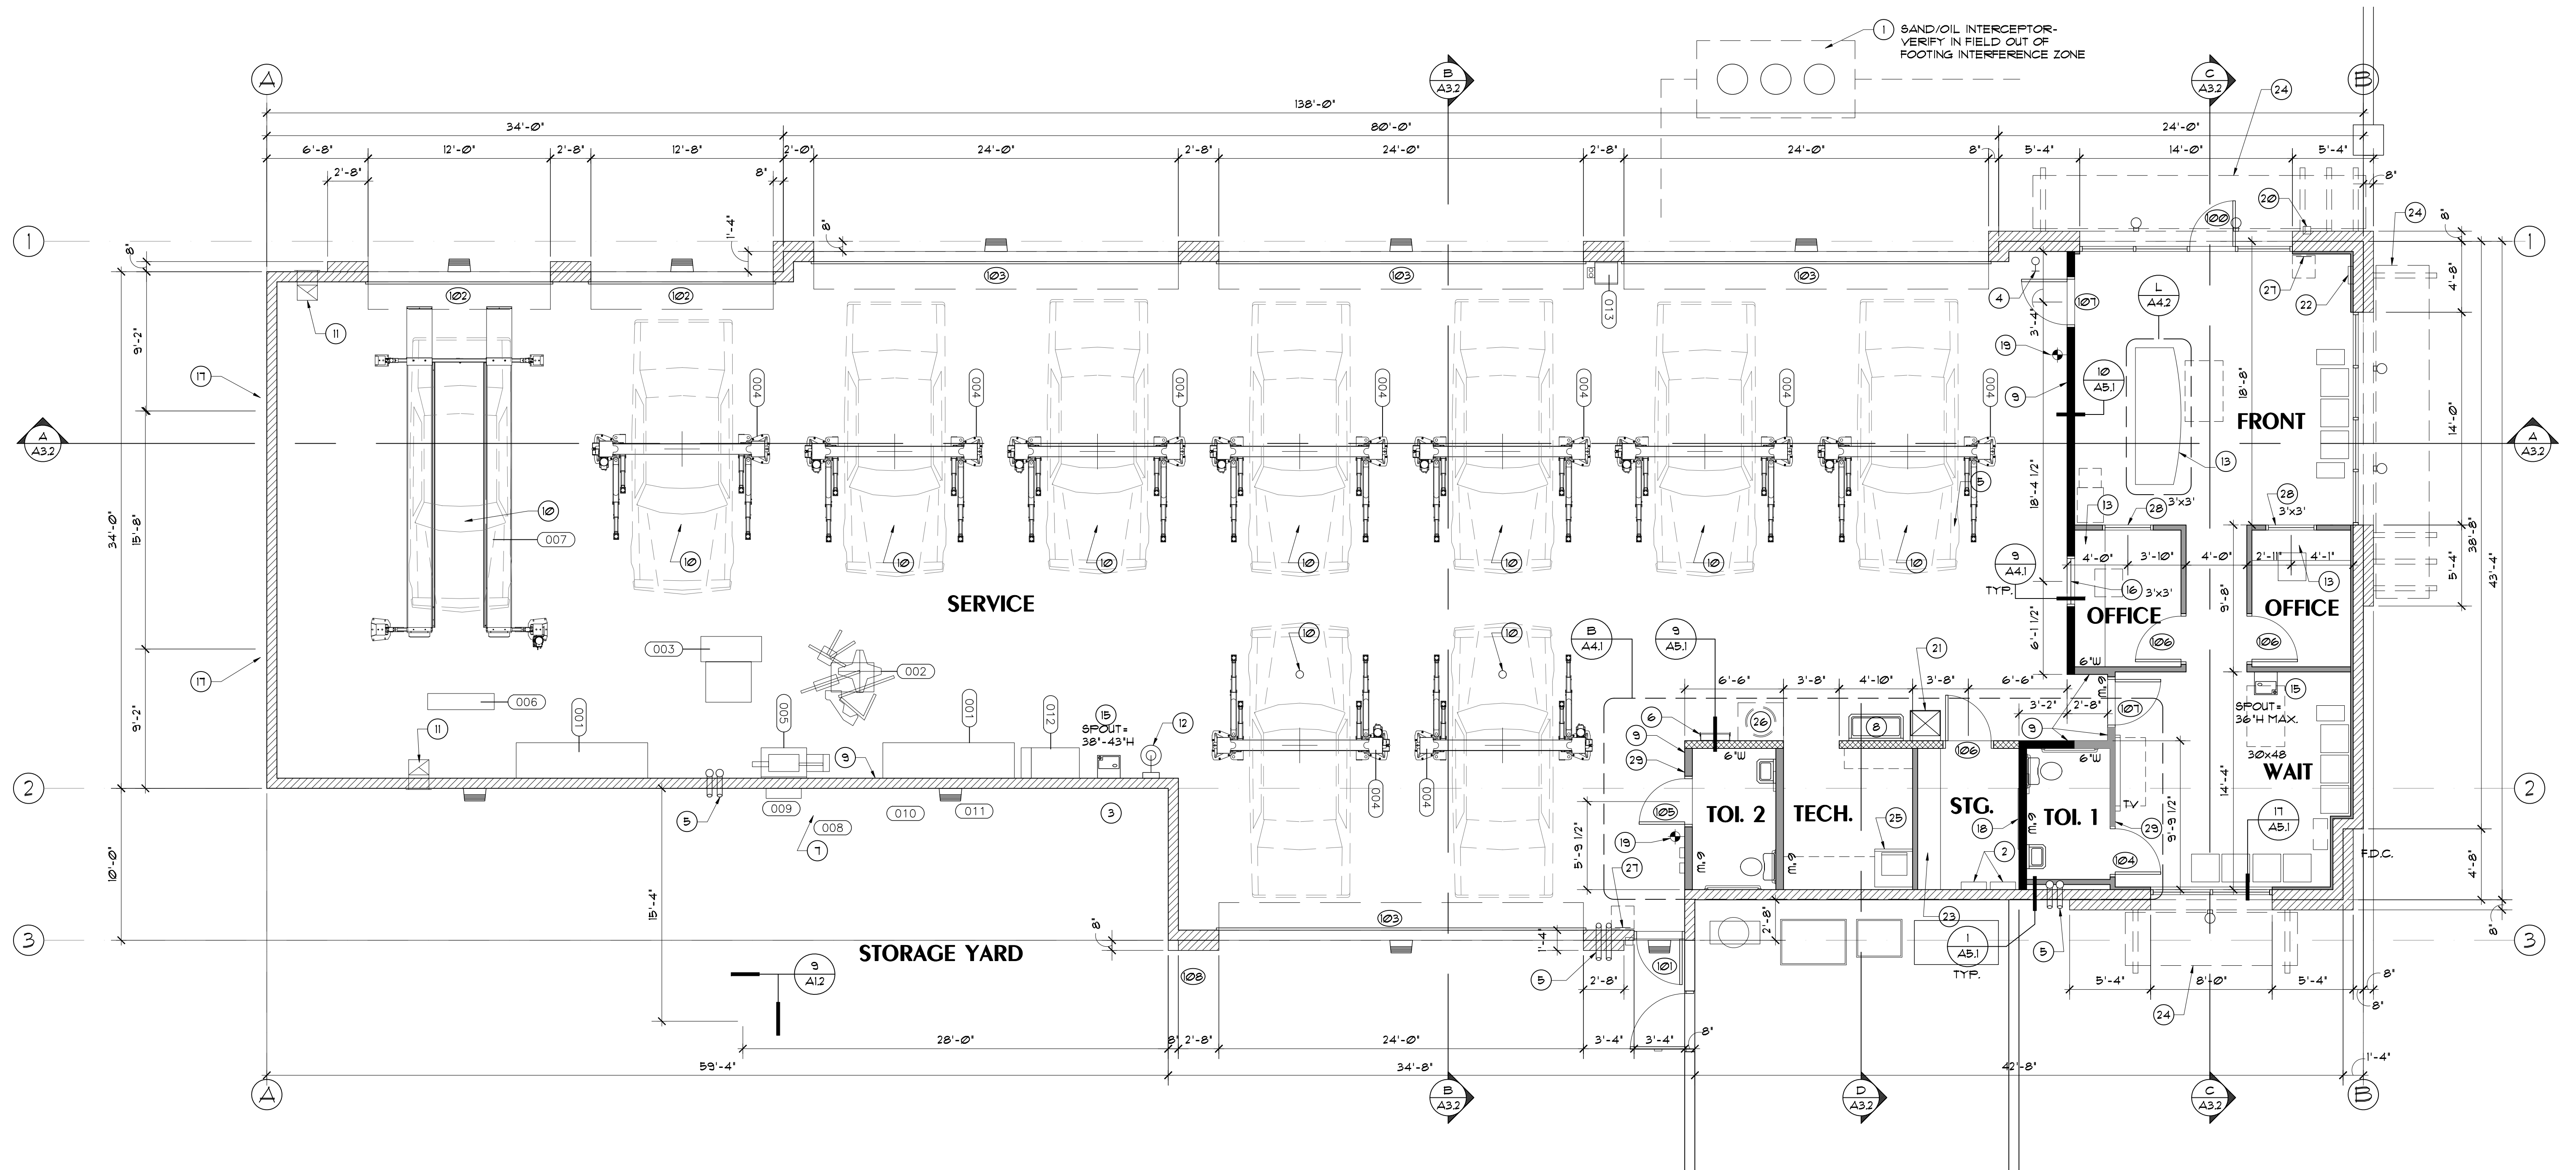

FLOOR PLAN

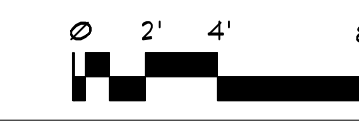

SCALE: 3/16" = 1'-0"

GREULICH'S IN GLENDALE
 51ST AVENUE AND BELL ROAD
 GLENDALE, ARIZONA

phoenix design group

JOB NO.: PDG-1847
 DATE: 11/25/2013
 REVISION:

DRAWN BY:
 CHECKED BY:
 SHEET NO.

A2.1