


PRELIMINARY NOT FOR CONSTRUCTION 12-22-08

ALL CONSTRUCTION MATERIALS, CONSTRUCTION SYSTEMS AND/OR COMPONENTS SHALL BE INSTALLED AS PER MANUFACTURER'S RECOMMENDATIONS OR REQUIREMENTS

A MASTER SITE PLAN
SCALE: N.T.S.
MIND TO SCALE PLAN

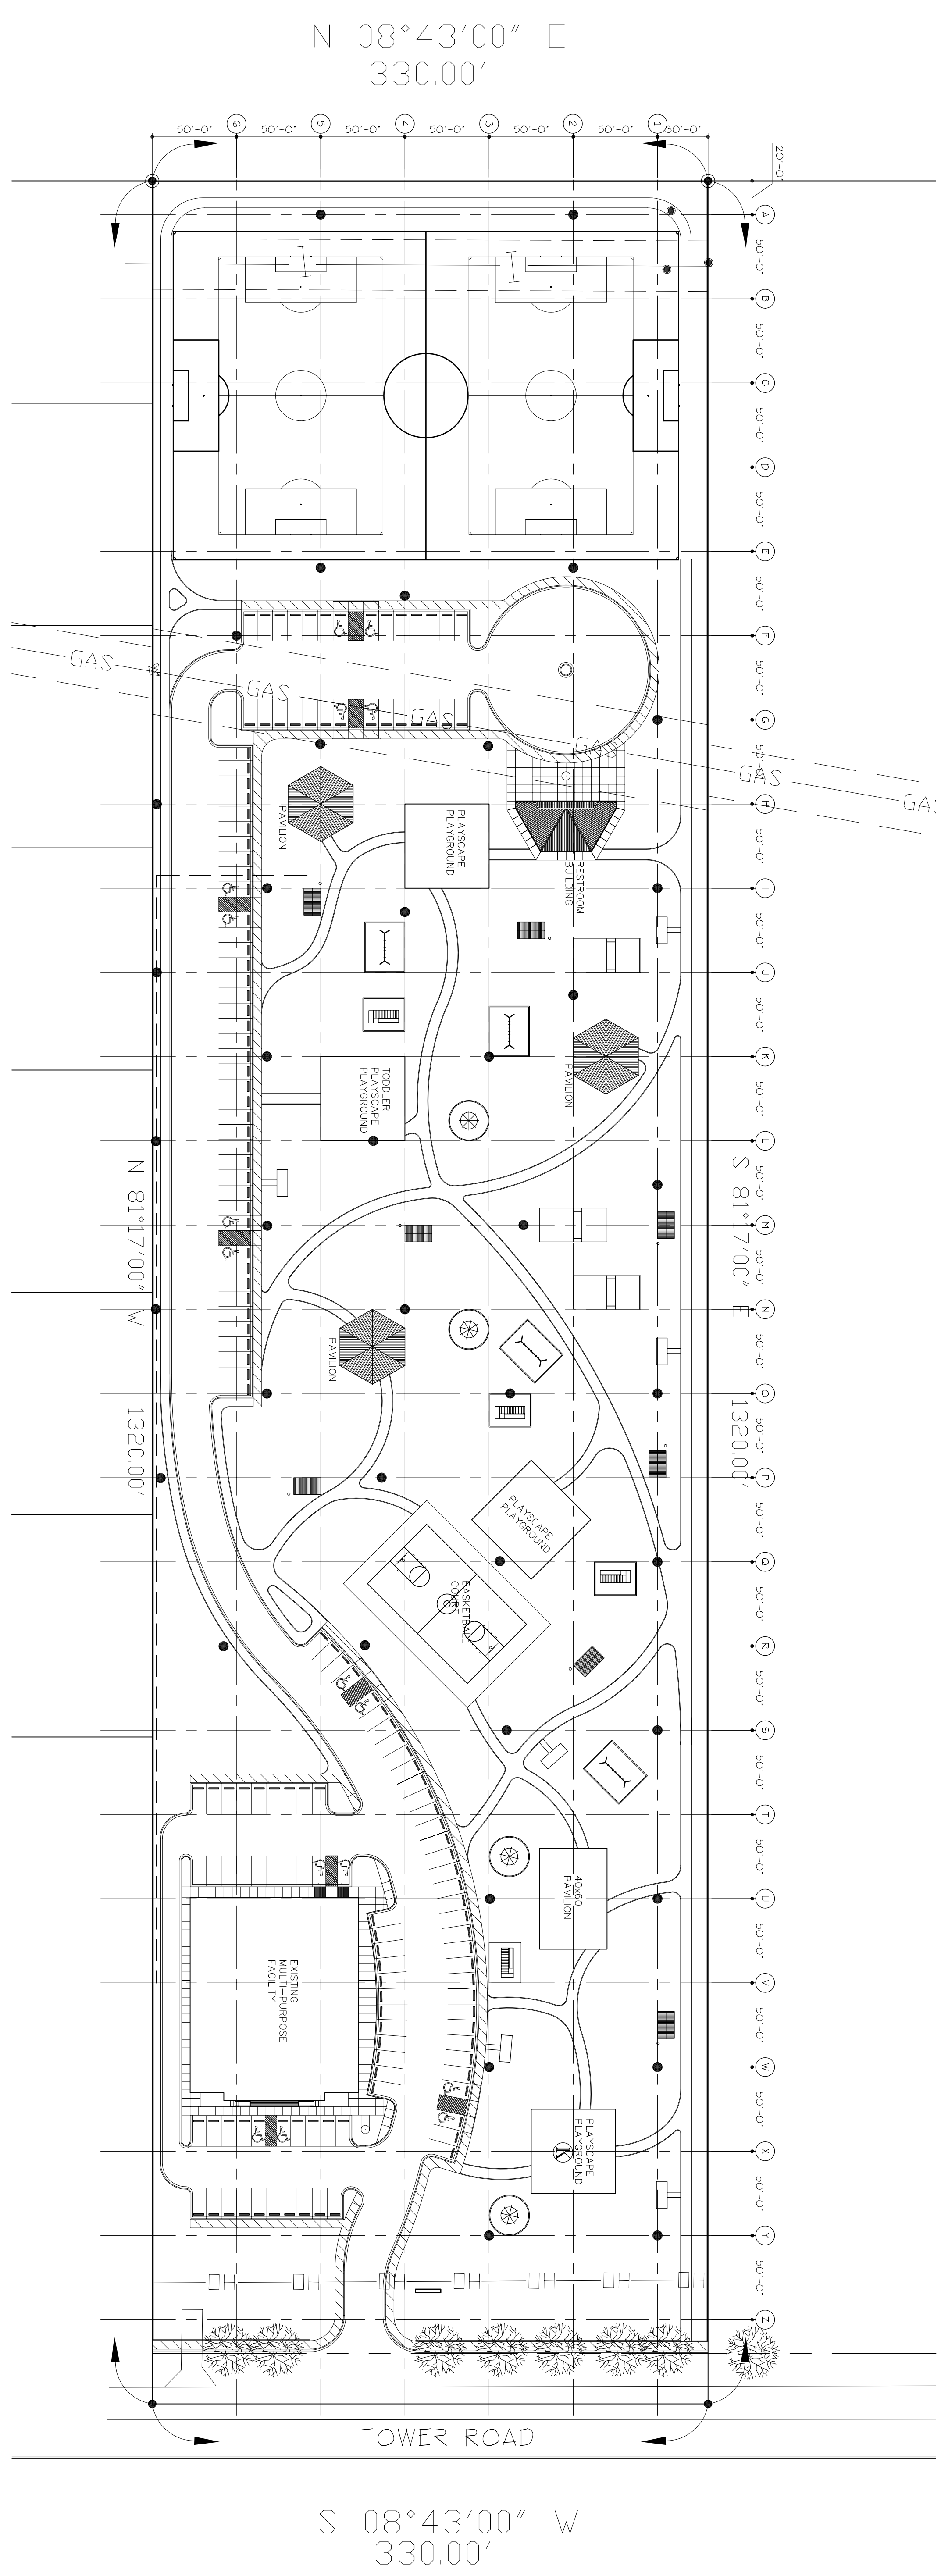

● - SOLAR POWERED LIGHTS AND SOCCER FIELD LIGHTS

© All rights reserved.
Date: 10-29-08

SHEET
OF

V·A Architecture
Vargas & Associates 2029 Industrial Drive McAllen, Texas 78504 (956) 631-2242

SOUTH TOWER CRC/PARK
PENDING CONSTRUCTION ITEMS
FOR
HIDALGO COUNTY
COMMISSIONER HECTOR "TITO" PALACIOS

These drawings and specifications are and shall remain the property of V·A Architecture. They may not be reused, reproduced or altered in any way, shape or form without prior written approval and with appropriate compensation to
V·A Architecture

JOB NO. 07-1004A
DATE 10-29-08
REVISIONS
DRAWN BY