

HIDALGO COUNTY  
URBAN COUNTY PROGRAM

RECEIVED  
MAY 12 2016  
HIDALGO COUNTY  
URBAN COUNTY PROGRAM

UCP CONTRACT CHANGE ORDER REQUEST

<p>CITY/PCT: Hidalgo County Precinct No. 1 1902 Joe Stephens Ave. Ste. 101 Weslaco, TX 78599</p> <p>Phone #: (956) 968-8733</p>	<p>DATE: May 11, 2016</p> <p>CHANGE ORDER NO. 1</p>
<p>CONTRACTOR/FIRM Texas Cordia Construction, LLC 3149-A Center Pointe Drive Edinburg, TX 78539</p> <p>Phone #: (956) 627-6181</p>	<p>PROJECT/NAME/ACCT. NO.  Hidalgo County Precinct No. 1 Street Improvements to: Old L a Blanca Road (Mile 10-12) Phase 2</p> <p>5013/14/15-91-0311-5000-9100- UCP-ML</p>
<p>You are hereby requested to comply with the following changes from the contract plans and specifications: This change order is due to additional culverts due to existing culverts not being reinforced, replacement of a leaking irrigation line under the roadway, and the alignment of the proposed roadway connecting to Mile 12 directly in lieu of a curve. The total additional time needed to complete the project is <u>10</u> days and will be added to the contract time.</p>	

<input type="checkbox"/>
<input type="checkbox"/>
<input checked="" type="checkbox"/>

Final Quantitative Adjustments  
Unit Prices  
Quantitative Addition

<input checked="" type="checkbox"/>
<input checked="" type="checkbox"/>
<input type="checkbox"/>

Quantitative Deletion  
Time Extension  
Other

REASON:

This change order is for three different items:

1. The existing culvert and grate inlet across Old La Blanca Rd. and Sioux Rd. do not have reinforcement and are damaged and not salvageable. The change order proposes to replace both items.
2. At Sta. 92+00 there is a 21-inch leaking irrigation line under the roadway that needs to be replaced.
3. The alignment of the proposed roadway connecting to Mile 12 will be revised to connect to the intersection directly in lieu of a curve. The curve is located outside the existing County ROW, and therefore, this area was revised.

The total additional time needed to complete the project is 10 days and will be added to the contract time.

Contract price prior to change order .....	\$ 986,188.50
Net Increase/Decrease of this Change Order .....	\$ 29,184.31
Contract Price with Change Order .....	\$ 1,015,372.81

Increase/Decrease in time 10 days

**HIDALGO COUNTY  
URBAN COUNTY PROGRAM  
UCP CONTRACT CHANGE ORDER REQUEST**

*[Signature]* 5-12-16  
PROJECT ENGINEER - ARCHITECT      DATE

Emigdio Salinas, P.E.  
PRINT NAME

*[Signature]*  
CONTRACTOR      DATE

Yara M. Corbitt, P.E.  
PRINT NAME


(FOR URBAN COUNTY PROGRAM USE ONLY)

<input type="checkbox"/>	Scope Increase	<input checked="" type="checkbox"/>	Quantitative Addition/Deletion
<input type="checkbox"/>	Scope Decrease	<input type="checkbox"/>	Final Quantitative Adjustment
<input type="checkbox"/>	L/M Beneficiary Change/Impact	<input checked="" type="checkbox"/>	Other <u>10mi Extension</u> 10 days New Expiration date: 11/19/16
<input type="checkbox"/>	Environmental Impact		
<input checked="" type="checkbox"/>	Approved	<input type="checkbox"/>	Disapproved

Title: Director

Signature: *[Signature]*  
Diana R. Serna

Date: 5-17-16

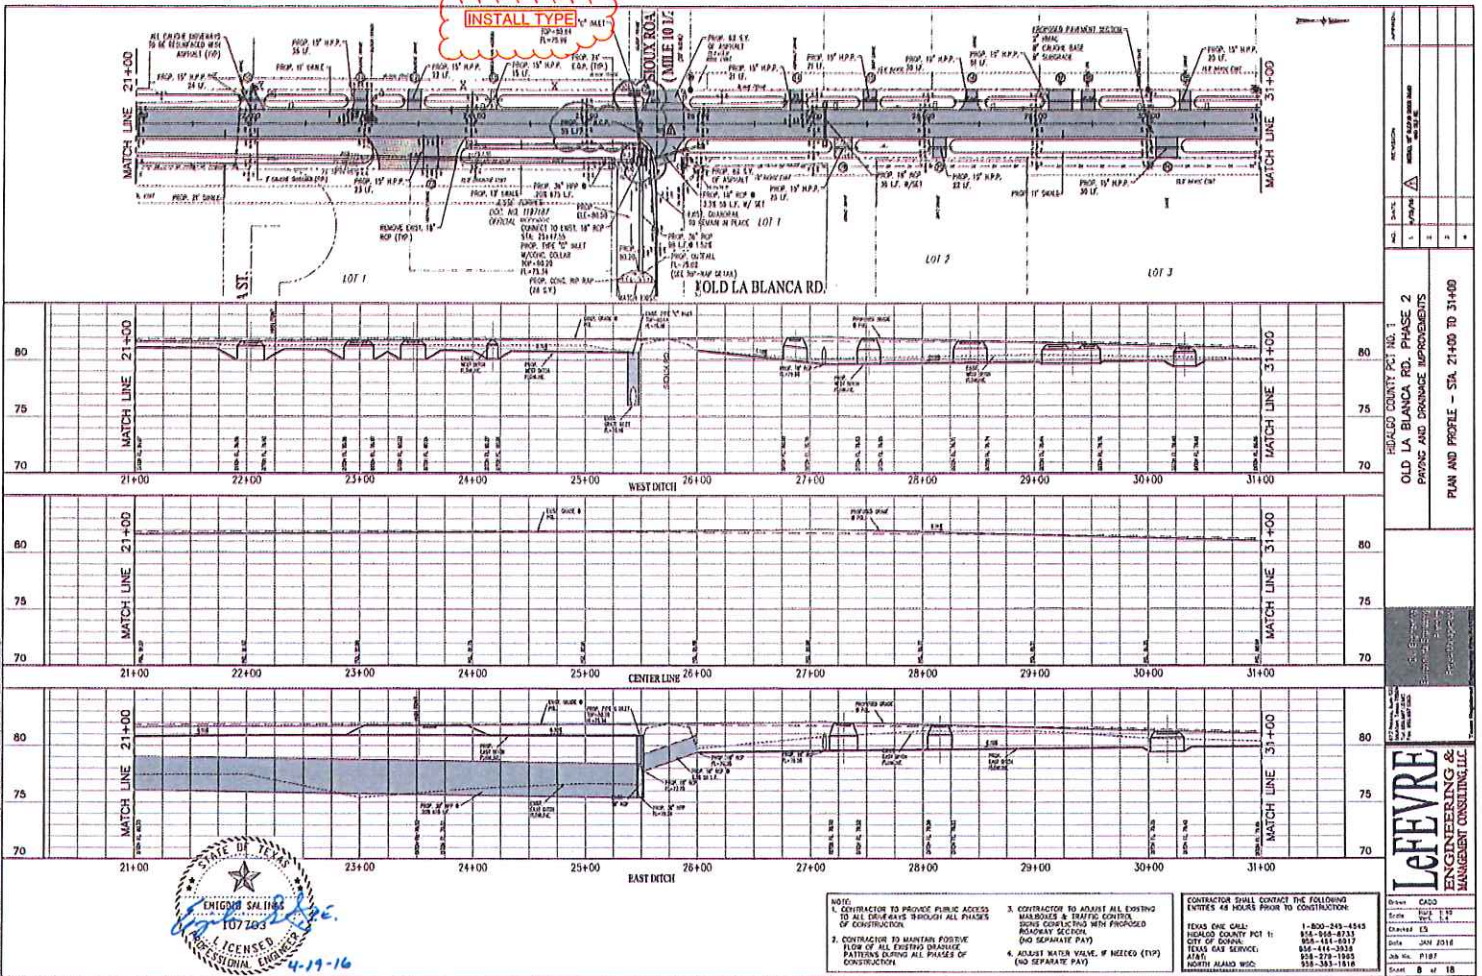

- NOTE:
- CONTRACTOR TO PROVIDE PUBLIC ACCESS TO ALL DRIVEWAYS THROUGH ALL PHASES OF CONSTRUCTION.
  - CONTRACTOR TO MAINTAIN POSITIVE FLOW OF ALL EXISTING DRAINAGE PATTERNS DURING ALL PHASES OF CONSTRUCTION.
  - CONTRACTOR TO ADJUST ALL EXISTING MAILBOXES & TRAFFIC CONTROL SIGNS CORRECTING WHEN PROPOSED ROADWAY SECTION (NO SEPARATE PAY).
  - ADJUST WATER VALVE, IF NEEDED (TYP) (NO SEPARATE PAY)


CONTRACTOR SHALL CONTACT THE FOLLOWING ENTITIES 48 HOURS PRIOR TO CONSTRUCTION:

TEXAS ONE CALL: 1-800-243-4545  
 HENKOLD COUNTY PCL 1: 856-566-8233  
 CITY OF GORDON: 856-444-8317  
 TEXAS GAS SERVICE: 856-444-3838  
 AT&T: 856-278-1885  
 NORTHERN ALABAMA WWD: 856-383-1818

**LEFEVRE**  
 ENGINEERING &  
 MANAGEMENT CONSULTING, LLC

Drawn	CAD
Checked	PC
Designed	PC
Contract	15
Job No.	2318
Job No.	2187
Scale	8 of 18

HENKOLD COUNTY PCL PHASE 1  
 OLD LA BLANCA RD. PHASE 2  
 PAVING AND DRAINAGE IMPROVEMENTS  
 PLAN AND PROFILE - STA. 21+00 TO 31+00

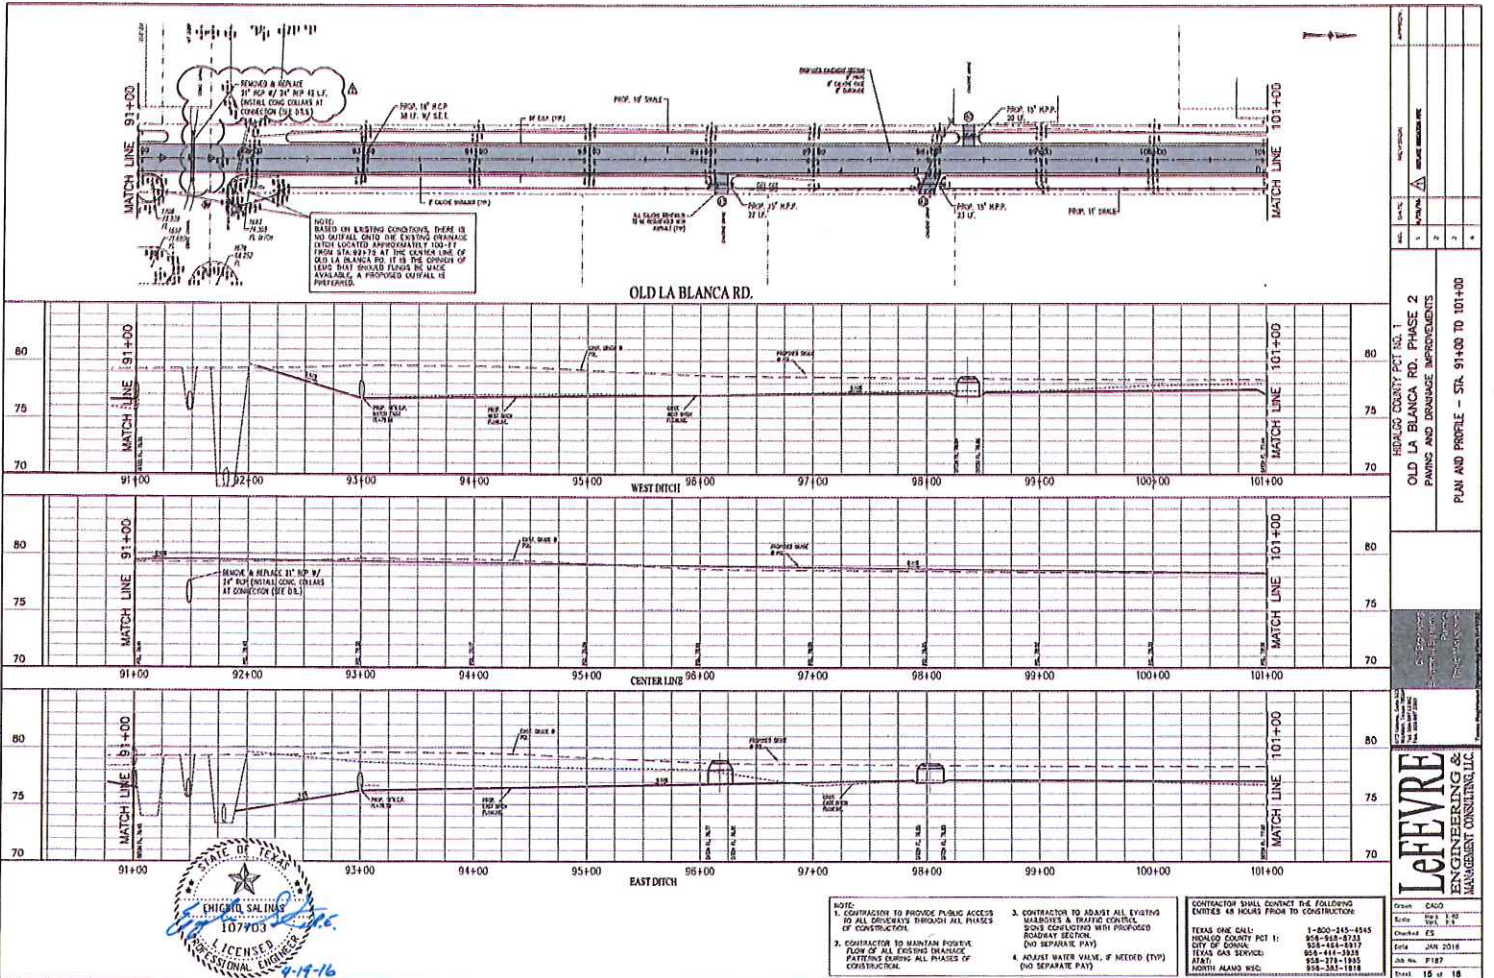


DATE	DESCRIPTION
1	ISSUED FOR PERMIT
2	ISSUED FOR CONSTRUCTION
3	ISSUED FOR AS-BUILT
4	ISSUED FOR RECORD

ROADWAY COUNTY PCT NO. 1  
 OLD LA BLANCA RD. PHASE 2  
 PAVING AND DRAINAGE IMPROVEMENTS  
 PLAN AND PROFILE - STA. 91+00 TO 101+00

**LeFevre**  
 ENGINEERING &  
 MANAGEMENT CONSULTANTS, L.L.C.

Drawn: CAG  
 Scale: 1" = 40'  
 Checked: CS  
 Date: JUN 2016  
 Texas One Call: 1-800-445-3545  
 ROADWAY COUNTY PCT 1: 858-948-8743  
 CITY OF GUNDS: 858-468-8817  
 TEXAS GAS SERVICE: 858-411-3935  
 AT&T: 858-378-1845  
 NORTH ALABAMA REC: 858-383-1818  
 Job No. P187  
 Sheet 15 of 18

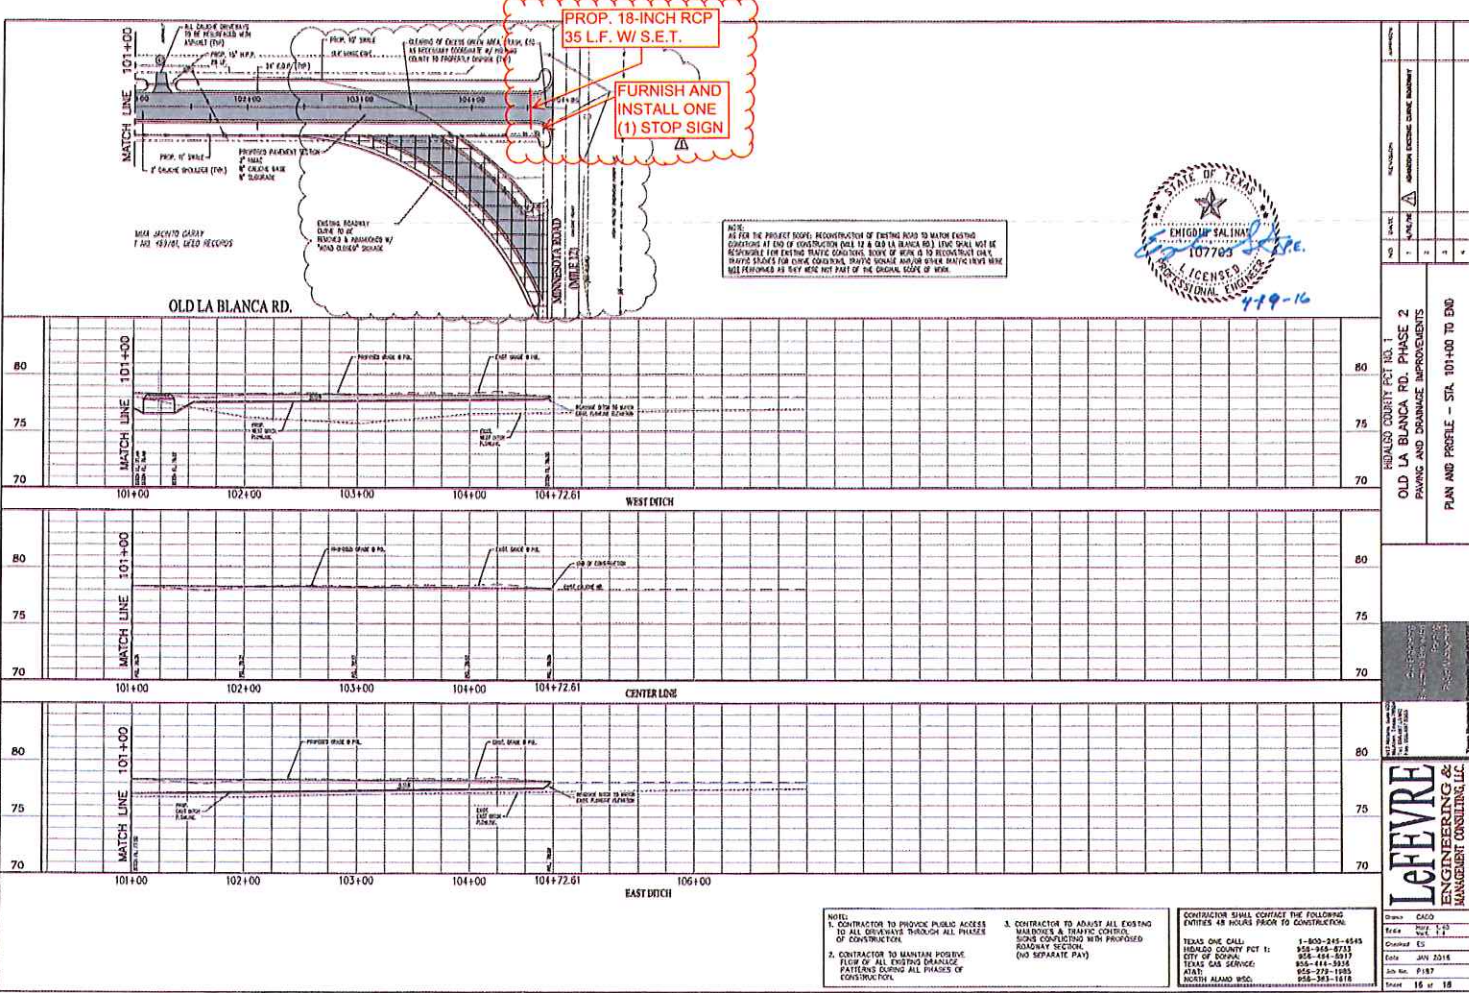

PROP. 18-INCH RCP  
35 L.F. W/ S.E.T.

FURNISH AND  
INSTALL ONE  
(1) STOP SIGN



NOTE:  
AS FOR THE PROJECT SCOPE, RECONSTRUCTION OF EXISTING ROAD TO MATCH EXISTING  
CONDITION AT END OF CONSTRUCTION DATE IS OLD LA BLANCA RD. LINE SHALL NOT BE  
RESPONSIBLE FOR EXISTING TRAFFIC CONDITIONS, SLOPE OF WORK IS TO RECONSTRUCT ONLY.  
TRAFFIC SIGNALS FOR CURVE CORNERING, DRIVE SIGNALS AND/OR OTHER TRAFFIC LIGHTS WERE  
NOT PERFORMED AS THEY WERE NOT PART OF THE ORIGINAL SCOPE OF WORK.

REVISION	DATE	BY	DESCRIPTION
1	4-19-16	EMIGDIO SALINAS	ISSUE FOR BIDDING
2			
3			
4			

HENDON COUNTY PCT. NO. 1  
OLD LA BLANCA RD. PHASE 2  
PAVING AND DRAINAGE IMPROVEMENTS  
PLAN AND PROFILE - STA. 101+00 TO END


**LEFEVRE**  
ENGINEERING &  
MANAGEMENT CONSULTING, LLC

Drawn: DACO  
Check: JAC 7-13  
Contract: 03  
Date: JULY 2016  
Job No.: P187  
Sheet: 16 of 18

- NOTE:
- CONTRACTOR TO PROVIDE PUBLIC ACCESS TO ALL DRIVEWAYS THROUGH ALL PHASES OF CONSTRUCTION.
  - CONTRACTOR TO MAINTAIN POSITIVE FLOW OF ALL EXISTING DRAINAGE PATTERNS DURING ALL PHASES OF CONSTRUCTION.
  - CONTRACTOR TO ADJUST ALL EXISTING MAINDRAINS & TRAFFIC CONTROL SIGNS CONFLICTING WITH PROPOSED ROADWAY SECTION (SEE SEPARATE PAY).

CONTRACTOR SHALL CONTACT THE FOLLOWING ENTITIES 48 HOURS PRIOR TO CONSTRUCTION:

TEXAS ONE CALL: 1-800-245-4545  
HENDON COUNTY PCT 1: 956-969-8755  
CITY OF DOWNA: 956-484-5015  
TEXAS GAS SERVICE: 800-444-3836  
AUST: 956-579-1995  
NORTH ALABAMA WPD: 956-363-1818

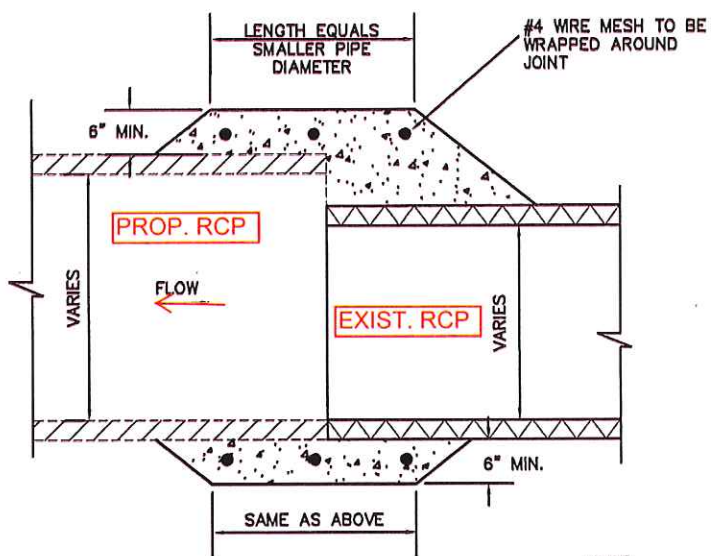

NOTE:

1. CONCRETE SHALL BE CLASS A

## TYPICAL PIPE COLLAR DETAIL

N.T.S.