



Exhibit A

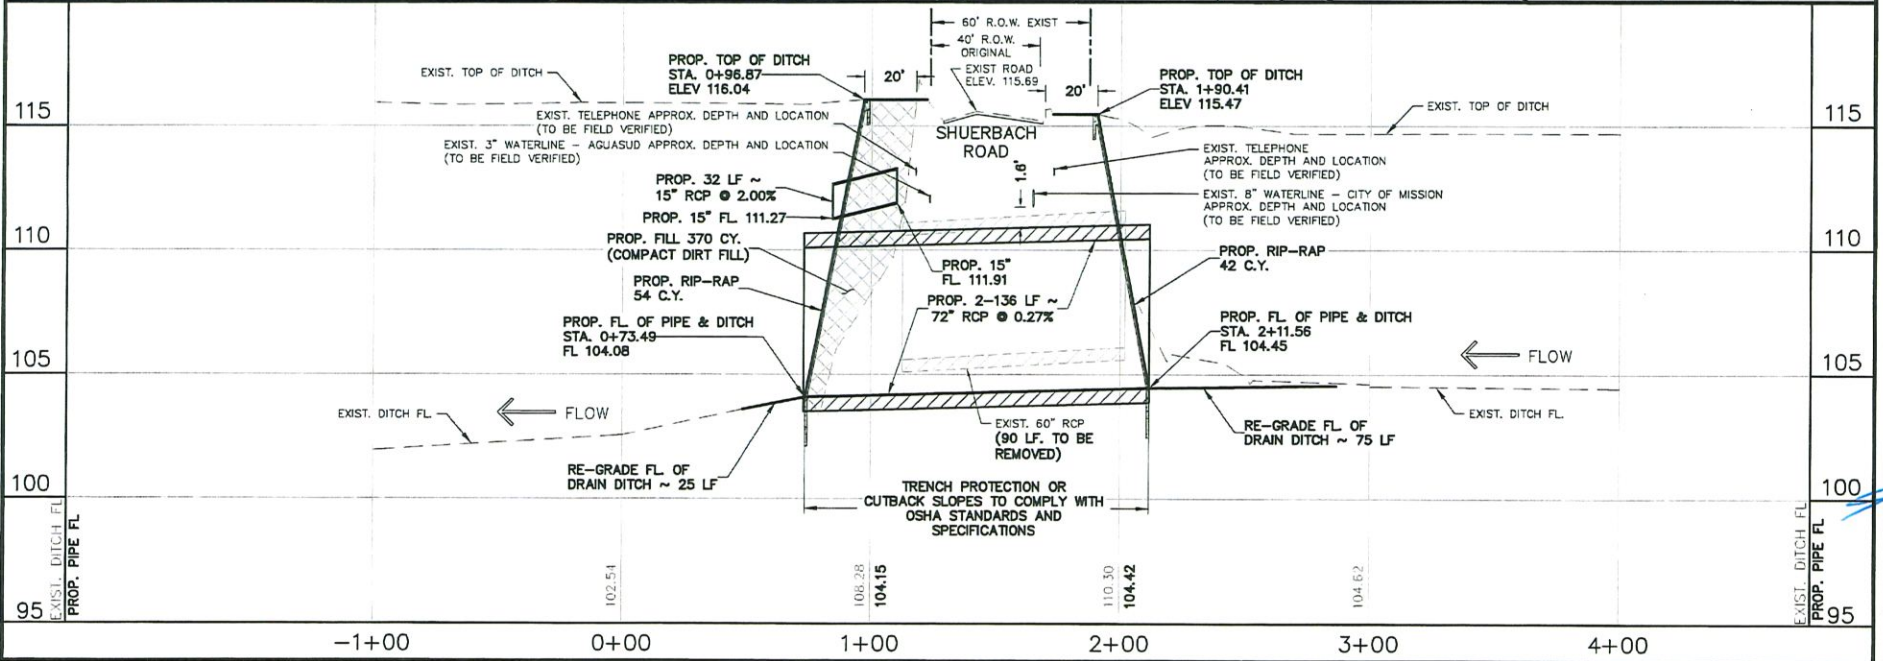

HIDALGO COUNTY DRAINAGE DISTRICT No. 1
 General Manager
 Floodplain Administrator
 Raul E. Sesin P.E., C.F.M.
 902 N. DOOLITTLE RD
 EDINBURG TX 78542
 TEL: (956) 292-7080
 www.hcd1.org

TERRA DORADA DRAIN IMPROVEMENTS - (SHUERBACH RD)
 PLAN AND PROFILE
 STA. 0+00 - STA. 3+00

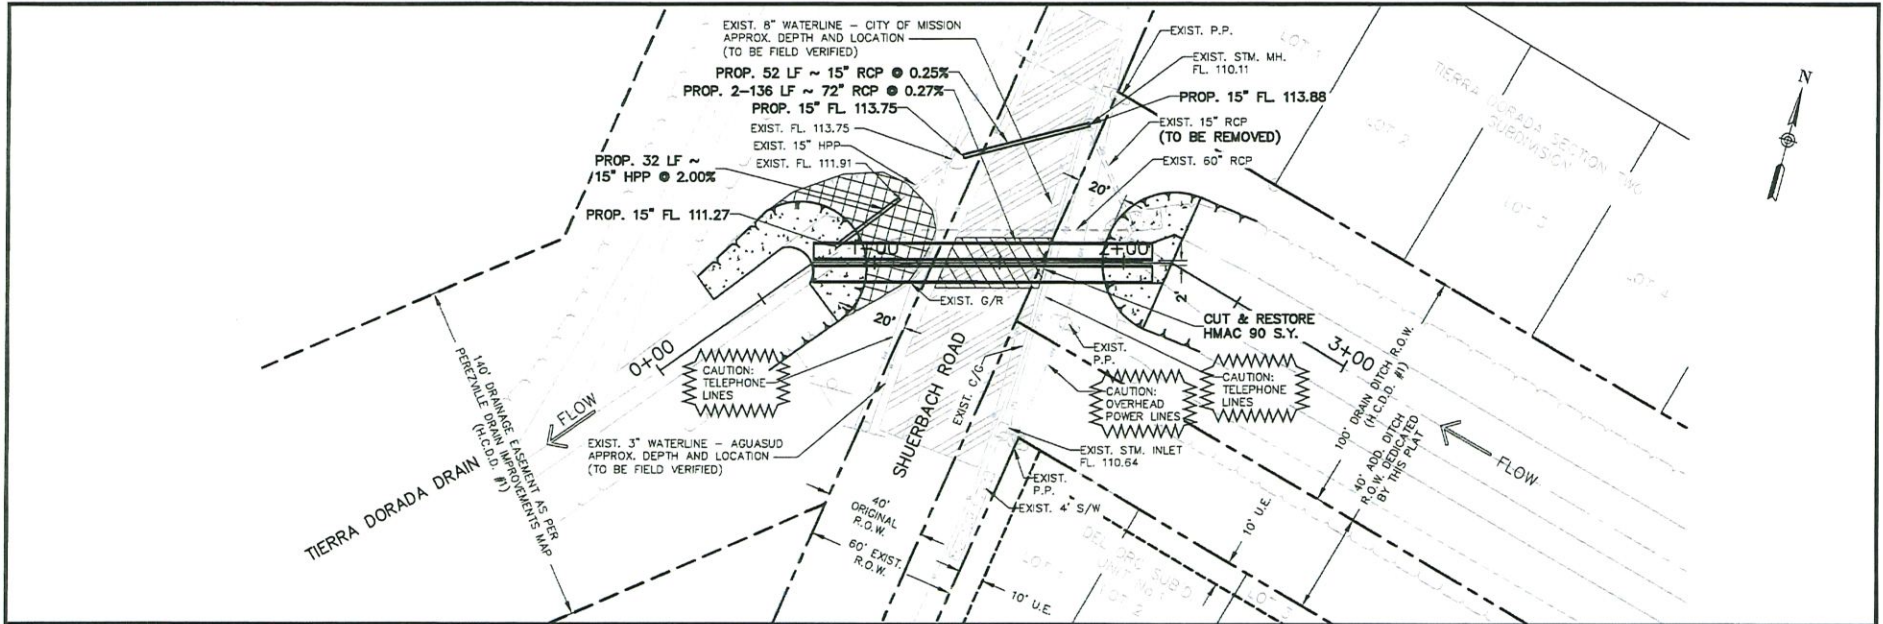

This seal appearing on this document was authorized by Jose N. Sedoy, P.E. No. 64075 on the above designated date.

PROJECT NO. E-21-024
 SCALE: H.1"=50' / V.1"=5'
 DRAWN BY: H.R.
 CHECKED BY: R.S./N.S.
 TYPED BY: C.T./A.R.
 SHEET: C01-01

