


Attachment 2: Site Plan

PLOTTED ON: 4/10/2024 12:02 PM BY: JOHNN MILLER ORIGINAL SHEET SIZE: ANSI B (24x36)

USDAL_D002850314_32026330_D15C_NORGE_CLEANERS/CA06393/MANIFOLD DETAIL.DWG

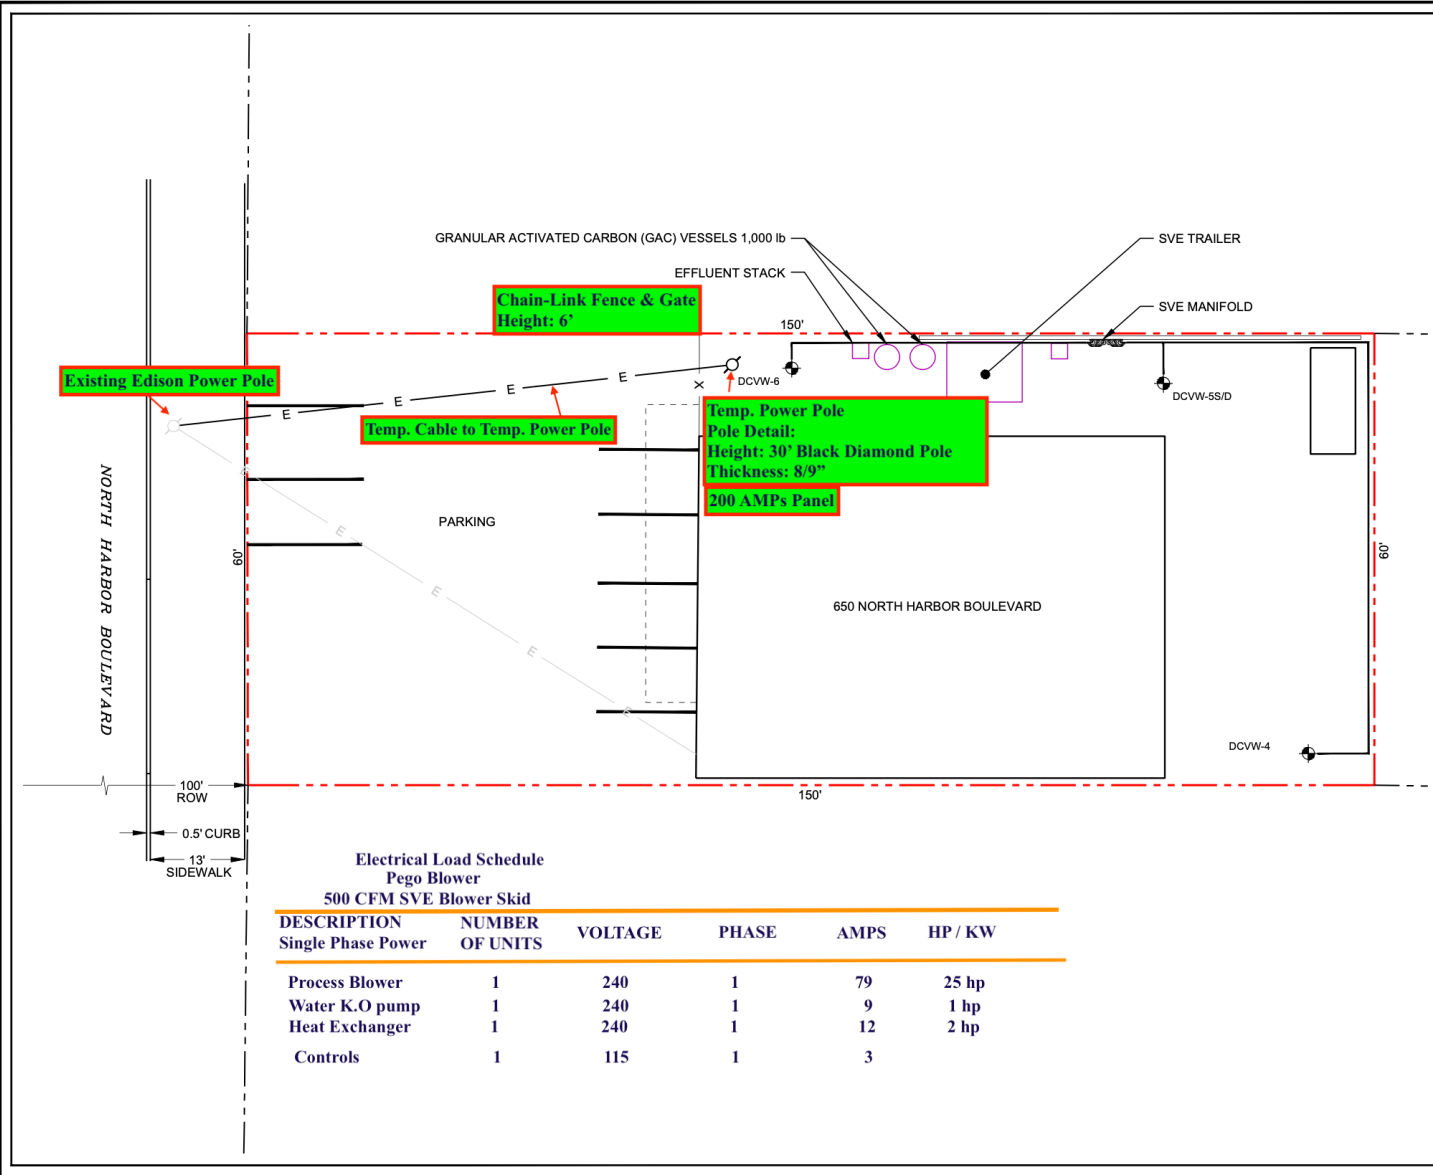


Electrical Load Schedule
Pego Blower
500 CFM SVE Blower Skid

DESCRIPTION	NUMBER OF UNITS	VOLTAGE	PHASE	AMPS	HP / KW
Process Blower	1	240	1	79	25 hp
Water K.O pump	1	240	1	9	1 hp
Heat Exchanger	1	240	1	12	2 hp
Controls	1	115	1	3	

LEGEND

- SITE BOUNDARY
- PARCEL BOUNDARY LINE
- EXISTING BUILDING
- AWNING
- PROPOSED SOIL VAPOR EXTRACTION (SVE) EQUIPMENT LOCATION
- SVE CONVEYANCE LINE (2" SCH 40 PVC)
- X SECURITY FENCE
- DCVW-4 SVE WELL
- E EXISTING OVERHEAD ELECTRIC LINE
- E EXISTING POWER POLE
- E PROPOSED TEMPORARY ELECTRIC LINE
- E PROPOSED TEMPORARY POWER POLE

 - NOTES**
- LEGAL DESCRIPTION - SEC 4 T 3 R 10 N 60 FT S 185 FT W 5 AC N1/2 NW1/4 SE1/4 -EX HWY & E 130 FT
 - APN 303-231-03, TRACT 231, LOT 3.
 - EXISTING BUILDING USED AS A DRY-CLEANER.
 - SECURITY FENCE TO HAVE MINIMUM 8-FEET HEIGHT, CHAIN-LINK CONSTRUCTION, AND PRIVACY SLATS.
 - SVE TRAILER DIMENSIONS ARE 8'L x 10'W x 10'H.
 - AFTER COMPLETION OF PROJECT, THE TEMPORARY POWER POLE AND ALL ASSOCIATED EQUIPMENT WILL BE REMOVED AND THE HOLE WILL BE BACKFILLED.
 - NO STOCKPILES WILL BE ALLOWED IN THE PUBLIC RIGHTS WAY AND ALL STOCKPILES INSIDE THE PRIVATE PROPERTY SHALL BE DISPOSED OF THAT SAME DAY.



SVE MANIFOLD AND COMPOUND LOCATION

650 North Harbor Boulevard
La Habra, California

GSI JOB NO.: 6339	DRAWN BY: JNM
ISSUED: 4/1/2024	CHKD BY: RDT
MAP ID: MANIFOLD	APPVD BY:

FIGURE 2