


BOHREREAST CSG

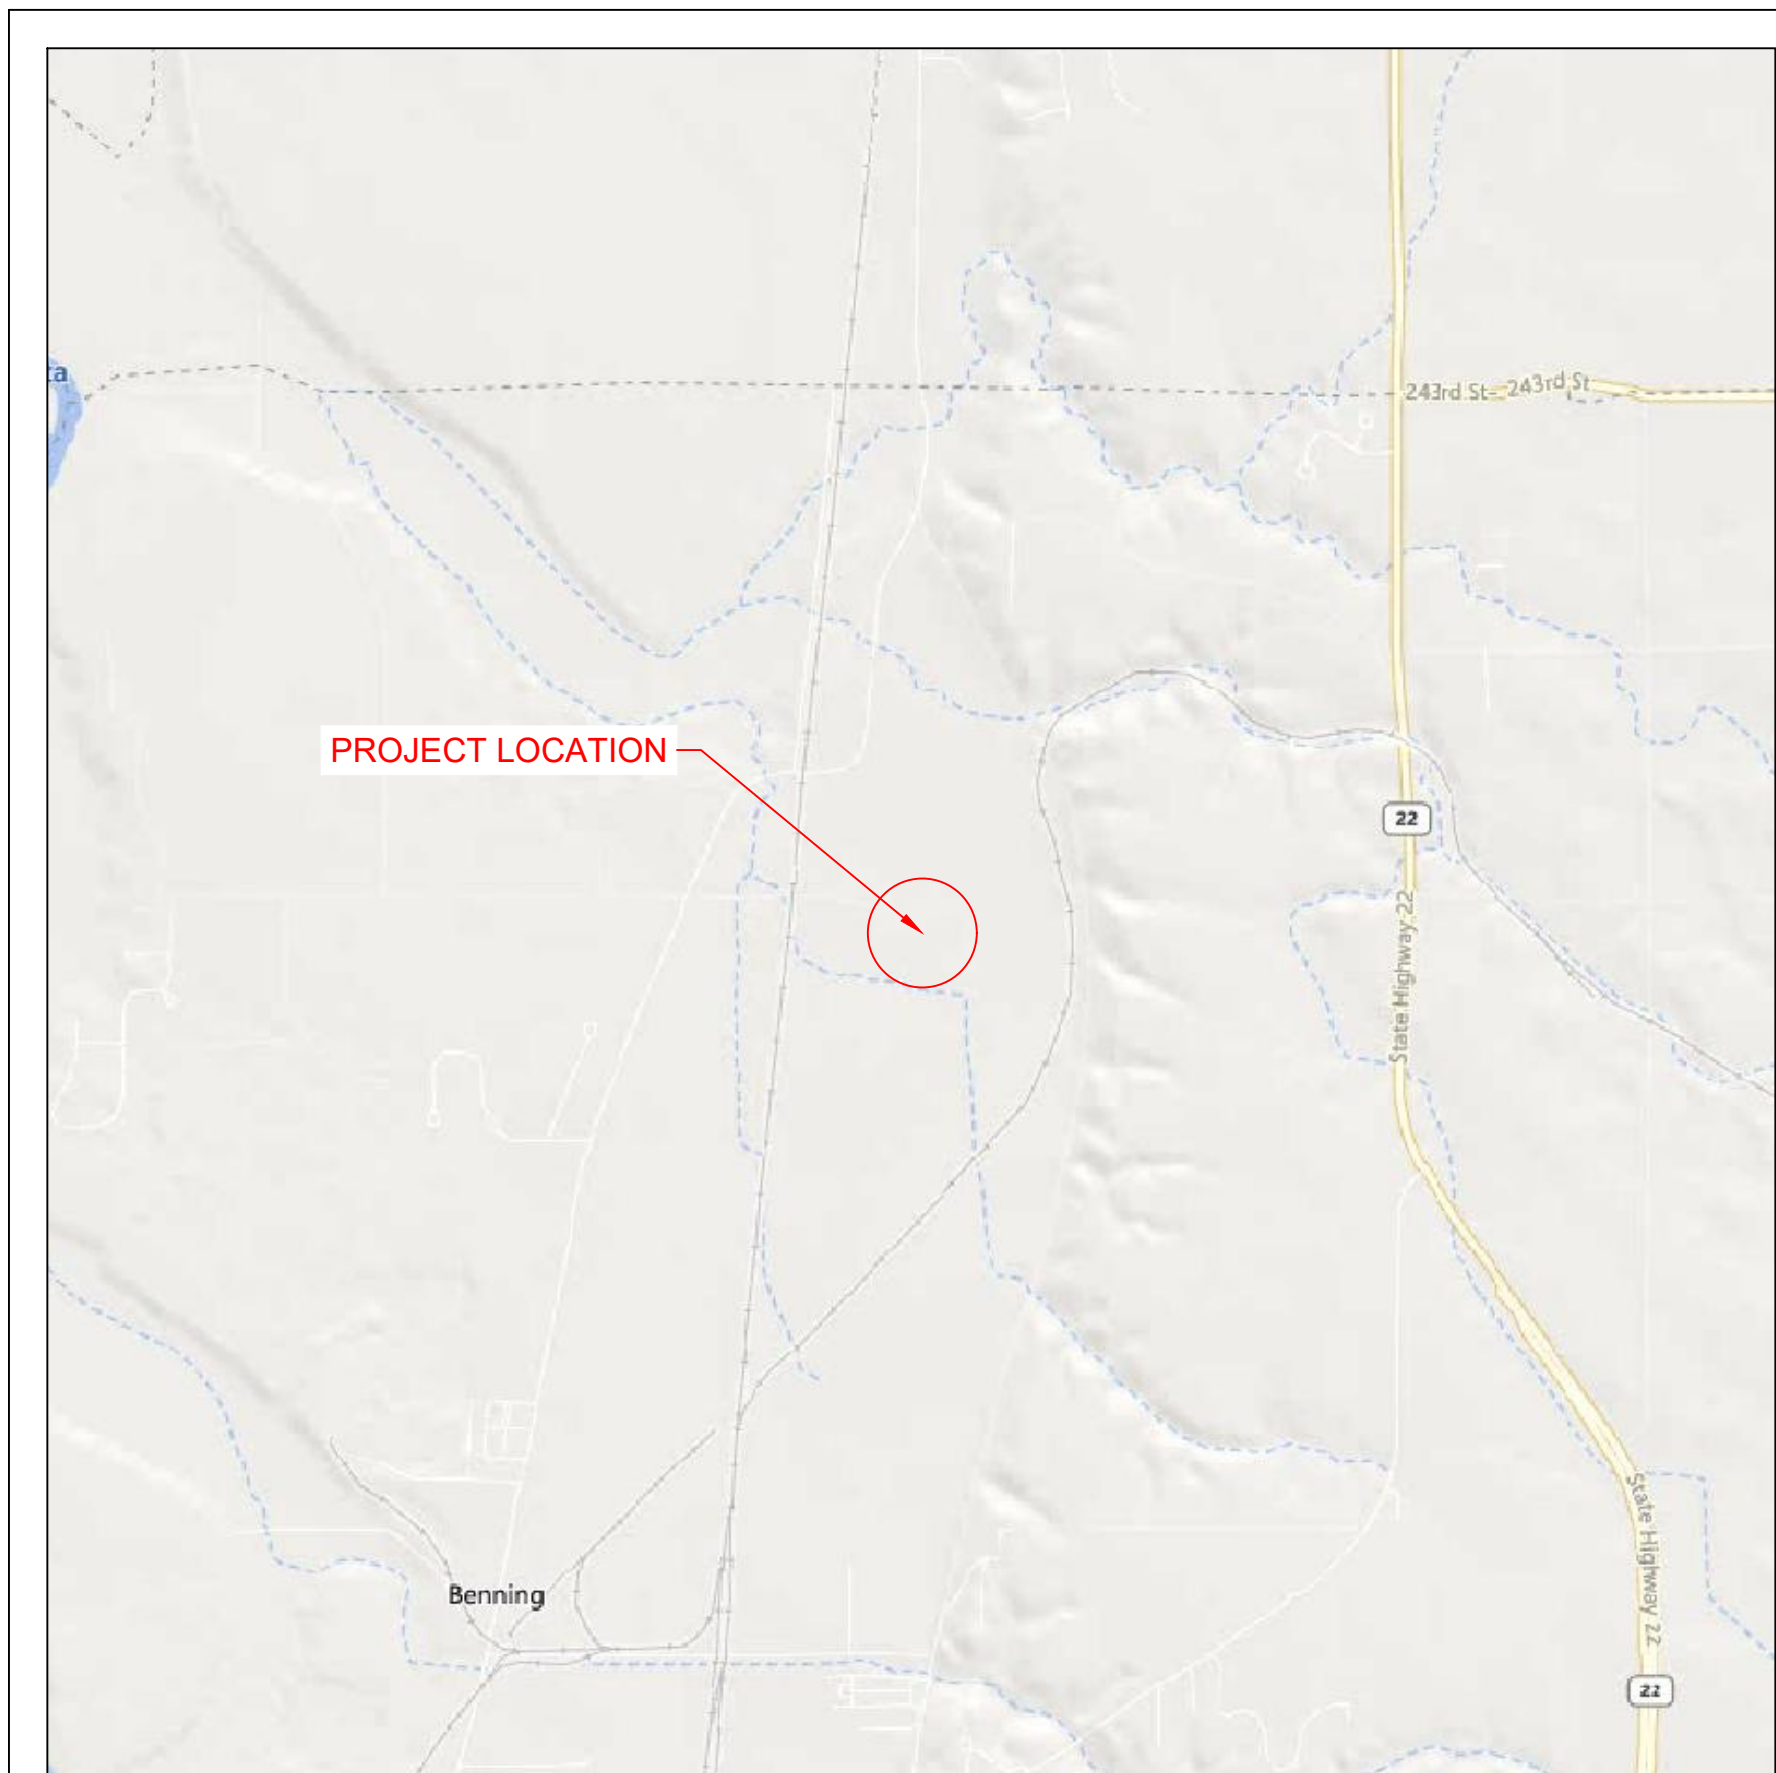

1 ARRAY LOCATION

Scale: 1" = 2000'

2 OVERHEAD MAP

Scale: 1" = 400'

PROJECT TEAM

PROJECT OWNER
MN CSG 2019-57 LLC
2530 RIVA ROAD, SUITE 200
ANNAPOLIS, MD 21401
443-267-5012

PROJECT DEVELOPER
NEW ENERGY EQUITY
2530 RIVA ROAD, SUITE 200
ANNAPOLIS, MD 21401
443-267-5012

GENERAL INFO

PROJECT ACREAGE
PARCEL ACREAGE: 84.22 ACRES
MODULE ACREAGE: 1.75 ACRES
FENCE ACREAGE: 7.2 ACRES
LIMITS OF PERMITTING ACREAGE: 10.86 ACRES
LOT COVERAGE (MODULE ACREAGE/PARCEL ACREAGE): 2.08%

PARCEL DESCRIPTION
PROPERTY OWNERS: JOHN BOHRER, AVAMAR PROPERTIES LLC, UNION
PACIFIC RAILROAD COMPANY
PARCEL ID NUMBERS: R40.04.29.200.017, R40.04.20.352.013, R40.04.20.501.001
ZONING CLASSIFICATION: RURAL CONSERVATION
APPLICATION TYPE: IUP

SETBACKS
REAR SETBACK: 50' FROM PARCEL LINE TO FENCE
SIDE SETBACK: 50' FROM PARCEL LINE TO FENCE
WETLANDS SETBACK: 30'
NON PARTICIPATING RESIDENTIAL DWELLING SETBACK: 750'

SHEET INDEX

SHEET #	DESCRIPTION	REVISION #	REVISION DATE
T1	TITLE SHEET	1	2/12/2024
PV1	EXISTING CONDITIONS	1	2/12/2024
PV2	SITE PLAN	1	2/12/2024
PV3	SETBACKS MAP	0	2/12/2024
PV4	PID MAP	0	2/12/2024
PV5	SOIL MAP	0	2/12/2024
PV6	TOPOGRAPHY & DRAINAGE PATTERNS	0	2/12/2024
PV7	LIMITS OF PERMITTING	0	2/12/2024
PV8	POLLINATOR DETAIL	0	2/20/2024
PV9	RACKING DETAIL	0	2/12/2024
PV10	FENCE DETAIL	0	2/12/2024
PV11	INFILTRATION BASIN DETAIL	0	2/12/2024
E1	SLD	0	2/12/2024
E2A	EQUIPMENT LABELS 1	0	2/12/2024
E2B	EQUIPMENT LABELS 2	0	2/12/2024
E3	IX PLAN DETAIL	0	2/12/2024



PROJECT ENTITY: MN CSG 2019-57 LLC

NEW ENERGY EQUITY, LLC
2530 RIVA ROAD, SUITE 200
ANNAPOLIS, MD 21041
NEWENERGYEQUITY.COM
443-267-5012

PROJECT ADDRESS
23759 THIRD AVE
MANKATO, MN 56001

LAT: 44.225
LONG: -93.979

SYSTEM SPECIFICATIONS

SYSTEM SIZE DC	1.503 MW
SYSTEM SIZE AC	POWER LIMITED TO 1.000 MW
DC/AC RATIO	1.503
AZIMUTH	180°
TILT	+/- 52°
MODULE COUNT	2592
MODULE TYPE	HANWA Q.PEAK DUO XL-G11.3_BFG - 580
MODULE STC RATING	580 W
INVERTER COUNT	9
INVERTER TYPE	SMA SUNNY HIGHPOWER PEAK-3 125kW
INVERTER POWER	POWER LIMITED TO 111.111kW
RACKING	TBD
MONITORING	ALSO ENERGY

DESIGN CRITERIA

MIN/MAX TEMP.	-26°C / 31°C
WIND SPEED (ASCE 7-10)	105 MPH
BUILDING CATEGORY	I
EXPOSURE CATEGORY	C
GROUND SNOW LOAD	50 PSF
BUILDING HEIGHT	0'-0"

OTHER NOTES

CASE NUMBER 05518220

NO POSITION, DISTANCE, OR CLEARANCE
ISSUES WITH OVERHEAD ELECTRIC
SERVICE LINES OR OTHER UTILITIES IN
RELATION TO THE PV PANELS.

24/7 UNESCORTED KEYLESS ACCESS
PROVIDED FOR ALL UTILITY ENERGY
EQUIPMENT INCLUDING THE METERS AND
AC DISCONNECT.

INTERCONNECTION TYPE: SECONDARY

REVISIONS

#	DESCRIPTION	BY	DATE
0	ORIGINAL DESIGN	SP	6/30/2023
1	REMOVED 1/2 MI FENCE TO FENCE SPACING INCREASE DC SIZE	NGA	7/5/2023
2	CUP PACKAGE	SP	2/9/2024
3	POLLINATOR BUFFER ADDITION	SP	2/20/2024
4	UPDATED WETLAND DELININATION	SP	6/4/2024
5	CUP RESUBMISSION	SP	7/18/2024
6			
7			
8			
9			
10			

PROJECT NAME

BOHREREAST CSG

DRAWING TITLE


TITLE SHEET

SCALE¹


AS NOTED 0 1" 2"

SHEET

T1

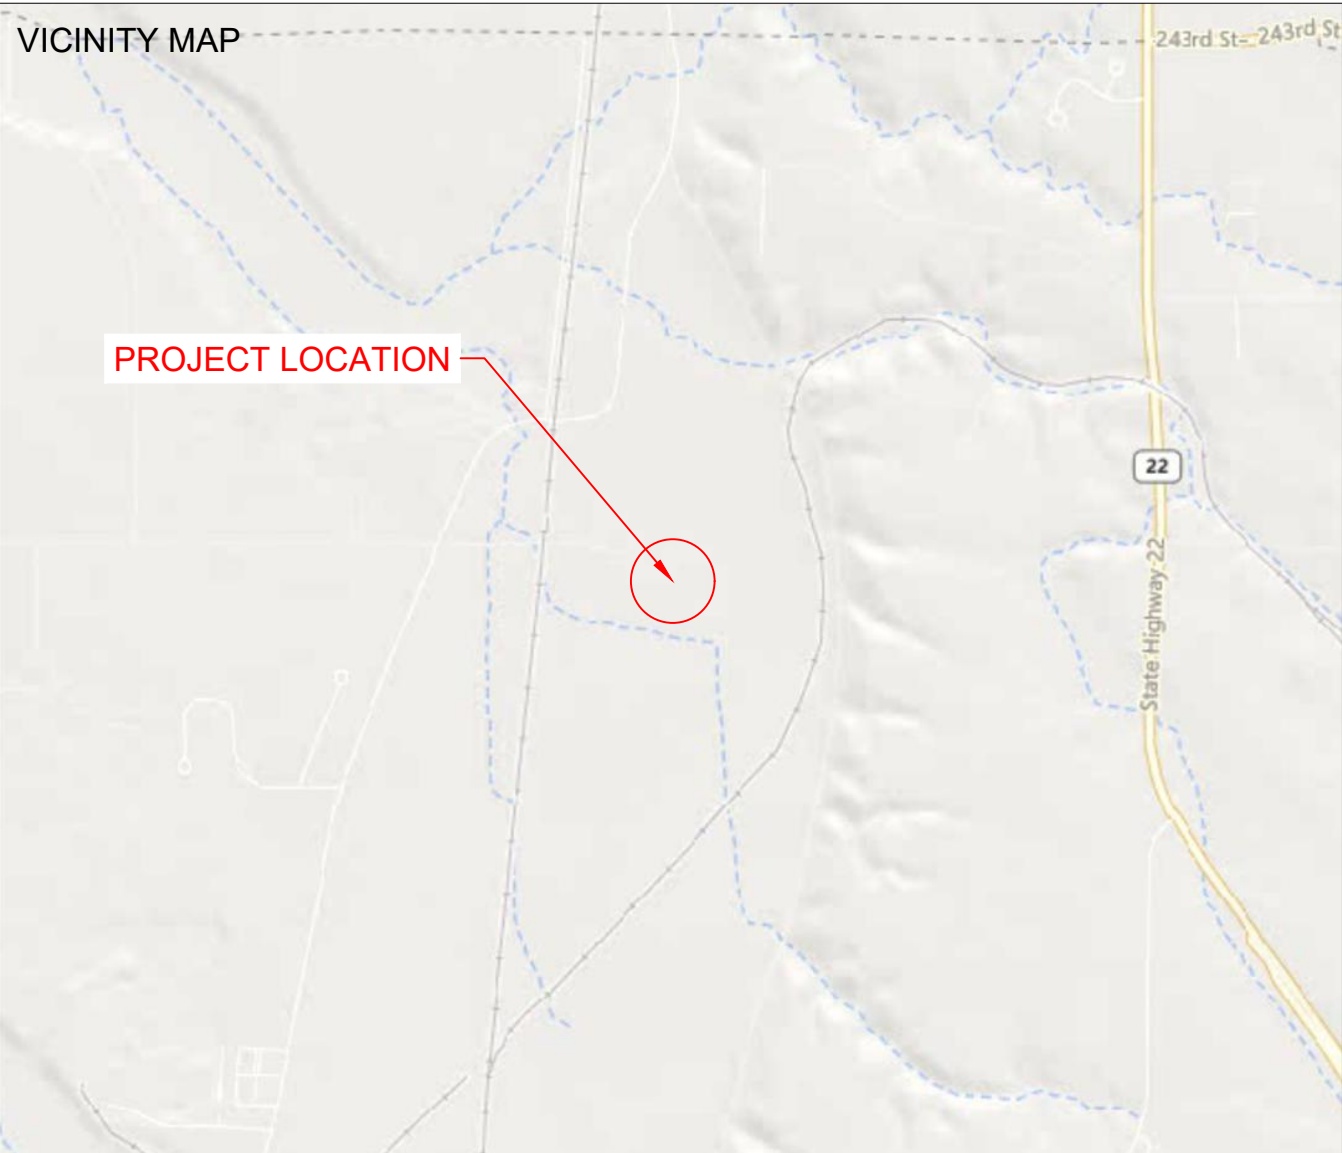

SPACE FOR PE STAMP:

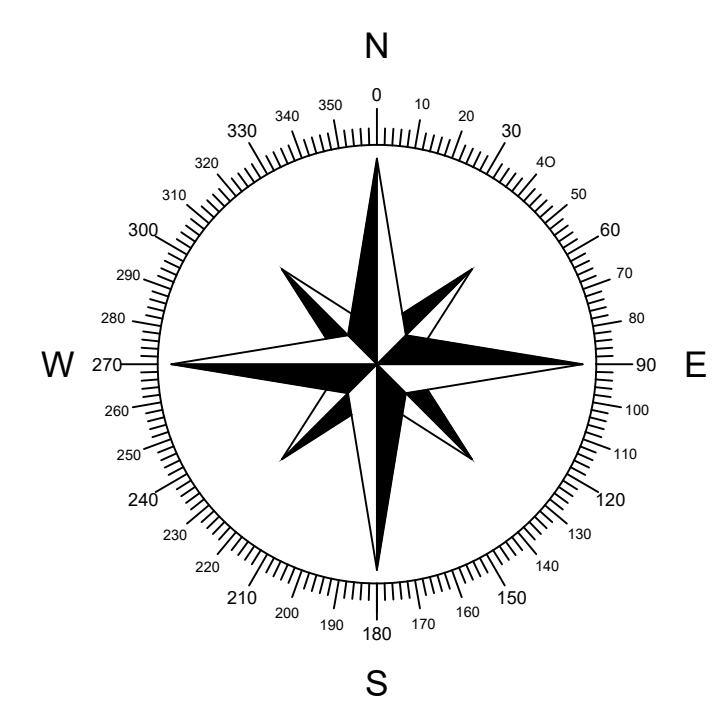

SHEET NOTES:

UTILITY POLES ARE SHOWN FOR INDICATING LOCATIONS ONLY. SPACING BETWEEN POLES, PHYSICAL PROTECTION BARRIER FOR SWITCHBOARDS, ETC. WILL BE ADDED IN THE DRAWINGS PREPARED FOR THE CONSTRUCTION DOCUMENTS



PROJECT ENTITY: MN CSG 2019-57 LLC

NEW ENERGY EQUITY, LLC
2530 RIVA ROAD, SUITE 200
ANNAPOLIS, MD 21041
NEWENERGYEQUITY.COM
443-267-5012

PROJECT ADDRESS
23759 THIRD AVE
MANKATO, MN 56001

LAT: 44.225
LONG: -93.979

SYSTEM SPECIFICATIONS

SYSTEM SIZE DC	1.503 MW
SYSTEM SIZE AC	POWER LIMITED TO 1.000 MW
DC/AC RATIO	1.503
AZIMUTH	180°
TILT	+/- 52°
MODULE COUNT	2592
MODULE TYPE	HANWA Q.PEAK DUO XL-G11.3_BFG - 580
MODULE STC RATING	580 W
INVERTER COUNT	9
INVERTER TYPE	SMA SUNNY HIGHPOWER PEAK-3 125kW
INVERTER POWER	POWER LIMITED TO 111.111kW
RACKING	TBD
MONITORING	ALSO ENERGY

DESIGN CRITERIA

MIN/MAX TEMP.	-26°C / 31°C
WIND SPEED (ASCE 7-10)	105 MPH
BUILDING CATEGORY	I
EXPOSURE CATEGORY	C
GROUND SNOW LOAD	50 PSF
BUILDING HEIGHT	0'-0"

OTHER NOTES

CASE NUMBER 05518220

NO POSITION, DISTANCE, OR CLEARANCE ISSUES WITH OVERHEAD ELECTRIC SERVICE LINES OR OTHER UTILITIES IN RELATION TO THE PV PANELS.

24/7 UNESCORTED KEYLESS ACCESS PROVIDED FOR ALL UTILITY ENERGY EQUIPMENT INCLUDING THE METERS AND AC DISCONNECT.

INTERCONNECTION TYPE: SECONDARY

REVISIONS

#	DESCRIPTION	BY	DATE
0	ORIGINAL DESIGN	SP	6/30/2023
1	REMOVED 1/2 MI FENCE TO FENCE SPACING INCREASE DC SIZE	NGA	7/5/2023
2	CUP PACKAGE	SP	2/9/2024
3	POLLINATOR BUFFER ADDITION	SP	2/20/2024
4	UPDATED WETLAND DELINEATION	SP	6/4/2024
5	CUP RESUBMISSION	SP	7/18/2024
6			
7			
8			
9			
10			

PROJECT NAME

BOHREREAST CSG

DRAWING TITLE

EXISTING CONDITIONS

SCALE ¹


1" = 140' 0 1" 2"

SHEET

PV1


LEGEND

PARCEL BOUNDARY (PID:40.04.29.200.017)	
WETLANDS (30', NTS, NATIONAL WETLANDS INVENTORY)	
EXISTING 3-PH OVERHEAD UTILITY LINE (XCEL, 13.8kV)	
EXISTING SINGLE-PH UTILITY LINE (XCEL, FEEDER SMT082, 7.97kV)	
EXISTING GAS PIPELINE (132' EASEMENT, NTS)	
NON PARTICIPATING RESIDENTIAL DWELLINGS (750' OFFSET, NTS)	

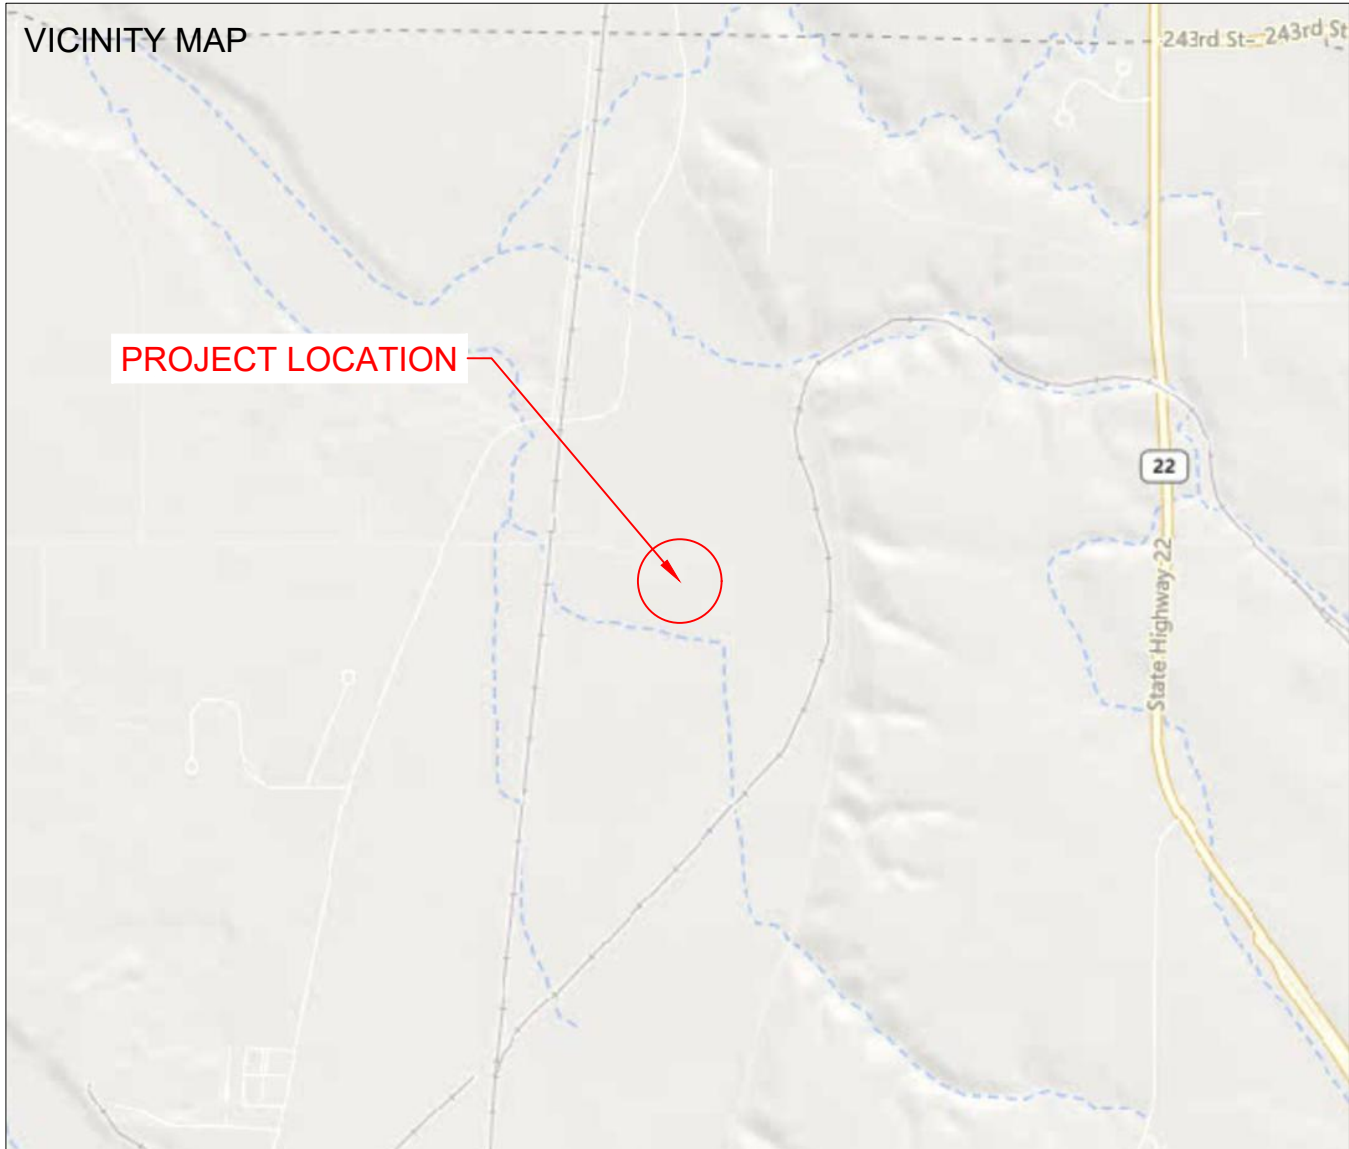

LEGEND	
PARCEL BOUNDARY (PID:40.04.29.200.017)	
50' SETBACK FROM PARCEL BOUNDARY	
WETLANDS (30', NTS, AREA M DELINEATION REPORT)	
EXISTING 3-PH OVERHEAD UTILITY LINE (XCEL, 13.8kV)	
EXISTING SINGLE-PH UTILITY LINE (XCEL, FEEDER SMT082, 7.97KV)	
PROPOSED OVERHEAD LINE EXTENSION (60')	
PROPOSED NEW UNDERGROUND ELECTRICAL LINE	
ARRAY FENCE LINE (2300' AND 7.2 ACRES)	
12' WIDE ACCESS ROAD (2675')	
ACCESS & UTILITIES EASEMENT (33' AROUND ROAD, NTS)	
EXISTING GAS PIPELINE (132' SETBACK, NTS)	
LIMITS OF PERMITTING (DETAILED ON PV7, ~10.86 ACRES)	
NON PARTICIPATING RESIDENTIAL DWELLINGS (750' OFFSET, NTS)	

SPACE FOR PE STAMP:

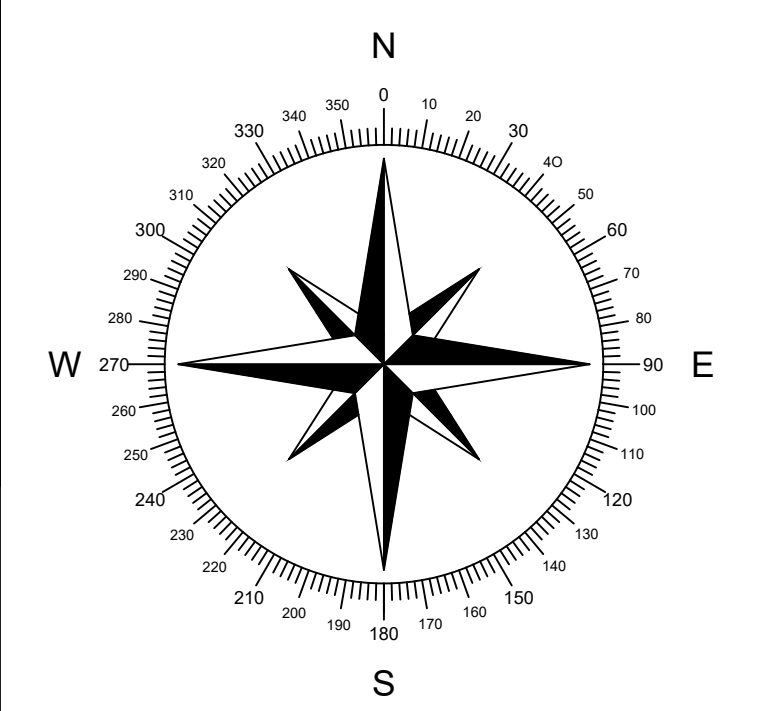

SHEET NOTES:

UTILITY POLES ARE SHOWN FOR INDICATING LOCATIONS ONLY. SPACING BETWEEN POLES, PHYSICAL PROTECTION BARRIER FOR SWITCHBOARDS, ETC. WILL BE ADDED IN THE DRAWINGS PREPARED FOR THE CONSTRUCTION DOCUMENTS



PROJECT ENTITY: MN CSG 2019-57 LLC

NEW ENERGY EQUITY, LLC
2530 RIVA ROAD, SUITE 200
ANNAPOLIS, MD 21041
NEWENERGYEQUITY.COM
443-267-5012

PROJECT ADDRESS
23759 THIRD AVE
MANKATO, MN 56001

LAT: 44.225
LONG: -93.979

SYSTEM SPECIFICATIONS	
SYSTEM SIZE DC	1,503 MW
SYSTEM SIZE AC	POWER LIMITED TO 1,000 MW
DC/AC RATIO	1.503
AZIMUTH	180°
TILT	+/- 52°
MODULE COUNT	2592
MODULE TYPE	HANWA Q.PEAK DUO XL-G11.3_BFG - 580
MODULE STC RATING	580 W
INVERTER COUNT	9
INVERTER TYPE	SMA SUNNY HIGHPOWER PEAK-3 125kW
INVERTER POWER	POWER LIMITED TO 111.111KW
RACKING	TBD
MONITORING	ALSO ENERGY

DESIGN CRITERIA	
MIN/MAX TEMP.	-26°C / 31°C
WIND SPEED (ASCE 7-10)	105 MPH
BUILDING CATEGORY	I
EXPOSURE CATEGORY	C
GROUND SNOW LOAD	50 PSF
BUILDING HEIGHT	0'-0"

OTHER NOTES

CASE NUMBER 05518220

NO POSITION, DISTANCE, OR CLEARANCE ISSUES WITH OVERHEAD ELECTRIC SERVICE LINES OR OTHER UTILITIES IN RELATION TO THE PV PANELS.

24/7 UNESCORTED KEYLESS ACCESS PROVIDED FOR ALL UTILITY ENERGY EQUIPMENT INCLUDING THE METERS AND AC DISCONNECT.

INTERCONNECTION TYPE: SECONDARY

REVISIONS			
#	DESCRIPTION	BY	DATE
0	ORIGINAL DESIGN	SP	6/30/2023
1	REMOVED 1/2 MI FENCE TO FENCE SPACING INCREASE DC SIZE	NGA	7/5/2023
2	CUP PACKAGE	SP	2/9/2024
3	POLLINATOR BUFFER ADDITION	SP	2/20/2024
4	UPDATED WETLAND DELINEATION	SP	6/4/2024
5	CUP RESUBMISSION	SP	7/18/2024
6			
7			
8			
9			
10			

PROJECT NAME

 
BOHREREAST CSG

DRAWING TITLE

SITE PLAN


SCALE ¹

1" = 160'




SHEET

PV2

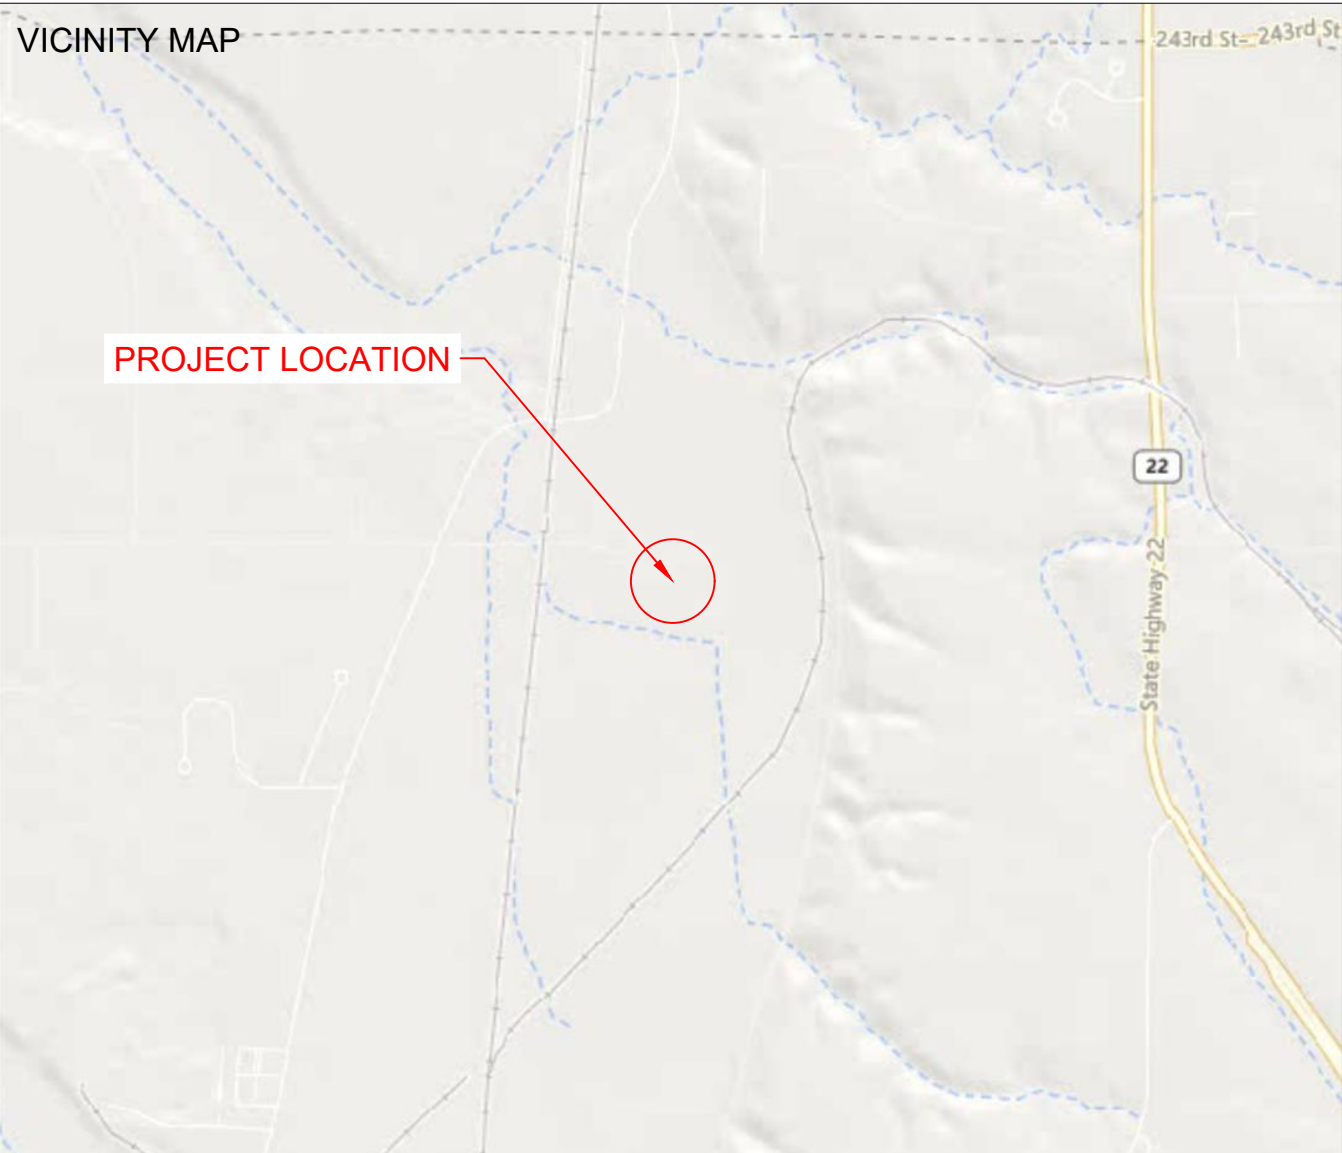


SPACE FOR PE STAMP:

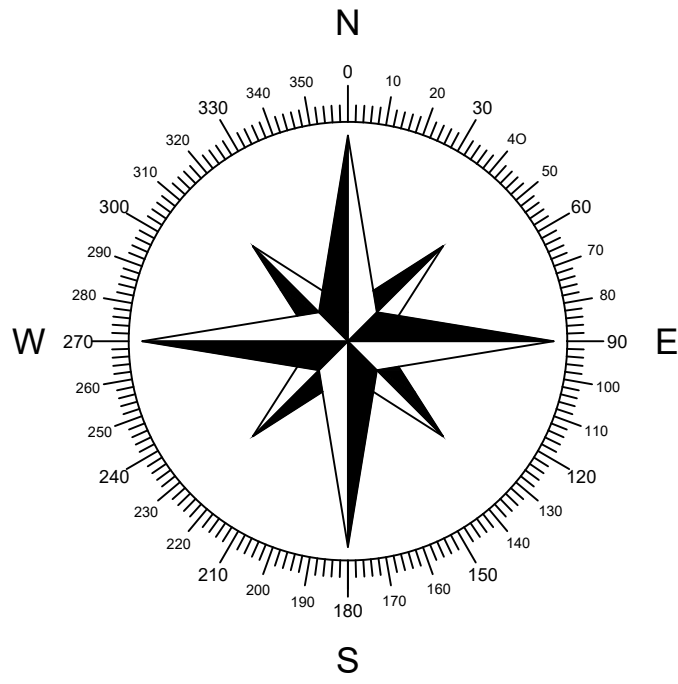

SHEET NOTES:

UTILITY POLES ARE SHOWN FOR INDICATING LOCATIONS ONLY. SPACING BETWEEN POLES, PHYSICAL PROTECTION BARRIER FOR SWITCHBOARDS, ETC. WILL BE ADDED IN THE DRAWINGS PREPARED FOR THE CONSTRUCTION DOCUMENTS

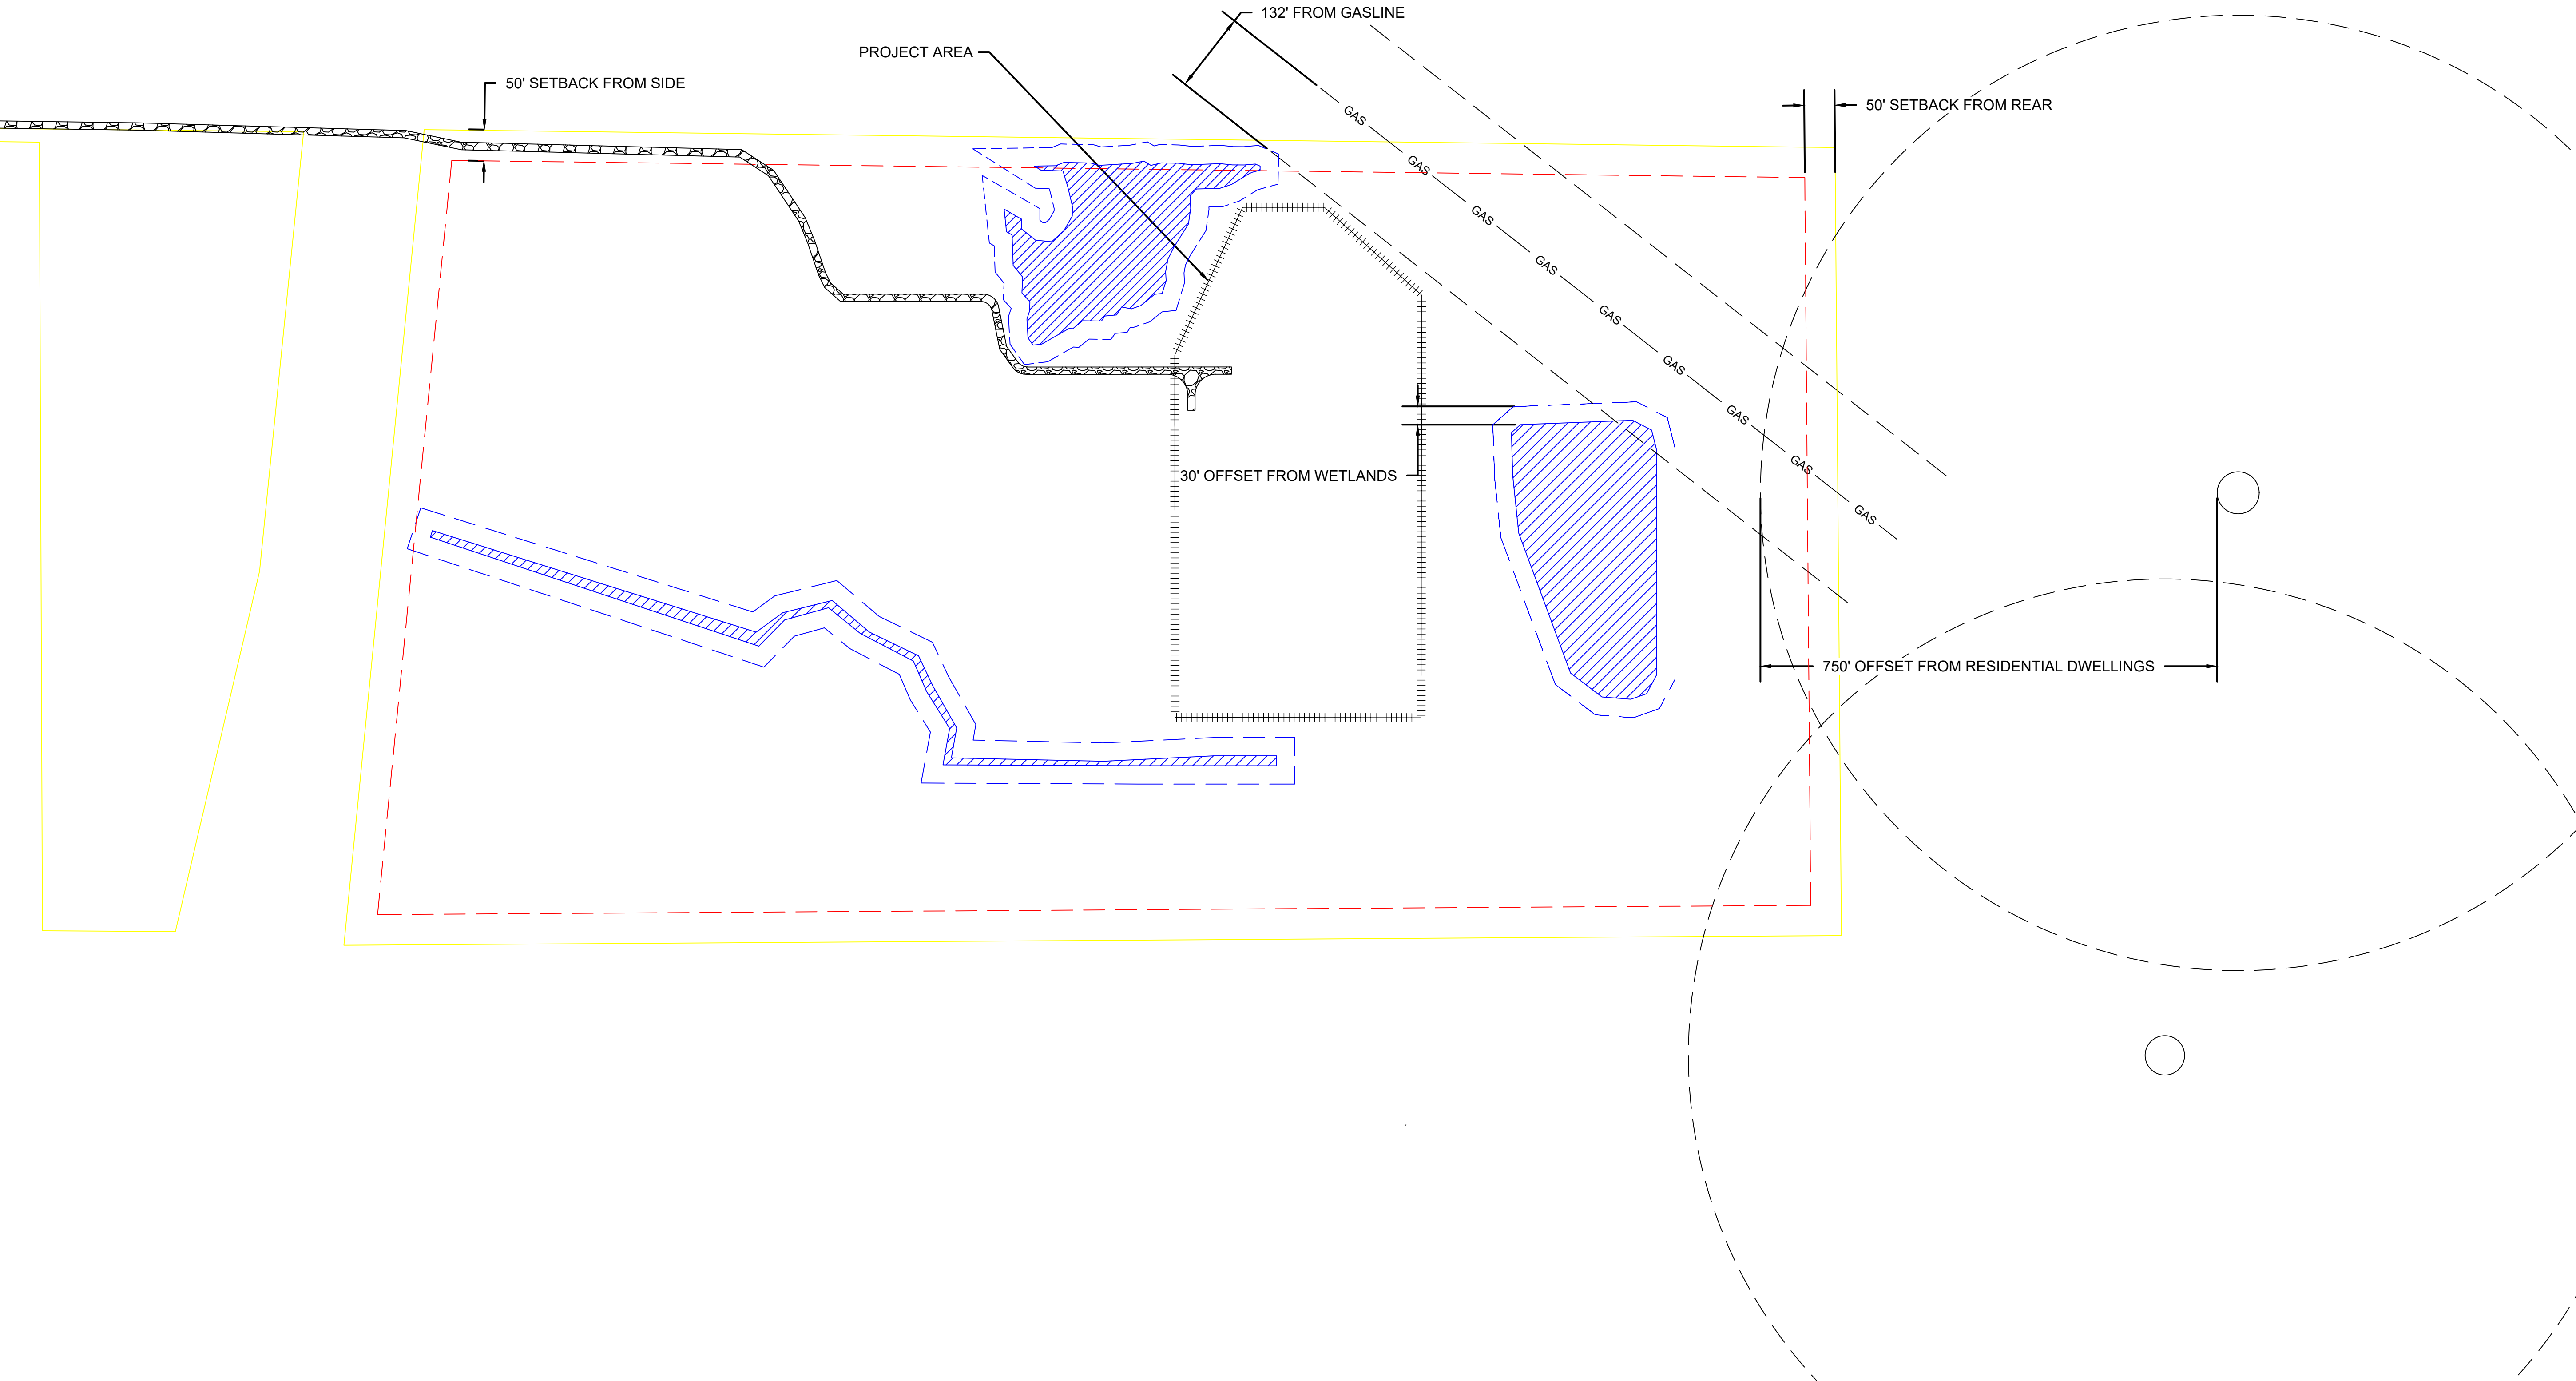

PROJECT ENTITY: MN CSG 2019-57 LLC

NEW ENERGY EQUITY, LLC
2530 RIVA ROAD, SUITE 200
ANNAPOLIS, MD 21041
NEWENERGYEQUITY.COM
443-267-5012

PROJECT ADDRESS
23759 THIRD AVE
MANKATO, MN 56001

LAT: 44.225
LONG: -93.979

SYSTEM SPECIFICATIONS

SYSTEM SIZE DC	1.503 MW
SYSTEM SIZE AC	POWER LIMITED TO 1.000 MW
DC/AC RATIO	1.503
AZIMUTH	180°
TILT	+/- 52°
MODULE COUNT	2592
MODULE TYPE	HANWA Q.PEAK DUO XL-G11.3_BFG - 580
MODULE STC RATING	580 W
INVERTER COUNT	9
INVERTER TYPE	SMA SUNNY HIGHPOWER PEAK-3 125kW
INVERTER POWER	POWER LIMITED TO 111.111kW
RACKING	TBD
MONITORING	ALSO ENERGY

DESIGN CRITERIA

MIN/MAX TEMP.	-26°C / 31°C
WIND SPEED (ASCE 7-10)	105 MPH
BUILDING CATEGORY	I
EXPOSURE CATEGORY	C
GROUND SNOW LOAD	50 PSF
BUILDING HEIGHT	0'-0"

OTHER NOTES

CASE NUMBER 05518220

NO POSITION, DISTANCE, OR CLEARANCE ISSUES WITH OVERHEAD ELECTRIC SERVICE LINES OR OTHER UTILITIES IN RELATION TO THE PV PANELS.

24/7 UNESCORTED KEYLESS ACCESS PROVIDED FOR ALL UTILITY ENERGY EQUIPMENT INCLUDING THE METERS AND AC DISCONNECT.

INTERCONNECTION TYPE: SECONDARY

REVISIONS

#	DESCRIPTION	BY	DATE
0	ORIGINAL DESIGN	SP	6/30/2023
1	REMOVED 1/2 MI FENCE TO FENCE SPACING INCREASE DC SIZE	NGA	7/5/2023
2	CUP PACKAGE	SP	2/9/2024
3	POLLINATOR BUFFER ADDITION	SP	2/20/2024
4	UPDATED WETLAND DELINEATION	SP	6/4/2024
5	CUP RESUBMISSION	SP	7/18/2024
6			
7			
8			
9			
10			

PROJECT NAME

BOHREREAST CSG

DRAWING TITLE

SETBACKS MAP


SCALE ¹

1" = 140'




SHEET

PV3

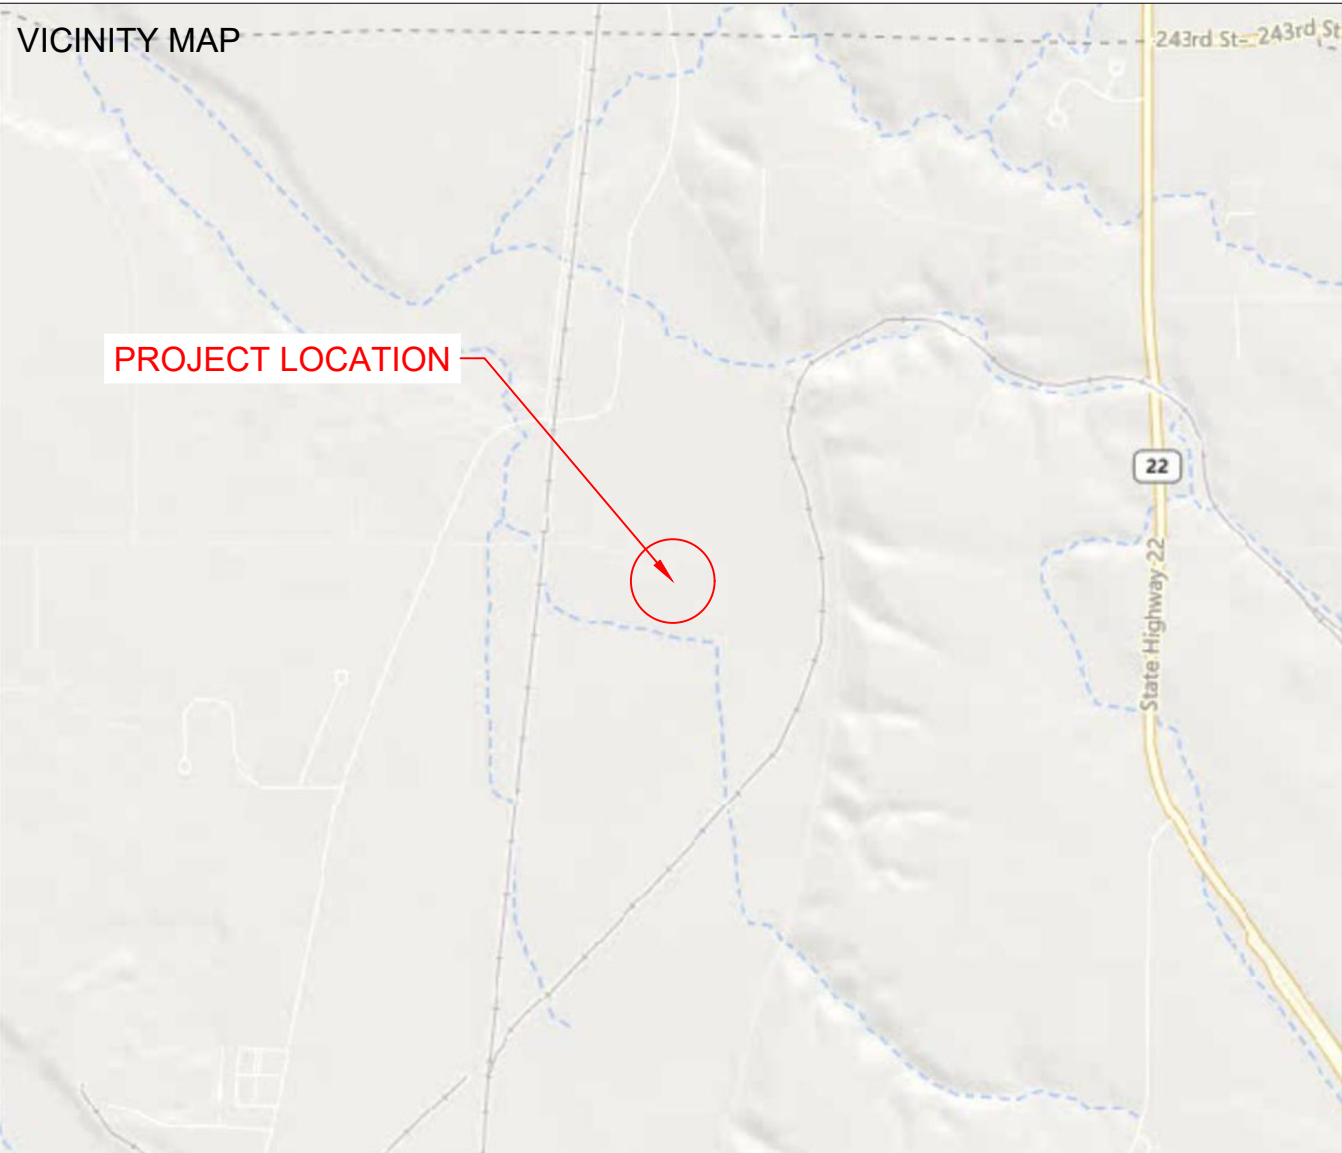

SPACE FOR PE STAMP:

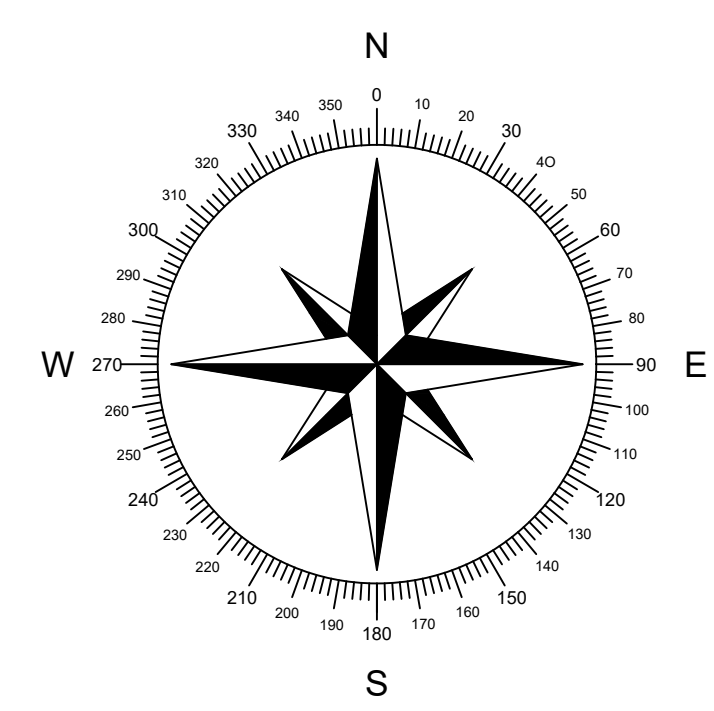

SHEET NOTES:

UTILITY POLES ARE SHOWN FOR INDICATING LOCATIONS ONLY. SPACING BETWEEN POLES, PHYSICAL PROTECTION BARRIER FOR SWITCHBOARDS, ETC. WILL BE ADDED IN THE DRAWINGS PREPARED FOR THE CONSTRUCTION DOCUMENTS



PROJECT ENTITY: MN CSG 2019-57 LLC

NEW ENERGY EQUITY, LLC
2530 RIVA ROAD, SUITE 200
ANNAPOLIS, MD 21041
NEWENERGYEQUITY.COM
443-267-5012

PROJECT ADDRESS
23759 THIRD AVE
MANKATO, MN 56001

LAT: 44.225
LONG: -93.979

SYSTEM SPECIFICATIONS

SYSTEM SIZE DC	1.503 MW
SYSTEM SIZE AC	POWER LIMITED TO 1.000 MW
DC/AC RATIO	1.503
AZIMUTH	180°
TILT	+/- 52°
MODULE COUNT	2592
MODULE TYPE	HANWA Q.PEAK DUO XL-G11.3_BFG - 580
MODULE STC RATING	580 W
INVERTER COUNT	9
INVERTER TYPE	SMA SUNNY HIGHPOWER PEAK-3 125kW
INVERTER POWER	POWER LIMITED TO 111.111kW
RACKING	TBD
MONITORING	ALSO ENERGY

DESIGN CRITERIA

MIN/MAX TEMP.	-26°C / 31°C
WIND SPEED (ASCE 7-10)	105 MPH
BUILDING CATEGORY	I
EXPOSURE CATEGORY	C
GROUND SNOW LOAD	50 PSF
BUILDING HEIGHT	0'-0"

OTHER NOTES

CASE NUMBER 05518220

NO POSITION, DISTANCE, OR CLEARANCE ISSUES WITH OVERHEAD ELECTRIC SERVICE LINES OR OTHER UTILITIES IN RELATION TO THE PV PANELS.

24/7 UNESCORTED KEYLESS ACCESS PROVIDED FOR ALL UTILITY ENERGY EQUIPMENT INCLUDING THE METERS AND AC DISCONNECT.

INTERCONNECTION TYPE: SECONDARY

REVISIONS

#	DESCRIPTION	BY	DATE
0	ORIGINAL DESIGN	SP	6/30/2023
1	REMOVED ½ MI FENCE TO FENCE SPACING INCREASE DC SIZE	NGA	7/5/2023
2	CUP PACKAGE	SP	2/9/2024
3	POLLINATOR BUFFER ADDITION	SP	2/20/2024
4	UPDATED WETLAND DELINEATION	SP	6/4/2024
5	CUP RESUBMISSION	SP	7/18/2024
6			
7			
8			
9			
10			

PROJECT NAME

 
BOHREREAST CSG

DRAWING TITLE

PID MAP

SCALE ¹

1" = 160'




SHEET

PV4




LEGEND

PARCEL BOUNDARY (PID:400429200017)

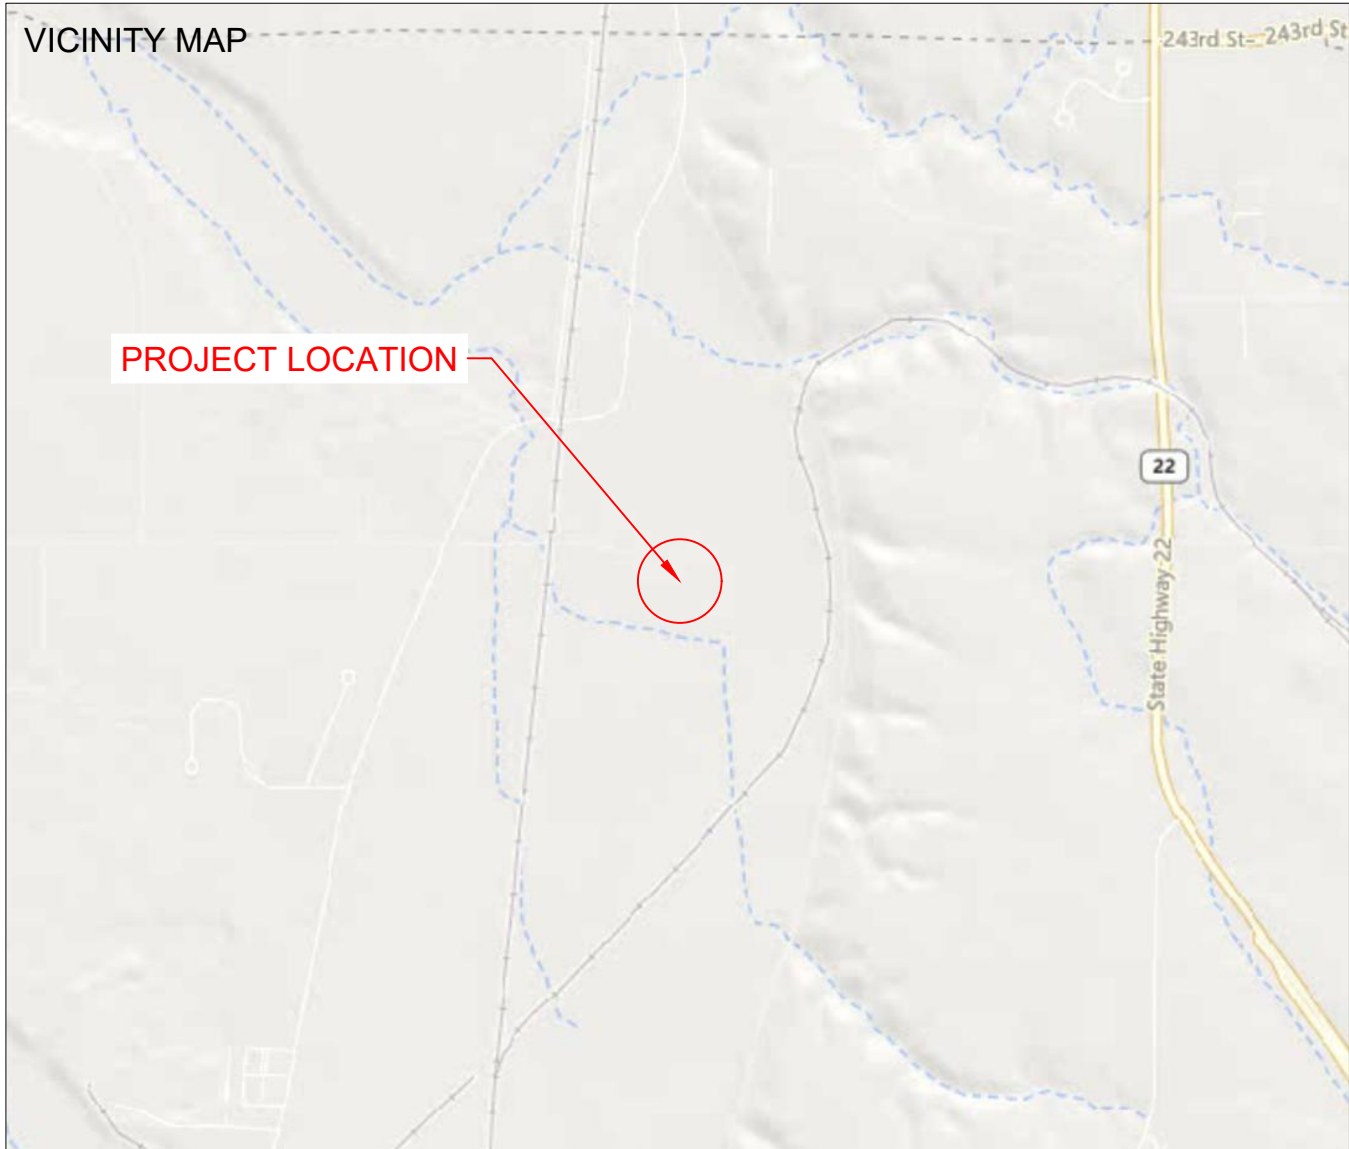

SOIL MAP LEGEND	
MAP UNIT SYMBOL	MAP UNIT NAME
85	CALCO SILTY CLAY LOAM, 0 TO 2 PERCENT SLOPES OCCASIONALLY FLOODED
1001	ALLUVIAL LAND, OCCASIONALLY FLOODED
35	BLUE EARTH MUCKY SILT LOAM, 0 TO 1 PERCENT SLOPES
160	FIELDON LOAM, 0 TO 2 PERCENT SLOPES
181	LITCHFIELD LOAMY FINE SAND, 1 TO 3 PERCENT SLOPES
321	TILFER SILTY CLAY LOAM
360B	LASA LOAMY FINE SAND, ROCK SUBSTRATUM 1 TO 6 PERCENT SLOPES
1800	CARON MUCKY PEAT

SPACE FOR PE STAMP:

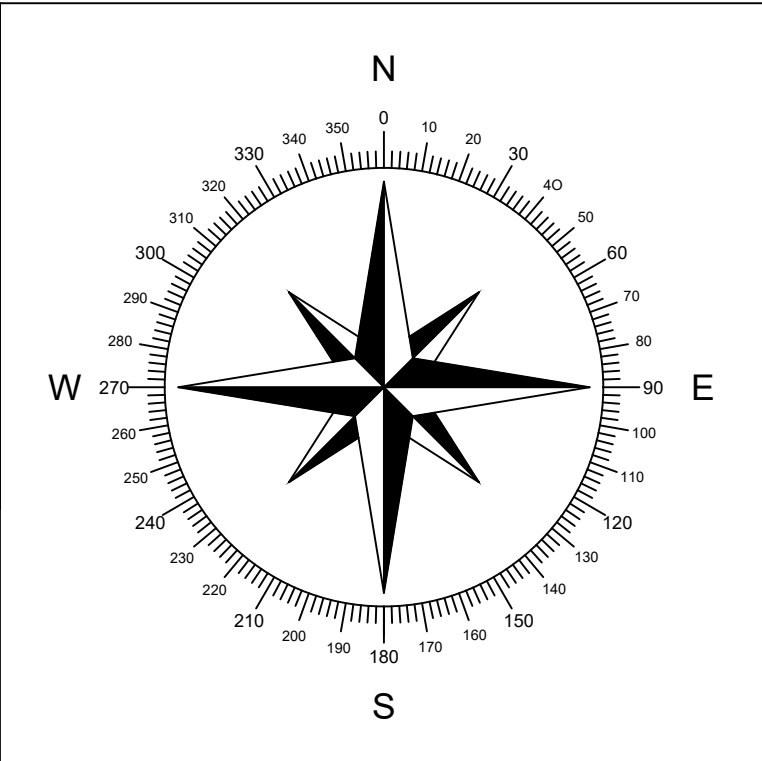

SHEET NOTES:
UTILITY POLES ARE SHOWN FOR INDICATING LOCATIONS ONLY. SPACING BETWEEN POLES, PHYSICAL PROTECTION BARRIER FOR SWITCHBOARDS, ETC. WILL BE ADDED IN THE DRAWINGS PREPARED FOR THE CONSTRUCTION DOCUMENTS



PROJECT ENTITY: MN CSG 2019-57 LLC

NEW ENERGY EQUITY, LLC
2530 RIVA ROAD, SUITE 200
ANNAPOLIS, MD 21041
NEWENERGYEQUITY.COM
443-267-5012

PROJECT ADDRESS
23759 THIRD AVE
MANKATO, MN 56001

LAT: 44.225
LONG: -93.979

SYSTEM SPECIFICATIONS	
SYSTEM SIZE DC	1,503 MW
SYSTEM SIZE AC	POWER LIMITED TO 1,000 MW
DC/AC RATIO	1.503
AZIMUTH	180°
TILT	+/- 52°
MODULE COUNT	2592
MODULE TYPE	HANWA Q.PEAK DUO XL-G11.3_BFG - 580
MODULE STC RATING	580 W
INVERTER COUNT	9
INVERTER TYPE	SMA SUNNY HIGHPOWER PEAK-3 125kW
INVERTER POWER	POWER LIMITED TO 111.111kW
RACKING	TBD
MONITORING	ALSO ENERGY
DESIGN CRITERIA	
MIN/MAX TEMP.	-26°C / 31°C
WIND SPEED (ASCE 7-10)	105 MPH
BUILDING CATEGORY	I
EXPOSURE CATEGORY	C
GROUND SNOW LOAD	50 PSF
BUILDING HEIGHT	0'-0"

OTHER NOTES

CASE NUMBER 05518220

NO POSITION, DISTANCE, OR CLEARANCE ISSUES WITH OVERHEAD ELECTRIC SERVICE LINES OR OTHER UTILITIES IN RELATION TO THE PV PANELS.


24/7 UNESCORTED KEYLESS ACCESS PROVIDED FOR ALL UTILITY ENERGY EQUIPMENT INCLUDING THE METERS AND AC DISCONNECT.

INTERCONNECTION TYPE: SECONDARY

REVISIONS			
#	DESCRIPTION	BY	DATE
0	ORIGINAL DESIGN	SP	6/30/2023
1	REMOVED 1/2 MI FENCE TO FENCE SPACING INCREASE DC SIZE	NGA	7/5/2023
2	CUP PACKAGE	SP	2/9/2024
3	POLLINATOR BUFFER ADDITION	SP	2/20/2024
4	UPDATED WETLAND DELINEATION	SP	6/4/2024
5	CUP RESUBMISSION	SP	7/18/2024
6			
7			
8			
9			
10			


PROJECT NAME
BOHREREAST CSG

 DRAWING TITLE
SOIL MAP


SCALE ¹
1" = 60' 

SHEET

PV5

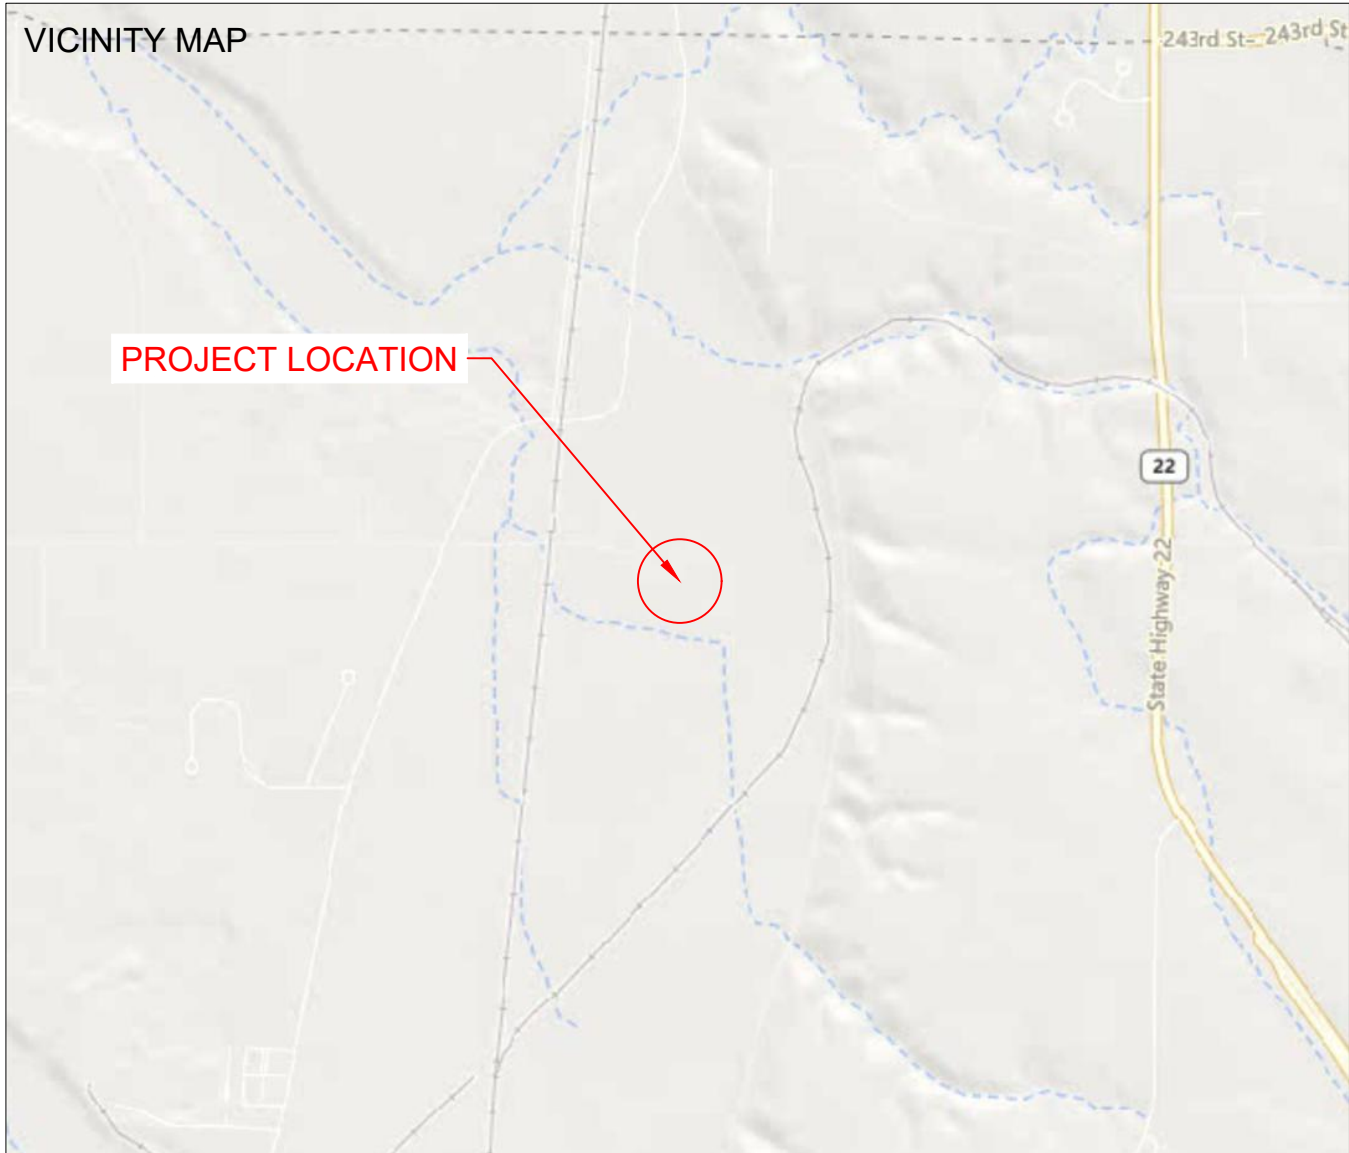


SPACE FOR PE STAMP:

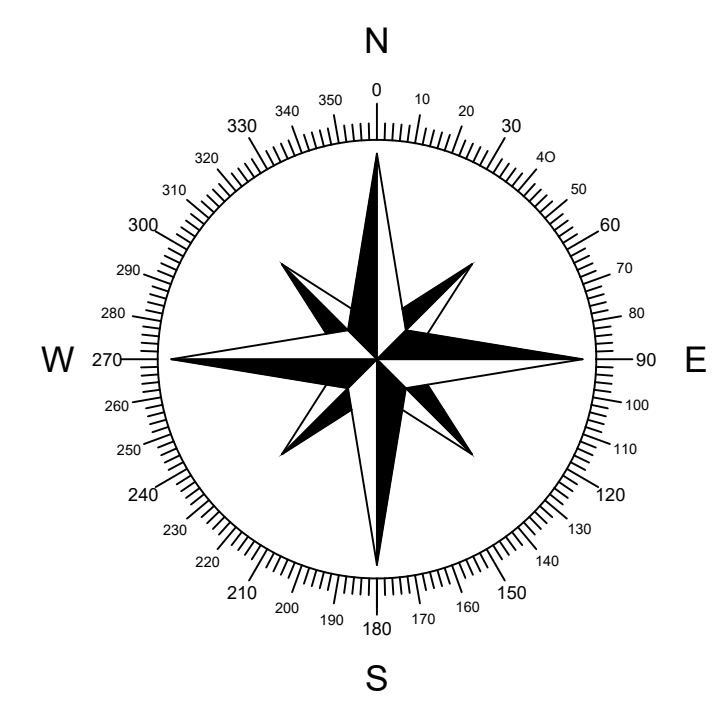

SHEET NOTES:

UTILITY POLES ARE SHOWN FOR INDICATING LOCATIONS ONLY. SPACING BETWEEN POLES, PHYSICAL PROTECTION BARRIER FOR SWITCHBOARDS, ETC. WILL BE ADDED IN THE DRAWINGS PREPARED FOR THE CONSTRUCTION DOCUMENTS

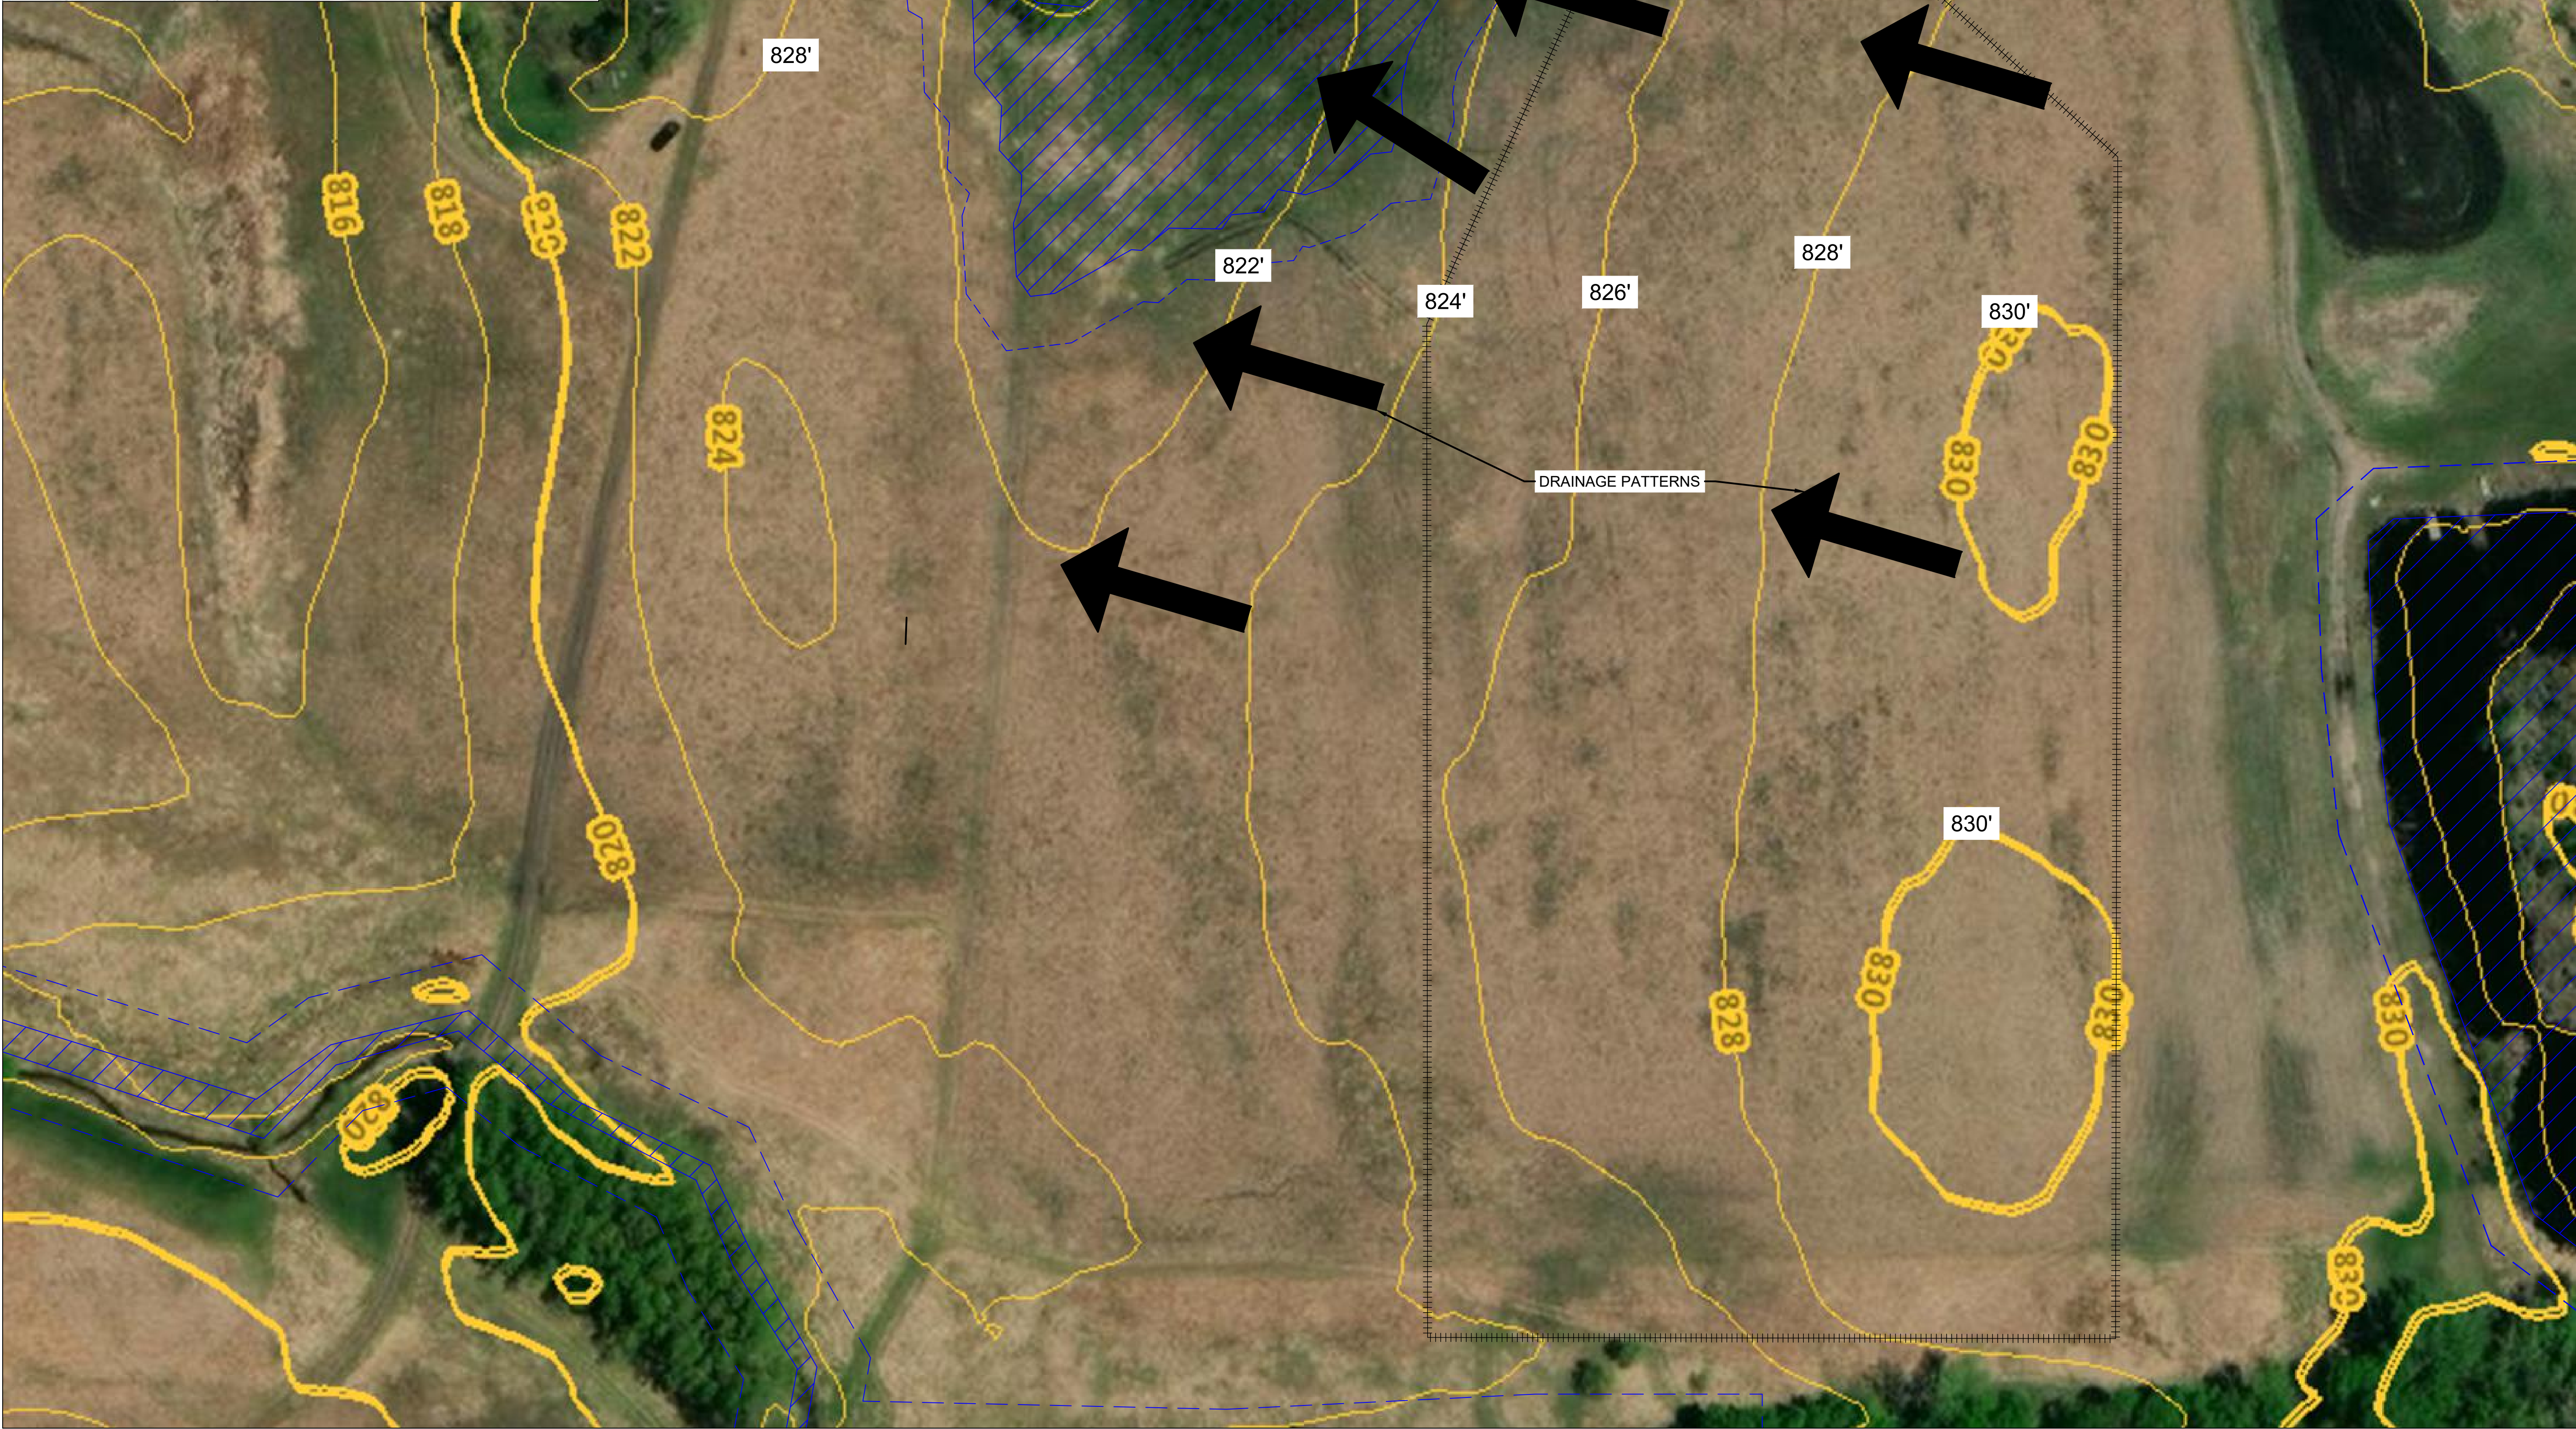

PROJECT ENTITY: MN CSG 2019-57 LLC

NEW ENERGY EQUITY, LLC
2530 RIVA ROAD, SUITE 200
ANNAPOLIS, MD 21041
NEWENERGYEQUITY.COM
443-267-5012

PROJECT ADDRESS
23759 THIRD AVE
MANKATO, MN 56001

LAT: 44.225
LONG: -93.979

SYSTEM SPECIFICATIONS

SYSTEM SIZE DC	1.503 MW
SYSTEM SIZE AC	POWER LIMITED TO 1.000 MW
DC/AC RATIO	1.503
AZIMUTH	180°
TILT	+/- 52°
MODULE COUNT	2592
MODULE TYPE	HANWA Q.PEAK DUO XL-G11.3.BFG - 580
MODULE STC RATING	580 W
INVERTER COUNT	9
INVERTER TYPE	SMA SUNNY HIGHPOWER PEAK-3 125kW
INVERTER POWER	POWER LIMITED TO 111.111kW
RACKING	TBD
MONITORING	ALSO ENERGY

DESIGN CRITERIA

MIN/MAX TEMP.	-26°C / 31°C
WIND SPEED (ASCE 7-10)	105 MPH
BUILDING CATEGORY	I
EXPOSURE CATEGORY	C
GROUND SNOW LOAD	50 PSF
BUILDING HEIGHT	0'-0"

OTHER NOTES

CASE NUMBER 05518220

NO POSITION, DISTANCE, OR CLEARANCE ISSUES WITH OVERHEAD ELECTRIC SERVICE LINES OR OTHER UTILITIES IN RELATION TO THE PV PANELS.

24/7 UNESCORTED KEYLESS ACCESS PROVIDED FOR ALL UTILITY ENERGY EQUIPMENT INCLUDING THE METERS AND AC DISCONNECT.

INTERCONNECTION TYPE: SECONDARY

REVISIONS

#	DESCRIPTION	BY	DATE
0	ORIGINAL DESIGN	SP	6/30/2023
1	REMOVED ½ MI FENCE TO FENCE SPACING INCREASE DC SIZE	NGA	7/5/2023
2	CUP PACKAGE	SP	2/9/2024
3	POLLINATOR BUFFER ADDITION	SP	2/20/2024
4	UPDATED WETLAND DELINEATION	SP	6/4/2024
5	CUP RESUBMISSION	SP	7/18/2024
6			
7			
8			
9			
10			

PROJECT NAME

BOHREREAST CSG

DRAWING TITLE

TOPOGRAPHY & DRAINAGE


SCALE ¹

1" = 50'



SHEET

PV6

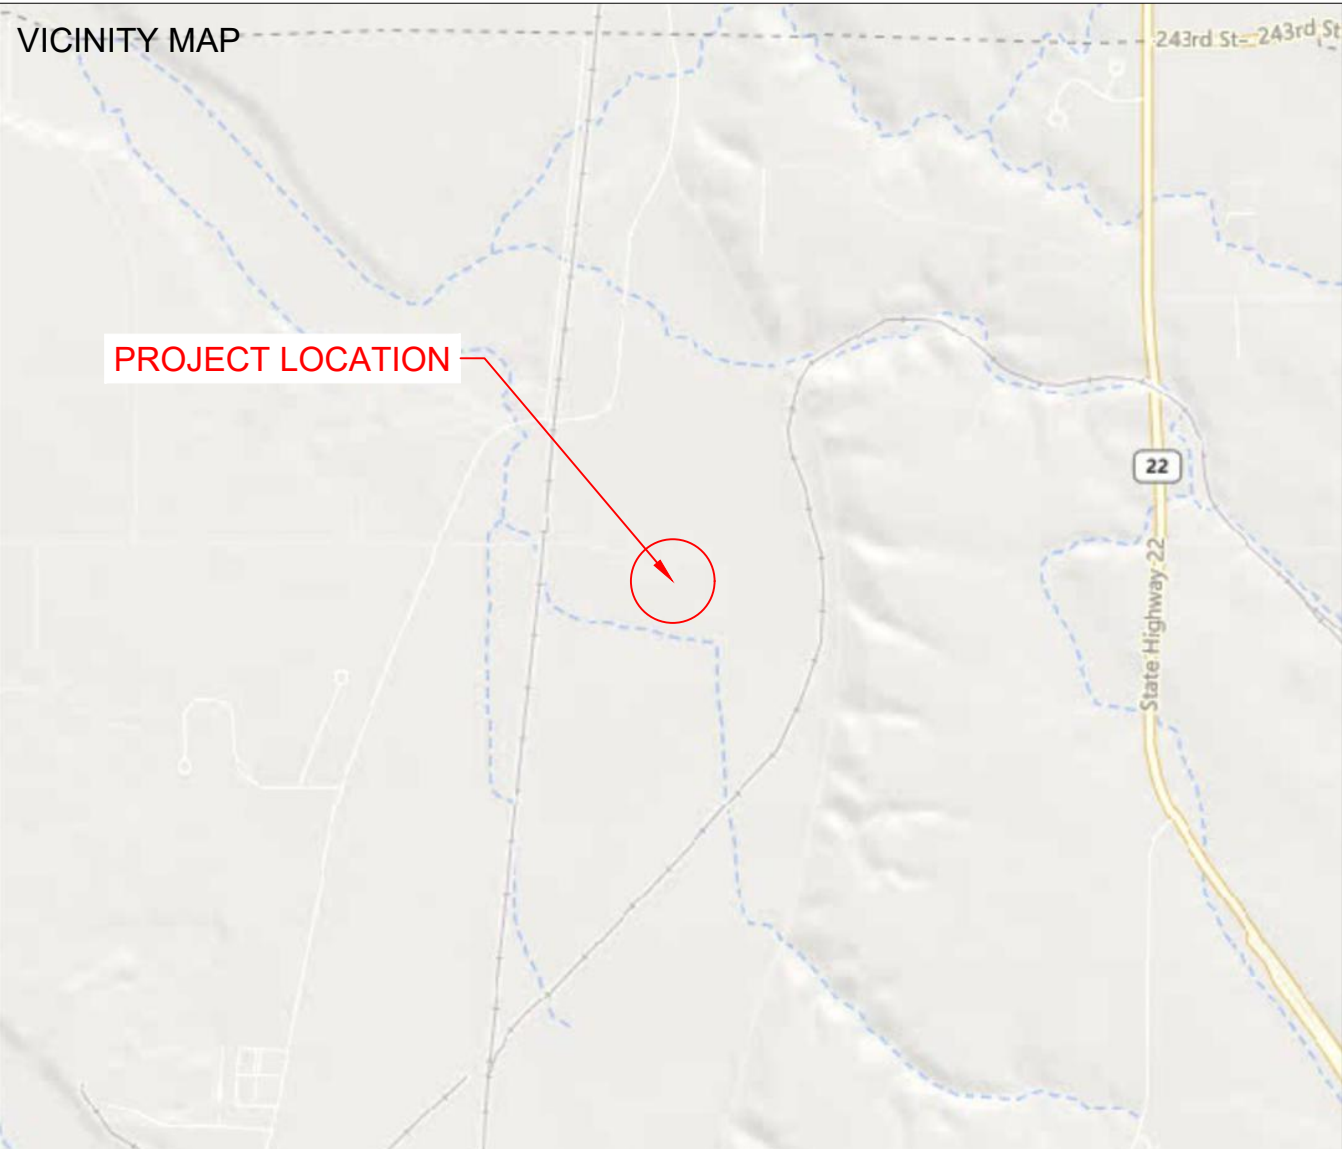


PROJECT LOCATION



LIMITS OF PERMITTING
FOLLOWS ACCESS EASEMENT
~10.86 ACRES

SPACE FOR PE STAMP:

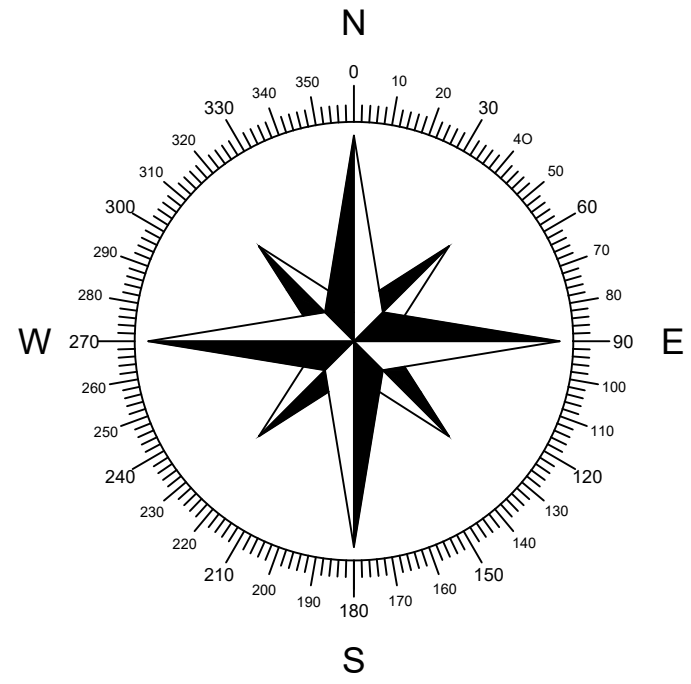

SHEET NOTES:

UTILITY POLES ARE SHOWN FOR INDICATING LOCATIONS ONLY. SPACING BETWEEN POLES, PHYSICAL PROTECTION BARRIER FOR SWITCHBOARDS, ETC. WILL BE ADDED IN THE DRAWINGS PREPARED FOR THE CONSTRUCTION DOCUMENTS



PROJECT ENTITY: MN CSG 2019-57 LLC

NEW ENERGY EQUITY, LLC
2530 RIVA ROAD, SUITE 200
ANNAPOLIS, MD 21041
NEWENERGYEQUITY.COM
443-267-5012

PROJECT ADDRESS
23759 THIRD AVE
MANKATO, MN 56001

LAT: 44.225
LONG: -93.979

SYSTEM SPECIFICATIONS

SYSTEM SIZE DC	1,503 MW
SYSTEM SIZE AC	POWER LIMITED TO 1,000 MW
DC/AC RATIO	1.503
AZIMUTH	180°
TILT	+/- 52°
MODULE COUNT	2592
MODULE TYPE	HANWA Q.PEAK DUO XL-G11.3.BFG - 580
MODULE STC RATING	580 W
INVERTER COUNT	9
INVERTER TYPE	SMA SUNNY HIGHPOWER PEAK-3 125kW
INVERTER POWER	POWER LIMITED TO 111.111kW
RACKING	TBD
MONITORING	ALSO ENERGY

DESIGN CRITERIA

MIN/MAX TEMP.	-26°C / 31°C
WIND SPEED (ASCE 7-10)	105 MPH
BUILDING CATEGORY	I
EXPOSURE CATEGORY	C
GROUND SNOW LOAD	50 PSF
BUILDING HEIGHT	0'-0"

OTHER NOTES

CASE NUMBER 05518220

NO POSITION, DISTANCE, OR CLEARANCE ISSUES WITH OVERHEAD ELECTRIC SERVICE LINES OR OTHER UTILITIES IN RELATION TO THE PV PANELS.

24/7 UNESCORTED KEYLESS ACCESS PROVIDED FOR ALL UTILITY ENERGY EQUIPMENT INCLUDING THE METERS AND AC DISCONNECT.

INTERCONNECTION TYPE: SECONDARY

REVISIONS

#	DESCRIPTION	BY	DATE
0	ORIGINAL DESIGN	SP	6/30/2023
1	REMOVED 1/2 MI FENCE TO FENCE SPACING INCREASE DC SIZE	NGA	7/5/2023
2	CUP PACKAGE	SP	2/9/2024
3	POLLINATOR BUFFER ADDITION	SP	2/20/2024
4	UPDATED WETLAND DELINEATION	SP	6/4/2024
5	CUP RESUBMISSION	SP	7/18/2024
6			
7			
8			
9			
10			

PROJECT NAME

BOHREREAST CSG

DRAWING TITLE


LIMITS OF PERMITTING

SCALE ¹

1" = 140' 0 1" 2"


SHEET

PV7

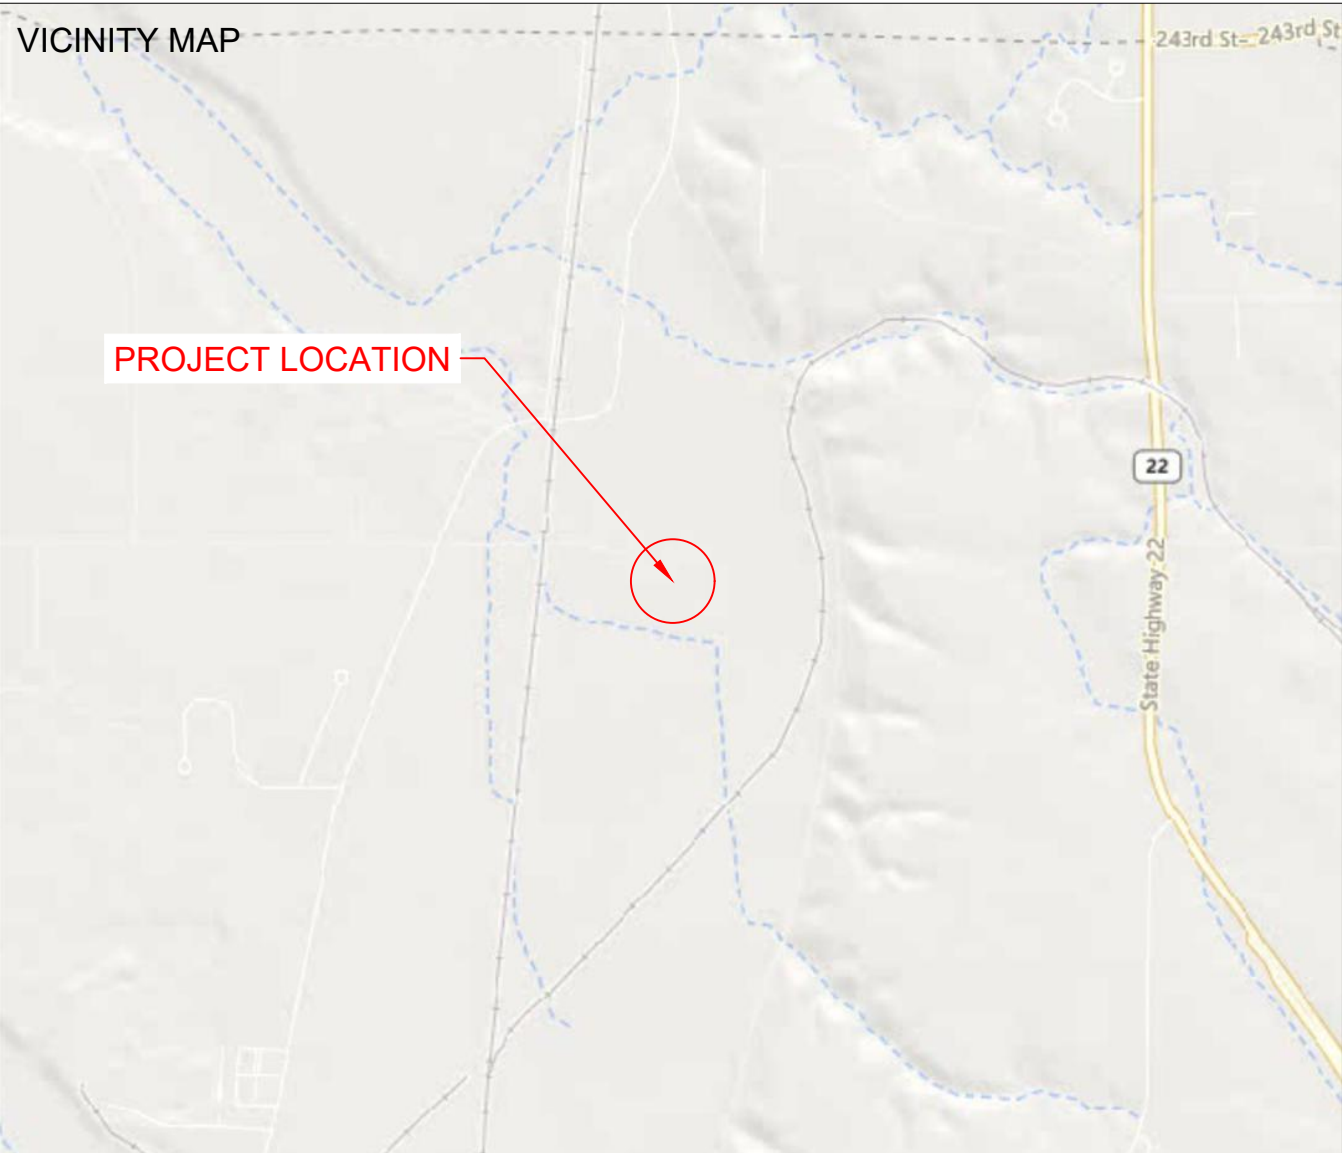

PROJECT LOCATION

SPACE FOR PE STAMP:

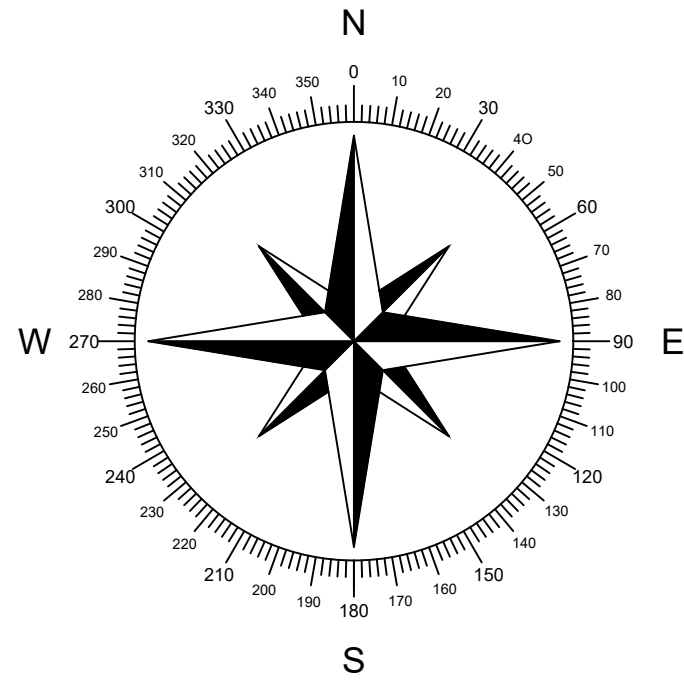

SHEET NOTES:

UTILITY POLES ARE SHOWN FOR INDICATING LOCATIONS ONLY. SPACING BETWEEN POLES, PHYSICAL PROTECTION BARRIER FOR SWITCHBOARDS, ETC. WILL BE ADDED IN THE DRAWINGS PREPARED FOR THE CONSTRUCTION DOCUMENTS



PROJECT ENTITY: MN CSG 2019-57 LLC

NEW ENERGY EQUITY, LLC
2530 RIVA ROAD, SUITE 200
ANNAPOLIS, MD 21041
NEWENERGYEQUITY.COM
443-267-5012

PROJECT ADDRESS
23759 THIRD AVE
MANKATO, MN 56001

LAT: 44.225
LONG: -93.979

SYSTEM SPECIFICATIONS

SYSTEM SIZE DC	1,503 MW
SYSTEM SIZE AC	POWER LIMITED TO 1,000 MW
DC/AC RATIO	1.503
AZIMUTH	180°
TILT	+/- 52°
MODULE COUNT	2592
MODULE TYPE	HANWA Q.PEAK DUO XL-G11.3.BFG - 580
MODULE STC RATING	580 W
INVERTER COUNT	9
INVERTER TYPE	SMA SUNNY HIGHPOWER PEAK-3 125kW
INVERTER POWER	POWER LIMITED TO 111.111kW
RACKING	TBD
MONITORING	ALSO ENERGY

DESIGN CRITERIA

MIN/MAX TEMP.	-26°C / 31°C
WIND SPEED (ASCE 7-10)	105 MPH
BUILDING CATEGORY	I
EXPOSURE CATEGORY	C
GROUND SNOW LOAD	50 PSF
BUILDING HEIGHT	0'-0"

OTHER NOTES

CASE NUMBER 05518220

NO POSITION, DISTANCE, OR CLEARANCE ISSUES WITH OVERHEAD ELECTRIC SERVICE LINES OR OTHER UTILITIES IN RELATION TO THE PV PANELS.

24/7 UNESCORTED KEYLESS ACCESS PROVIDED FOR ALL UTILITY ENERGY EQUIPMENT INCLUDING THE METERS AND AC DISCONNECT.

INTERCONNECTION TYPE: SECONDARY

REVISIONS

#	DESCRIPTION	BY	DATE
0	ORIGINAL DESIGN	SP	6/30/2023
1	REMOVED 1/2 MI FENCE TO FENCE SPACING INCREASE DC SIZE	NGA	7/5/2023
2	CUP PACKAGE	SP	2/9/2024
3	POLLINATOR BUFFER ADDITION	SP	2/20/2024
4	UPDATED WETLAND DELINEATION	SP	6/4/2024
5	CUP RESUBMISSION	SP	7/18/2024
6			
7			
8			
9			
10			

PROJECT NAME

BOHREREAST CSG

DRAWING TITLE

LANDSCAPING PLAN


SCALE ¹

1" = 140'




SHEET


PV8

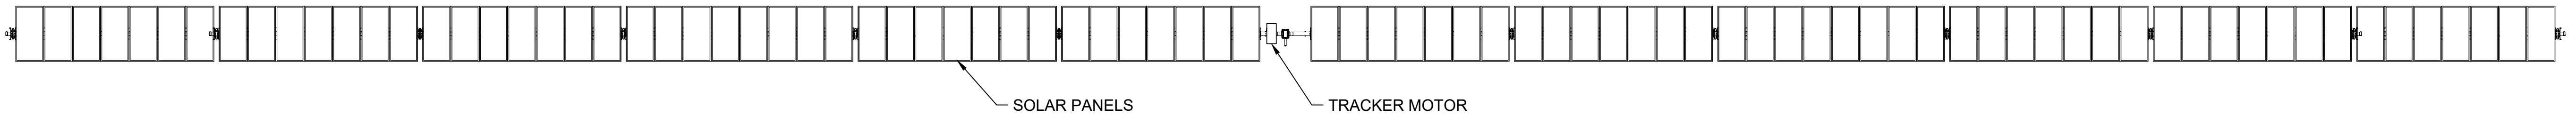

1 SINGLE AXIS TRACKER TOP DOWN VIEW
NTS

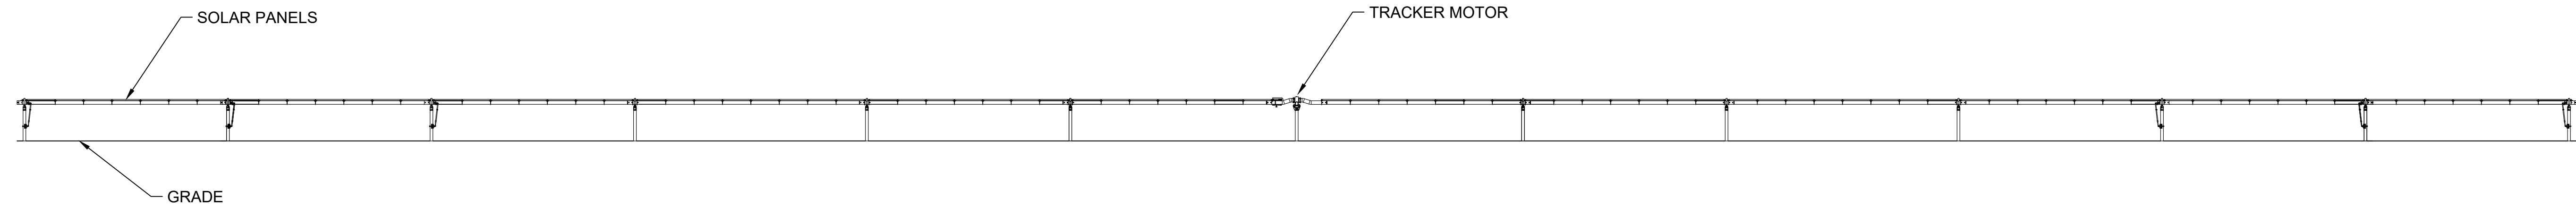

2 SINGLE AXIS TRACKER EAST-WEST ELEVATION
NTS

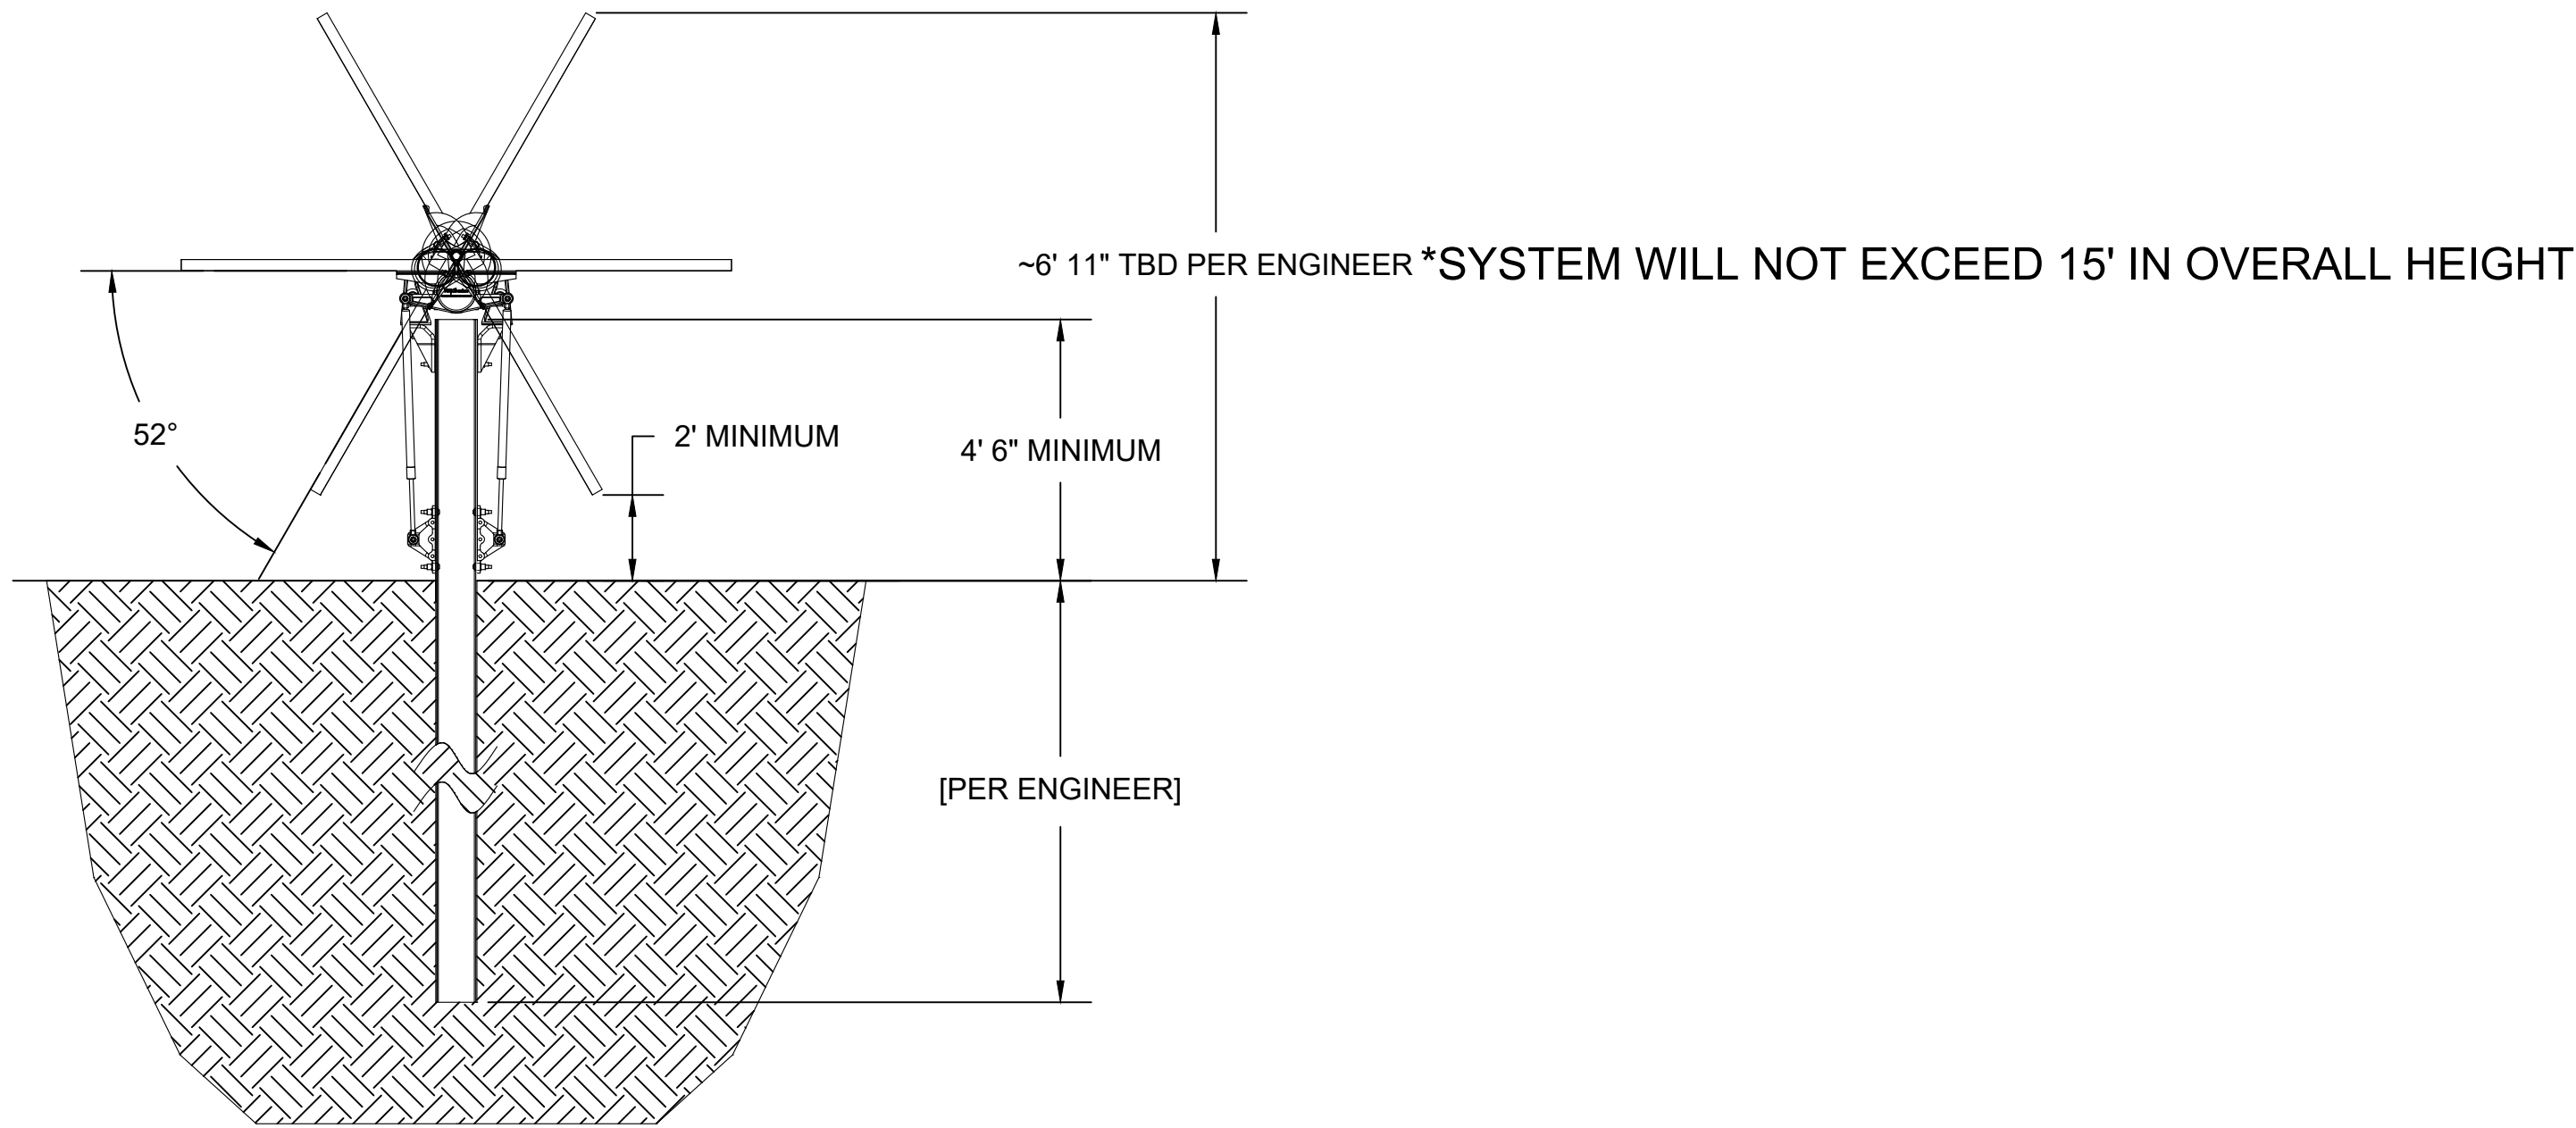

3 SINGLE AXIS TRACKER NORTH-SOUTH ELEVATION
NTS



PROJECT ENTITY: MN CSG 2019-57 LLC

NEW ENERGY EQUITY, LLC
2530 RIVA ROAD, SUITE 200
ANNAPOLIS, MD 21041
NEWENERGYEQUITY.COM
443-267-5012

PROJECT ADDRESS
23759 THIRD AVE
MANKATO, MN 56001

LAT: 44.225
LONG: -93.979

SYSTEM SPECIFICATIONS

SYSTEM SIZE DC	1.503 MW
SYSTEM SIZE AC	POWER LIMITED TO 1.000 MW
DC/AC RATIO	1.503
AZIMUTH	180°
TILT	+/- 52°
MODULE COUNT	2592
MODULE TYPE	HANWA Q.PEAK DUO XL-G11.3_BFG - 580
MODULE STC RATING	580 W
INVERTER COUNT	9
INVERTER TYPE	SMA SUNNY HIGHPOWER PEAK-3 125kW
INVERTER POWER	POWER LIMITED TO 111.111kW
RACKING	TBD
MONITORING	ALSO ENERGY

DESIGN CRITERIA

MIN/MAX TEMP.	-26°C / 31°C
WIND SPEED (ASCE 7-10)	105 MPH
BUILDING CATEGORY	I
EXPOSURE CATEGORY	C
GROUND SNOW LOAD	50 PSF
BUILDING HEIGHT	0'-0"

OTHER NOTES

CASE NUMBER 05518220

NO POSITION, DISTANCE, OR CLEARANCE
ISSUES WITH OVERHEAD ELECTRIC
SERVICE LINES OR OTHER UTILITIES IN
RELATION TO THE PV PANELS.

24/7 UNESCORTED KEYLESS ACCESS
PROVIDED FOR ALL UTILITY ENERGY
EQUIPMENT INCLUDING THE METERS AND
AC DISCONNECT.

INTERCONNECTION TYPE: SECONDARY

REVISIONS

#	DESCRIPTION	BY	DATE
0	ORIGINAL DESIGN	SP	6/30/2023
1	REMOVED ½ MI FENCE TO FENCE SPACING INCREASE DC SIZE	NGA	7/5/2023
2	CUP PACKAGE	SP	2/9/2024
3	POLLINATOR BUFFER ADDITION	SP	2/20/2024
4	UPDATED WETLAND DELIINIATION	SP	6/4/2024
5	CUP RESUBMISSION	SP	7/18/2024
6			
7			
8			
9			
10			

PROJECT NAME

BOHREREAST CSG

DRAWING TITLE

SAT RACKING DETAIL

SCALE ¹

NTS

SHEET

PV9

SYSTEM SPECIFICATIONS

SYSTEM SIZE DC	1.503 MW
SYSTEM SIZE AC	POWER LIMITED TO 1.000 MW
DC/AC RATIO	1.503
AZIMUTH	180°
TILT	+/- 52°
MODULE COUNT	2592
MODULE TYPE	HANWA Q.PEAK DUO XL-G11.3_BFG - 580
MODULE STC RATING	580 W
INVERTER COUNT	9
INVERTER TYPE	SMA SUNNY HIGHPOWER PEAK-3 125kW
INVERTER POWER	POWER LIMITED TO 111.111kW
RACKING	TBD
MONITORING	ALSO ENERGY

DESIGN CRITERIA

MIN/MAX TEMP.	-26°C / 31°C
WIND SPEED (ASCE 7-10)	105 MPH
BUILDING CATEGORY	I
EXPOSURE CATEGORY	C
GROUND SNOW LOAD	50 PSF
BUILDING HEIGHT	0'-0"

OTHER NOTES

CASE NUMBER 05518220

NO POSITION, DISTANCE, OR CLEARANCE
ISSUES WITH OVERHEAD ELECTRIC
SERVICE LINES OR OTHER UTILITIES IN
RELATION TO THE PV PANELS.

24/7 UNESCORTED KEYLESS ACCESS
PROVIDED FOR ALL UTILITY ENERGY
EQUIPMENT INCLUDING THE METERS AND
AC DISCONNECT.

INTERCONNECTION TYPE: SECONDARY

REVISIONS

#	DESCRIPTION	BY	DATE
0	ORIGINAL DESIGN	SP	6/30/2023
1	REMOVED ½ MI FENCE TO FENCE SPACING INCREASE DC SIZE	NGA	7/5/2023
2	CUP PACKAGE	SP	2/9/2024
3	POLLINATOR BUFFER ADDITION	SP	2/20/2024
4	UPDATED WETLAND DELINEATION	SP	6/4/2024
5	CUP RESUBMISSION	SP	7/18/2024
6			
7			
8			
9			
10			

PROJECT NAME

BOHREREAST CSG

DRAWING TITLE


FENCE DETAIL

SCALE ¹


NTS

SHEET

PV10

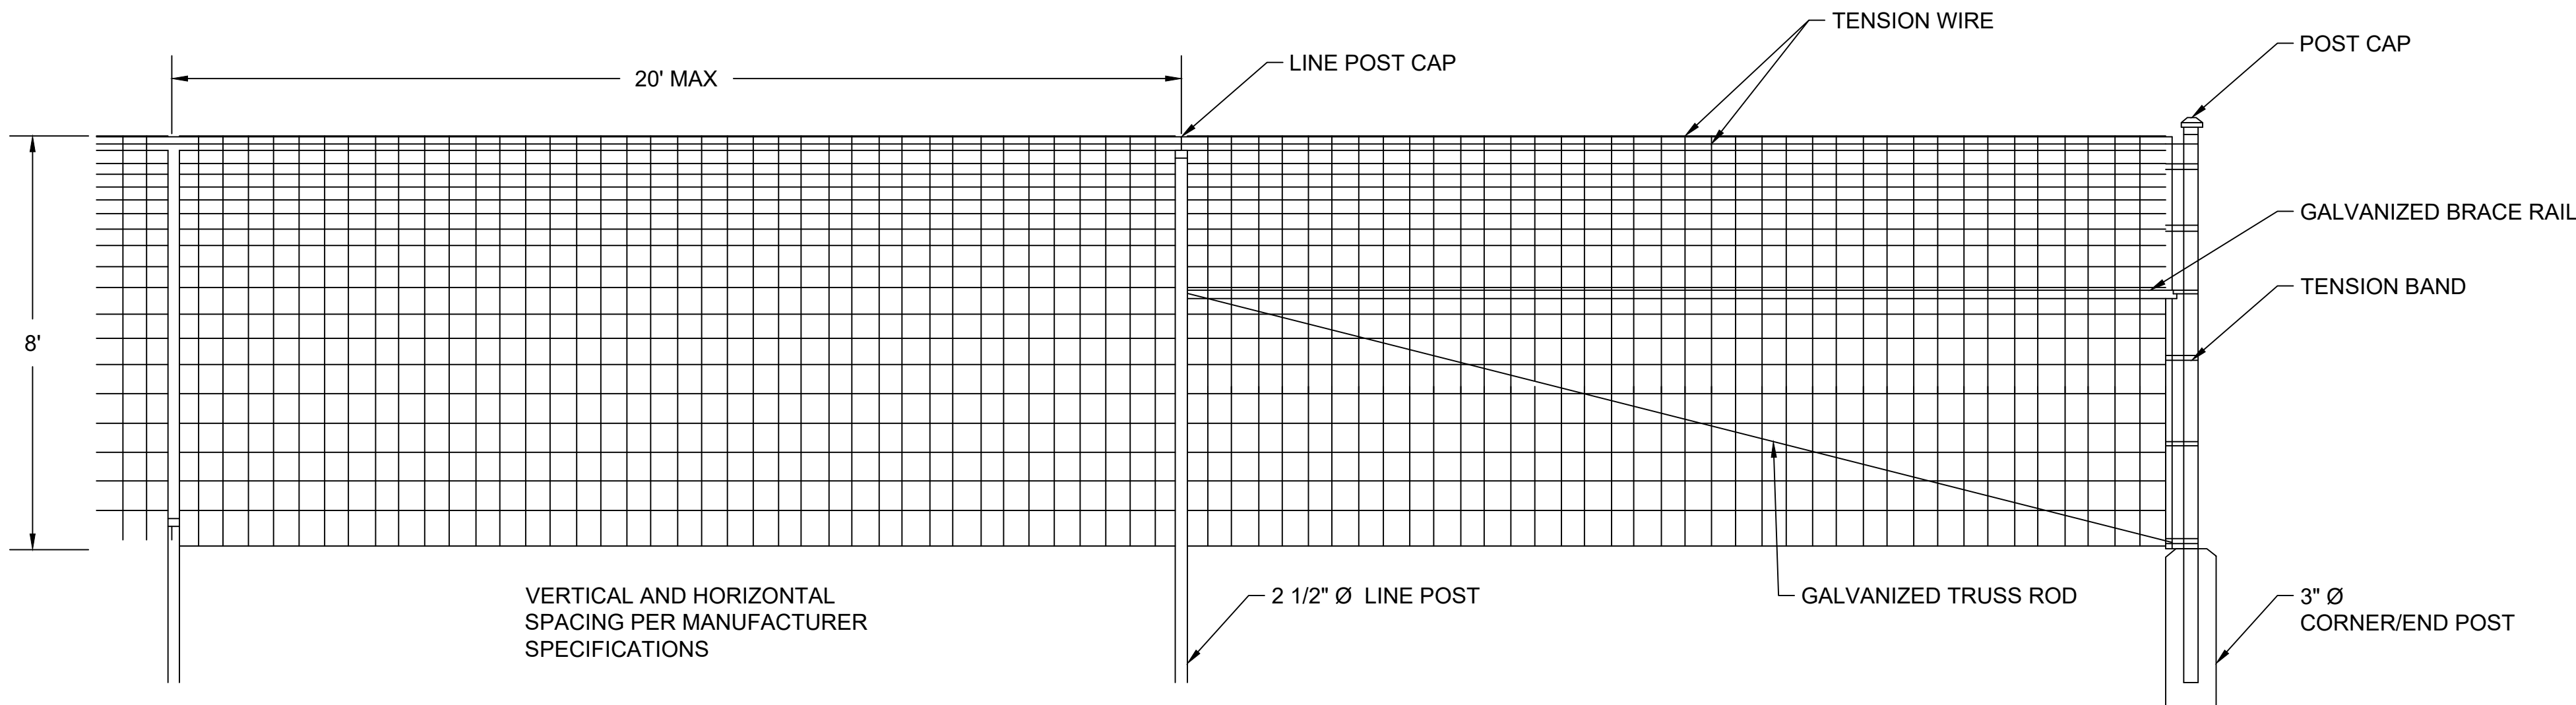

1 8' FIXED KNOT FENCE NTS

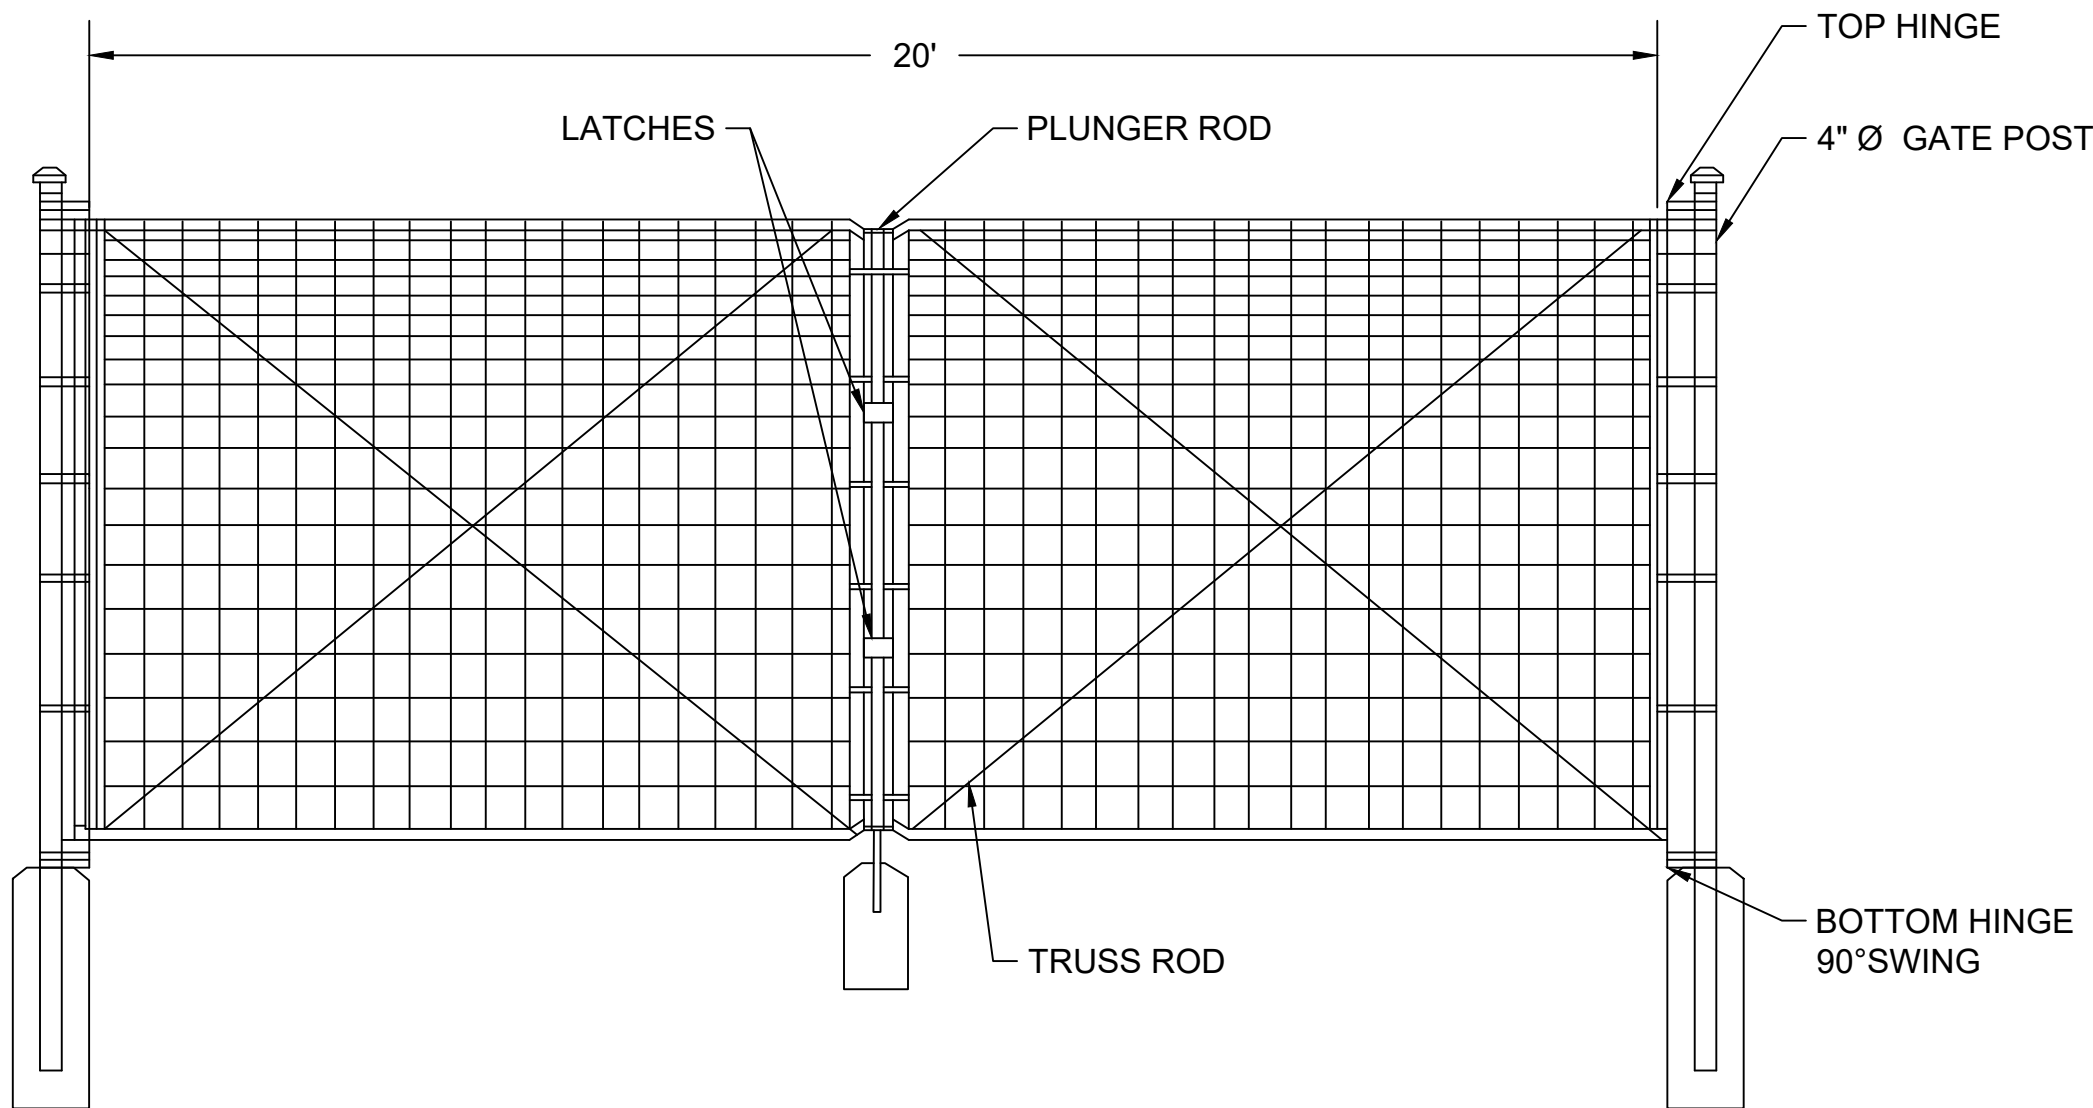

2 8' FIXED KNOT FENCE GATE NTS

NOTE:
1. THIS DRAWING IS FOR INFORMATIONAL PURPOSES ONLY
AND NOT TO BE USED FOR CONTRUCTION.
2. DO NOT SCALE DRAWING

SYSTEM SPECIFICATIONS

SYSTEM SIZE DC	1.503 MW
SYSTEM SIZE AC	POWER LIMITED TO 1.000 MW
DC/AC RATIO	1.503
AZIMUTH	180°
TILT	+/- 52°
MODULE COUNT	2592
MODULE TYPE	HANWA Q.PEAK DUO XL-G11.3_BFG - 580
MODULE STC RATING	580 W
INVERTER COUNT	9
INVERTER TYPE	SMA SUNNY HIGHPOWER PEAK-3 125kW
INVERTER POWER	POWER LIMITED TO 111.111kW
RACKING	TBD
MONITORING	ALSO ENERGY

DESIGN CRITERIA

MIN/MAX TEMP.	-26°C / 31°C
WIND SPEED (ASCE 7-10)	105 MPH
BUILDING CATEGORY	I
EXPOSURE CATEGORY	C
GROUND SNOW LOAD	50 PSF
BUILDING HEIGHT	0'-0"

OTHER NOTES

CASE NUMBER 05518220

NO POSITION, DISTANCE, OR CLEARANCE
ISSUES WITH OVERHEAD ELECTRIC
SERVICE LINES OR OTHER UTILITIES IN
RELATION TO THE PV PANELS.

24/7 UNESCORTED KEYLESS ACCESS
PROVIDED FOR ALL UTILITY ENERGY
EQUIPMENT INCLUDING THE METERS AND
AC DISCONNECT.

INTERCONNECTION TYPE: SECONDARY

REVISIONS

#	DESCRIPTION	BY	DATE
0	ORIGINAL DESIGN	SP	6/30/2023
1	REMOVED 1/2 MI FENCE TO FENCE SPACING INCREASE DC SIZE	NGA	7/5/2023
2	CUP PACKAGE	SP	2/9/2024
3	POLLINATOR BUFFER ADDITION	SP	2/20/2024
4	UPDATED WETLAND DELINATION	SP	6/4/2024
5	CUP RESUBMISSION	SP	7/18/2024
6			
7			
8			
9			
10			

PROJECT NAME

BOHREREAST CSG

DRAWING TITLE



INFILTRATION BASIN DETAIL

SCALE ¹

NTS


SHEET

PV11

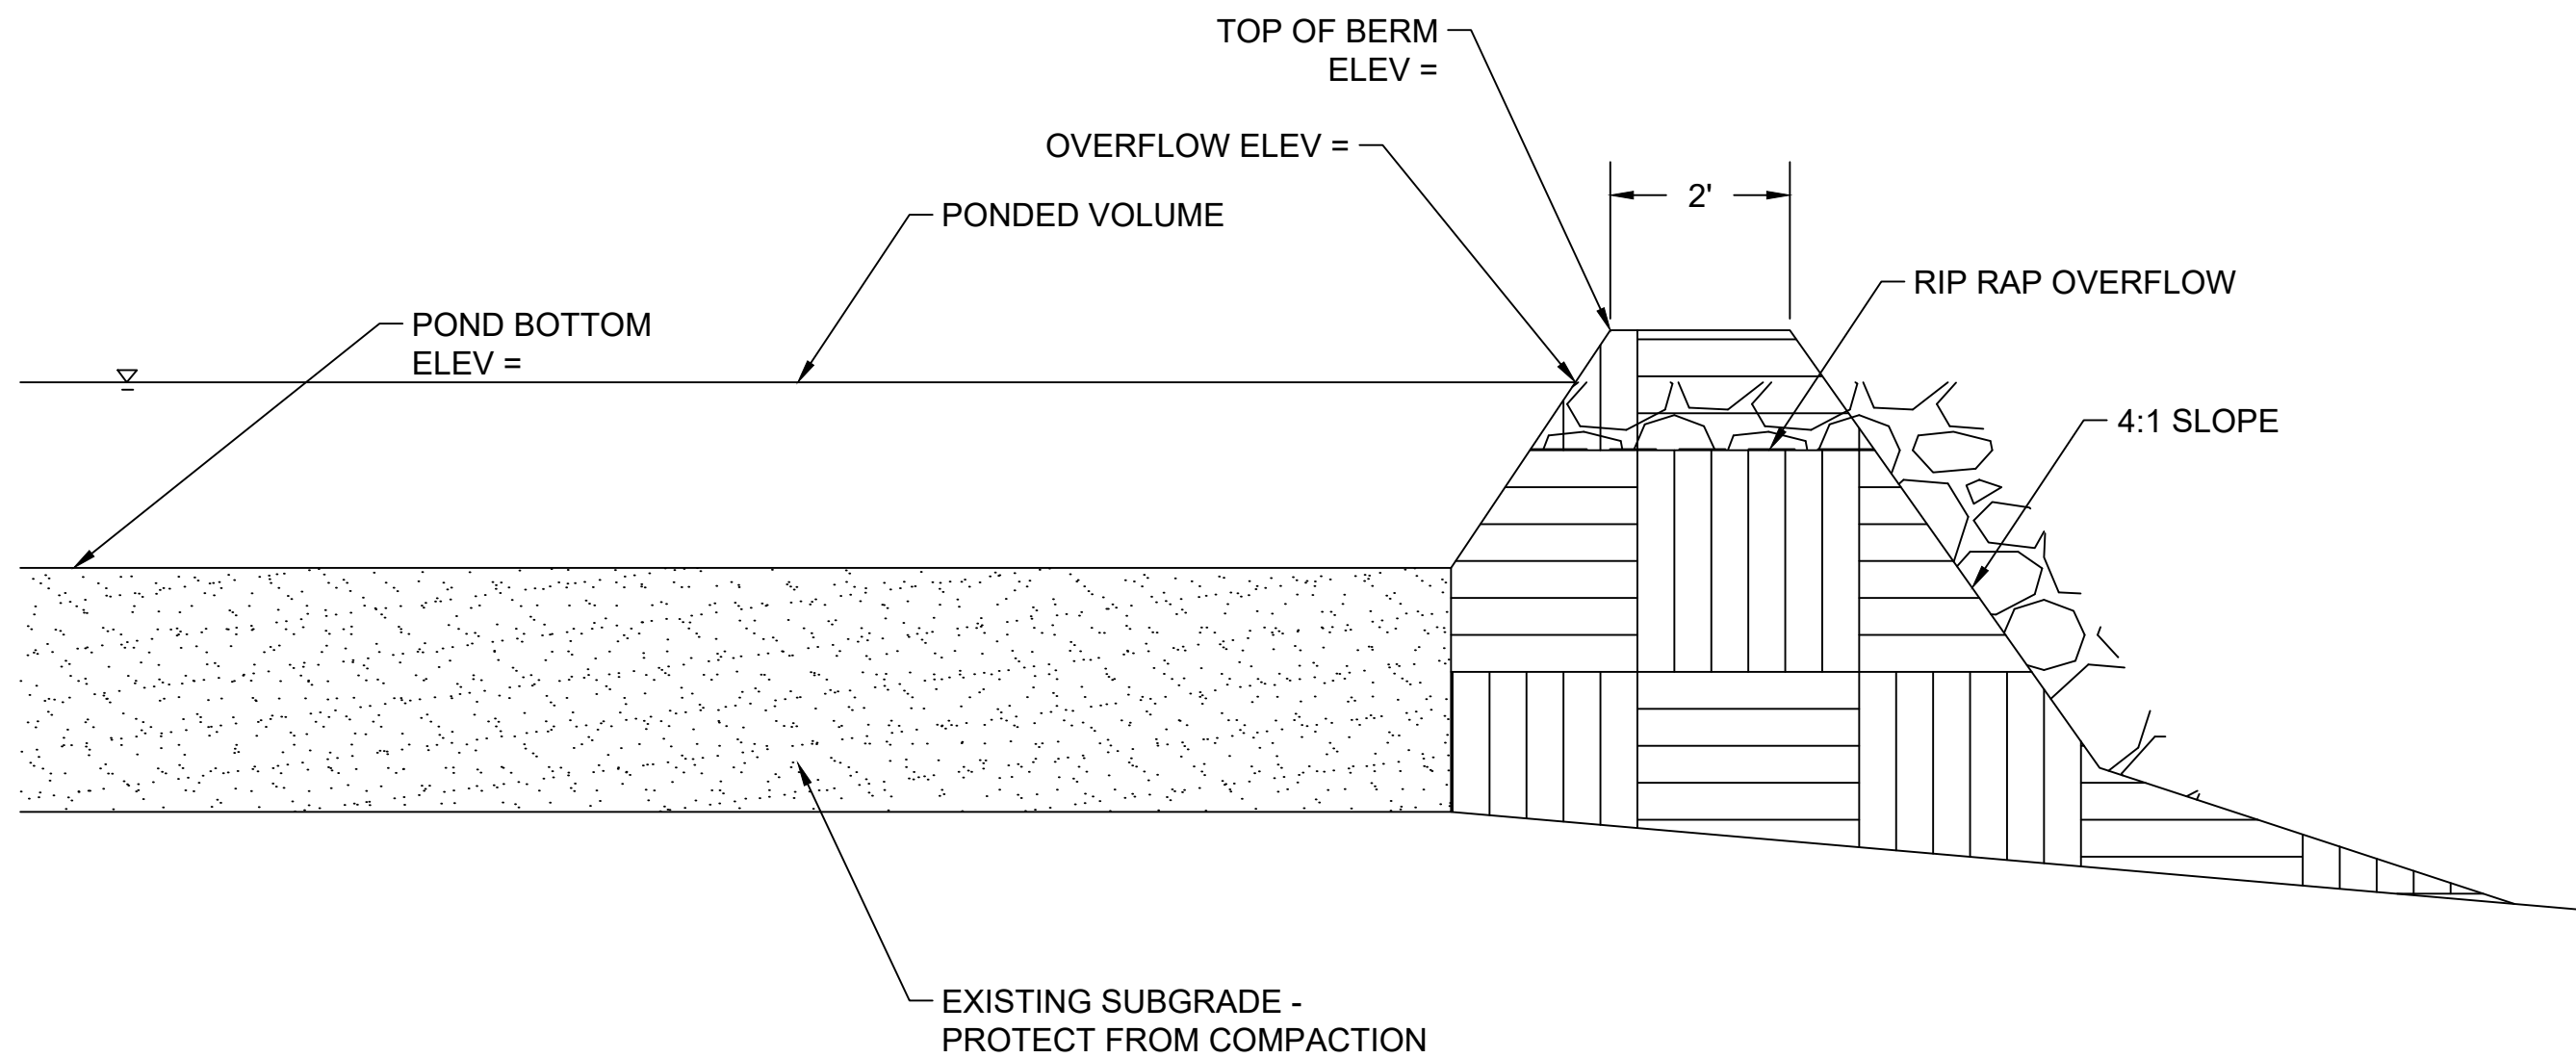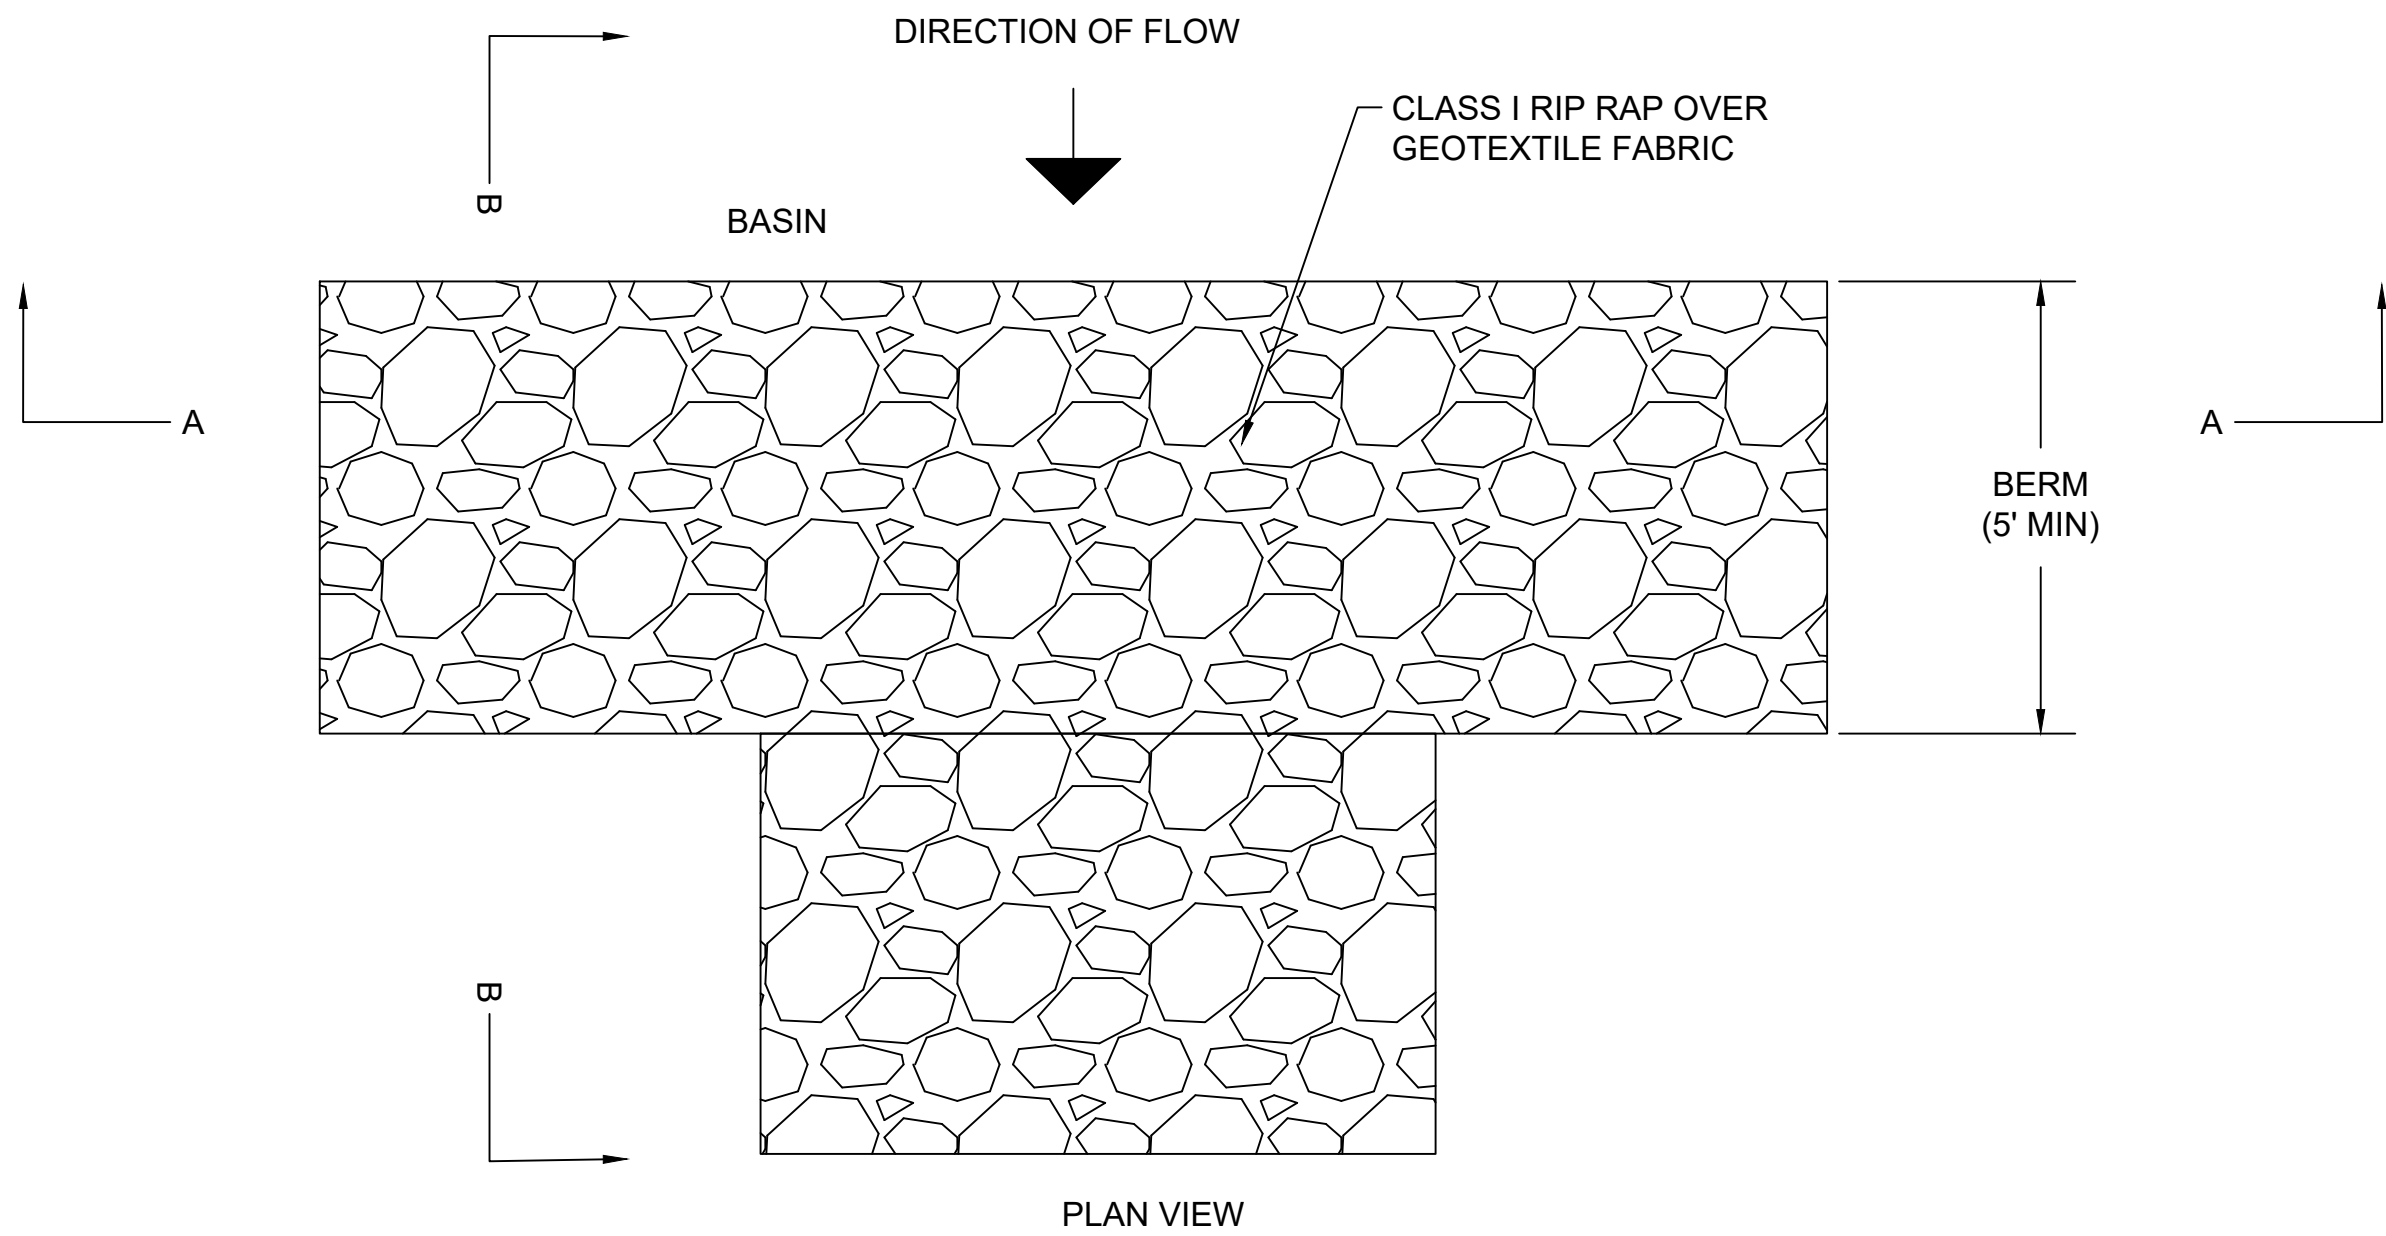


1 INFILTRATION BASIN

NTS

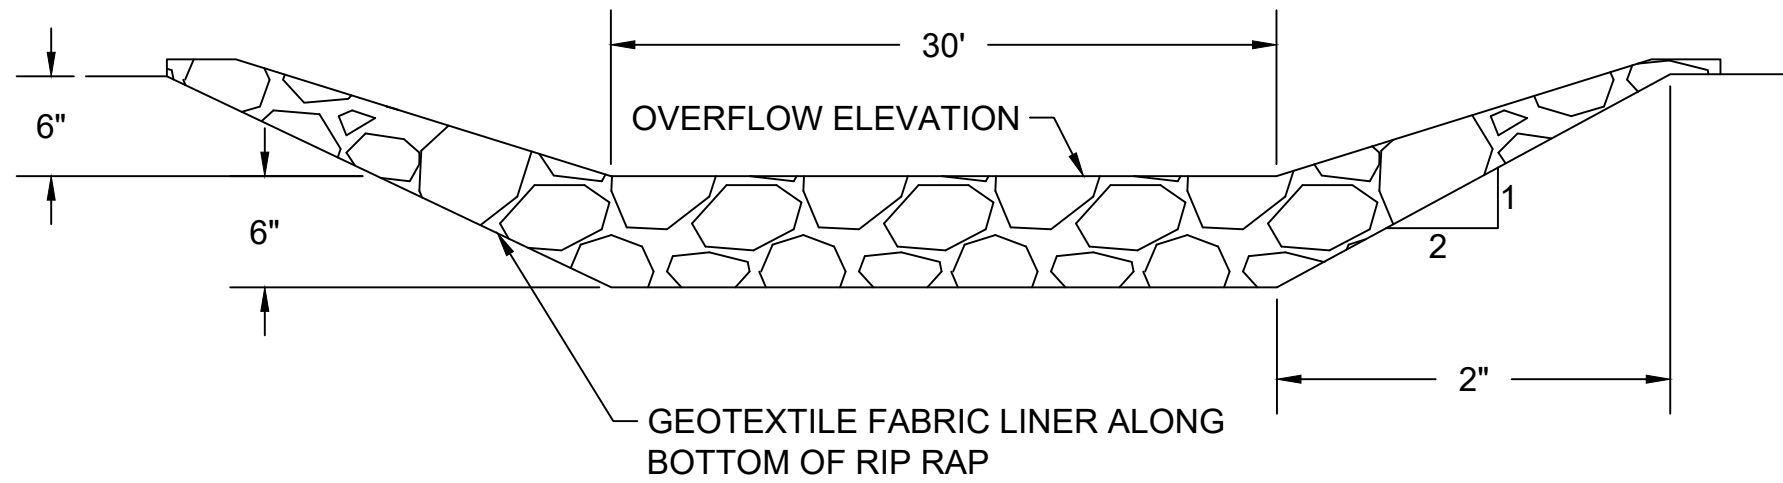


SECTION AA

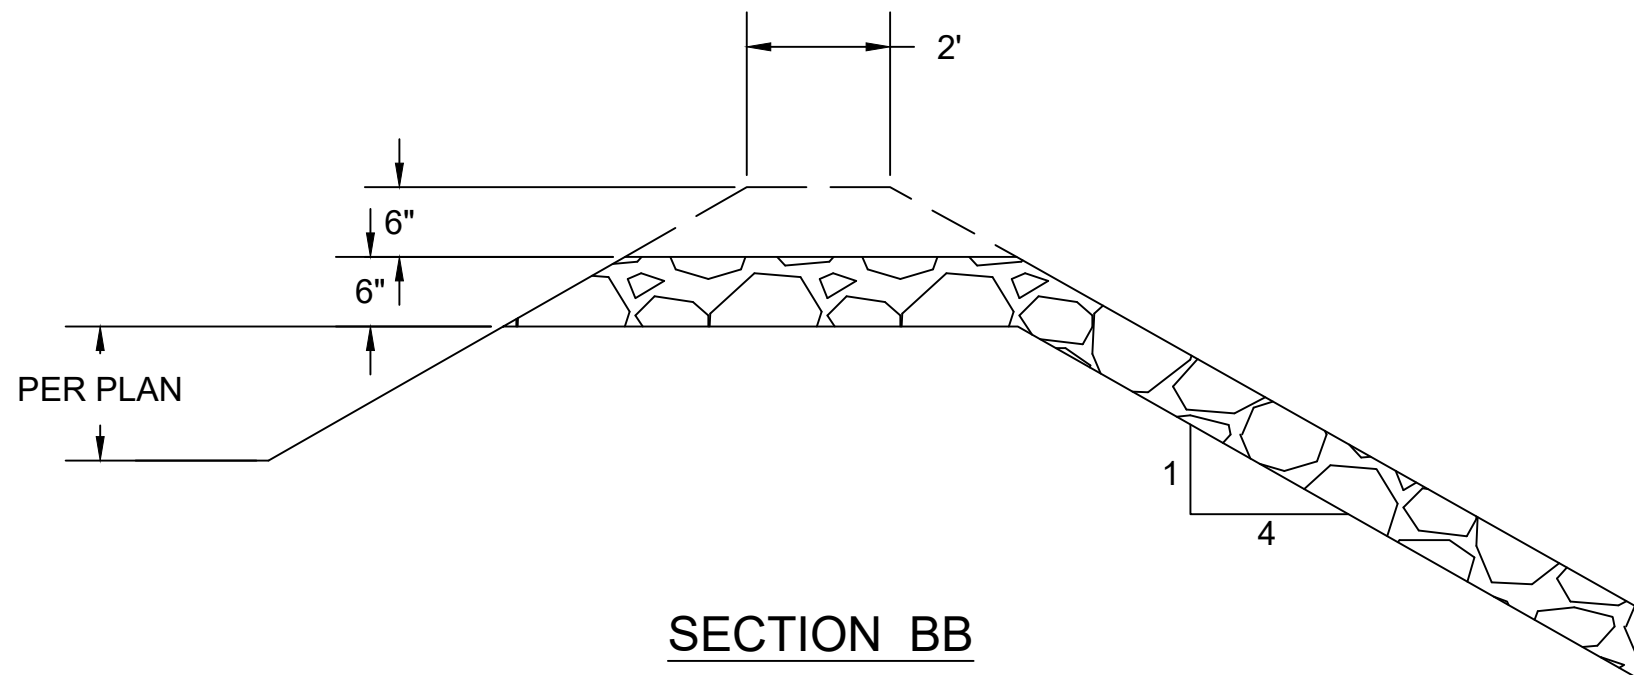

SECTION BB

2 RIP RAP OVERFLOW

NTS

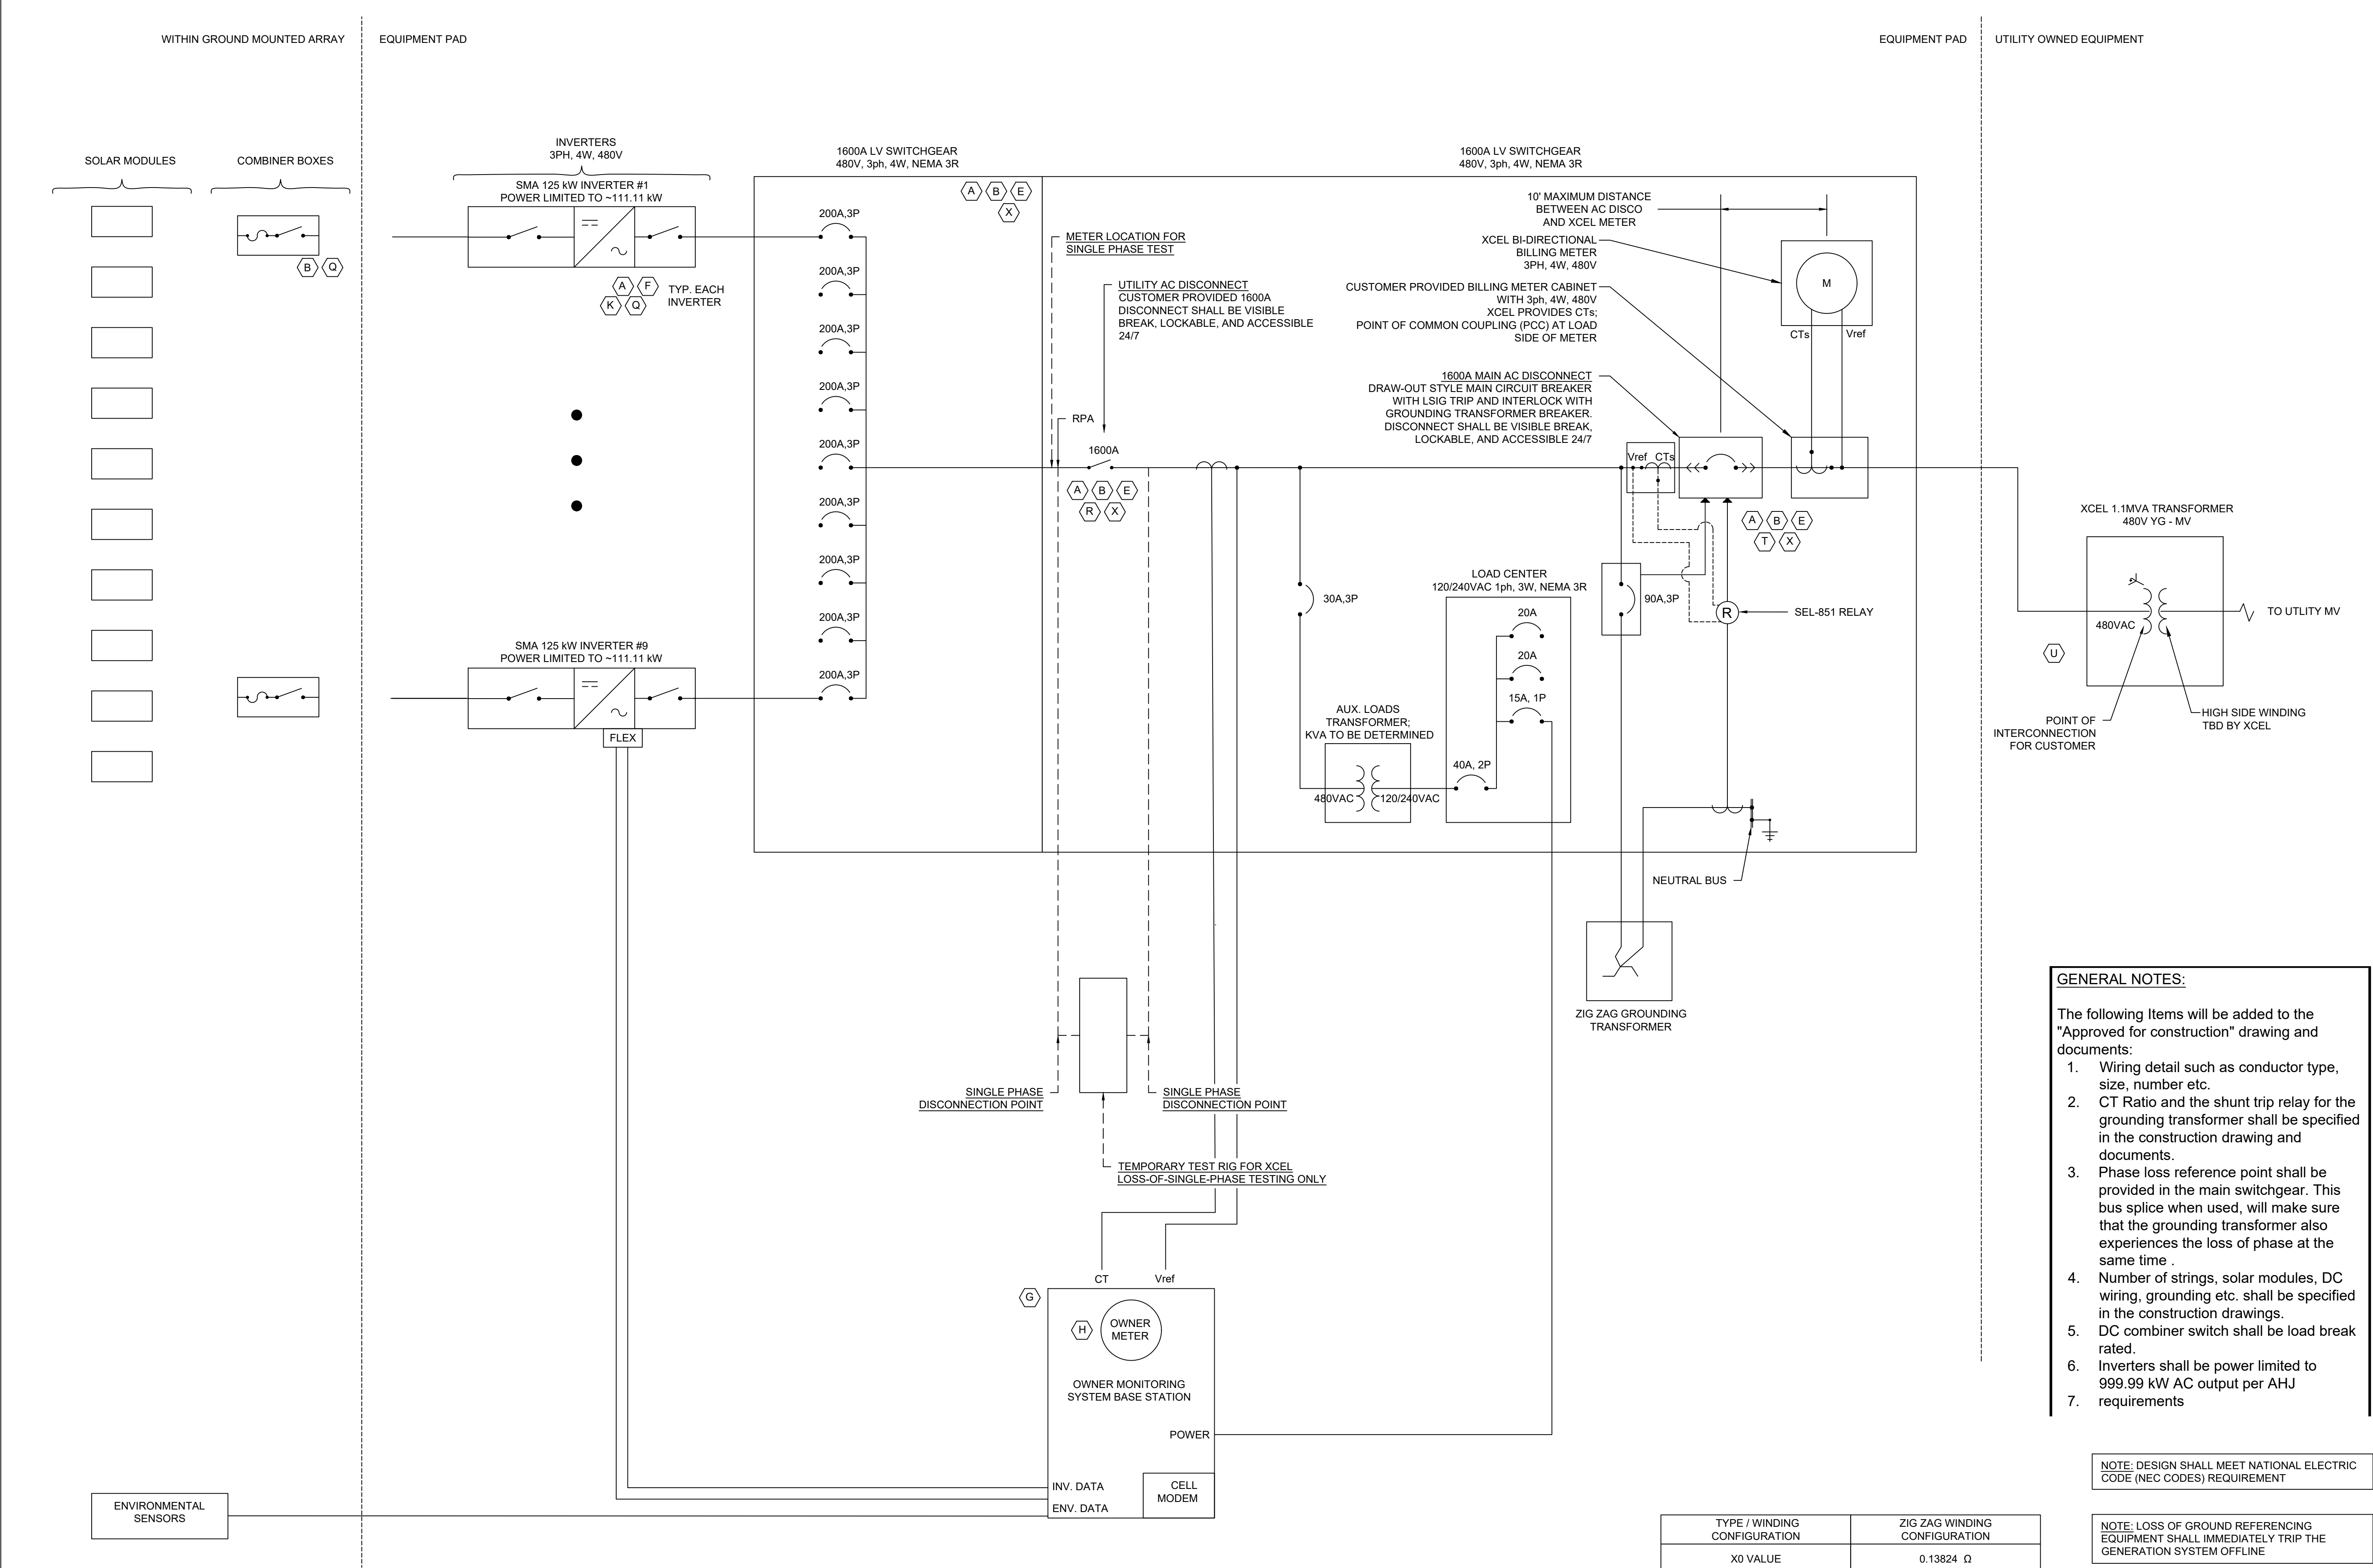

PROJECT ENTITY: MN CSG 2019-57 LLC

NEW ENERGY EQUITY, LLC
2530 RIVA ROAD, SUITE 200
ANNAPOLIS, MD 21041
NEWENERGYEQUITY.COM
443-267-5012

PROJECT ADDRESS
23759 THIRD AVE
MANKATO, MN 56001

LAT: 44.225
LONG: -93.979

SYSTEM SPECIFICATIONS

SYSTEM SIZE DC	1.503 MW
SYSTEM SIZE AC	POWER LIMITED TO 1.000 MW
DC/AC RATIO	1.503
AZIMUTH	180°
TILT	+/- 52°
MODULE COUNT	2592
MODULE TYPE	HANWA Q.PEAK DUO XL-G11.3_BFG - 580
MODULE STC RATING	580 W
INVERTER COUNT	9
INVERTER TYPE	SMA SUNNY HIGHPOWER PEAK-3 125kW
INVERTER POWER	POWER LIMITED TO 111.111kW
RACKING	TBD
MONITORING	ALSO ENERGY

DESIGN CRITERIA

MIN/MAX TEMP.	-26°C / 31°C
WIND SPEED (ASCE 7-10)	105 MPH
BUILDING CATEGORY	I
EXPOSURE CATEGORY	C
GROUND SNOW LOAD	50 PSF
BUILDING HEIGHT	0'-0"

OTHER NOTES

CASE NUMBER 05518220

NO POSITION, DISTANCE, OR CLEARANCE
ISSUES WITH OVERHEAD ELECTRIC
SERVICE LINES OR OTHER UTILITIES IN
RELATION TO THE PV PANELS.

24/7 UNESCORTED KEYLESS ACCESS
PROVIDED FOR ALL UTILITY ENERGY
EQUIPMENT INCLUDING THE METERS AND
AC DISCONNECT.

INTERCONNECTION TYPE: SECONDARY

REVISIONS

#	DESCRIPTION	BY	DATE
0	ORIGINAL DESIGN	SP	6/30/2023
1	REMOVED ½ MI FENCE TO FENCE SPACING INCREASE DC SIZE	NGA	7/5/2023
2	CUP PACKAGE	SP	2/9/2024
3	POLLINATOR BUFFER ADDITION	SP	2/20/2024
4	UPDATED WETLAND DELININATION	SP	6/4/2024
5	CUP RESUBMISSION	SP	7/18/2024
6			
7			
8			
9			
10			

PROJECT NAME

BOHREREAST CSG

DRAWING TITLE

SINGLE LINE


SCALE¹

NTS


SHEET

E1

W

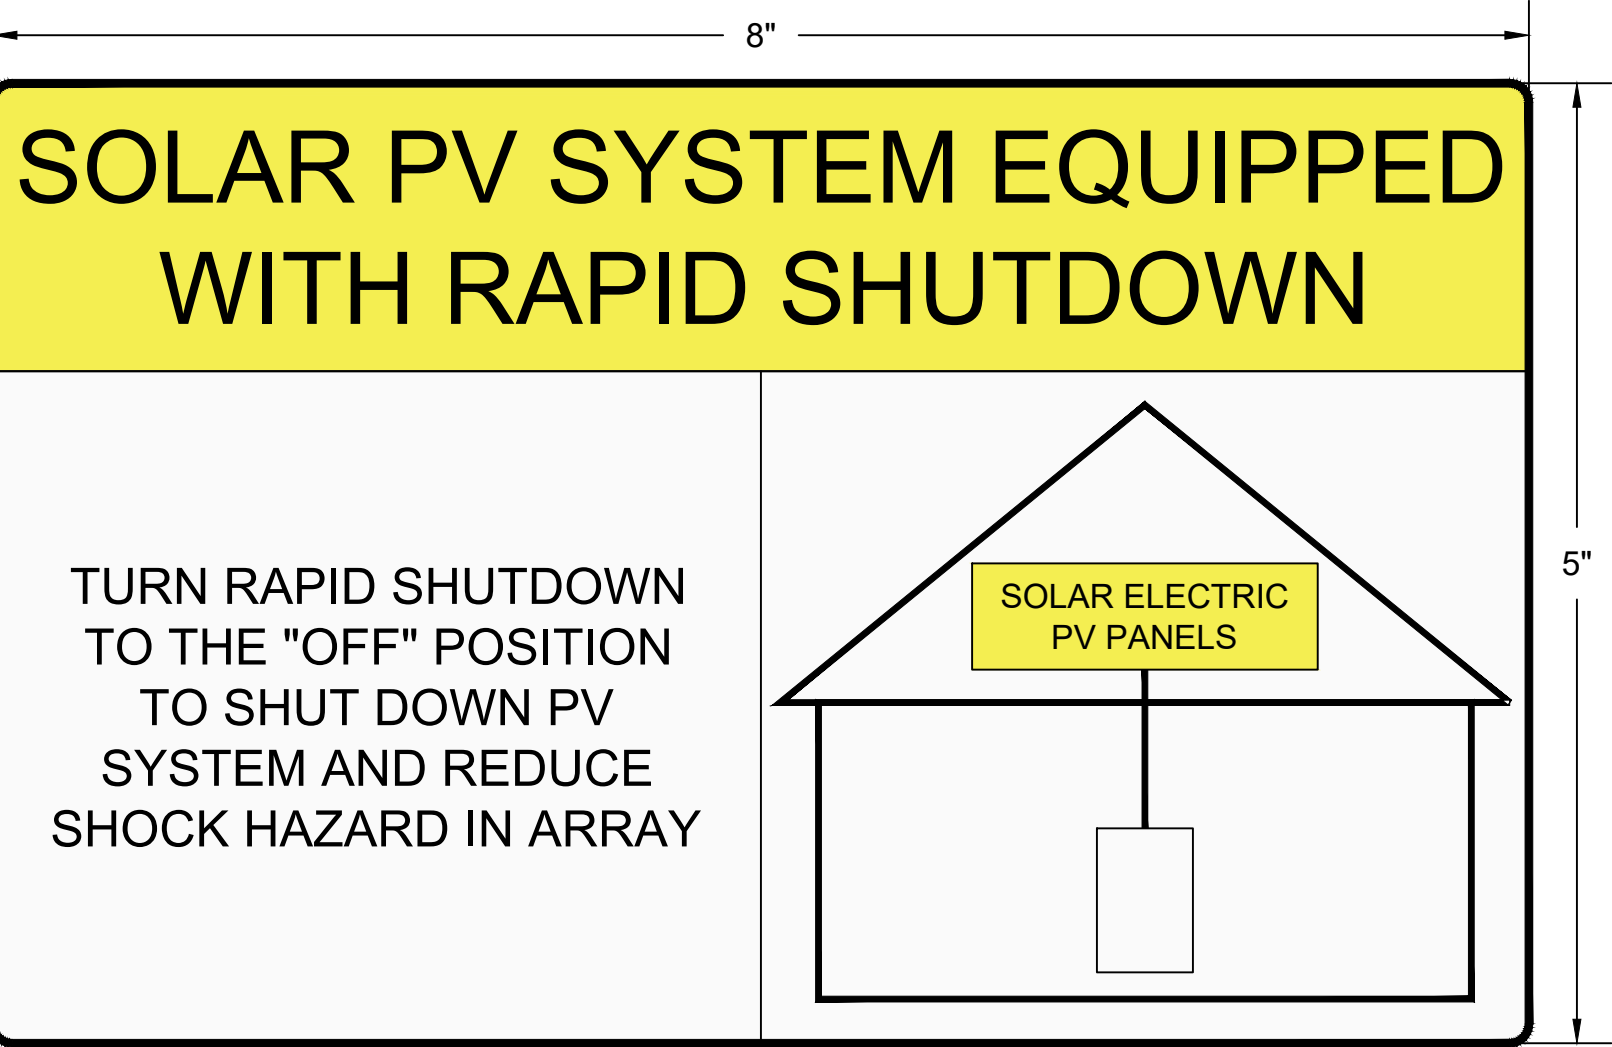

X

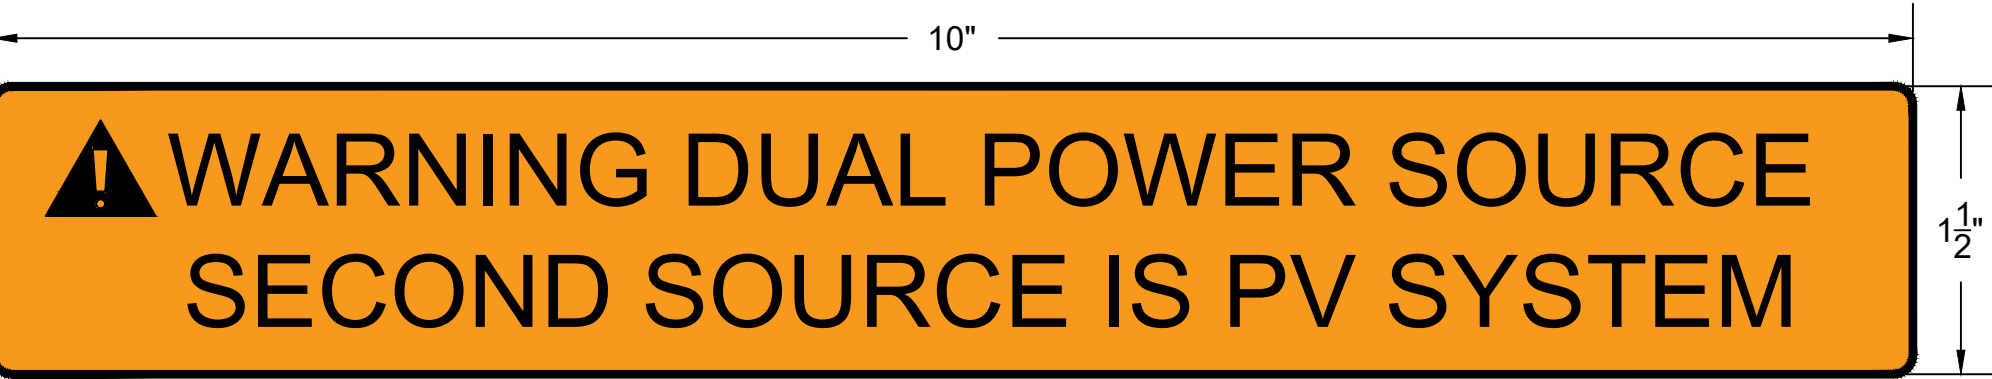

GENERAL NOTES:

- (1) ALL LABELS MUST COMPLY WITH 2020 NEC 110.21(B):
- (2) LABELS AS PROVIDED AND NOTED ON THIS SHEET MEET WARNING, EFFECTIVE WORDING AND COLOR/SYMBOL REQUIREMENTS
- (3) LABELS SHALL BE PERMANENTLY AFFIXED TO EQUIPMENT OR WIRING METHOD
- (4) LABELS SHALL BE OF SUFFICIENT DURABILITY TO WITHSTAND THE ENVIRONMENT INVOLVED. STICKERS OF PROPER DURABILITY AND ADHESION ARE PREFERRED. REFERENCE ANSI Z535.4-2011 FOR GUIDELINES.

SPECIFIC LABEL NOTES:

- A. 2020 NEC 690.13(D)
- B. 2020 NEC 110.16
- C. 2020 NEC 705.12(B)(1)(b)
- D. 2020 NEC 110.27(C)
- E. 2020 NEC 110.27(C)
- F. 2020 NEC 690.53
- G. UTILITY REQUIREMENT
- H. UTILITY REQUIREMENT
- I. LABEL REMOVED
- J. UTILITY REQUIREMENT
- K. 2020 NEC 690.54
- L. 2020 NEC 690.55
- M. LABEL FOR ACCUMULATION PANEL
- N. 2020 NEC 690.31(F)
- O. 2020 NEC 690.56(C)
- P. 2020 NEC 690.13(B)
- Q. 2020 NEC 690.13(B)
- R. 2020 NEC 690.54
- S. 2020 NEC 690.54
- T. 2020 NEC 690.13(B)
- U. LABEL FOR POINT OF INTERCONNECTION
- V. 2020 NEC 705.10 SYSTEM PLACCARD
- W. 2020 NEC 690.56(C)(1)
- X. 2020 NEC 690.59

EQUIPMENT	LABELS
ACCUMULATION PANELS, COMBINER BOXES, PULL BOXES, ENCLOSURES	A, B, E, M
DC CONDUIT	N
RAPID SHUTDOWN	O, W
ENERGY STORAGE	L
INVERTERS	K
MONITORING EQUIPMENT	G
METERS	H, J, X, Y
DC DISCONNECT	A, F, Q
AC DISCONNECT	A, B, E, O, P, R, S, T, X
POINT OF INTERCONNECTION	A, C, D, U, V, E



PROJECT ENTITY: MN CSG 2019-57 LLC

NEW ENERGY EQUITY, LLC
2530 RIVA ROAD, SUITE 200
ANNAPOLIS, MD 21041
NEWENERGYEQUITY.COM
443-267-5012

PROJECT ADDRESS
23759 THIRD AVE
MANKATO, MN 56001

LAT: 44.225
LONG: -93.979

SYSTEM SPECIFICATIONS

SYSTEM SIZE DC	1.503 MW
SYSTEM SIZE AC	POWER LIMITED TO 1.000 MW
DC/AC RATIO	1.503
AZIMUTH	180°
TILT	+/- 52°
MODULE COUNT	2592
MODULE TYPE	HANWA Q.PEAK DUO XL-G11.3_BFG - 580
MODULE STC RATING	580 W
INVERTER COUNT	9
INVERTER TYPE	SMA SUNNY HIGHPOWER PEAK-3 125kW
INVERTER POWER	POWER LIMITED TO 111.111kW
RACKING	TBD
MONITORING	ALSO ENERGY

DESIGN CRITERIA

MIN/MAX TEMP.	-26°C / 31°C
WIND SPEED (ASCE 7-10)	105 MPH
BUILDING CATEGORY	I
EXPOSURE CATEGORY	C
GROUND SNOW LOAD	50 PSF
BUILDING HEIGHT	0'-0"

OTHER NOTES

CASE NUMBER 05518220

NO POSITION, DISTANCE, OR CLEARANCE ISSUES WITH OVERHEAD ELECTRIC SERVICE LINES OR OTHER UTILITIES IN RELATION TO THE PV PANELS.

24/7 UNESCORTED KEYLESS ACCESS PROVIDED FOR ALL UTILITY ENERGY EQUIPMENT INCLUDING THE METERS AND AC DISCONNECT.

INTERCONNECTION TYPE: SECONDARY

REVISIONS

#	DESCRIPTION	BY	DATE
0	ORIGINAL DESIGN	SP	6/30/2023
1	REMOVED 1/2 MI FENCE TO FENCE SPACING INCREASE DC SIZE	NGA	7/5/2023
2	CUP PACKAGE	SP	2/9/2024
3	POLLINATOR BUFFER ADDITION	SP	2/20/2024
4	UPDATED WETLAND DELINIATION	SP	6/4/2024
5	CUP RESUBMISSION	SP	7/18/2024
6			
7			
8			
9			
10			

PROJECT NAME

BOHREREAST CSG

DRAWING TITLE

SYSTEM LABELS B

SCALE¹

NTS

SHEET

E2B

SYSTEM SPECIFICATIONS

SYSTEM SIZE DC	1.503 MW
SYSTEM SIZE AC	POWER LIMITED TO 1.000 MW
DC/AC RATIO	1.503
AZIMUTH	180°
TILT	+/- 52°
MODULE COUNT	2592
MODULE TYPE	HANWA Q.PEAK DUO XL-G11.3.BFG - 580
MODULE STC RATING	580 W
INVERTER COUNT	9
INVERTER TYPE	SMA SUNNY HIGHPOWER PEAK-3 125kW
INVERTER POWER	POWER LIMITED TO 111.111kW
RACKING	TBD
MONITORING	ALSO ENERGY

DESIGN CRITERIA

MIN/MAX TEMP.	-26°C / 31°C
WIND SPEED (ASCE 7-10)	105 MPH
BUILDING CATEGORY	I
EXPOSURE CATEGORY	C
GROUND SNOW LOAD	50 PSF
BUILDING HEIGHT	0'-0"

OTHER NOTES

CASE NUMBER 05518220

NO POSITION, DISTANCE, OR CLEARANCE
ISSUES WITH OVERHEAD ELECTRIC
SERVICE LINES OR OTHER UTILITIES IN
RELATION TO THE PV PANELS.

24/7 UNESCORTED KEYLESS ACCESS
PROVIDED FOR ALL UTILITY ENERGY
EQUIPMENT INCLUDING THE METERS AND
AC DISCONNECT.

INTERCONNECTION TYPE: SECONDARY

REVISIONS

#	DESCRIPTION	BY	DATE
0	ORIGINAL DESIGN	SP	6/30/2023
1	REMOVED 1/2 MI FENCE TO FENCE SPACING INCREASE DC SIZE	NGA	7/5/2023
2	CUP PACKAGE	SP	2/9/2024
3	POLLINATOR BUFFER ADDITION	SP	2/20/2024
4	UPDATED WETLAND DELININATION	SP	6/4/2024
5	CUP RESUBMISSION	SP	7/18/2024
6			
7			
8			
9			
10			

PROJECT NAME

BOHREREAST CSG

DRAWING TITLE

ELECTRICAL DETAILS

SCALE ¹


AS NOTED

SHEET

E3


SHEET NOTES:

- Overhead line to underground service
conductors detail - provided by utility
- Fence Detail and Fence Grounding -
provided in the civil engineering
drawings

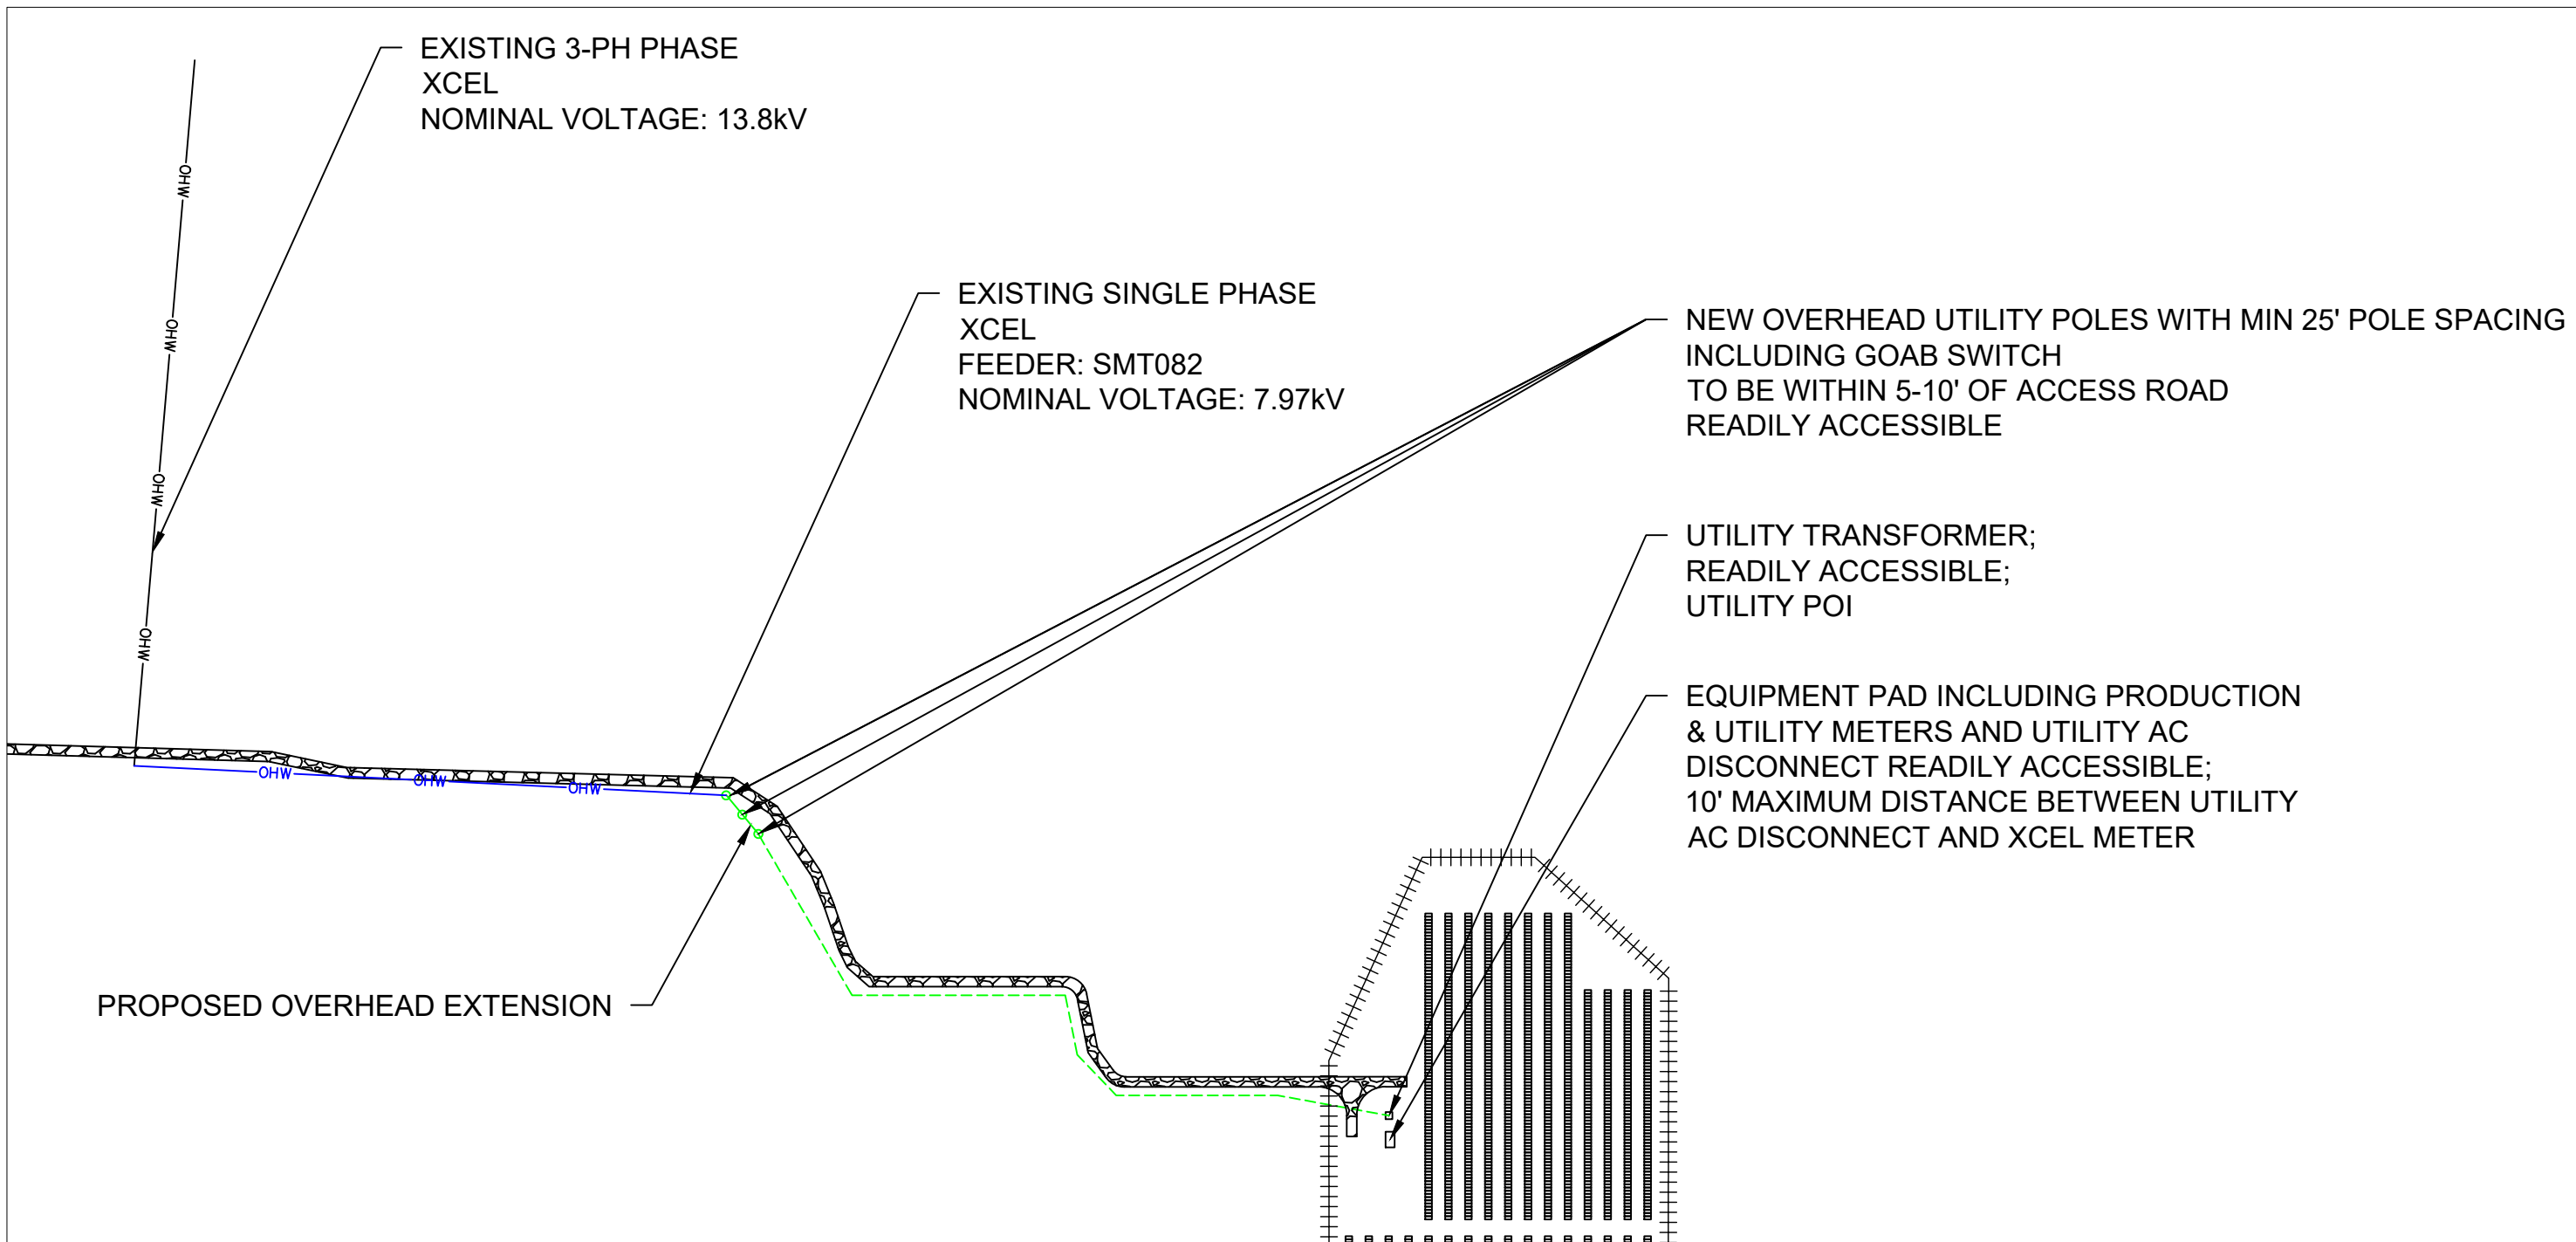

1 INTERCONNECTION PLAN


Scale: 1" = 200'

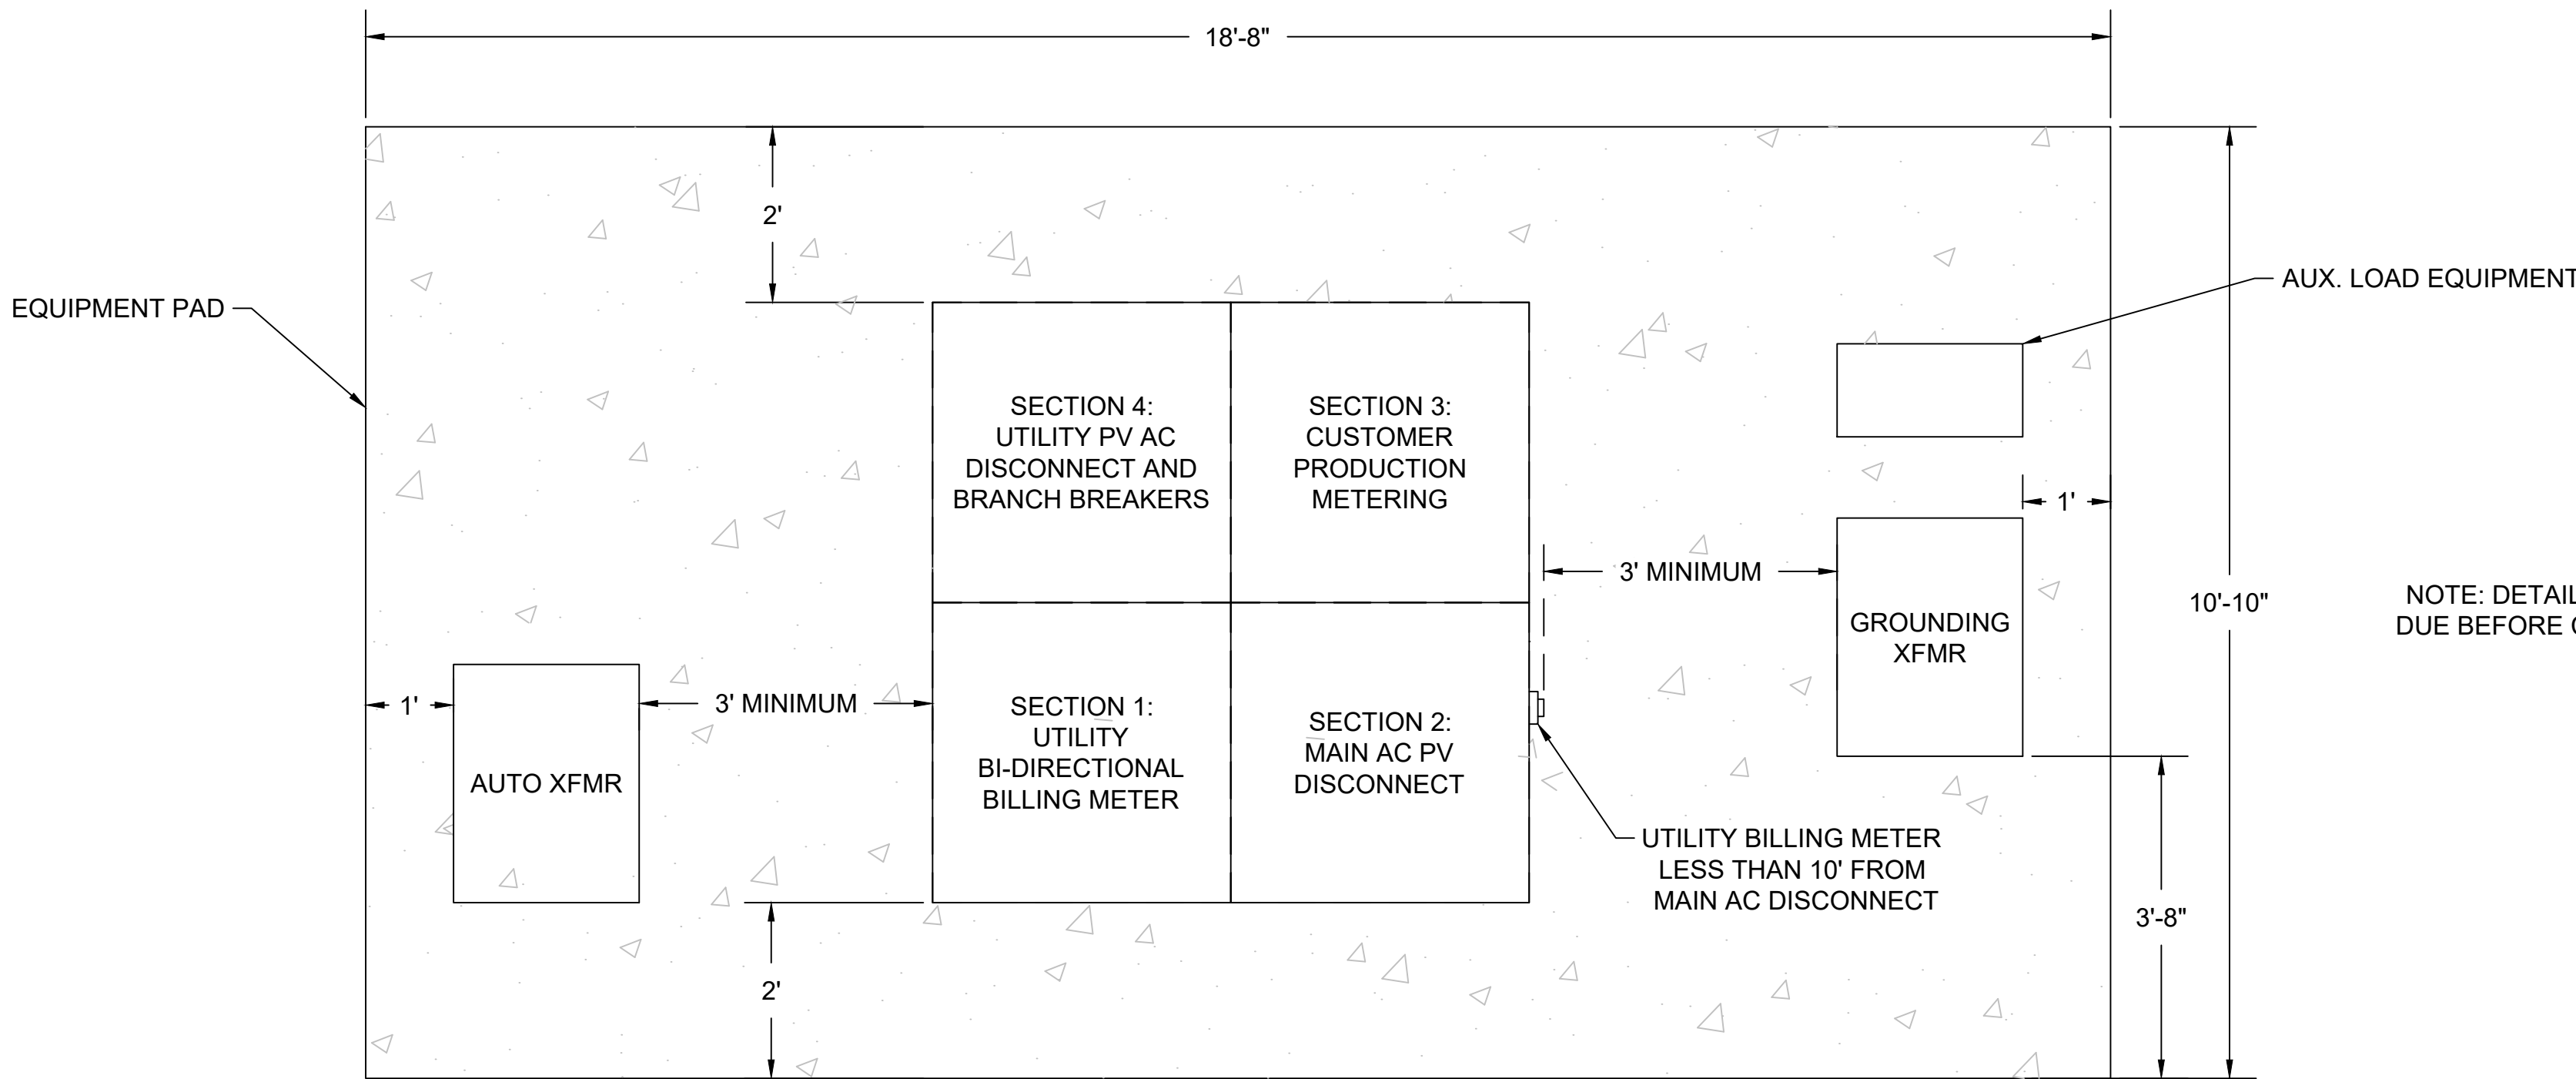

2 EQUIPMENT PAD PLAN

Scale: 3/4" = 1'

SEPARATE EQUIPMENT
PAD FOR UTILITY
OWNED
TRANSFORMER

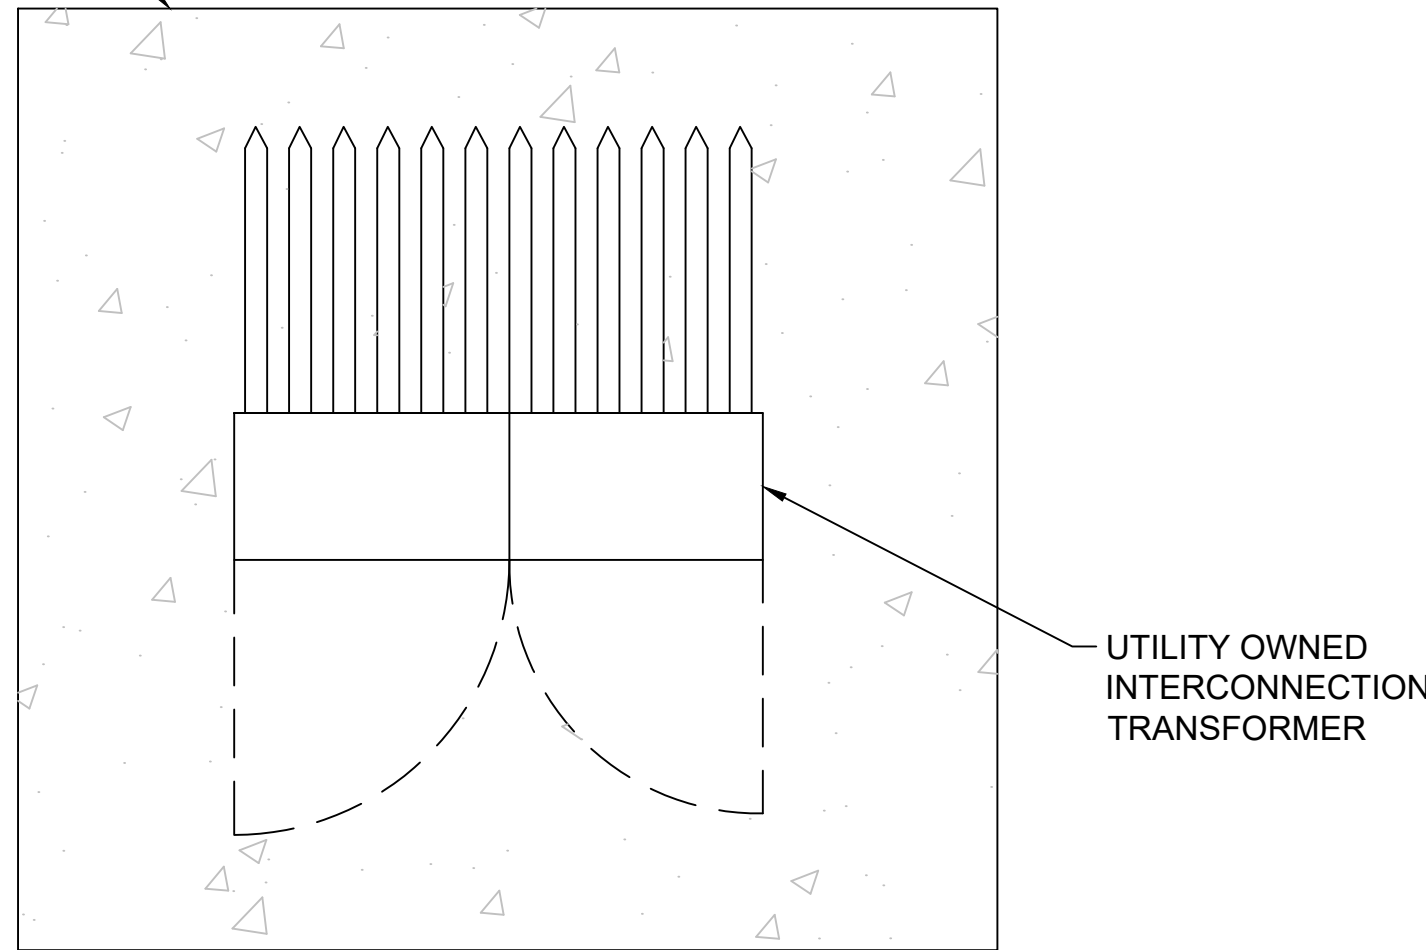

SPACE FOR PE STAMP: