
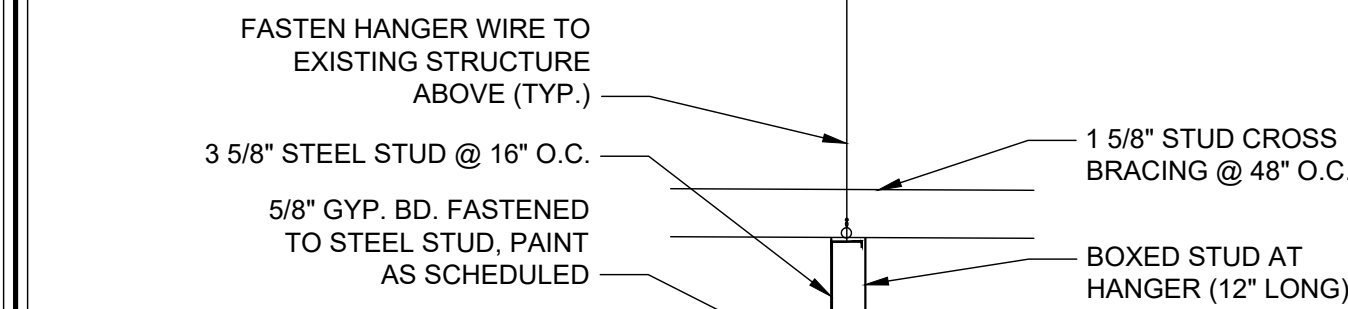
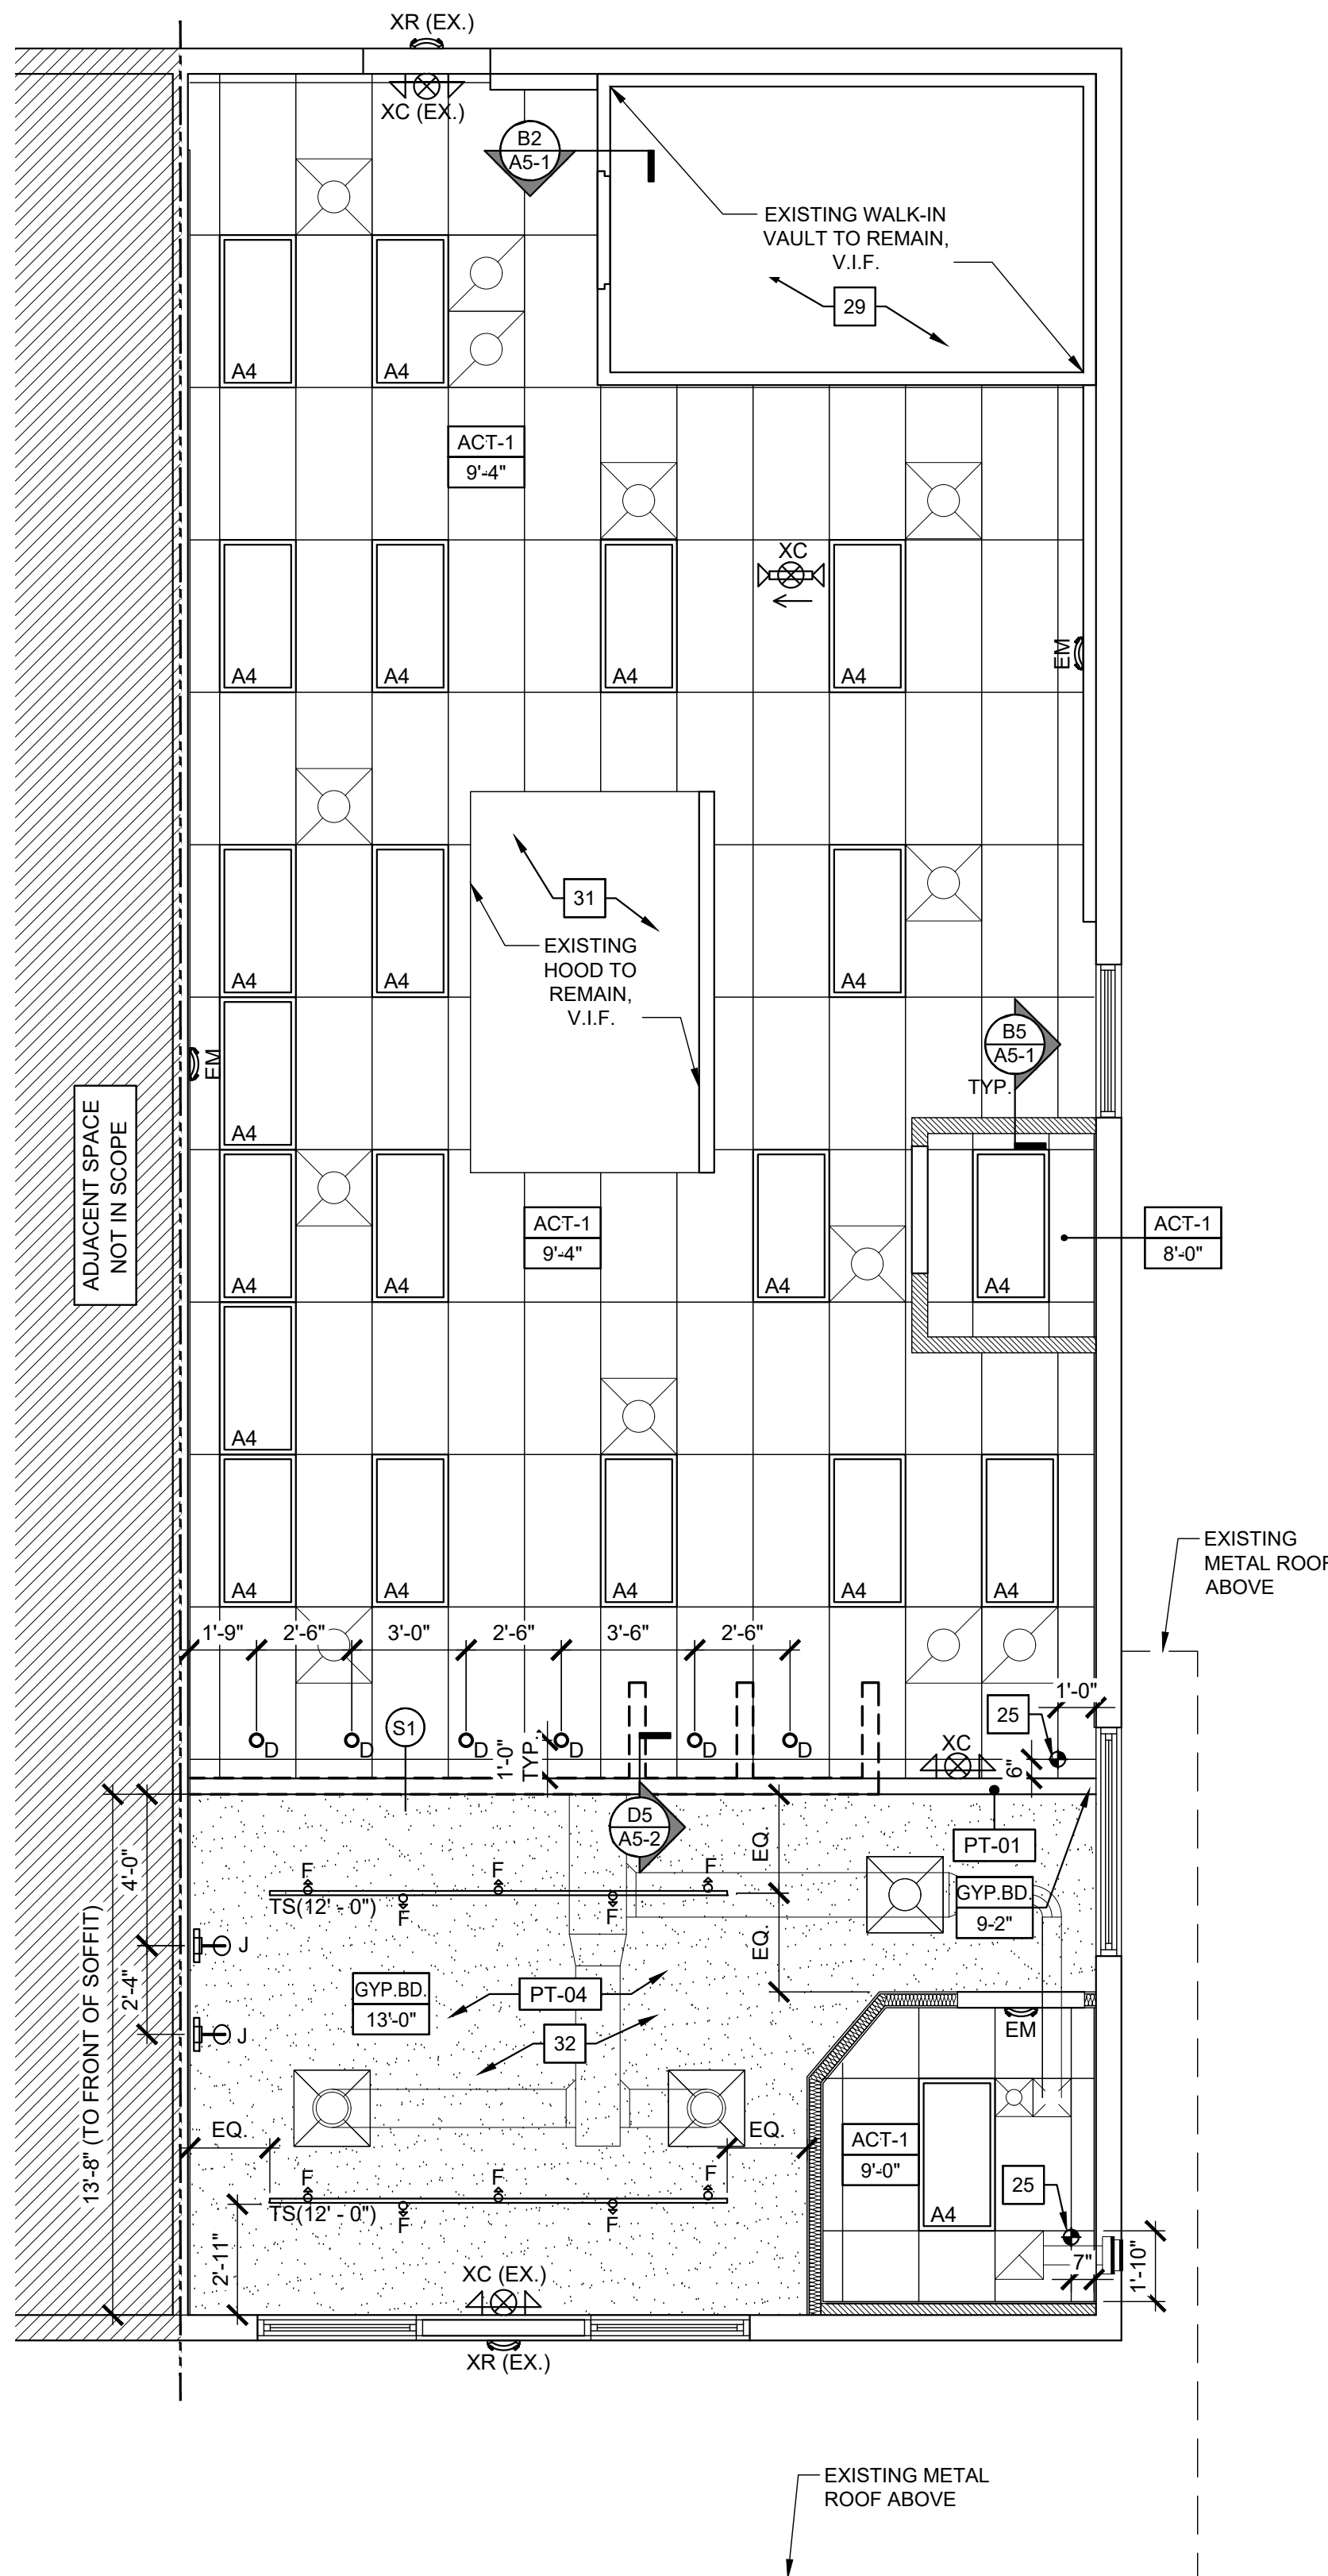


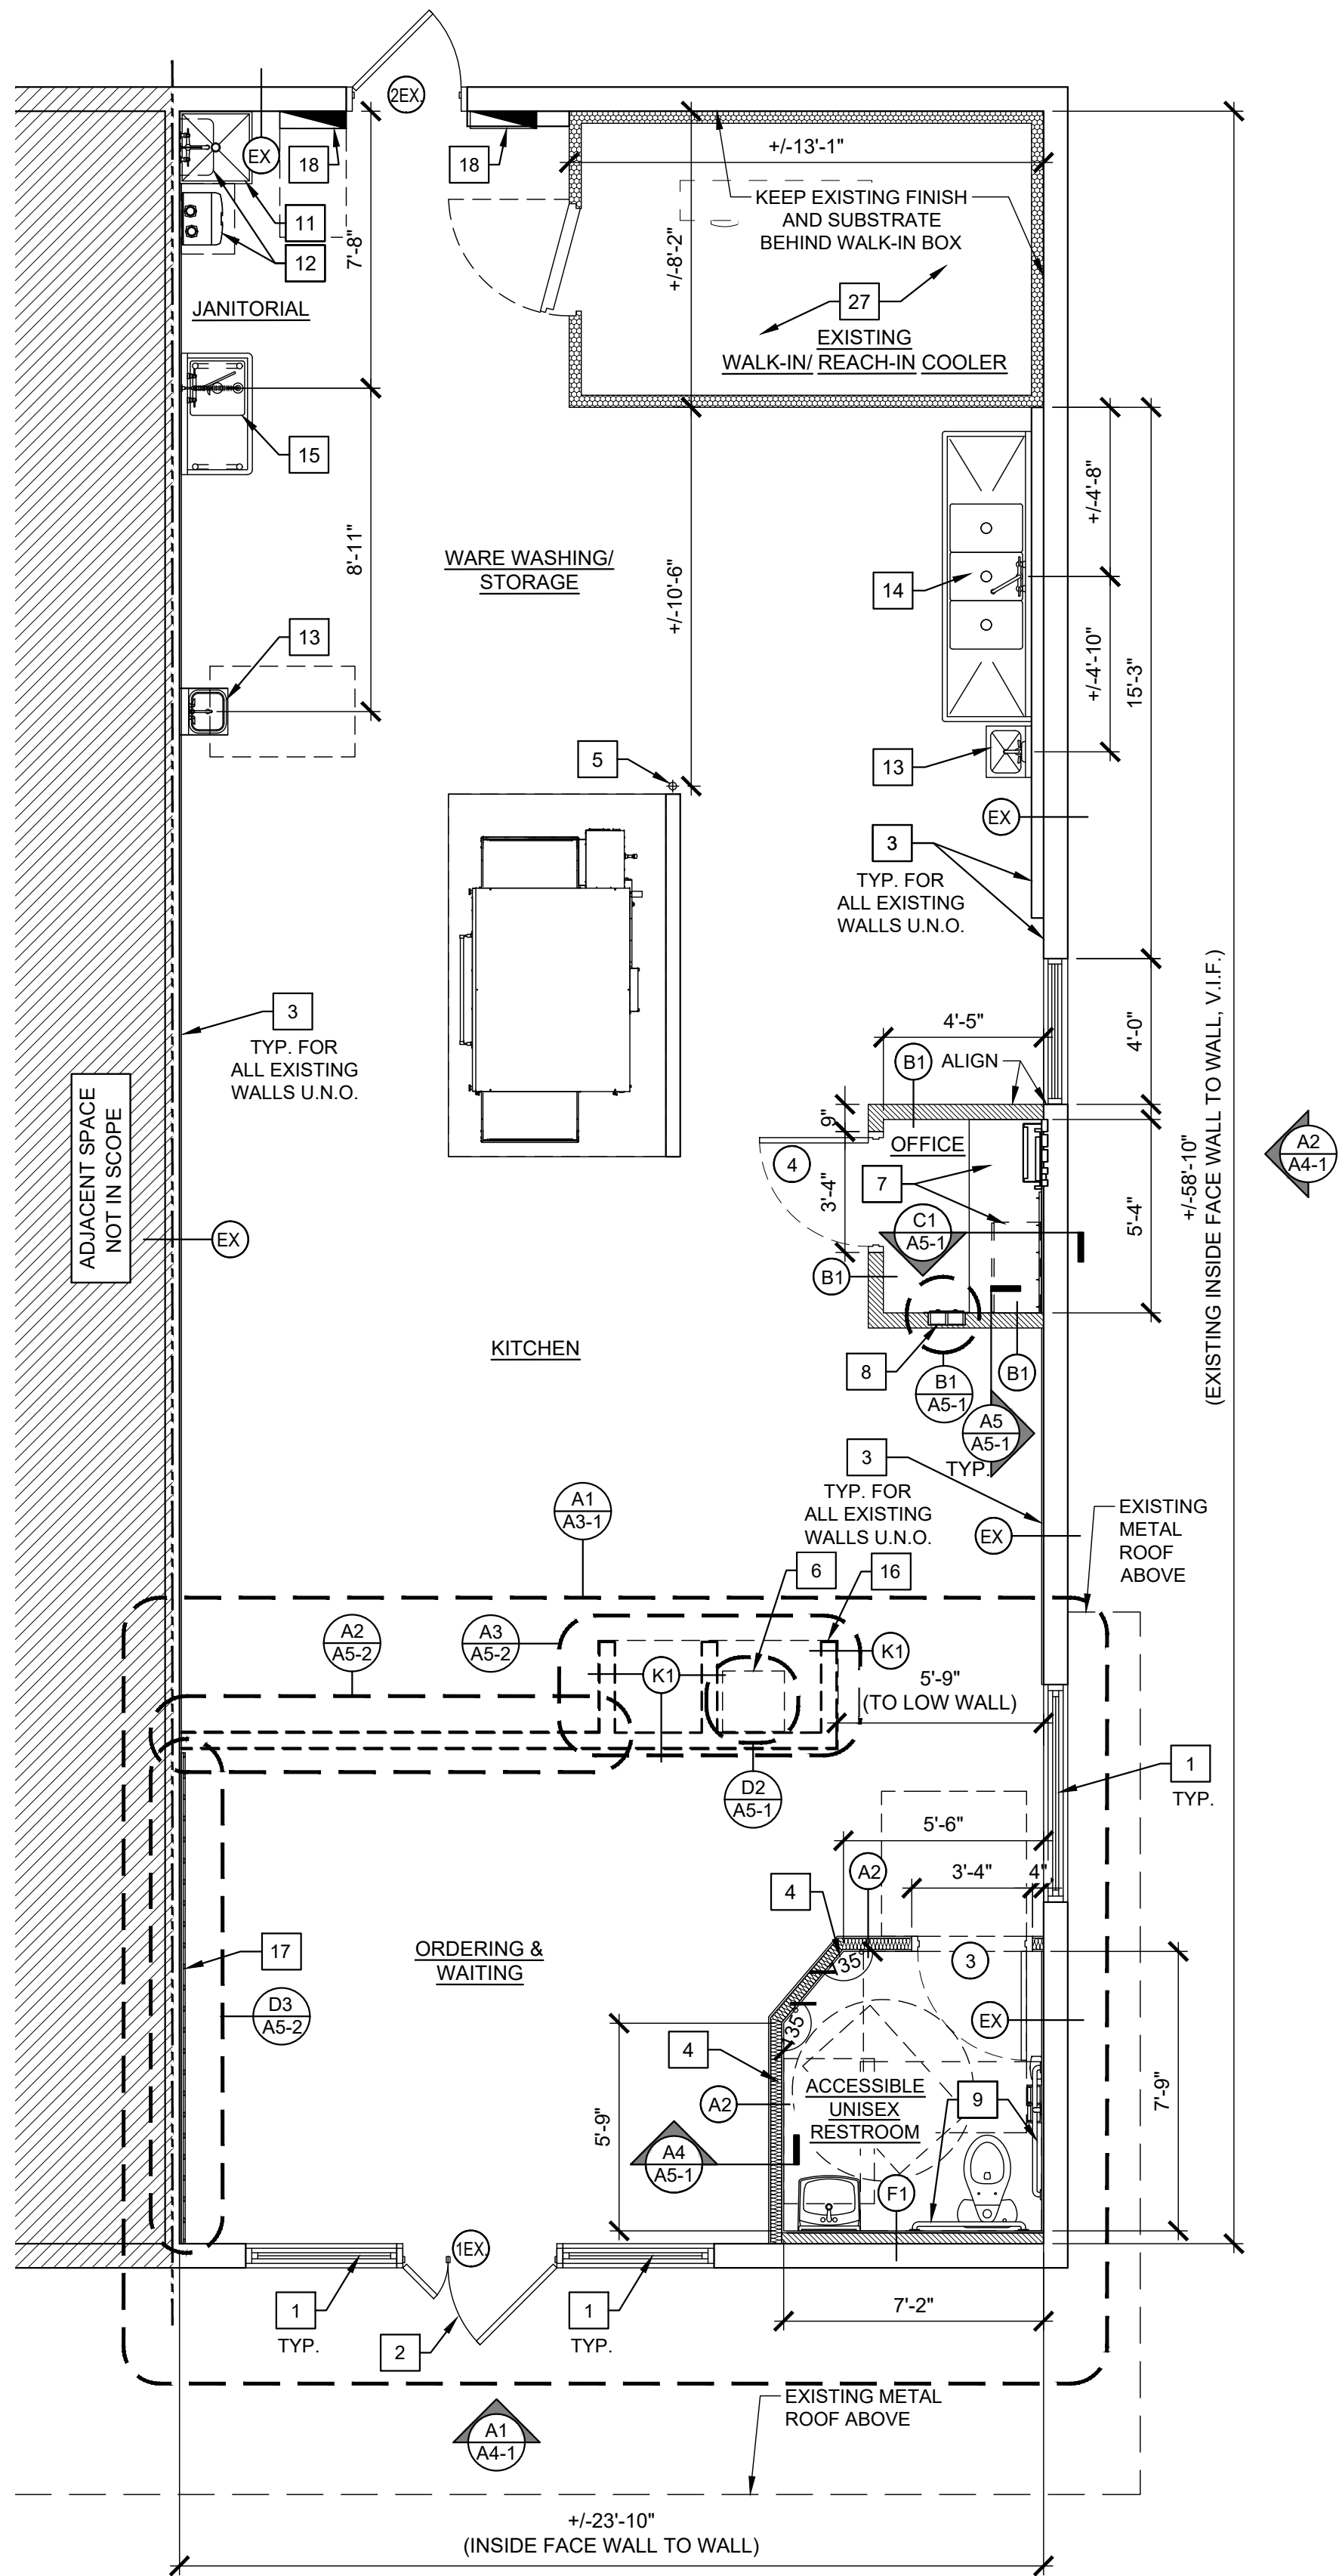

3 GYP.BD. CEILING DETAIL

SCALE: 1 1/2" = 1'-0"

RCP LEGEND

	NEW HVAC CEILING MOUNTED SUPPLY DIFFUSER. REFER TO MECHANICAL DRAWINGS		DIRECTIONAL CEILING MOUNTED EXIT/ EMERGENCY LIGHT. REFER TO ELECTRICAL DRAWINGS
	NEW HVAC CEILING MOUNTED RETURN DIFFUSER. REFER TO MECHANICAL DRAWINGS		WALL MOUNT EMERGENCY LIGHT. REFER TO ELECTRICAL DRAWINGS
	NEW HVAC CEILING MOUNTED EXHAUST FAN. REFER TO MECHANICAL DRAWINGS		EXTERIOR EXIT/ EMERGENCY LIGHT. REFER TO ELECTRICAL DRAWINGS
	EXIT/ EMERGENCY LIGHT. REFER TO ELECTRICAL DRAWINGS		2x4 LED LIGHT FIXTURE REF. ELECTRICAL REFER TO ELECTRICAL DRAWINGS
	DIRECTIONAL WALL MOUNTED EXIT/ EMERGENCY LIGHT. REFER TO ELECTRICAL DRAWINGS		DOWNLIGHT RECESSED LIGHT FIXTURE. REFER TO ELECTRICAL DRAWINGS
	CEILING MOUNTED EXIT/ EMERGENCY LIGHT. REFER TO ELECTRICAL DRAWINGS		WALL SCONCE LIGHT FIXTURE. REFER TO ELECTRICAL DRAWINGS
			LIGHTING TRACK. REFER TO ELECTRICAL DRAWINGS

LIGHTING VARIES. REFER TO LIGHTING FIXTURE TAG AND SCHEDULE BELOW

KEY NOTES - FLOOR PLAN & REFLECTED CEILING PLAN

- EXISTING STOREFRONT WINDOWS TO REMAIN.
- EXISTING ENTRANCE STOREFRONT DOOR IN EXISTING MULLION/FRAME SYSTEM TO REMAIN.
- GC TO INSTALL 5/8" PLYWOOD BACKING TYP. @ ALL EXTERIOR WALLS AND DEMISING WALL. - G.C. TO VERIFY CONDITION IN FIELD. KEEP EXISTING WALL FINISH AND SUBSTRATE ONLY AROUND THE WALK-IN BOX. NOTE: IF PLYWOOD BACKING OCCURS AT RATED WALL ASSEMBLIES, WALL TO BE REPAIRED BACK TO ORIGINAL TO MAINTAIN EXISTING ASSEMBLY RATING.
- PROVIDE SOUND-ATTENUATION BATT INSULATION AT RESTROOM WALL FROM FLOOR TO CEILING.
- APPROXIMATE LOCATION OF EXISTING 3/4" NPT PIZZA OVEN GAS CONNECTION. VERIFY CONDITION IN FIELD. INFORM ARCHITECT OF ANY DISCREPANCIES.
- FLOOR SAFE. REFER TO EQUIPMENT PLAN. G.C. TO SECURE TO FLOOR.
- WALL MOUNTED OFFICE DESK AND UPPER CABINETS, REFER TO EQUIPMENT PLAN.
- DRIVER DROP BOX, RECESSED INTO WALL. REFER TO EQUIPMENT PLAN AND DETAIL.
- G.C. TO VERIFY IF IN-WALL BLOCKING IS PROVIDED FOR ALL TOILET ROOM ACCESSORIES AND GRAB BARS. PROVIDE AS REQUIRED.
- NOT USED.
- EXISTING MOP SINK.
- (1) EXISTING WALL MOUNTED WATER HEATER AND (1) NEW WALL MOUNTED WATER HEATER. REFER TO PLUMBING DRAWINGS.
- HAND SINK. REFER TO PLUMBING DRAWINGS.
- 3 COMPARTMENT SINK. REFER TO EQUIPMENT PLAN.
- 1 COMPARTMENT SINK. REFER TO EQUIPMENT PLAN.
- CUSTOM COUNTERTOP SUPPORTED ON LOW WALLS. REFER TO EQUIPMENT PLAN.
- BOARD AND BATTON WALL FEATURE, SUPPLIED AND INSTALLED BY G.C.
- (1) EXISTING ELECTRICAL PANEL AND (1) NEW ELECTRICAL PANEL AND LIGHTING CONTROL PANEL, REFER TO ELECTRICAL DRAWINGS.
- EXISTING WATER SERVICE AND METER BASE IN FIELD (NOT SHOWN). REFER TO PLUMBING DRAWINGS.
- EXISTING GAS LINE IN BUILDING (NOT SHOWN). REFER TO PLUMBING DRAWINGS.
- NOT USED.
- NOT USED.
- NOT USED.
- NOT USED.
- ACT CEILING START POINT.
- NOT USED.
- NOT USED.
- NOT USED.
- EXISTING WALK-IN COOLER LIGHTS TO REMAIN, RELAMP AS REQUIRED.
- EXISTING HOOD TO BE REUSED. VERIFY DIMENSIONS TO HOLD W/ EQUIPMENT.
- GC TO PAINT NEW GYP.BD. CEILING. REFER TO DETAIL #3 ON THIS SHEET.
- NOT USED.
- NOT USED.

PARTITION SCHEDULE

TAG	TYPE	FRAMING / CORE	SHEATHING
(A2)	RESTROOM WALL	3 5/8" METAL STUDS @ 16" O.C. W/ SOUND ATTENUATION BATT INSULATION TO CEILING	5/8" CEMENT BOARD UP TO 12" A.F.F. BOTH SIDES; AND 5/8" FIRE RETARDANT PLYWOOD FROM 12" A.F.F. TO 6" ABOVE CEILING, 5/8" GYP. BD. FROM 12"A.F.F. TO CEILING RESTROOM SIDE
(B1)	TYPICAL KITCHEN WALL	3 5/8" METAL STUDS @ 16" O.C.	5/8" CEMENT BOARD UP TO 12" A.F.F. AND 5/8" FIRE RETARDANT PLYWOOD FROM 12" A.F.F. TO 6" ABOVE CEILING; BOTH SIDES
(F1)	FURR-OUT WALL	3 5/8"x 20 GA. METAL STUDS @ 16" O.C. ATTACHED TO EXISTING WALL	5/8" CEMENT BOARD UP TO 12" A.F.F. RESTROOM SIDE ONLY, 5/8" GYP. BD. FROM 12"A.F.F. TO CEILING
(K1)	KNEE WALL	3 5/8" METAL STUDS @ 16" O.C.	5/8" CEMENT BOARD UP TO 12" A.F.F. AND 5/8" GYP. BD. FROM 12" A.F.F. TO TOP OF WALL; BOTH SIDES
(S1)	SOFFIT WALL	3 5/8" METAL STUDS @ 16" O.C.	5/8" GYPSUM BOARD TO 6" ABOVE CEILING, BOTH SIDES

EXISTING WALL TO REMAIN. REMOVE EXISTING FINISH AND SUBSTRATE DOWN TO STUD. G.C. TO INSTALL NEW PLYWOOD ON EXISTING STUD. TYP. @ ALL EXTERIOR WALLS AND DEMISING WALL. KEEP EXISTING GYP.BD AND FINISH ONLY WHERE EXISTING WALK-IN BOX IS LOCATED

G.C. TO VERIFY WALL LOCATION AND CONSTRUCTION TYPE PRIOR TO START OF CONSTRUCTION, NOTIFY ARCHITECT OF ANY DISCREPANCIES, COORDINATE REMOVAL OR RETENTION OF SHEATHING WITH DEMOLITION PLAN AND NEW SHEATHING WITH FINISH PLAN. PATCH WALL AS NEEDED.

LIGHTING FIXTURES

TAG	QTY	TYPE	MOUNTING	SUPPLIED BY	INSTALLED BY
A4	21	Flat Panel 2x4	ACT ceiling recessed	EC	EC
D	6	Downlight Recessed	ACT ceiling recessed	EC	EC
EM*	3	Emergency Lighting	Wall or Ceiling (see plans)	EC	EC
F	10	Track Head	Track	EC	EC
J	2	Wall Sconce	Surface mounted Wall	O	EC
TS	2	Track	Ceiling mounted	EC	EC
XC*	4	Exit Sign/Emerg. Lighting		EC	EC
XR*	2	Emergency Lighting Exterior		EC	EC

REFER TO ELECTRICAL DRAWINGS FOR LIGHTING FIXTURE SPECIFICATIONS

O = OWNER
EC = ELECTRICAL CONTRACTOR
GC = GENERAL CONTRACTOR

GENERAL NOTES

- GC TO VERIFY ALL DIMENSIONS AND NOTIFY ARCHITECT OF ANY DISCREPANCIES.
- DIMENSIONS ON THIS PLAN ARE FROM FACE OF SHEATHING. ALL SHEATHING IS UNIFORM AT 5/8" THICK, UNLESS OTHERWISE NOTED.
- GC SHALL INSTALL ALL REQUIRED BLOCKING AND/OR BACKING FOR ALL EQUIPMENT, HANGERS, ETC.
- ALL WORK SHALL CONFORM TO ALL LOCAL AND STATE CODES AND REGULATIONS.
- REFER TO CHART ON SHEET G1-0 FOR METAL STUD GAUGE SIZES.
- EXISTING WALLS TO REMAIN PER FLOOR PLAN. G.C. TO PREP TO RECEIVE NEW FINISHES AND EQUIPMENT AS NECESSARY. FOR RATED PARTITIONS REPAIR ANY DAMAGE AND TREAT ALL PENETRATIONS TO MAINTAIN RATING.