


3/18/2025 1:31 PM J:\PROJECTS\NNG\2024\MEASUREMENT & SPECIAL PROJECTS\01091000 WL TO WASECA METER & BTU MONITOR\2-PIPELINE\01091000 MECH CONST 0

CONTINUATION ON DWG P7-1

CONTINUATION ON DWG P7-3

CONTINUATION ON DWG P7-1

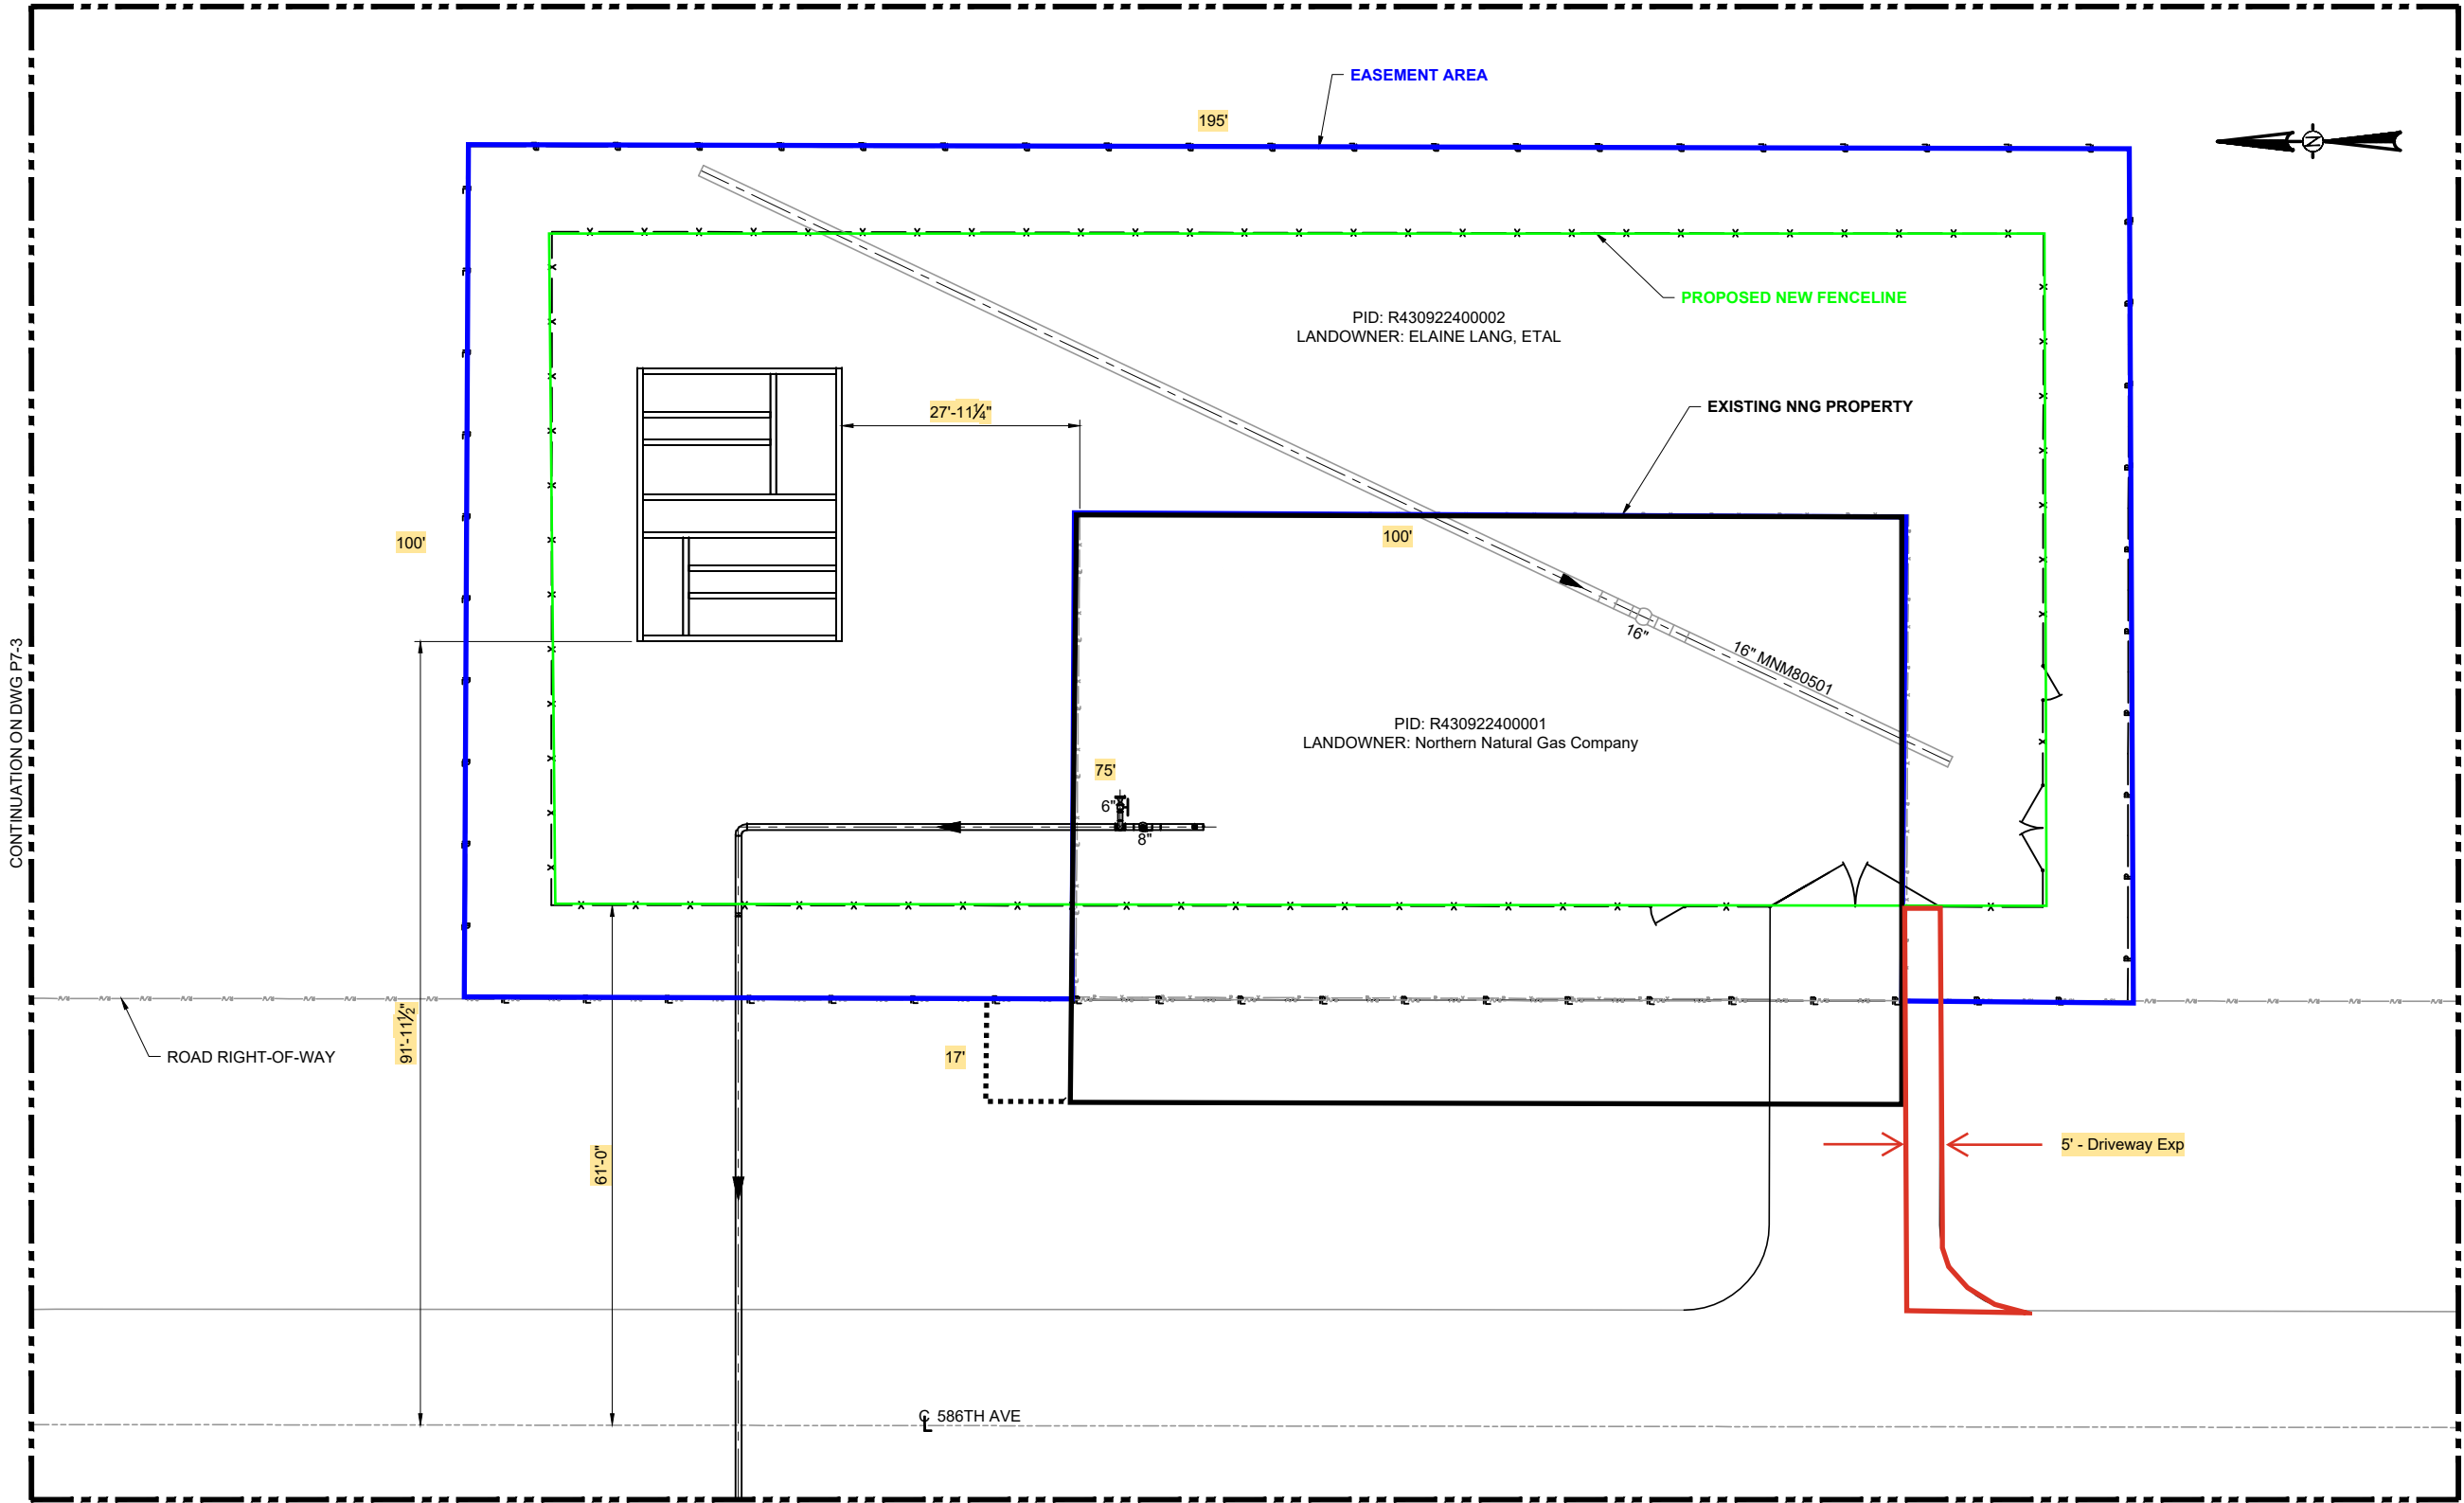

- NOTES:**
- 1. ALL NEW CONSTRUCTION TO BE DONE BY CONTRACTOR.
 - 2. CONTRACTOR TO FIELD VERIFY ALL DIMENSIONS AND ELEVATIONS PRIOR TO FABRICATION.
 - 3. CONTRACTOR TO EXERCISE EXTREME CAUTION WHILE DITCHING DUE TO ANY BURIED PIPE, CONDUIT OR CABLE NOT SHOWN ON DRAWING.

 
Existing Site Footprint (Owned in Fee by NNG)
Proposed New Fence Line
New Facilities Easement

DRAWING LIMITS

SEE CONSTRUCTION YEAR BREAK

LEGEND

- EXISTING FACILITIES
- NEW CONSTRUCTION
- FENCE LINE



SCALE: 1/4" = 1'-0"

SCALE DISCLAIMER:
NOTED SCALE APPLIES TO 22"x34" PAPER SIZE ONLY

INTERNAL INFORMATION
DISTRIBUTION/COPIES LIMITED TO
PROJECT NEEDS

0	ISSUED FOR CONSTRUCTION	DJS	8/27/24		
NO.	REVISION - DESCRIPTION	BY	DATE	CHK'D	APP'D

**APPROVED
FOR
CONSTRUCTION**

STATUS	CHECKED		APPROVED	
	BY	DATE	BY	DATE
PRELIM			ELS	12/8/22
BID			KAM	5/17/24
CONST.	MSP	8/27/24	KAM	8/27/24

FAC. CODE: MNR-002/MNR-0025	REL. W.O. SEE ABOVE
PL# MNR80501/MNR83001	CONST. YR 2024
STA# N/A	POI# N/A
DESIGN	BY DATE
DRAWN	DJS 12/16/22
ASBUILT	DJS 12/16/22
FILE NO.:	
SCALE: 1/4"=1'-0"	

**WASECA WEST LEG TIE-OVER REGULATOR
WL TO WASECA METER & BTU MONITOR
AREA PIPING PLAN
SEC. 22, T108N, R26
BLUE EARTH, MINNESOTA**



WORK ORDER NO.
01091000

DWG. NO.
P7-2

