


Right © 2024 LED A DALY Company

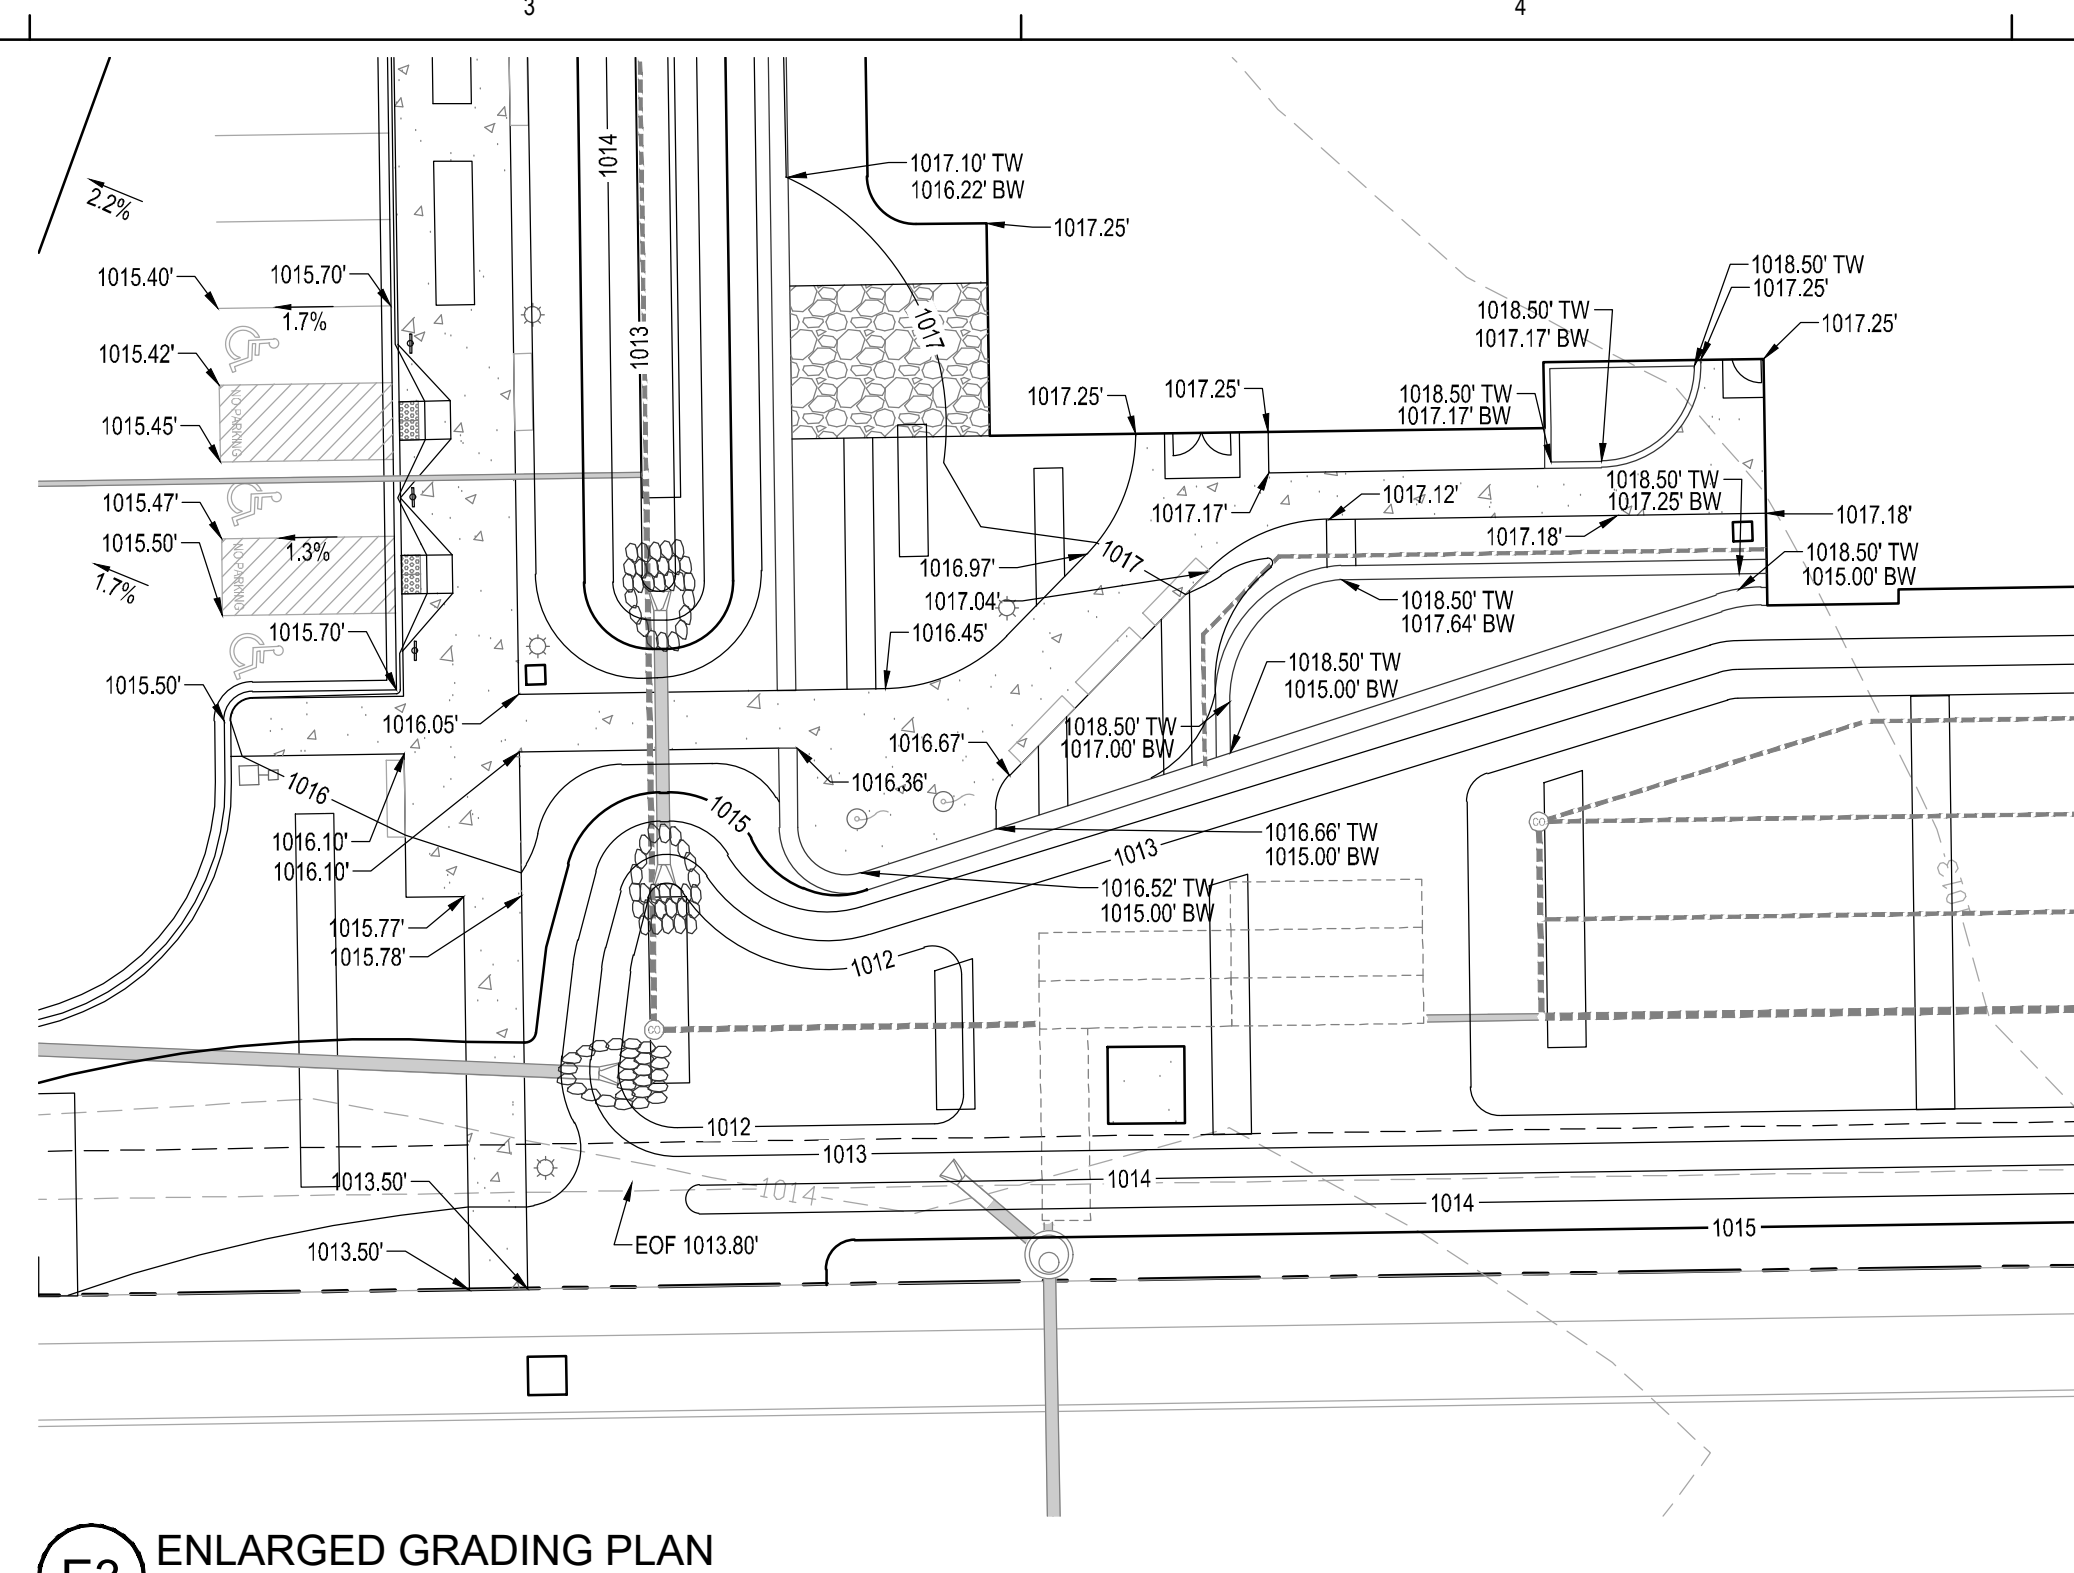

52 ENLARGED GRADING PLAN




A1 GRADING PLAN

1. SEE SHEET CN101 FOR GRADING PLAN NOTES & LEGEND



730 Second Avenue South, Suite 1300
Minneapolis, MN 55402-2455
Tel: 612.338.8741

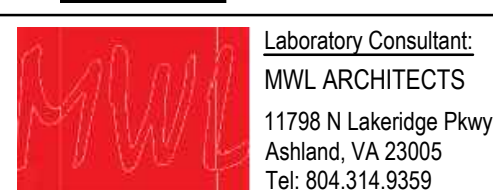

KEY PLAN

[illegible]

FILE LOG

ACTIVITY	BY
Manager	MJW
Design	MJW
Draw	AKW
Check	SMJ

STAMP

PRELIMINARY
NOT FOR CONSTRUCTION

100% DESIGN DEVELOPMENT

Project No. 023-10680-000 / LAD240017
MARCH 28, 2025

GRADING PLAN

CG101




30 90
SCALE IN FEET

1. SEE SHEET CN101 FOR UTILITY PLAN NOTES & LEGEND.

1. GEOTHERMAL WELL SETBACKS ARE AS FOLLOWS:

- 10' TO POWER LINES, NATURAL GAS MAINS, WATER MAINS, AND BUILDINGS
- 20' TO STORM SEWER LINES
- 50' TO OTHER GEOTHERMAL WELLS, STORMWATER RETENTION PONDS, AND SANITARY LINES

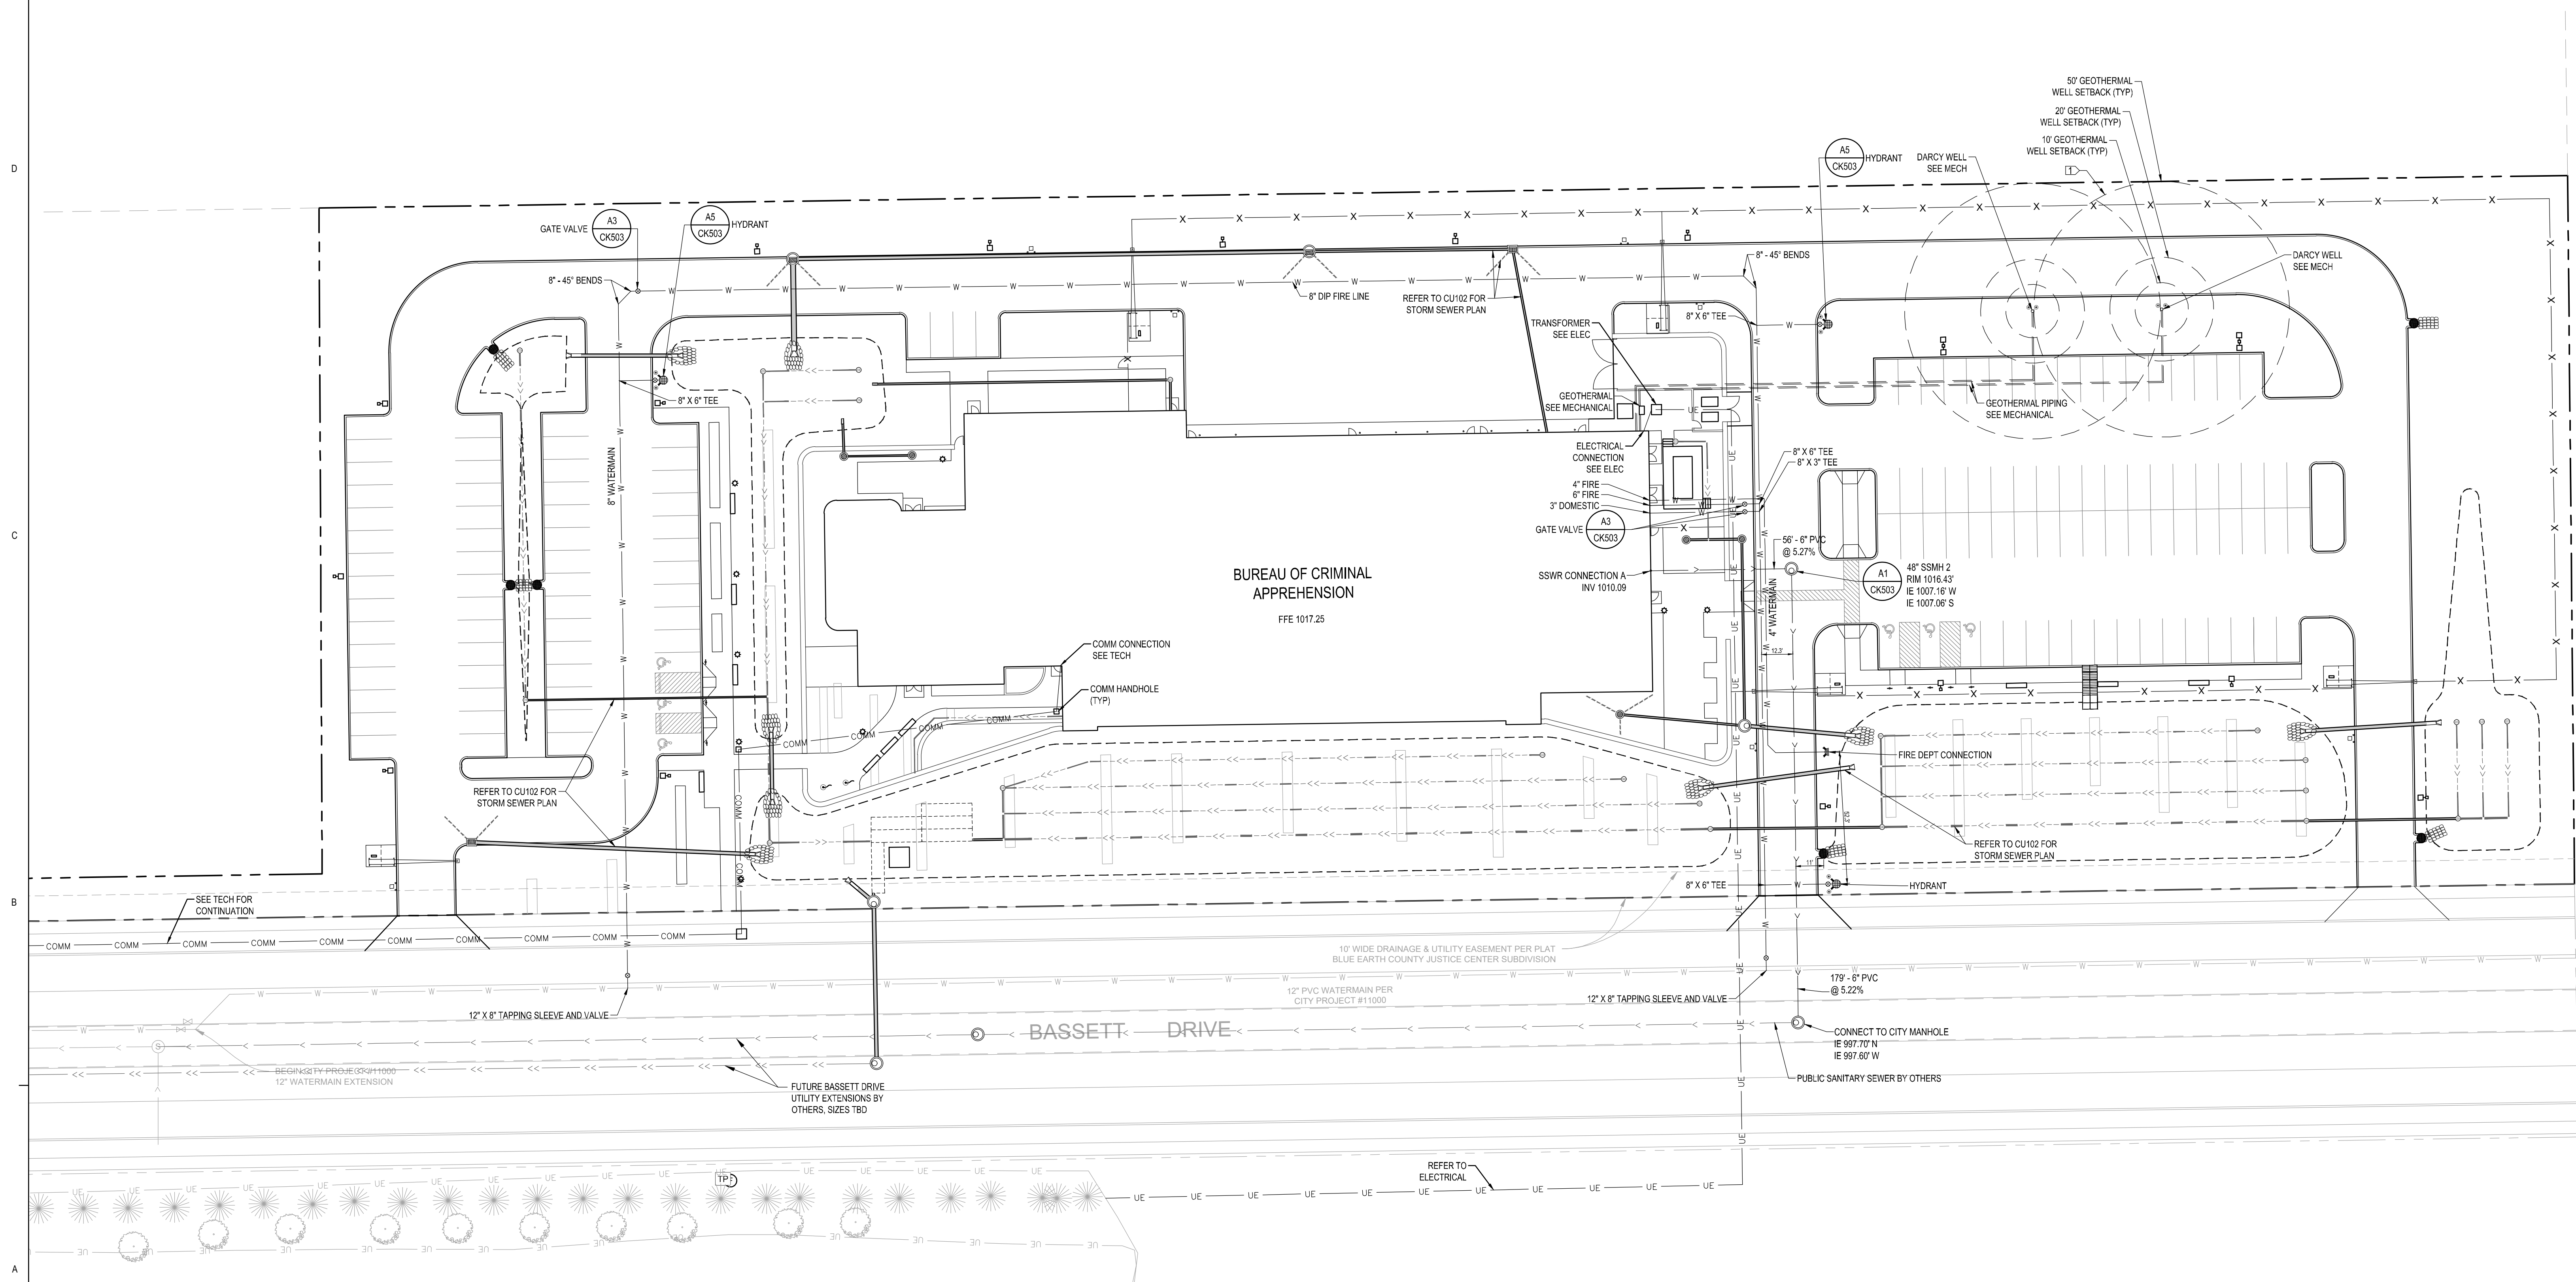

A1 UTILITY PLAN
1" = 30'



Know what's below.
Call before you dig.

30 90
SCALE IN FEET

 **Minnesota
BCA**
Bureau of Criminal Apprehension

MN BCA Southern Regional
Office and Laboratory

TBD (Bassett Drive)
Mankato, MN 56001

STATE OF MINNESOTA
State RECS Project Number: 07MK

 **Department of
Public Safety**

445 Minnesota St.,
St. Paul, MN 55101



LEO A DALY

730 Second Avenue South, Suite 1300
Minneapolis, MN 55402-2455
Tel: 612.338.8741



Civil Consultant:
ÉLAN DESIGN LAB, INC.
 310 4th Avenue South, Suite 1006
 Minneapolis, MN 55415
 Tel: 612.292.7004

DF/ Landscape Consultant:
DAMON FARBER
310 4th Avenue South, Suite 705
Minneapolis, MN 55415
Tel: 612 332 7522

Laboratory Consultant:
MWL ARCHITECTS
11798 N Lakeridge Pkwy
Ashland, VA 23005
Tel: 804.314.9359

KEY PLAN

[illegible]

FILE LOG

ACTIVITY	BY
Manager	MJW
Design	MJW
Draw	AKW
Check	SMJ

STAMP

PRELIMINARY
NOT FOR CONSTRUCTION

100% DESIGN DEVELOPMENT

Project No. 023-10680-000 / LAD240017
MARCH 28, 2025


UTILITY PLAN

CU101

1. SEE SHEET CN101 FOR UTILITY PLAN NOTES & LEGEND

1. GEOTHERMAL WELL SETBACKS ARE AS FOLLOWS:

- 10' TO POWER LINES, NATURAL GAS MAINS, WATER MAINS, AND BUILDINGS
- 20' TO STORM SEWER LINES
- 50' TO OTHER GEOTHERMAL WELLS, STORMWATER RETENTION PONDS, AND SANITARY LINES

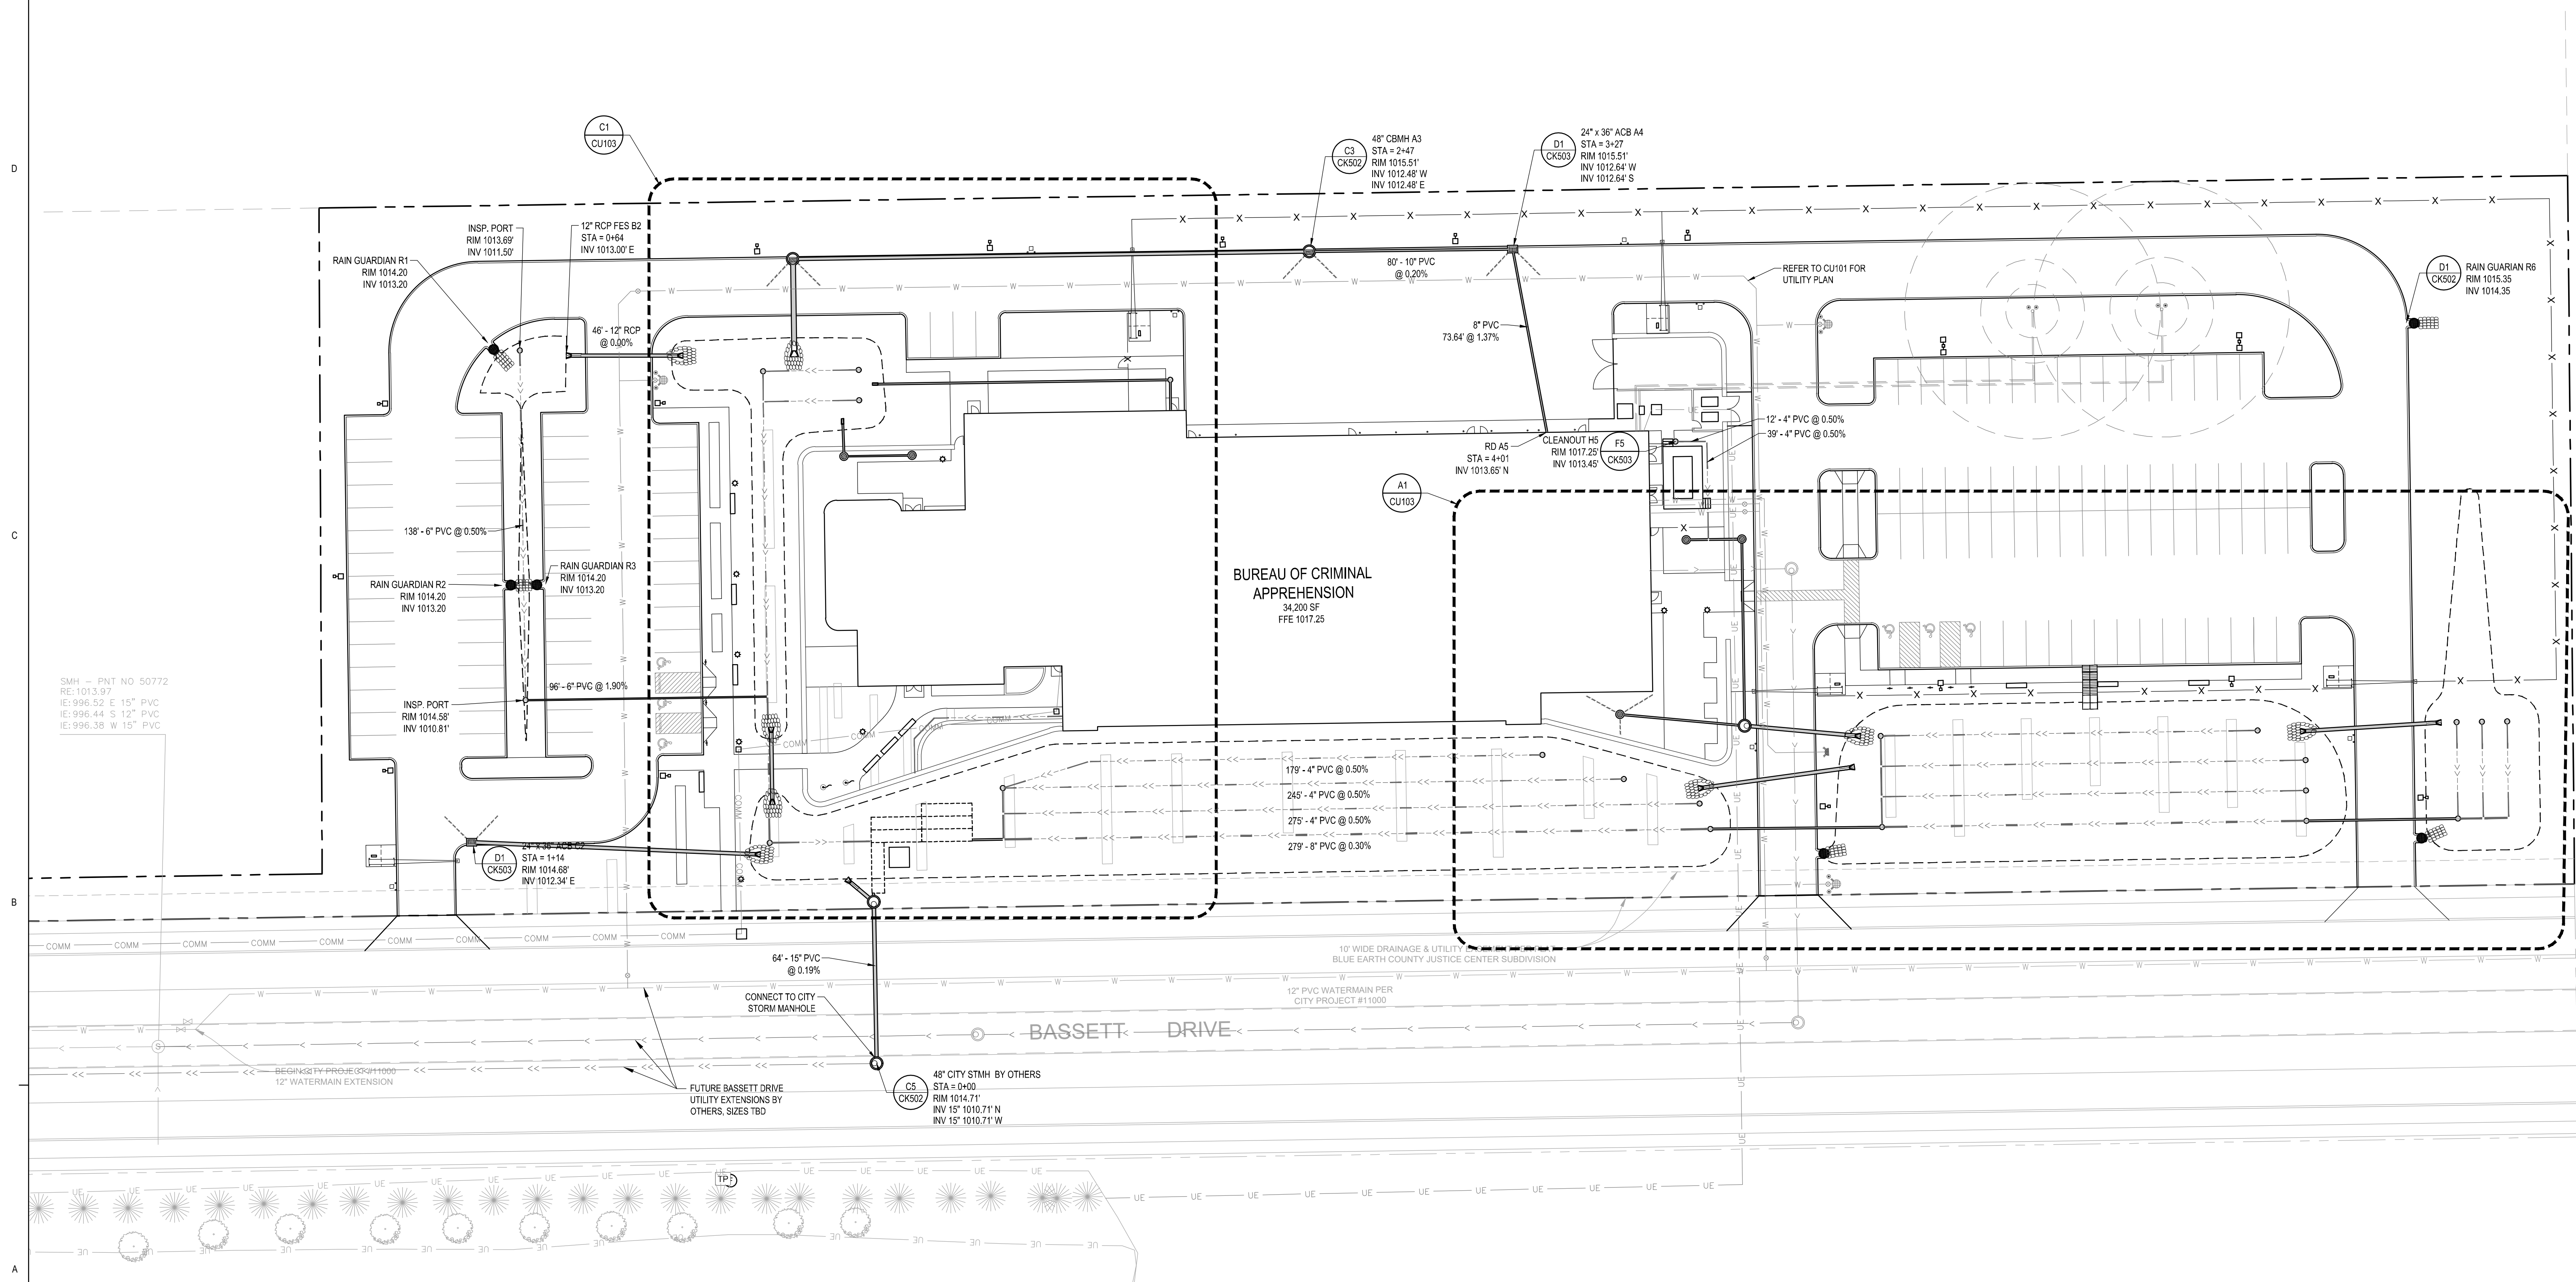

A1 STORM SEWER PLAN
1" = 30'



Know what's below.
Call before you dig.

30 9
SCALE IN FEET

 **Minnesota
BCA**
Bureau of Criminal Apprehension

MN BCA Southern Regional
Office and Laboratory

TBD (Bassett Drive)
Mankato, MN 56001

STATE OF MINNESOTA
State RECS Project Number: 07MK

 **Department of
Public Safety**

445 Minnesota St.,
St. Paul, MN 55101



LEO A DALY

730 Second Avenue South, Suite 1300
Minneapolis, MN 55402-2455
Tel: 612.338.8741



Civil Consultant:
ÉLAN DESIGN LAB, INC.
 310 4th Avenue South, Suite 1006
 Minneapolis, MN 55415
 Tel: 612.292.7004

DF/

Laboratory Consultant:
MWL ARCHITECTS
11798 N Lakeridge Pkwy
Ashland, VA 23005
Tel: 804.314.9359

KEY PLAN

[illegible]

REVISIONS

[illegible]

STAMP

PRELIMINARY
NOT FOR CONSTRUCTION

100% DESIGN DEVELOPMENT

Project No. 023-10680-000 / LAD240017
MARCH 28, 2025

STORM SEWER PLAN

CU102

