



PRELIMINARY NOT FOR CONSTRUCTION PRELIMINARY NOT FOR CONSTRUCTION

THIS DOCUMENT IS THE PROPERTY OF A.S. GROUP, INC. AND MAY NOT BE USED, COPIED OR DUPLICATED WITHOUT PRIOR WRITTEN CONSENT.

PROJECT

**MANKATO
SURGERY
CENTER
EXPANSION**

MANKATO MINNESOTA

REVISION SCHEDULE		DATE	BY
1	DESIGN	12/15/2020	RLS
2	DESIGN		
3	DESIGN		
4	DESIGN		
5	DESIGN		
6	DESIGN		
7	DESIGN		
8	DESIGN		
9	DESIGN		
10	DESIGN		


PROJECT NO. 25-32122
FILE NAME: SITE ELEC RSM.dwg
DRAWN BY: RLS
CHECKED BY: RLS
CUSTODY BY: RLS
CUSTODY DATE: 12/15/2020
CLIENT PROJECT NO.

TITLE

**SITE
PHOTOMETRIC**

SHEET

E2-03

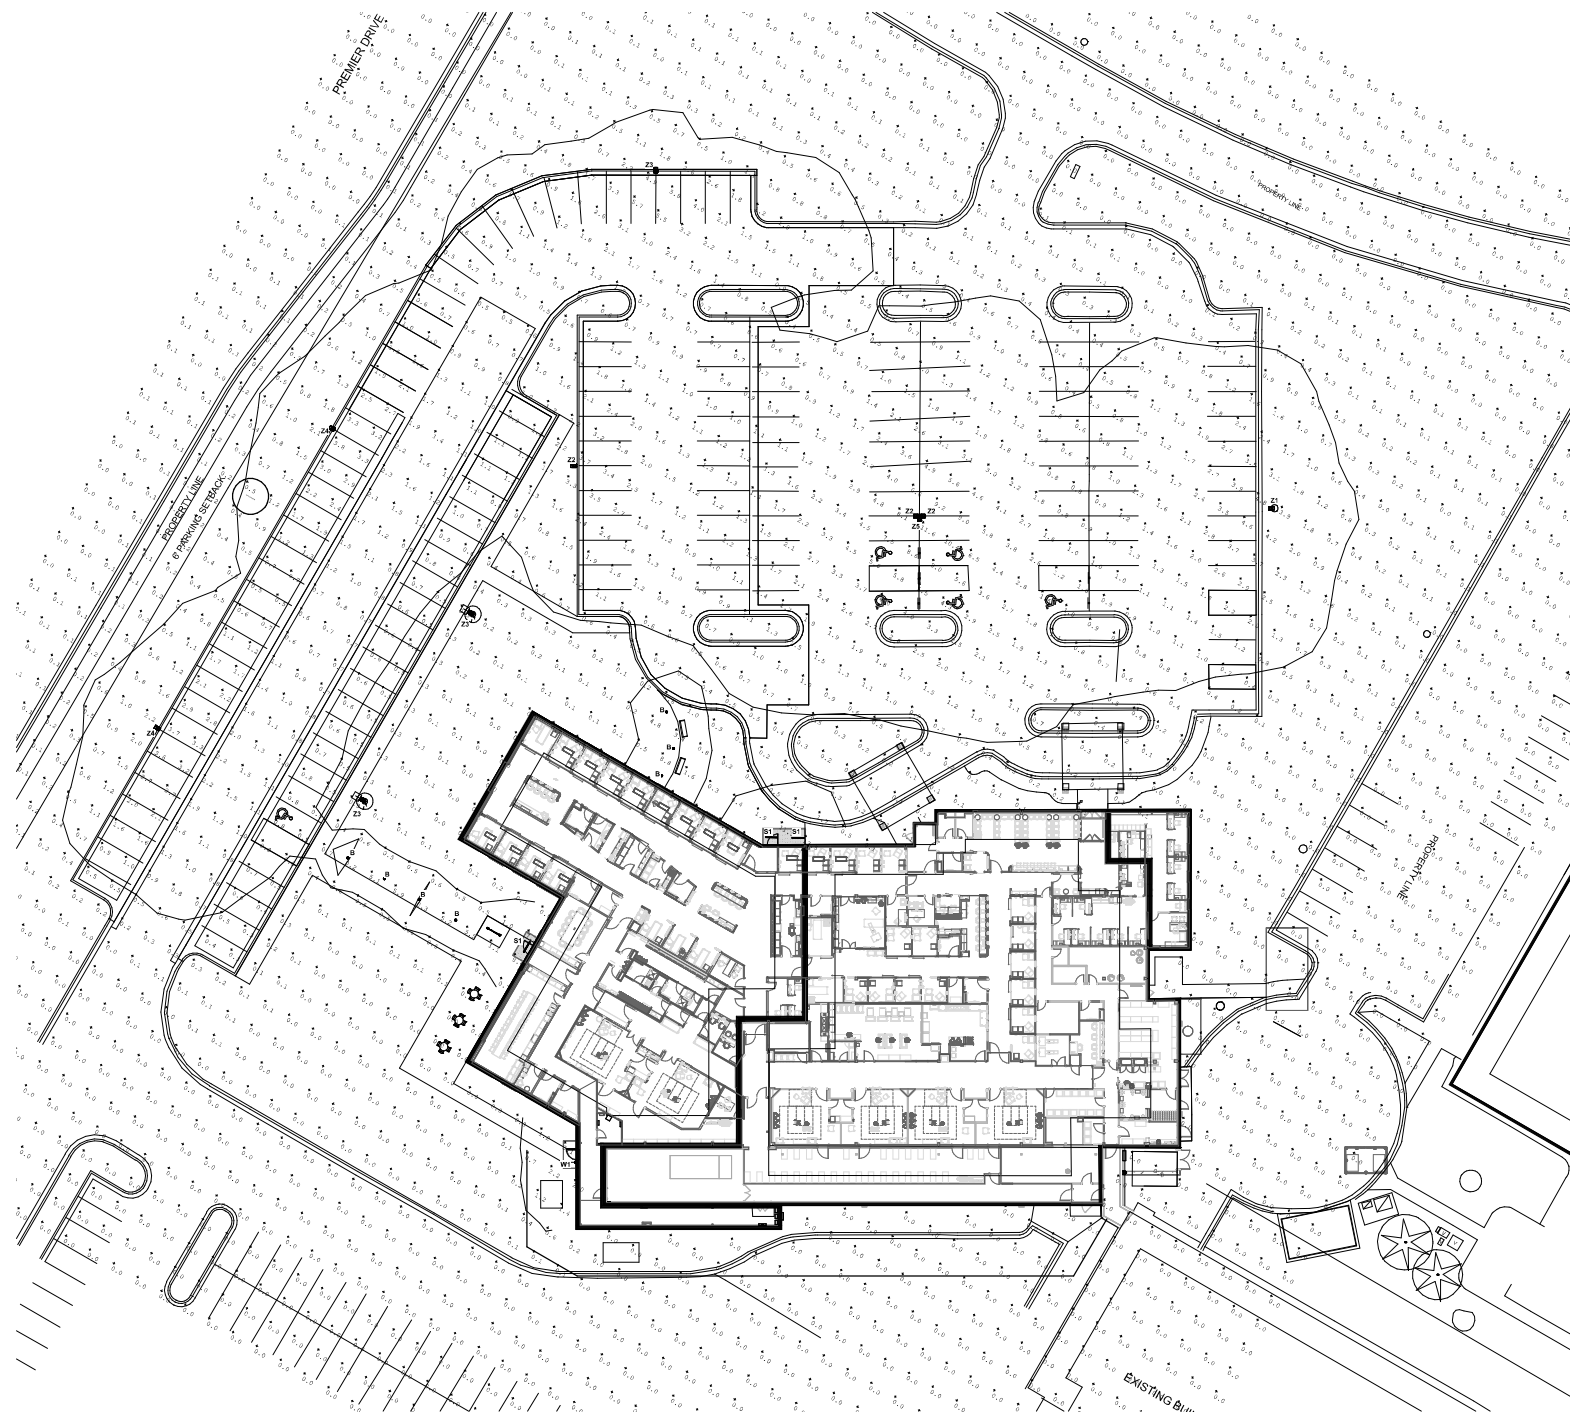

1 SITE PHOTOMETRIC
1/16" = 1'-0"



1/16" = 1'-0"

2020/12/15/2020

 


Diagram 1 (Left): Side view of light pole base installation. Dimensions include 8'-0" total height, 6'-0" base height, 1" dia. conduit, 1" dia. conduit, 24" dia. conc. pile footing, and 4 galvanized steel anchor bolts. The base is installed and provided by an electrical contractor.

Diagram 2 (Right): Front view of light pole base installation. Dimensions include 2'-0" top section, 8'-0" middle section, 12'-0" bottom section, 1" dia. conduit, 24" dia. conc. pile footing, and 4 galvanized steel anchor bolts. The base is installed and provided by an electrical contractor.

THIS DOCUMENT IS THE PROPERTY OF J.S. GROUP. IT IS LOANED TO YOU AND IS NOT TO BE REPRODUCED OR DISTRIBUTED WITHOUT PRIOR WRITTEN CONSENT.		
PROJECT:		
MANKATO SURGERY CENTER EXPANSION		
MANKATO		MINNESOTA
DATE	REVISIONS	BY
	DESCRIPTION	
PROJECT NO. 25-32122		
TITLE NAME 2025 ELEC FOR RM		
DESIGN BY 103		
DRAWN BY 103		
CHECKED BY 103		
INVESTIGATED BY 103		
ORIGINAL PROJECT DATE 10/00/00		
CLIENT PROJECT NO.		
TITLE		
LIGHT FIXTURE SCHEDULE AND DETAIL		
SHEET		
E2-04		