
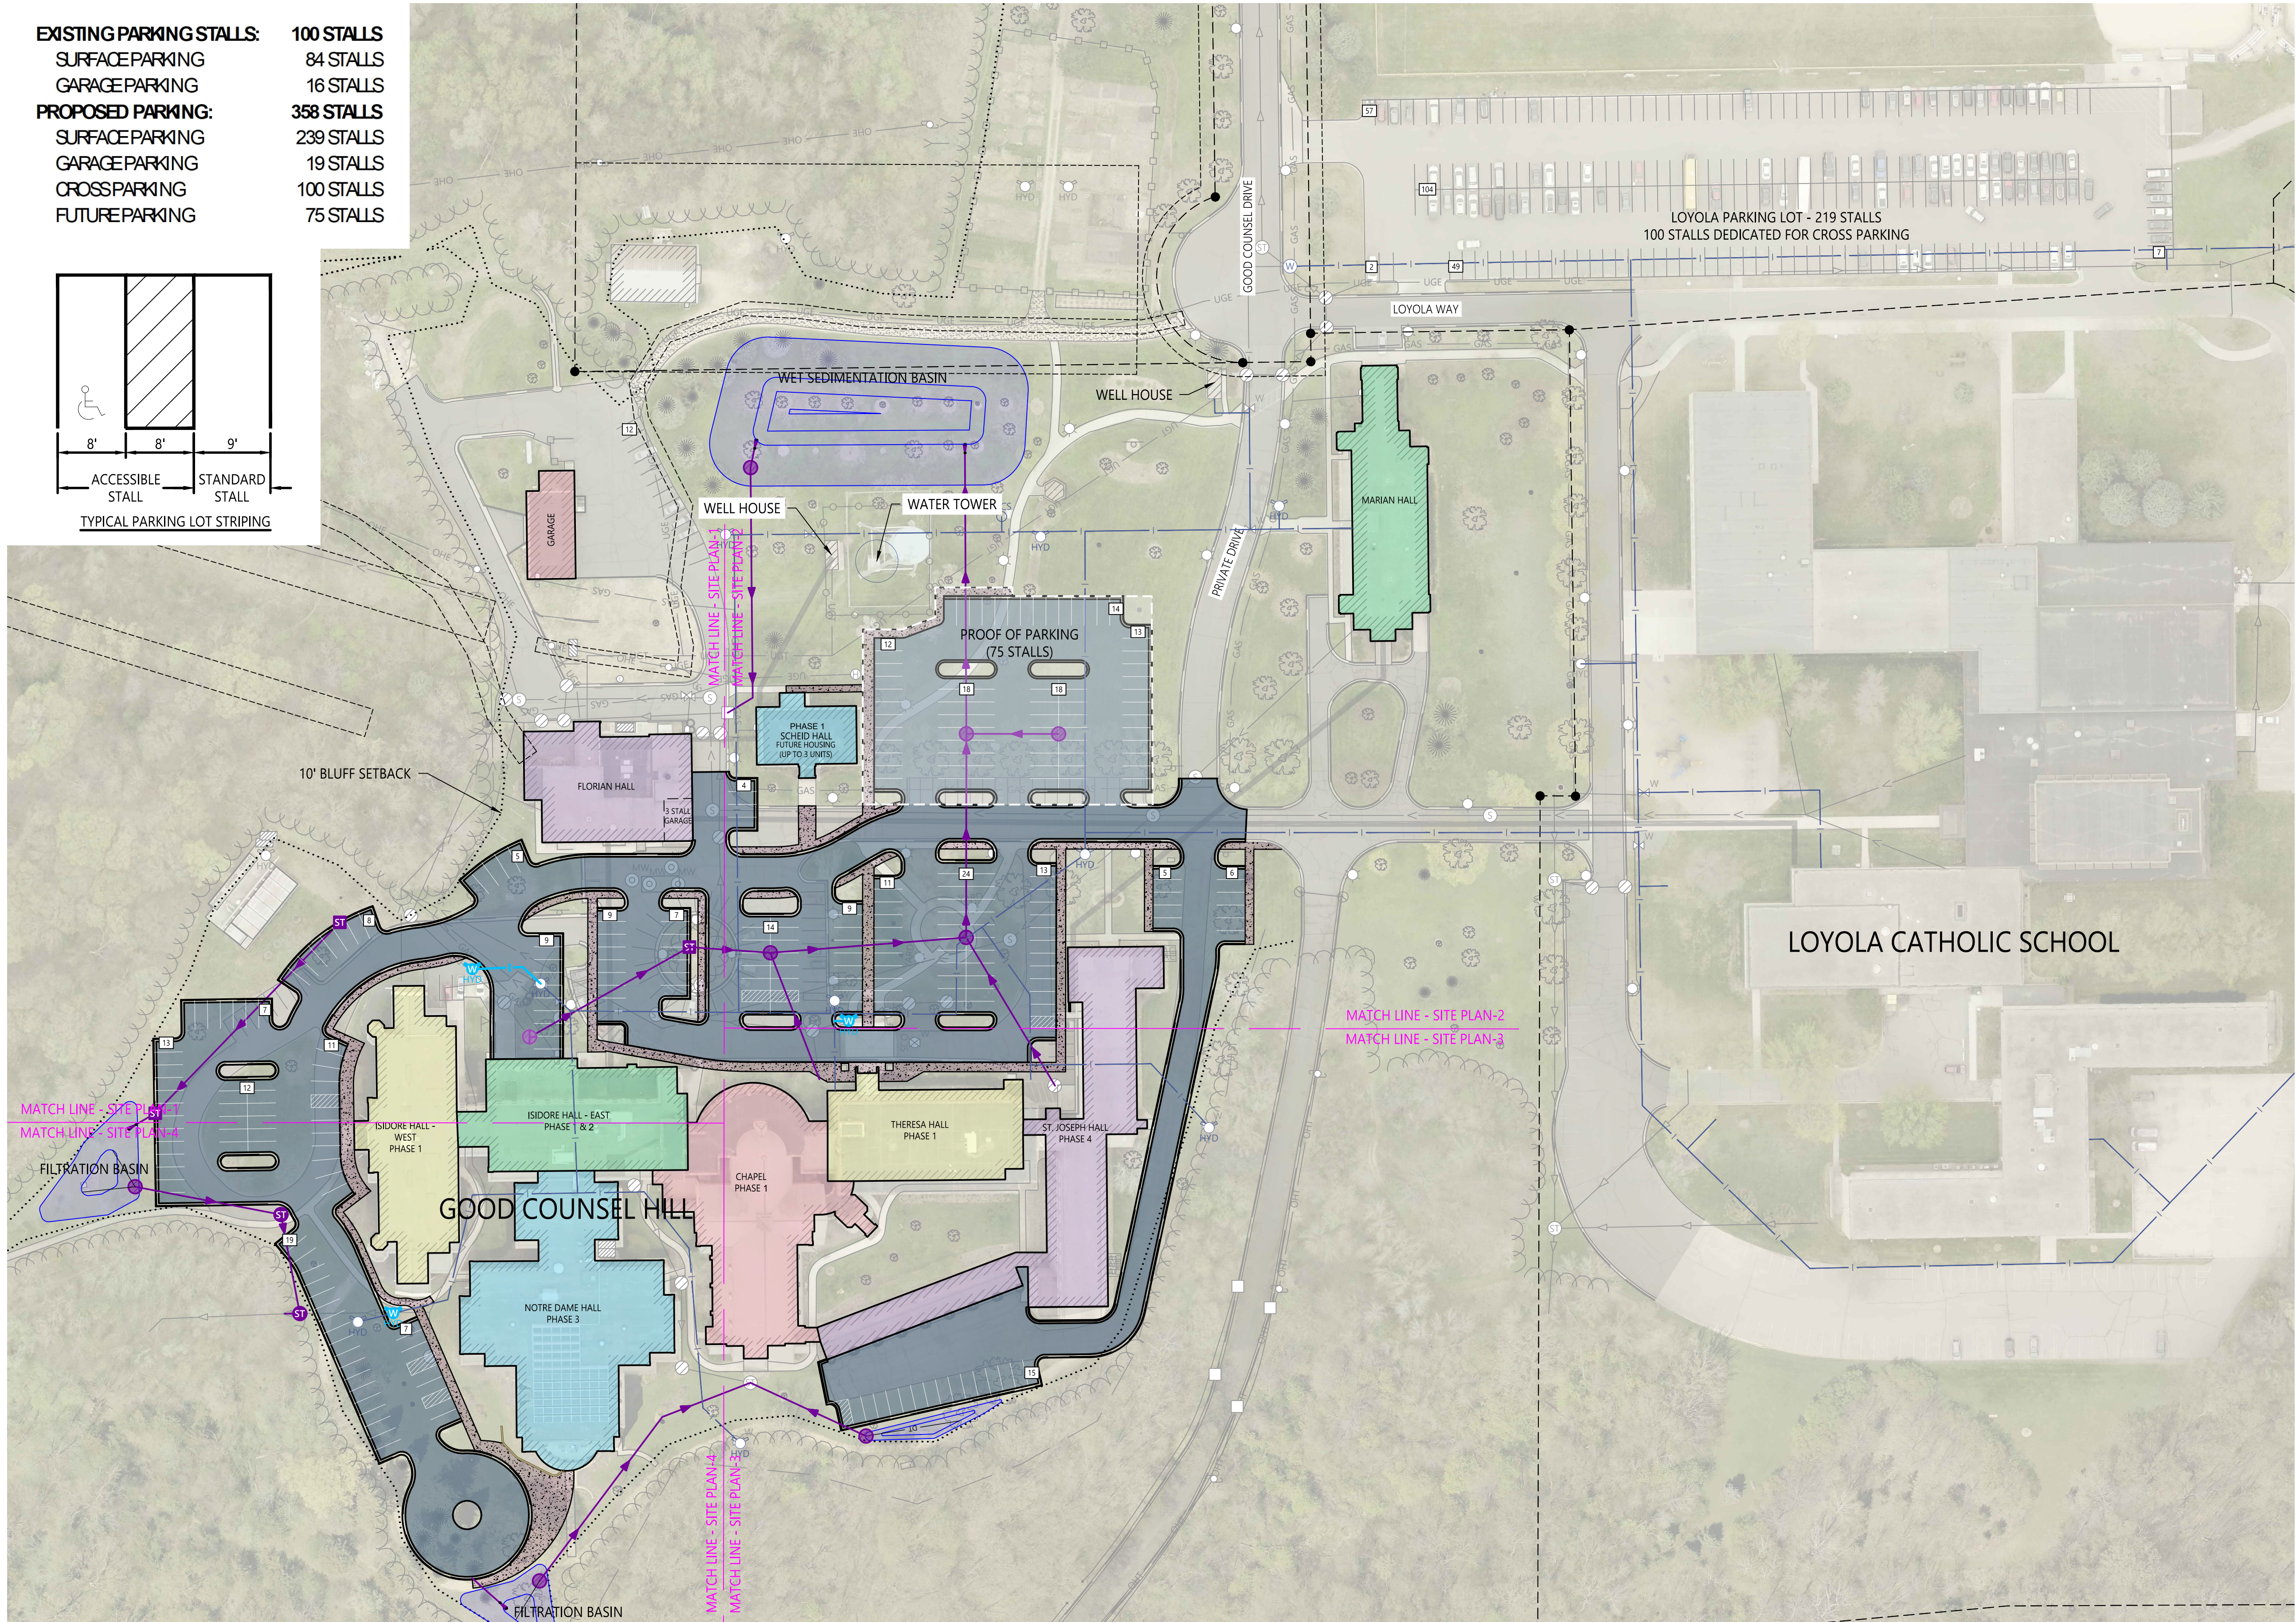


EXISTING PARKING STALLS: 100 STALLS
SURFACE PARKING 84 STALLS
GARAGE PARKING 16 STALLS
PROPOSED PARKING: 358 STALLS
SURFACE PARKING 239 STALLS
GARAGE PARKING 19 STALLS
CROSS PARKING 100 STALLS
FUTURE PARKING 75 STALLS

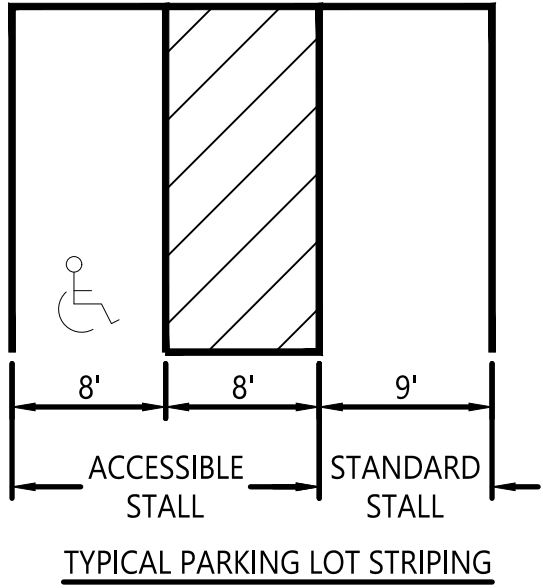


PROPOSED LEGEND

- BITUMINOUS SURFACE
- CONCRETE SURFACE
- CURB & GUTTER
- STORM SEWER CATCH BASIN
- STORM SEWER CLEANOUT
- STORM SEWER INLET STRUCTURE
- STORM SEWER MANHOLE
- STORM SEWER GRAVITY MAIN
- STORM SEWER DRAINTILE
- HYDRANT
- WATER MAIN VALVE
- WATER MAIN PIPE

EXISTING LEGEND

- SHRUB
- TREE - CONIFEROUS
- TREE - DECIDUOUS
- EDGE OF WOODS
- BUILDING
- CHAINLINK FENCE
- RETAINING WALL
- FOC — UNDERGROUND FIBER OPTIC LINE
- OHT — OVERHEAD TELEPHONE LINE
- UGT — UNDERGROUND TELEPHONE LINE
- OHC — OVERHEAD TV LINE
- UGC — UNDERGROUND TV LINE
- FOC — UNDERGROUND FIBER OPTIC LINE
- UGT — UNDERGROUND TELEPHONE LINE
- LIGHT POLE
- UGE — UNDERGROUND ELECTRIC LINE
- GAS — NATURAL GAS LINE
- SANITARY MANHOLE
- SANITARY GRAVITY MAIN
- STORM SEWER CATCH BASIN
- CULVERT APRON
- STORM SEWER INLET STRUCTURE
- STORM SEWER MANHOLE
- STORM SEWER GRAVITY MAIN
- WCS — CURB STOP
- FIRE HYDRANT
- WATER MAIN LINE

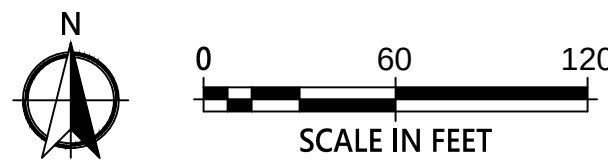

WIDSETH
ARCHITECTS • ENGINEERS • SCIENTISTS • SURVEYORS

DRAWN BY:
RSH
CHECKED BY:
CNB

I HEREBY CERTIFY THAT THIS PLAN, SPECIFICATION, OR REPORT WAS PREPARED BY ME OR UNDER MY DIRECT SUPERVISION AND THAT I AM A DULY LICENSED PROFESSIONAL PROFESSION UNDER THE LAWS OF THE STATE OF MINNESOTA.
SIGNER NAME LIC. NO.: NUMBER DATE: MM/DD/YYYY

DATE	REV#	REVISIONS DESCRIPTION

GOOD COUNSEL
SITE PLAN

PROJECT #: 2025-10591




PROPOSED LEGEND

- BITUMINOUS SURFACE
- CONCRETE SURFACE
- CURB & GUTTER
- STORM SEWER CATCH BASIN
- STORM SEWER CLEANOUT
- STORM SEWER INLET STRUCTURE
- STORM SEWER MANHOLE
- STORM SEWER GRAVITY MAIN
- STORM SEWER DRAINTILE
- HYDRANT
- WATER MAIN VALVE
- WATER MAIN PIPE

EXISTING LEGEND

- SHRUB
- TREE - CONIFEROUS
- TREE - DECIDUOUS
- EDGE OF WOODS
- BUILDING
- CHAINLINK FENCE
- RETAINING WALL
- FOC - UNDERGROUND FIBER OPTIC LINE
- OHT - OVERHEAD TELEPHONE LINE
- UGT - UNDERGROUND TELEPHONE LINE
- OHC - OVERHEAD TV LINE
- UGC - UNDERGROUND TV LINE
- FOC - UNDERGROUND FIBER OPTIC LINE
- UGT - UNDERGROUND TELEPHONE LINE
- LIGHT POLE
- UGE - UNDERGROUND ELECTRIC LINE
- GAS - NATURAL GAS LINE
- SANITARY MANHOLE
- SANITARY GRAVITY MAIN
- STORM SEWER CATCH BASIN
- CULVERT APRON
- STORM SEWER INLET STRUCTURE
- STORM SEWER MANHOLE
- STORM SEWER GRAVITY MAIN
- WCS - CURB STOP
- FIRE HYDRANT
- WATER MAIN LINE

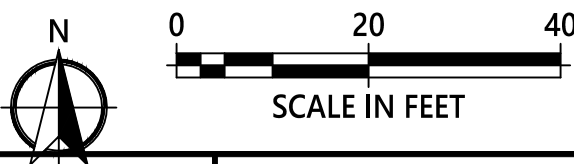

DRAWN BY:
RSH
CHECKED BY:
CNB

I HEREBY CERTIFY THAT THIS PLAN, SPECIFICATION, OR REPORT WAS PREPARED BY ME OR UNDER MY DIRECT SUPERVISION AND THAT I AM A DULY LICENSED PROFESSIONAL PROFESSION UNDER THE LAWS OF THE STATE OF MINNESOTA.

SIGNER NAME LIC. NO.: NUMBER DATE: MM/DD/YYYY


DATE	REV#	REVISIONS DESCRIPTION

GOOD COUNSEL

SITE PLAN-1

PROJECT #: 2025-10591

© 2026 WIDSETH - FILE: W:\PROJECTS\SOUTHWEST MINNESOTA HOUSING PARTNERSHIP (SWMHP)-49049\2025-10591\CADD\CIVIL\GOOD COUNCIL\CS-2025-10591.DWG - PLOTTED BY: VANESSA HINES, January 26, 2026

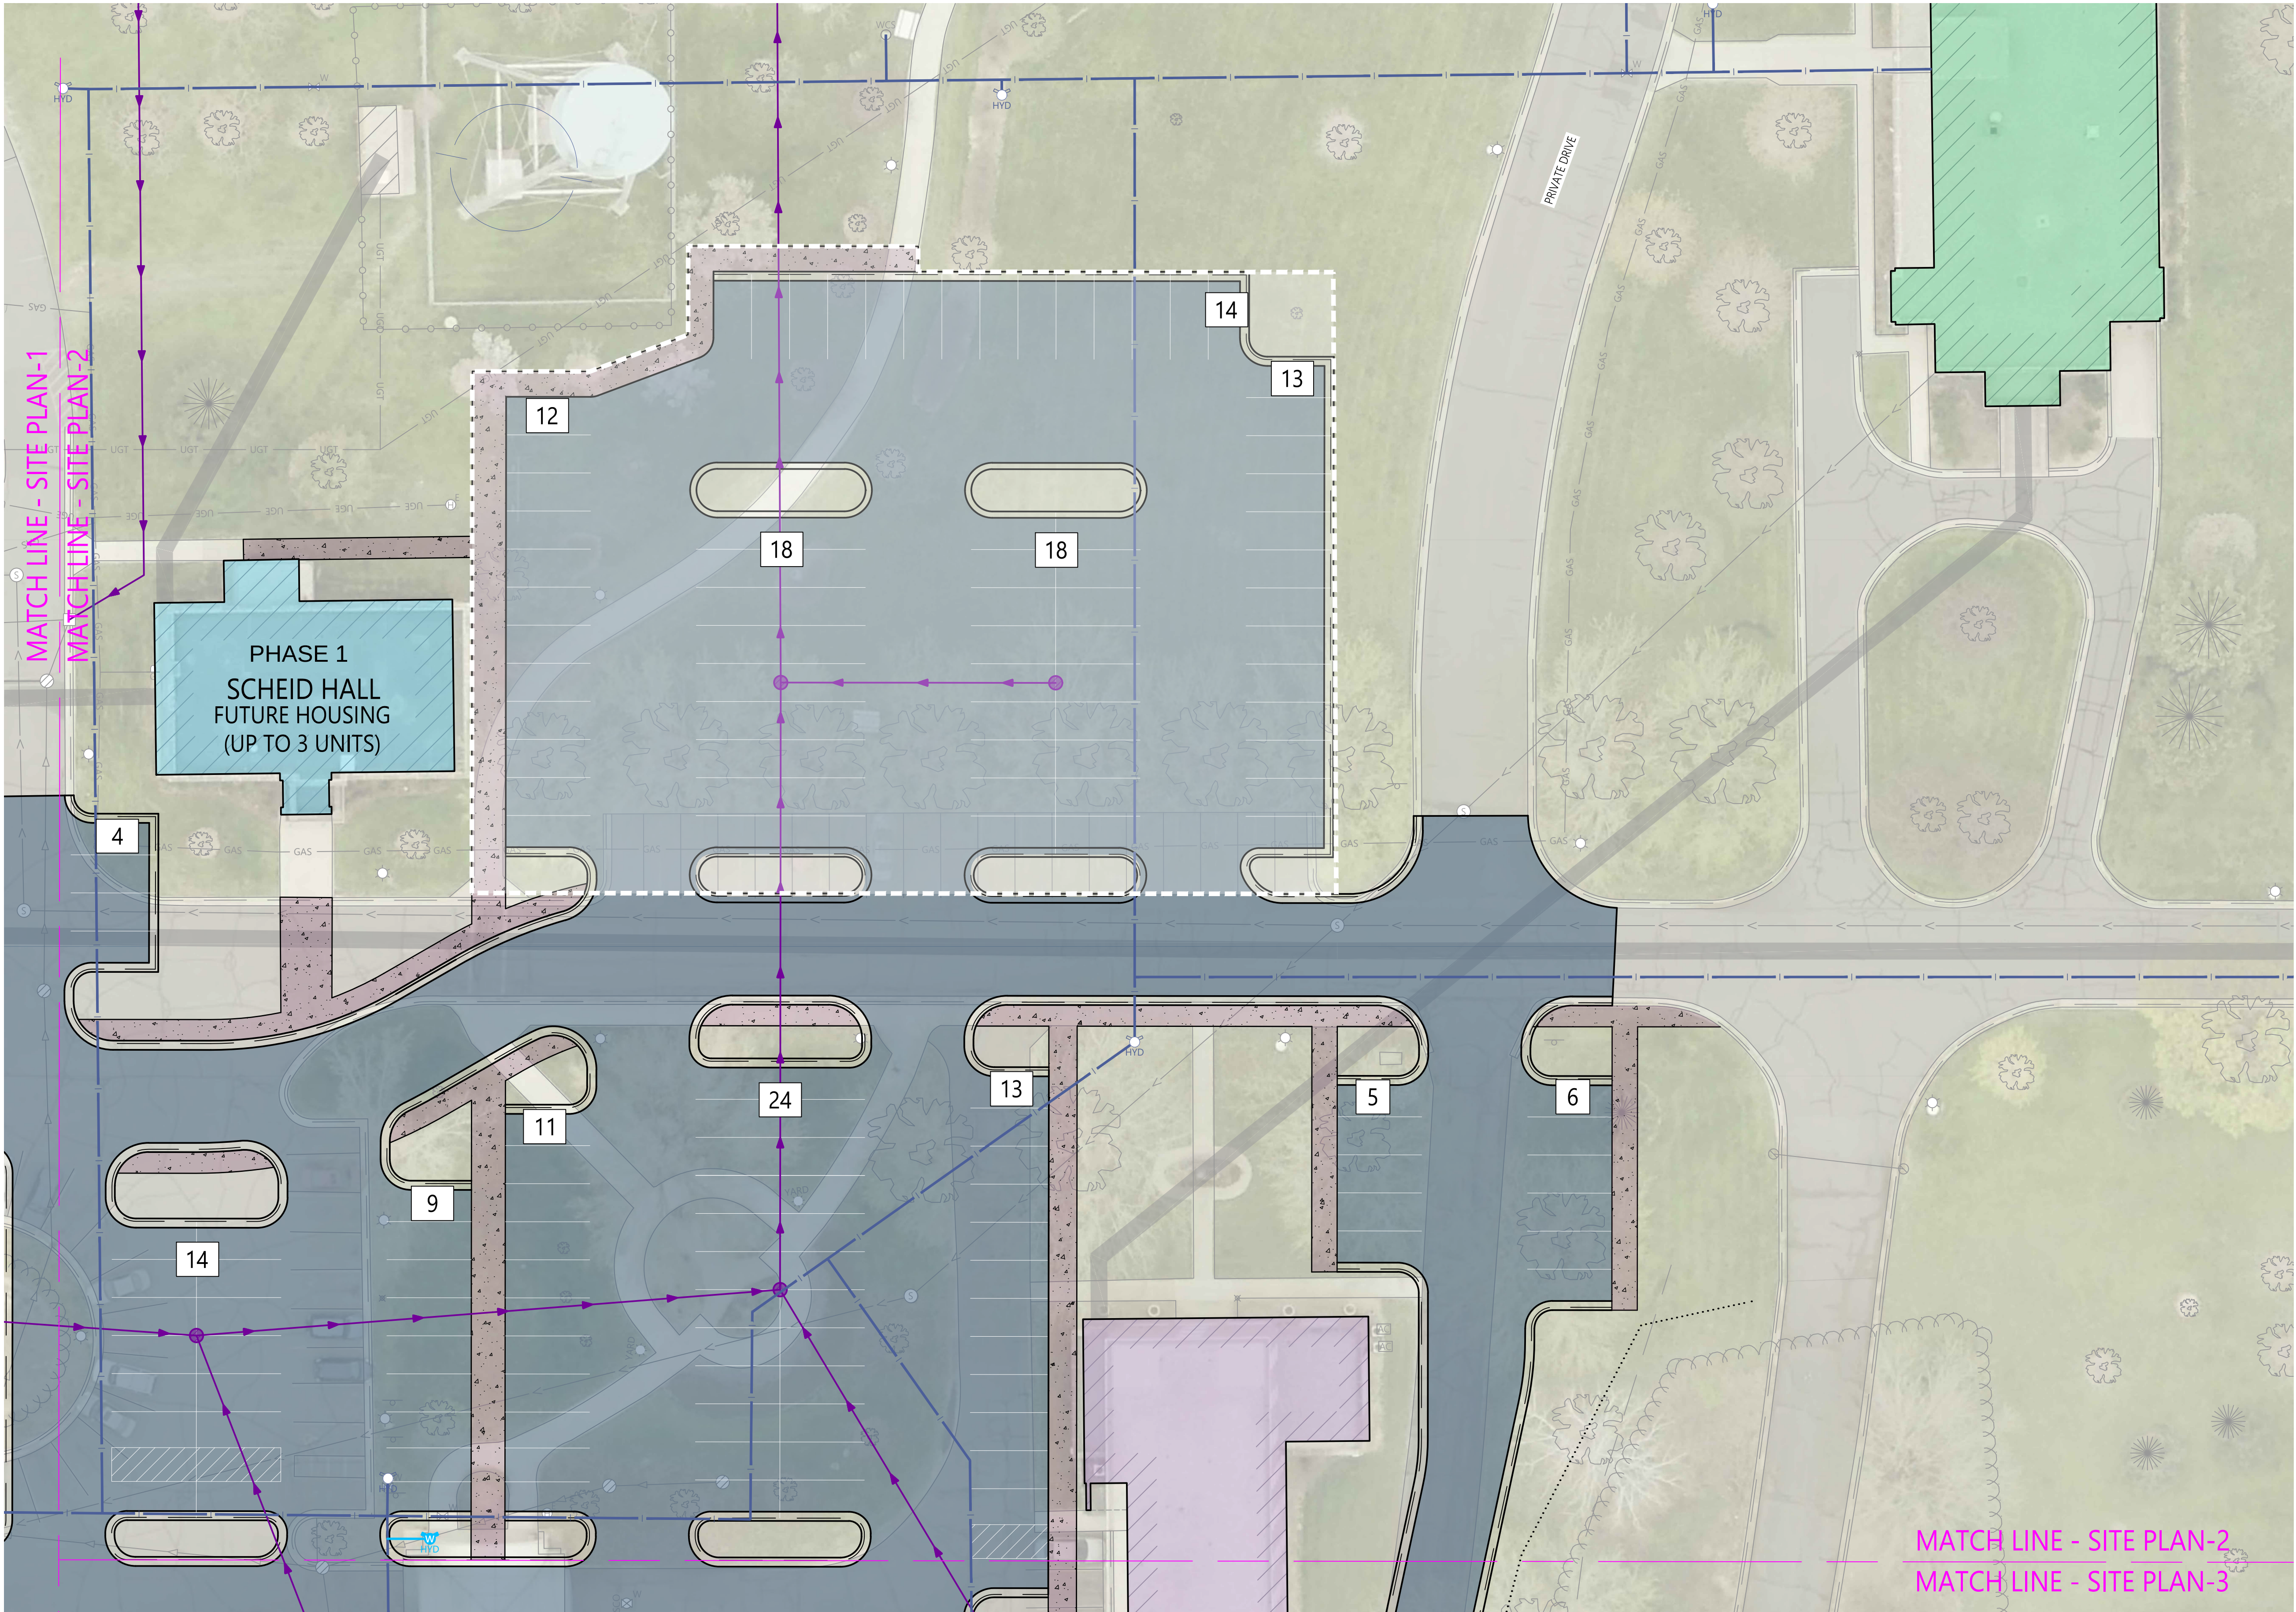


PROPOSED LEGEND

- BITUMINOUS SURFACE
- CONCRETE SURFACE
- CURB & GUTTER
- STORM SEWER CATCH BASIN
- STORM SEWER CLEANOUT
- STORM SEWER INLET STRUCTURE
- STORM SEWER MANHOLE
- STORM SEWER GRAVITY MAIN
- STORM SEWER DRAINTILE
- HYDRANT
- WATER MAIN VALVE
- WATER MAIN PIPE

EXISTING LEGEND

- SHRUB
- TREE - CONIFEROUS
- TREE - DECIDUOUS
- EDGE OF WOODS
- BUILDING
- CHAINLINK FENCE
- RETAINING WALL
- FOC - UNDERGROUND FIBER OPTIC LINE
- OHT - OVERHEAD TELEPHONE LINE
- UGT - UNDERGROUND TELEPHONE LINE
- OHC - OVERHEAD TV LINE
- UGC - UNDERGROUND TV LINE
- FOC - UNDERGROUND FIBER OPTIC LINE
- UGT - UNDERGROUND TELEPHONE LINE
- UGE - UNDERGROUND ELECTRIC LINE
- GAS - NATURAL GAS LINE
- SANITARY MANHOLE
- SANITARY GRAVITY MAIN
- STORM SEWER CATCH BASIN
- CULVERT APRON
- STORM SEWER INLET STRUCTURE
- STORM SEWER MANHOLE
- STORM SEWER GRAVITY MAIN
- CURB STOP
- FIRE HYDRANT
- WATER MAIN LINE

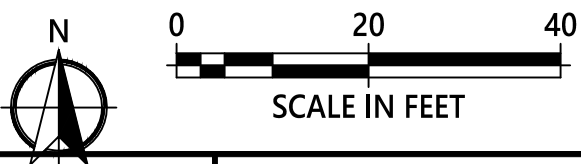

DRAWN BY:
RSH
CHECKED BY:
CNB

I HEREBY CERTIFY THAT THIS PLAN, SPECIFICATION, OR REPORT WAS PREPARED BY ME OR UNDER MY DIRECT SUPERVISION AND THAT I AM A DULY LICENSED PROFESSIONAL PROFESSION UNDER THE LAWS OF THE STATE OF MINNESOTA.


SIGNER NAME LIC. NO.: NUMBER DATE: MM/DD/YYYY

DATE	REV#	REVISIONS DESCRIPTION

GOOD COUNSEL

SITE PLAN-2

PROJECT #: 2025-10591

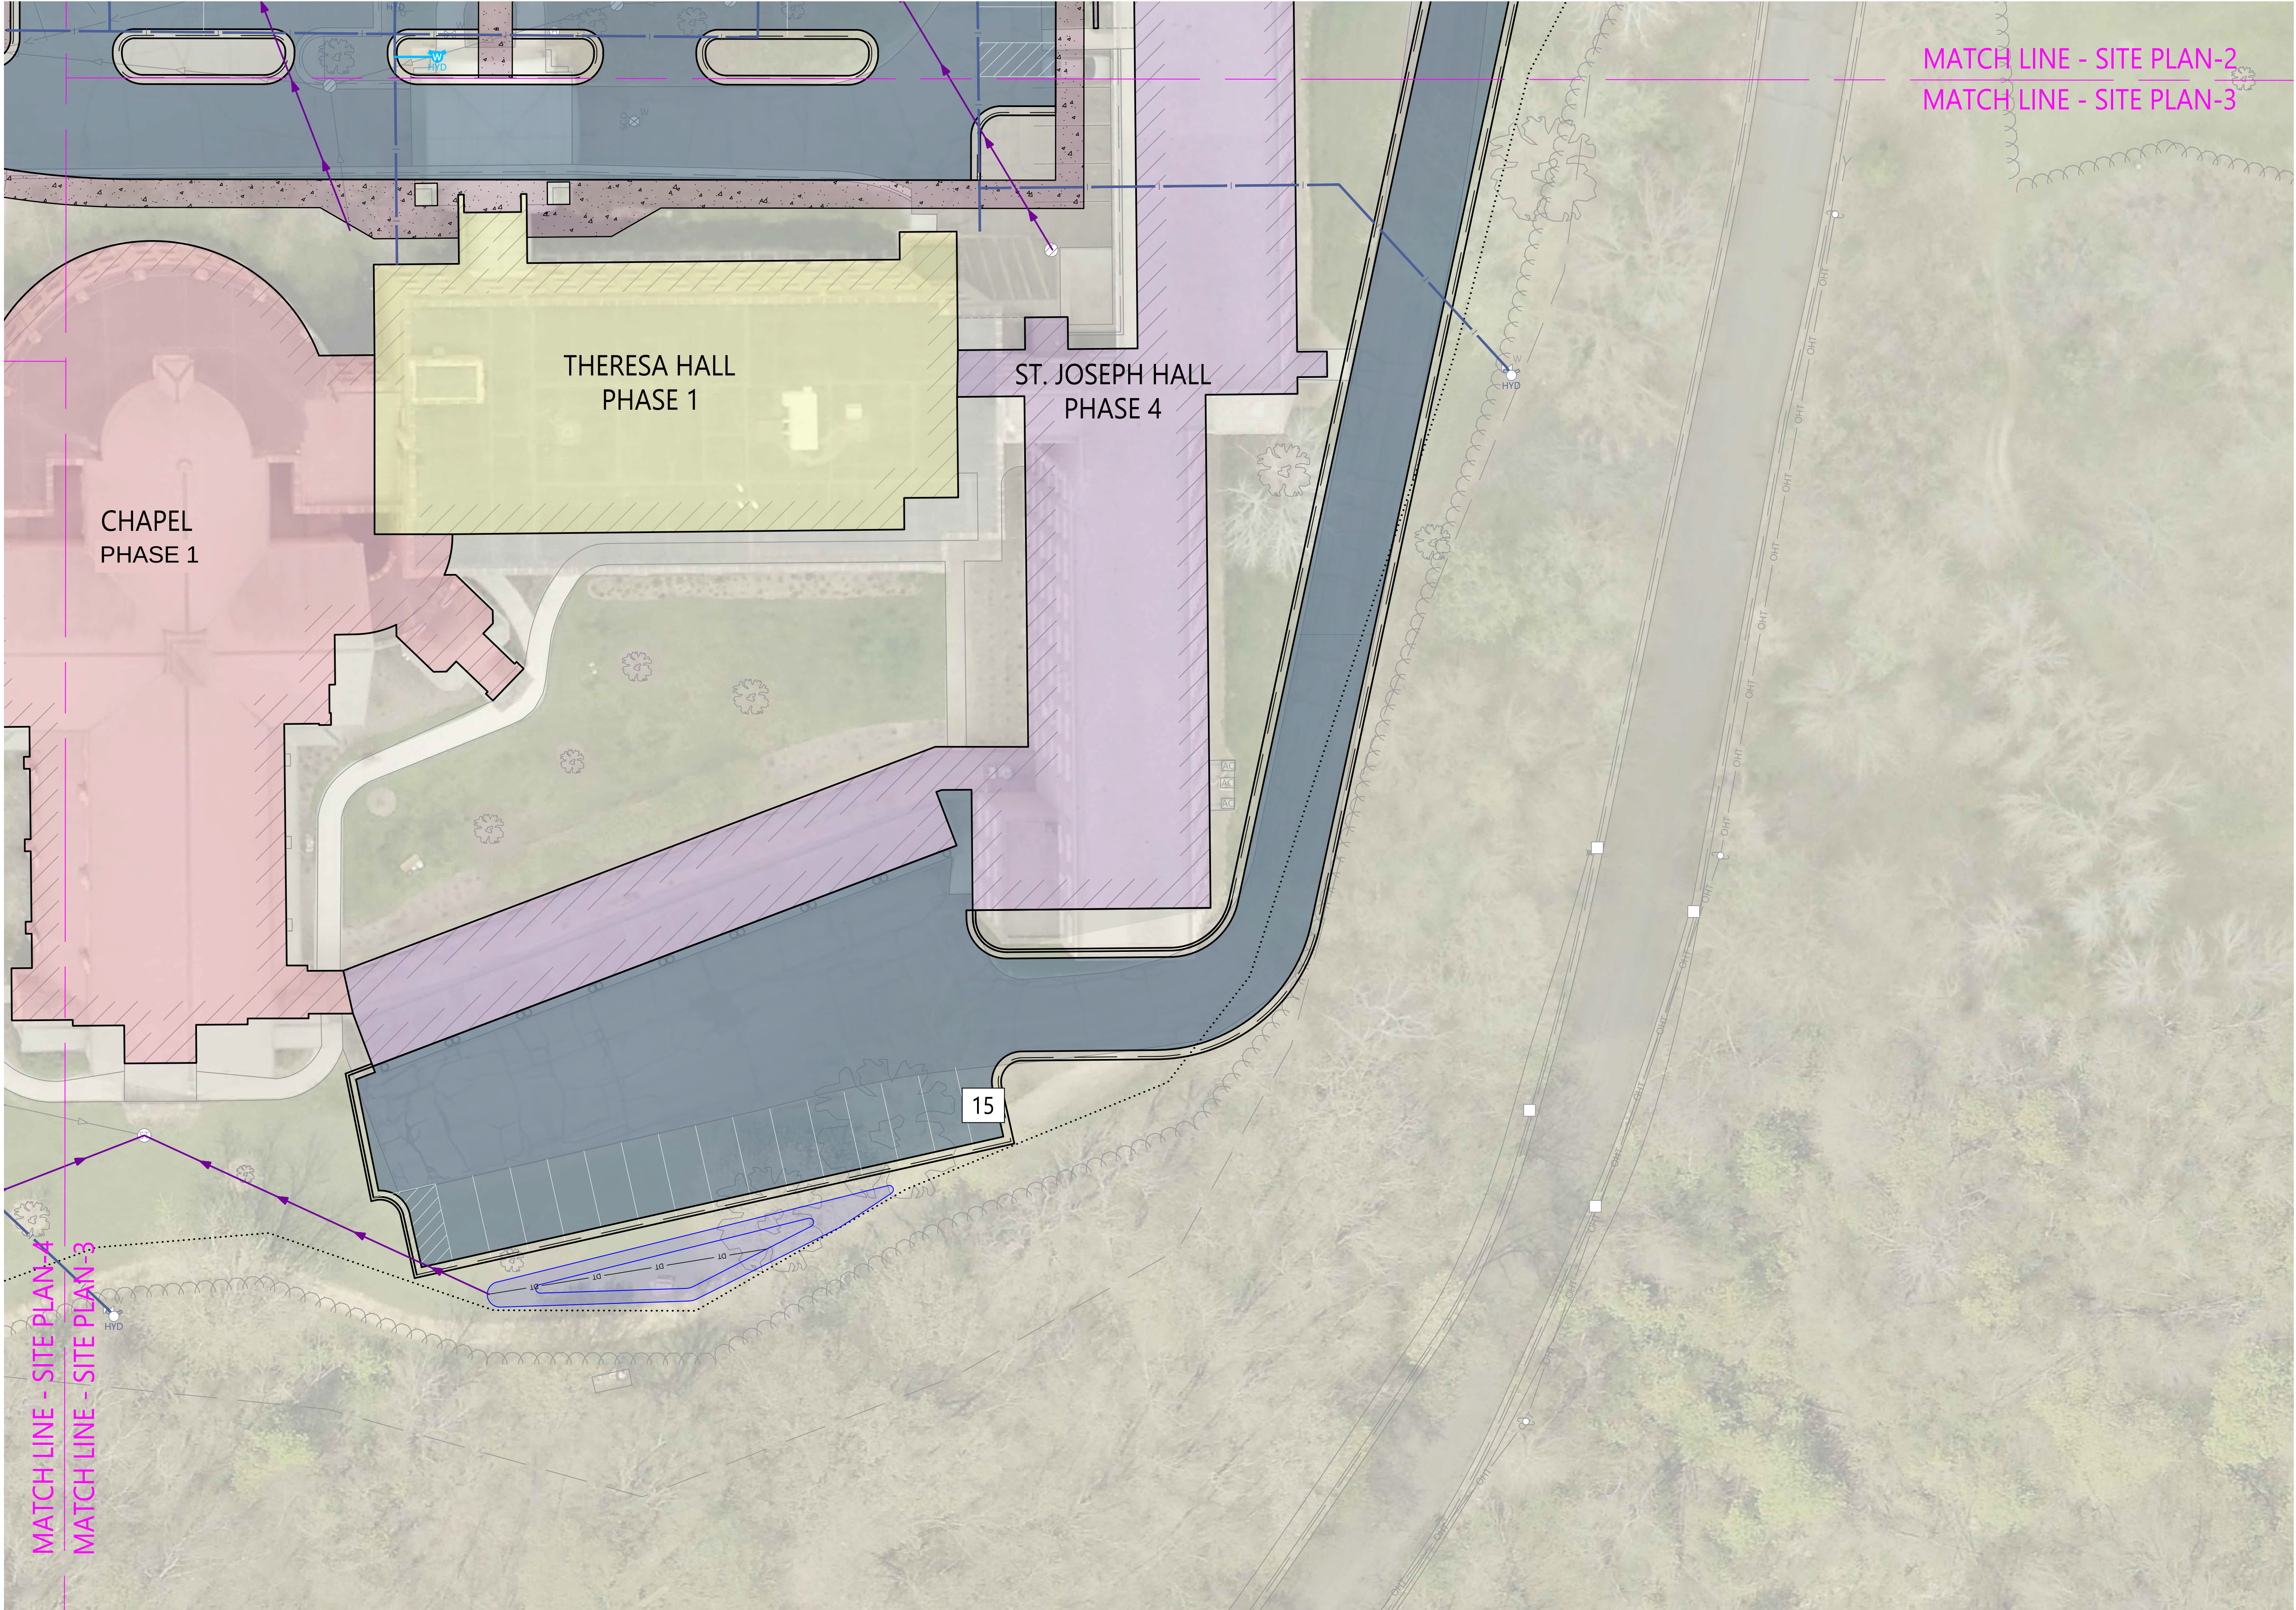


PROPOSED LEGEND

- BITUMINOUS SURFACE
- CONCRETE SURFACE
- CURB & GUTTER
- STORM SEWER CATCH BASIN
- STORM SEWER CLEANOUT
- STORM SEWER INLET STRUCTURE
- STORM SEWER MANHOLE
- STORM SEWER GRAVITY MAIN
- STORM SEWER DRAINTILE
- HYDRANT
- WATER MAIN VALVE
- WATER MAIN PIPE

EXISTING LEGEND

- SHRUB
- TREE - CONIFEROUS
- TREE - DECIDUOUS
- EDGE OF WOODS
- BUILDING
- CHAINLINK FENCE
- RETAINING WALL
- FOC - UNDERGROUND FIBER OPTIC LINE
- OHT - OVERHEAD TELEPHONE LINE
- UGT - UNDERGROUND TELEPHONE LINE
- OHC - OVERHEAD TV LINE
- UGC - UNDERGROUND TV LINE
- FOC - UNDERGROUND FIBER OPTIC LINE
- UGT - UNDERGROUND TELEPHONE LINE
- LIGHT POLE
- UGE - UNDERGROUND ELECTRIC LINE
- GAS - NATURAL GAS LINE
- SANITARY MANHOLE
- SANITARY GRAVITY MAIN
- STORM SEWER CATCH BASIN
- CULVERT APRON
- STORM SEWER INLET STRUCTURE
- STORM SEWER MANHOLE
- STORM SEWER GRAVITY MAIN
- CURB STOP
- FIRE HYDRANT
- WATER MAIN LINE

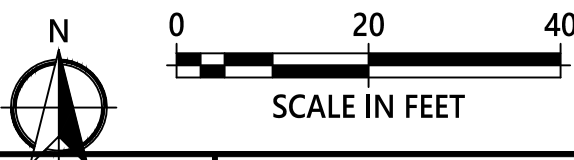


DRAWN BY:
RSH
CHECKED BY:
CNB

I HEREBY CERTIFY THAT THIS PLAN, SPECIFICATION, OR REPORT WAS PREPARED BY ME OR UNDER MY DIRECT SUPERVISION AND THAT I AM A DULY LICENSED PROFESSIONAL PROFESSION UNDER THE LAWS OF THE STATE OF MINNESOTA.
SIGNER NAME _____ LIC. NO.: NUMBER _____ DATE: MM/DD/YYYY _____

DATE	REV#	REVISIONS	DESCRIPTION

GOOD COUNSEL
SITE PLAN-3

PROJECT #: 2025-10591

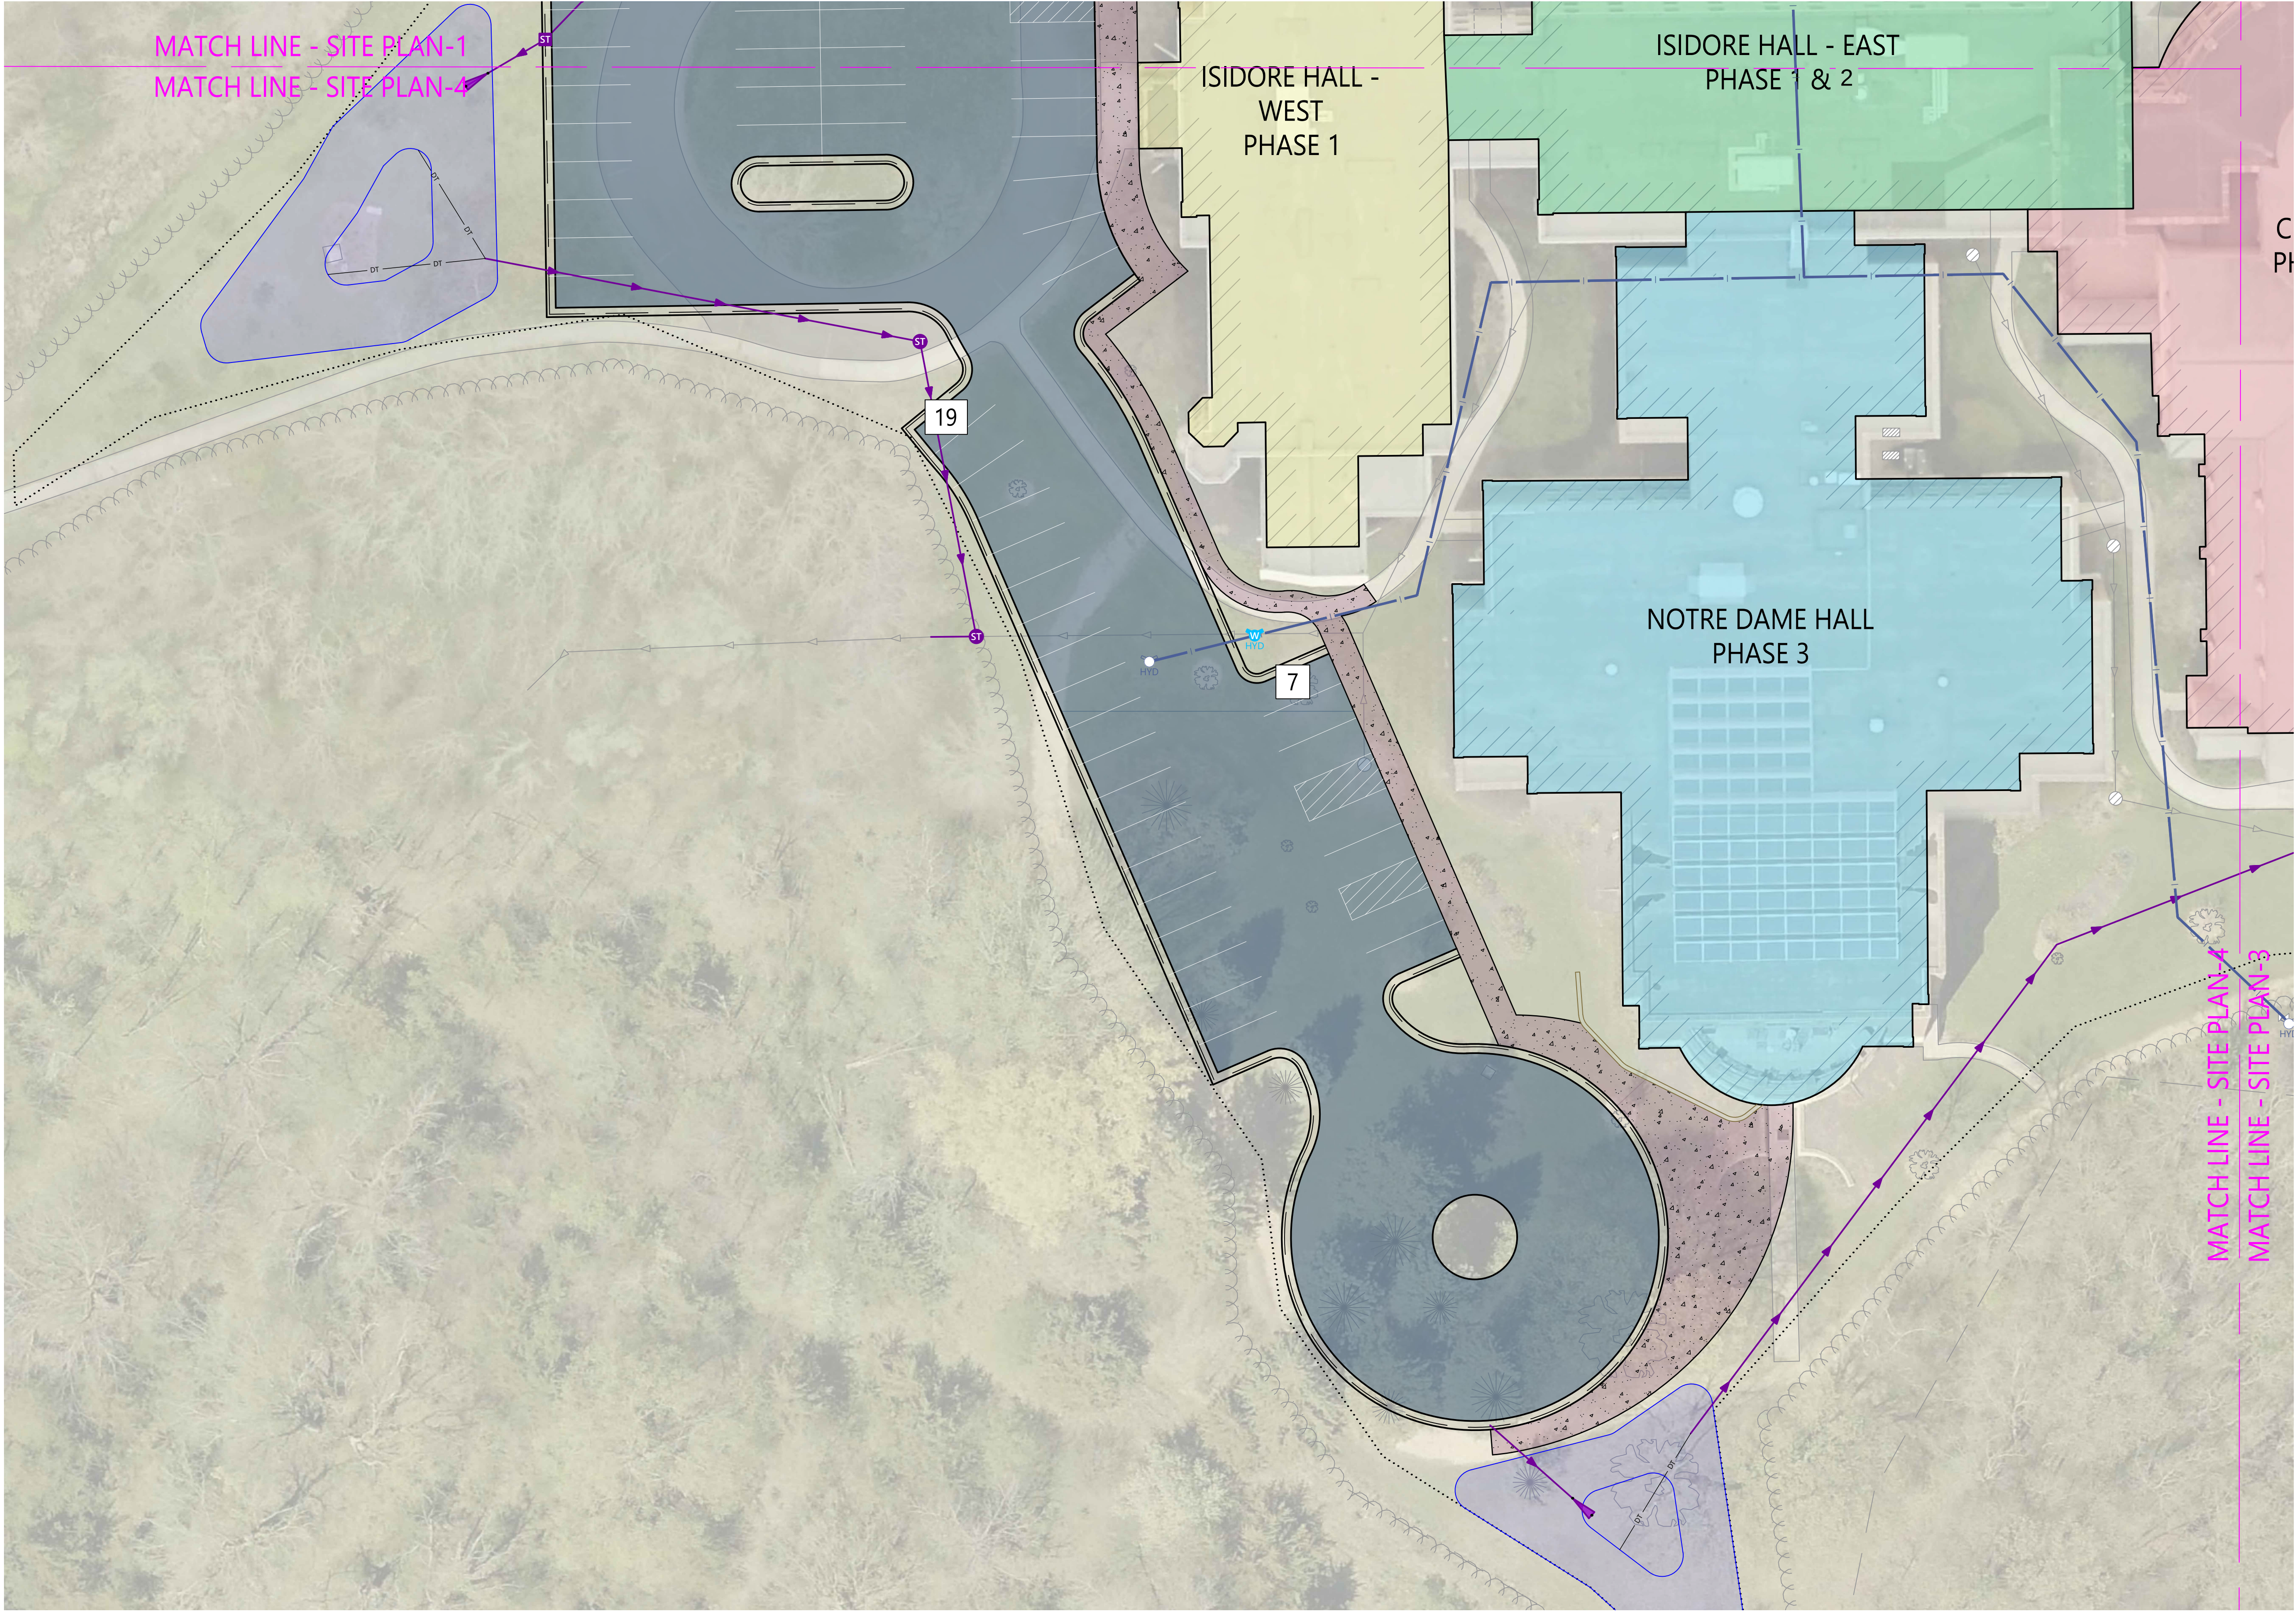


PROPOSED LEGEND

- BITUMINOUS SURFACE
- CONCRETE SURFACE
- CURB & GUTTER
- STORM SEWER CATCH BASIN
- STORM SEWER CLEANOUT
- STORM SEWER INLET STRUCTURE
- STORM SEWER MANHOLE
- STORM SEWER GRAVITY MAIN
- STORM SEWER DRAINTILE
- HYDRANT
- WATER MAIN VALVE
- WATER MAIN PIPE

EXISTING LEGEND

- SHRUB
- TREE - CONIFEROUS
- TREE - DECIDUOUS
- EDGE OF WOODS
- BUILDING
- CHAINLINK FENCE
- RETAINING WALL
- FOC - UNDERGROUND FIBER OPTIC LINE
- OHT - OVERHEAD TELEPHONE LINE
- UGT - UNDERGROUND TELEPHONE LINE
- OHC - OVERHEAD TV LINE
- UGC - UNDERGROUND TV LINE
- FOC - UNDERGROUND FIBER OPTIC LINE
- UGT - UNDERGROUND TELEPHONE LINE
- UGE - UNDERGROUND ELECTRIC LINE
- GAS - NATURAL GAS LINE
- S - SANITARY MANHOLE
- Sanitary Gravity Main
- Storm Sewer Catch Basin
- Culvert Apron
- Storm Sewer Inlet Structure
- Storm Sewer Manhole
- Storm Sewer Gravity Main
- WCS - CURB STOP
- HYD - FIRE HYDRANT
- Water Main Line

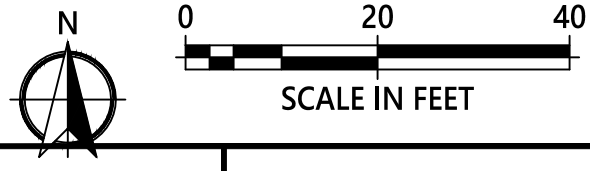

DRAWN BY:
RSH
CHECKED BY:
CNB

I HEREBY CERTIFY THAT THIS PLAN, SPECIFICATION, OR REPORT WAS PREPARED BY ME OR UNDER MY DIRECT SUPERVISION AND THAT I AM A DULY LICENSED PROFESSIONAL PROFESSION UNDER THE LAWS OF THE STATE OF MINNESOTA.

SIGNER NAME _____ LIC. NO.: NUMBER _____ DATE: MM/DD/YYYY _____

DATE	REV#	REVISIONS DESCRIPTION