


2 ROOF PLAN
1/8" = 1'-0"



1 LEVEL 1 FLOOR PLAN
1/8" = 1'-0"

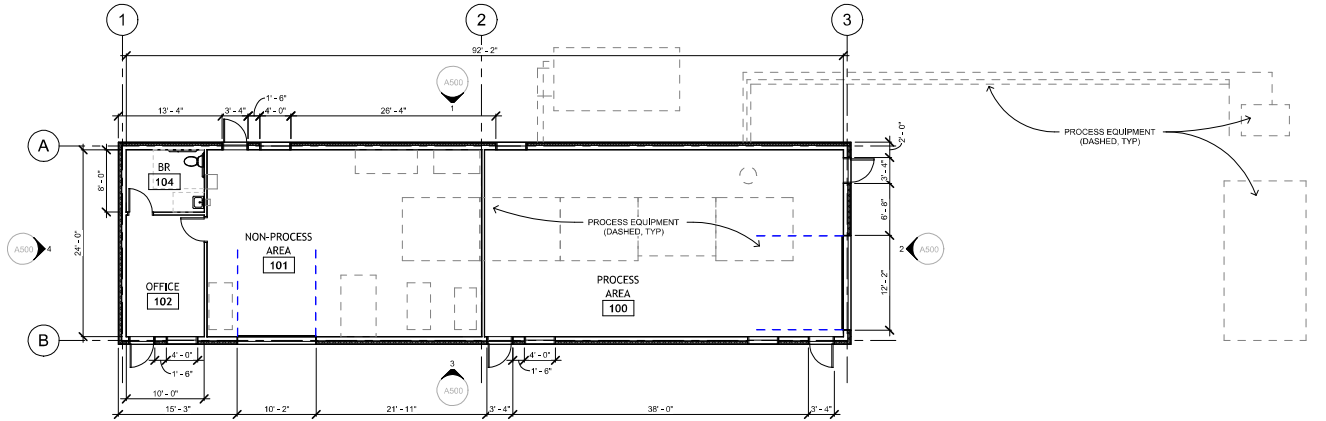

MIDTOWN COMMONS
2324 UNIVERSITY AVE W, SUITE
200, ST. PAUL, MN 55114
PH. 612.338.4590

CENTERPOINT ENERGY - MANKATO
2400 N. RIVERSIDE DR. MANKATO,
MN 56001
CONTACT: DENNIS DAVIS
PHONE: (651) 270-0050

CONSULTANT

PROJECT NAME: CENTERPOINT
ENERGY - MANKATO GREEN
HYDROGEN
PROJECT NUMBER: 19001.001
DATE: 03/27/2026

REVISIONS		
NUMBER	DESCRIPTION	DATE

I HEREBY CERTIFY THAT THIS PLAN,
SPECIFICATION OR REPORT WAS
PREPARED BY ME OR UNDER MY
DIRECT SUPERVISION AND THAT I
AM A DULY LICENSED ARCHITECT
UNDER THE LAWS OF THE STATE OF
MINNESOTA.

PRINT NAME
SIGNATURE
03/27/2026
DATE

Not For
Construction

SHEET TITLE:

FLOOR PLAN AND ROOF
PLAN

SHEET NUMBER:

A210