
 


METCON ADDITION

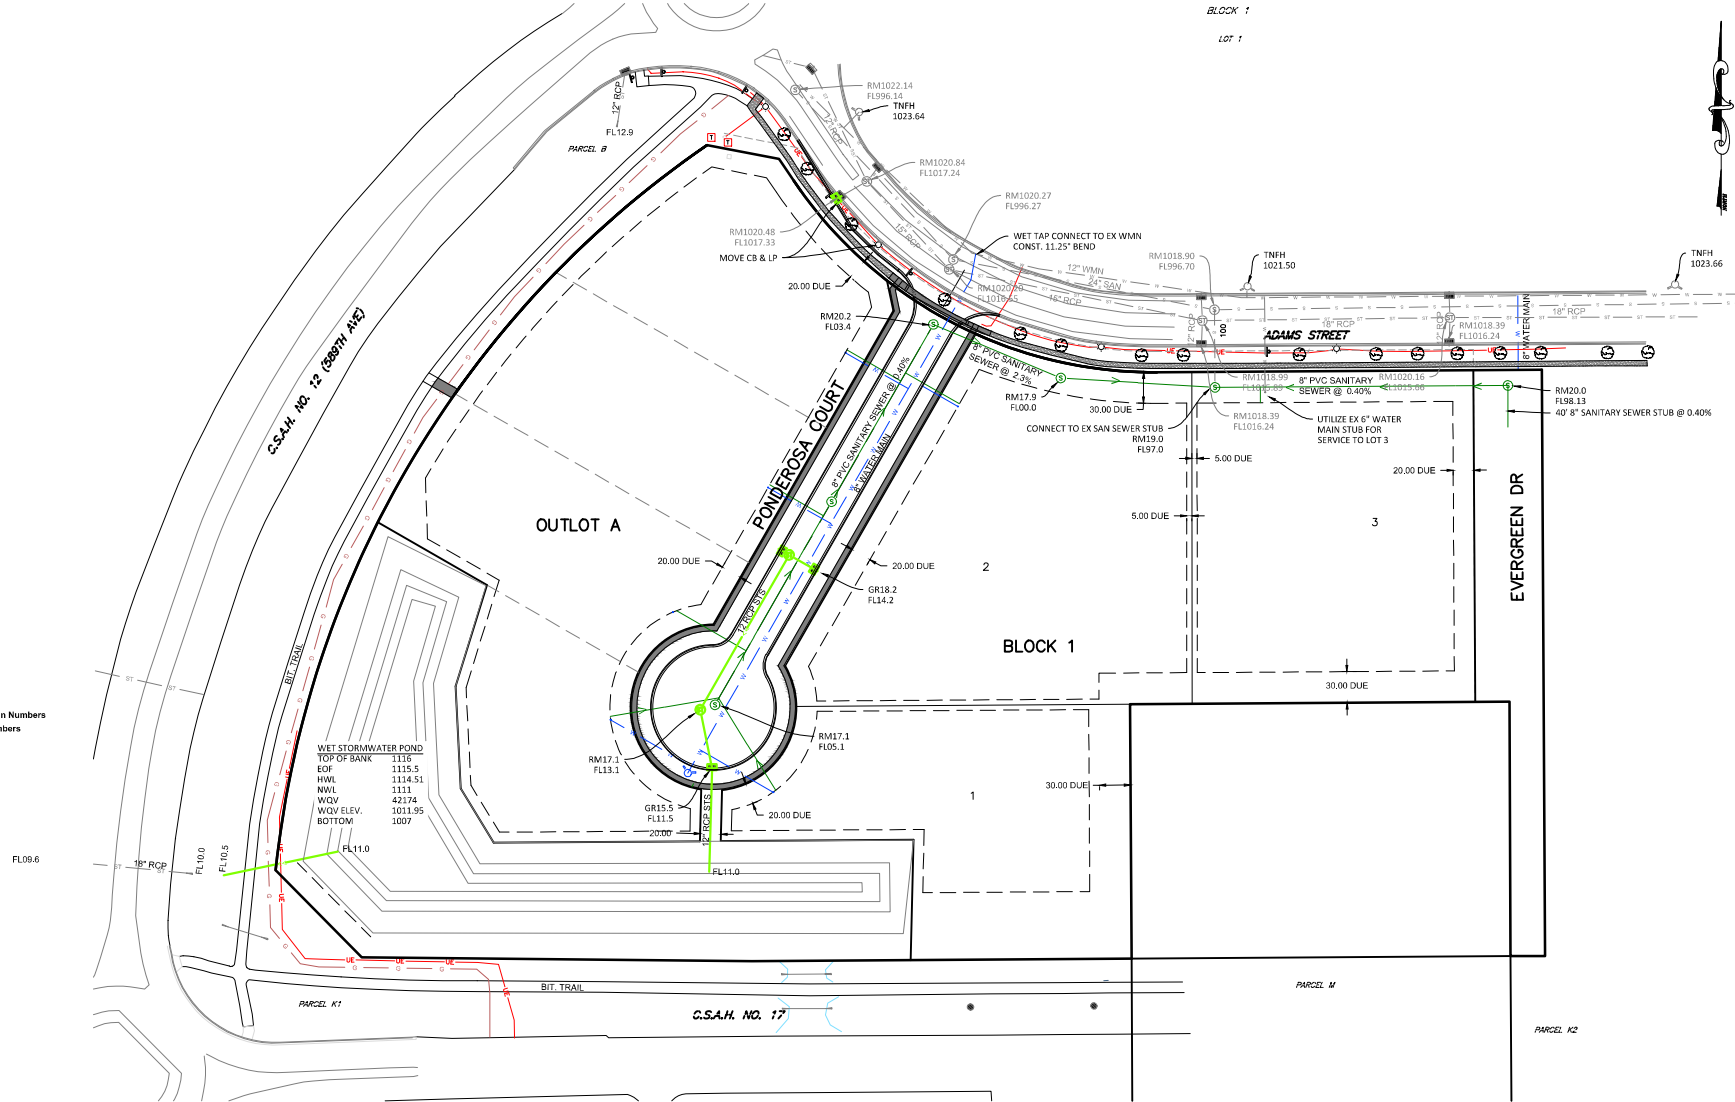

LEGEND

- W = Water Main
- S = Sanitary Sewer
- ST = Storm Sewer
- G = Gas Main
- UT = Underground Telephone
- OT = Overhead Telephone
- FO = Fiber-Optics
- UE = Underground Electric
- OE = Overhead Electric
- UTV = Underground TV
- LM = Judicial Landmark
- CLM = Chain Link Fence
- X = Control Access
- Sign
- Stop Sign
- Light Pole
- Flood Lights
- Power Pole
- Guy Anchor
- Fire Hydrant
- Water Main Valve
- Culvert
- Catch Basin & Catch Basin Numbers
- Manholes & Manhole Numbers
- Elevation Contour Line
- Spot Elevation
- Rim Elevation
- Flow Line Elevation
- Deciduous Tree
- Coniferous Tree
- Bush



REV.	BY	DATE	REVISION DESCRIPTION
-	-	-	-
-	-	-	-
-	-	-	-
-	-	-	-

JONES HAUGH SMITH
Engineers & Surveyors
415 West North Street Owatonna, MN 56045-4598

DESIGNED: JKS
DRAWN: JKS
CHECKED: BJW
Date: 7/28/26
DWG: 25-1234PP

I hereby certify that this plan, specification, or report was prepared by me or under my direct supervision and that I am a duly Licensed Professional Engineer under the laws of the State of Minnesota.
John H. Schulte V
License No. 44639 Date: 7/28/26

PRELIMINARY PLAT	SHEET
METCON ADDITION	2
PART OF SW1/4 SECTION 11-T108N-R26W	OF
UTILITY PLAN	3