


METCON ADDITION

BLOCK 1

LOT 1



- LEGEND**
- W = Water Main
 - S = Sanitary Sewer
 - ST = Storm Sewer
 - G = Gas Main
 - UT = Underground Telephone
 - OT = Overhead Telephone
 - FO = Fiber-Optics
 - UE = Underground Electric
 - OE = Overhead Electric
 - UTV = Underground TV
 - JLM = Judicial Landmark
 - X = Chain Link Fence
 - Control Access
 - Sign
 - Stop Sign
 - Light Pole
 - Flood Lights
 - Power Pole
 - Guy Anchor
 - Fire hydrant
 - Water Main Valve
 - Culvert
 - Catch Basin & Catch Basin Numbers
 - Manholes & Manhole Numbers
 - Elevation Contour Line
 - Spot Elevation
 - Rim Elevation
 - FlowLine Elevation
 - Deciduous Tree
 - Coniferous Tree
 - Bush

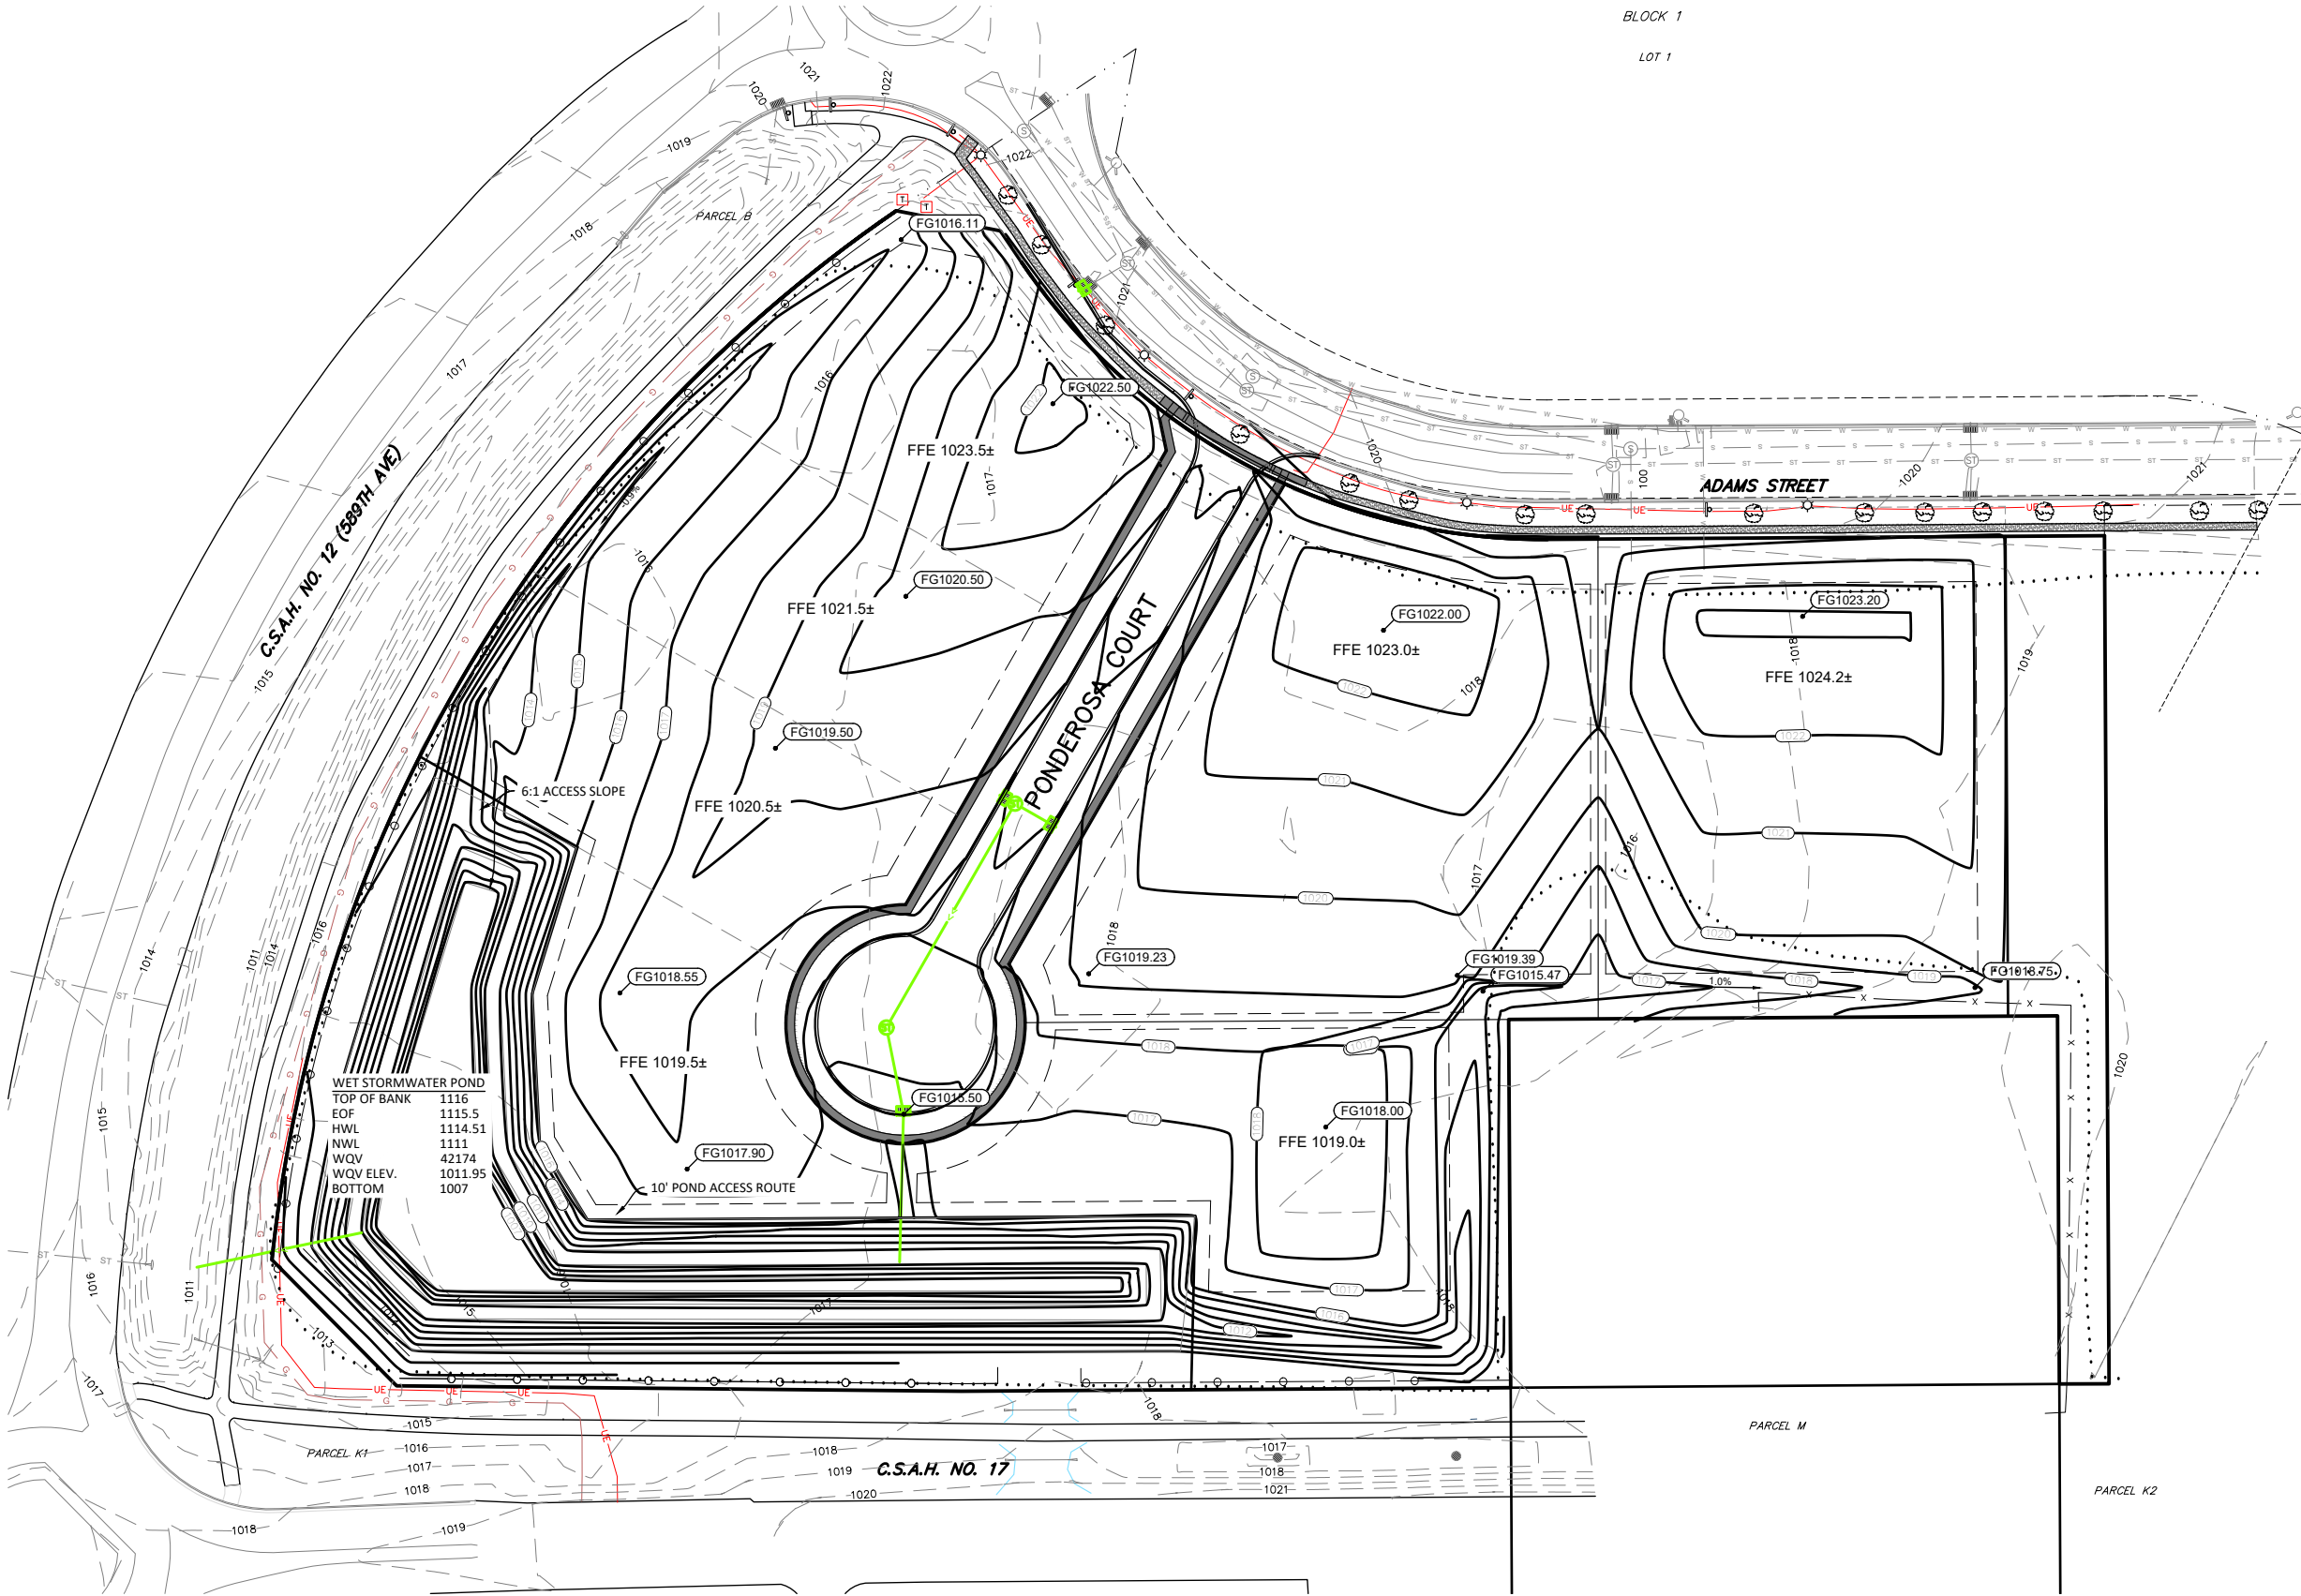

NOTE: CONTOUR SHOWN ARE FOR MASS GRADING AND INCLUDE A 1' HOLD-DOWN AT BUILDING PADS

 


REV.	BY	DATE	REVISION DESCRIPTION

 **JONES HAUGH SMITH**
Engineers + Surveyors
415 West North Street Owatonna, MN 56045-4598

DESIGNED: JHS
DRAWN: JHS
CHECKED: BJU
Date: 8/13/26
DWG: 25-1234PP

I hereby certify that this plan, specification, or report was prepared by me or under my direct supervision and that I am a duly Licensed Professional Engineer under the laws of the State of Minnesota.


John H. Schulte V
License No. 44639 Date: 8/13/26

PRELIMINARY PLAT	SHEET
METCON ADDITION	2
PART OF SW1/4 SECTION 11-T108N-R26W	OF
GRADING PLAN	2