


PLANTING SCHEDULE						
QTY.	KEY	COMMON NAME	BOTANICAL NAME	SIZE	MTHD	REMARKS
2	AB	AUTUMN BLAZE MAPLE	ACER FREEMANII	2.5" CAL.	BB	
2	IH	IMPERIAL HONEYLOCUS	GLEDITSIA TRICANTHOS	2.5" CAL.	BB	
1	RS	RED SPLENDOR CRAB	MALUS*HYBRIDS 'RED SPLENDOR'	1.5" CAL.	BB	
9	SR	SHRUB ROSE	ROSA 'KNOCKOUT'	12" TALL	CONT.	
8	BB	COMPACT BURNING BUSH	EUONYMUS ALATUS 'COMPACTA'	18"-24" TALL	CONT.	
5	PL	PURPLE LILAC	SYRINGA VULGARIS PURPUREA	36" TALL	CONT.	

LANDSCAPE NOTES:


- SEED/SOD AREAS AS SHOWN ON THE PLAN.
- SEE PLAN FOR PLANTINGS LOCATED IN ROCK MULCH BED. ROCK MULCH BEDS SEPARATED FROM SOD BY BLACK VINYL EDGER. OTHER PLANTINGS TO HAVE WOOD MULCH RING TO PREVENT WEED GROWTH AND CONSERVE WATER.
- UNDERGROUND IRRIGATION SYSTEM TO BE PROVIDED FOR ALL FOUNDATION PLANTINGS AND TURF AREAS. PROVIDE MOISTURE SENSOR. IRRIGATION DESIGN BY CONTRACTOR.
- SEE PLAN FOR EXISTING TREES TO BE SAVED OR REMOVED
- TREE CALCULATION:
1 TREE PER 1,000 S.F. OF BUILDING S.F.
4,048 S.F. @ 1/1000 = 4 DECIDUOUS TREES
5 TREES PROVIDED
- SHRUB CALCULATION:
1 SHRUB PER 300 S.F. OF BUILDING S.F.
4,048 S.F. @ 1/300 = 14 SHRUBS
22 SHRUBS PROVIDED

SITE LIGHTING NOTES:

- LIGHTING SHOWN FOR SCHEMATIC PURPOSES ONLY. LIGHTING IS DESIGN-BUILD BY ELECTRICAL CONTRACTOR. VERIFY SIZE, STYLE, QUANTITY, AND LOCATION W/ OWNER AND CONTRACTOR. PROVIDE LIGHTING PHOTOMETRICS IF NECESSARY AT CITY'S REQUEST.
- ALL LIGHTING IS TO BE SHIELDED/DIRECTED AWAY FROM ADJACENT PROPERTIES AND STREET RIGHT OF WAYS.
- PROVIDE EMERGENCY EXIT LIGHTING AT ALL EXIT DOORS.

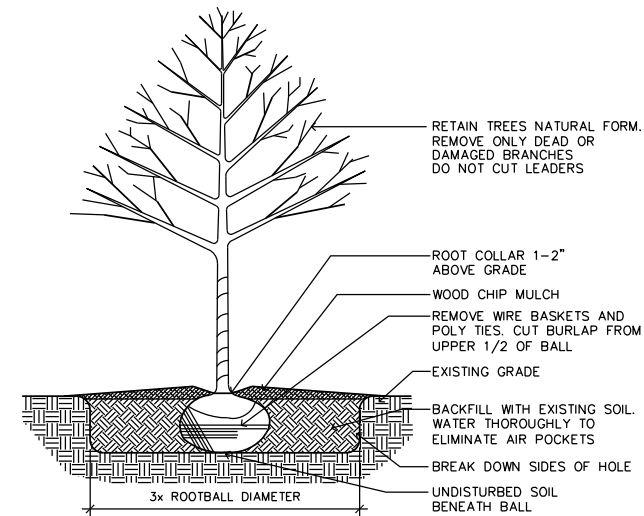


2 TREE PLANTING DETAIL
L1 SCALE: NOT TO SCALE

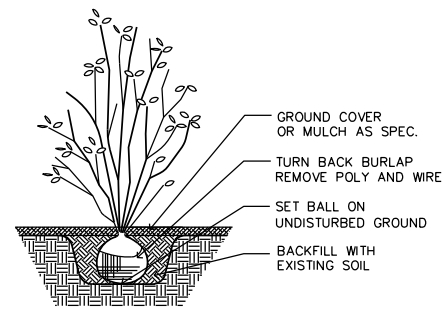

3 SHRUB PLANTING DETAIL
L1 SCALE: NOT TO SCALE

1 LANDSCAPE AND SITE LIGHTING
L1 SCALE: 1" = 20'-0"

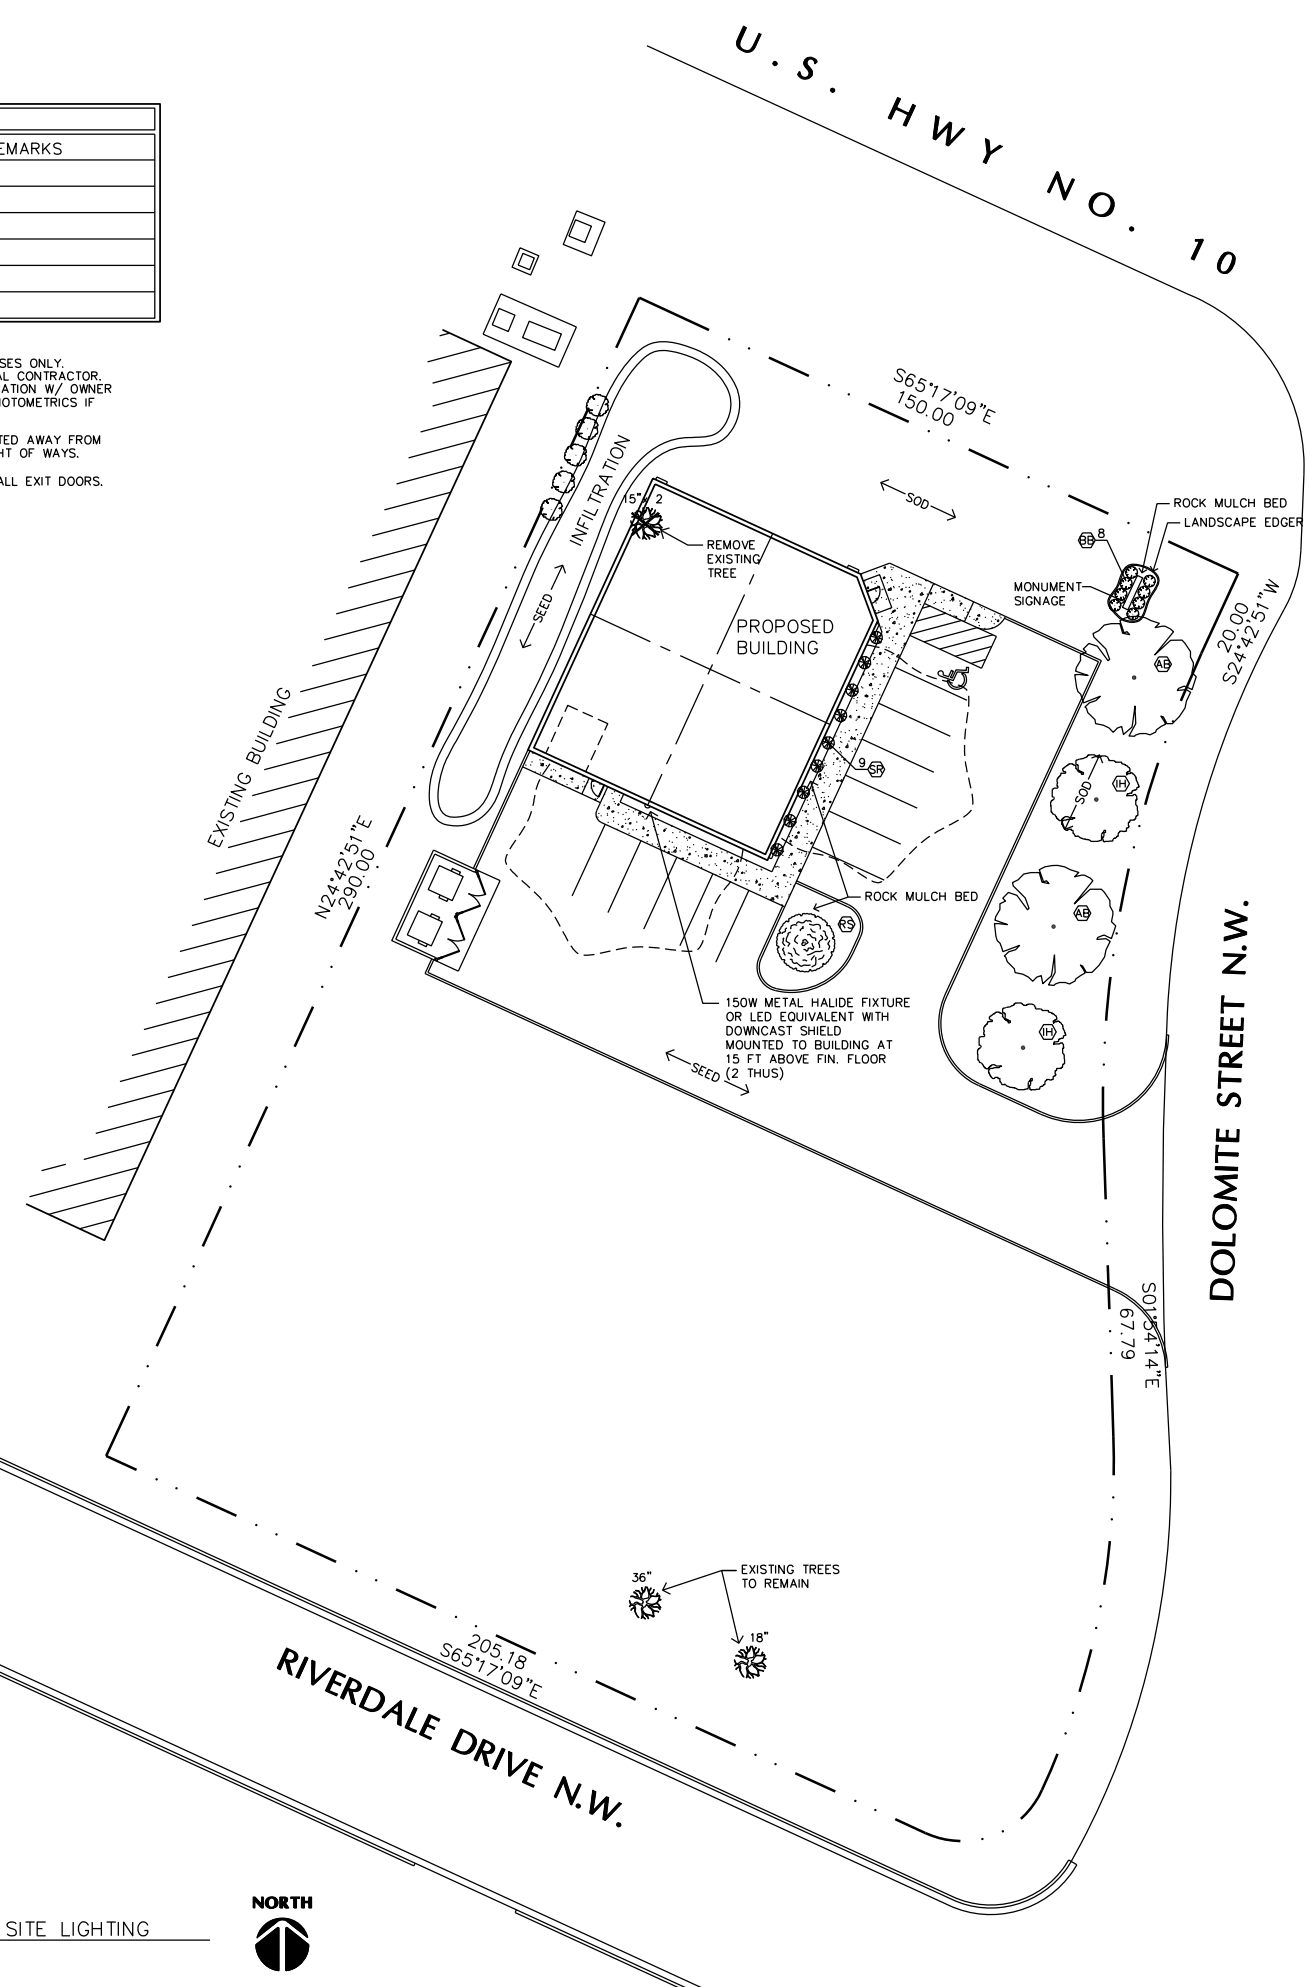

**PRELIMINARY
NOT FOR
CONSTRUCTION**

(763) 784-1950
FAX 784-9707
STONE CONSTRUCTION, INC.
2181 - 107th LANE N.E.
BLAINE, MINNESOTA 55434

STERLING TROPHY
Ramsey, Minnesota

Drawn By: JRB
Checked By: LL
Revisions
6/28/18 PRELIMINARY

**LANDSCAPE AND
SITE LIGHTING PLAN**
Sheet Number

L1