




**UTILITY NOTES**


1. See Sheet C400 for Utility Notes.

**SYMBOL LEGEND**

○	STORM MANHOLE	— CTV —	CABLE UNDERGROUND LINE
○	CATCH BASIN	— OE —	ELECTRIC OVERHEAD LINE
□	CURB INLET	— UE —	ELECTRIC UNDERGROUND LINE
▲	FLARED END	— FO —	FIBER OPTIC UNDERGROUND LINE
○	SANITARY MANHOLE	— GAS —	NATURAL GAS UNDERGROUND LINE
○	HYDRANT	— S —	SANITARY SEWER PIPE
⊗	GATE VALVE & BOX	— T —	STORM SEWER PIPE
⊗	WATER SHUTOFF	— DT —	TELEPHONE UNDERGROUND LINE
⊙	LIGHT POLE	— W —	WATERMAIN PIPE
		— DT —	DRAIN TILE PIPE
		— T —	TREE PROTECTION
		— P —	PROPERTY LINE
		— R —	RIGHT OF WAY LINE
		— E —	EASEMENT LINE
		— S —	SETBACK LINE
		— W —	WETLAND
		— B —	WETLAND BUFFER

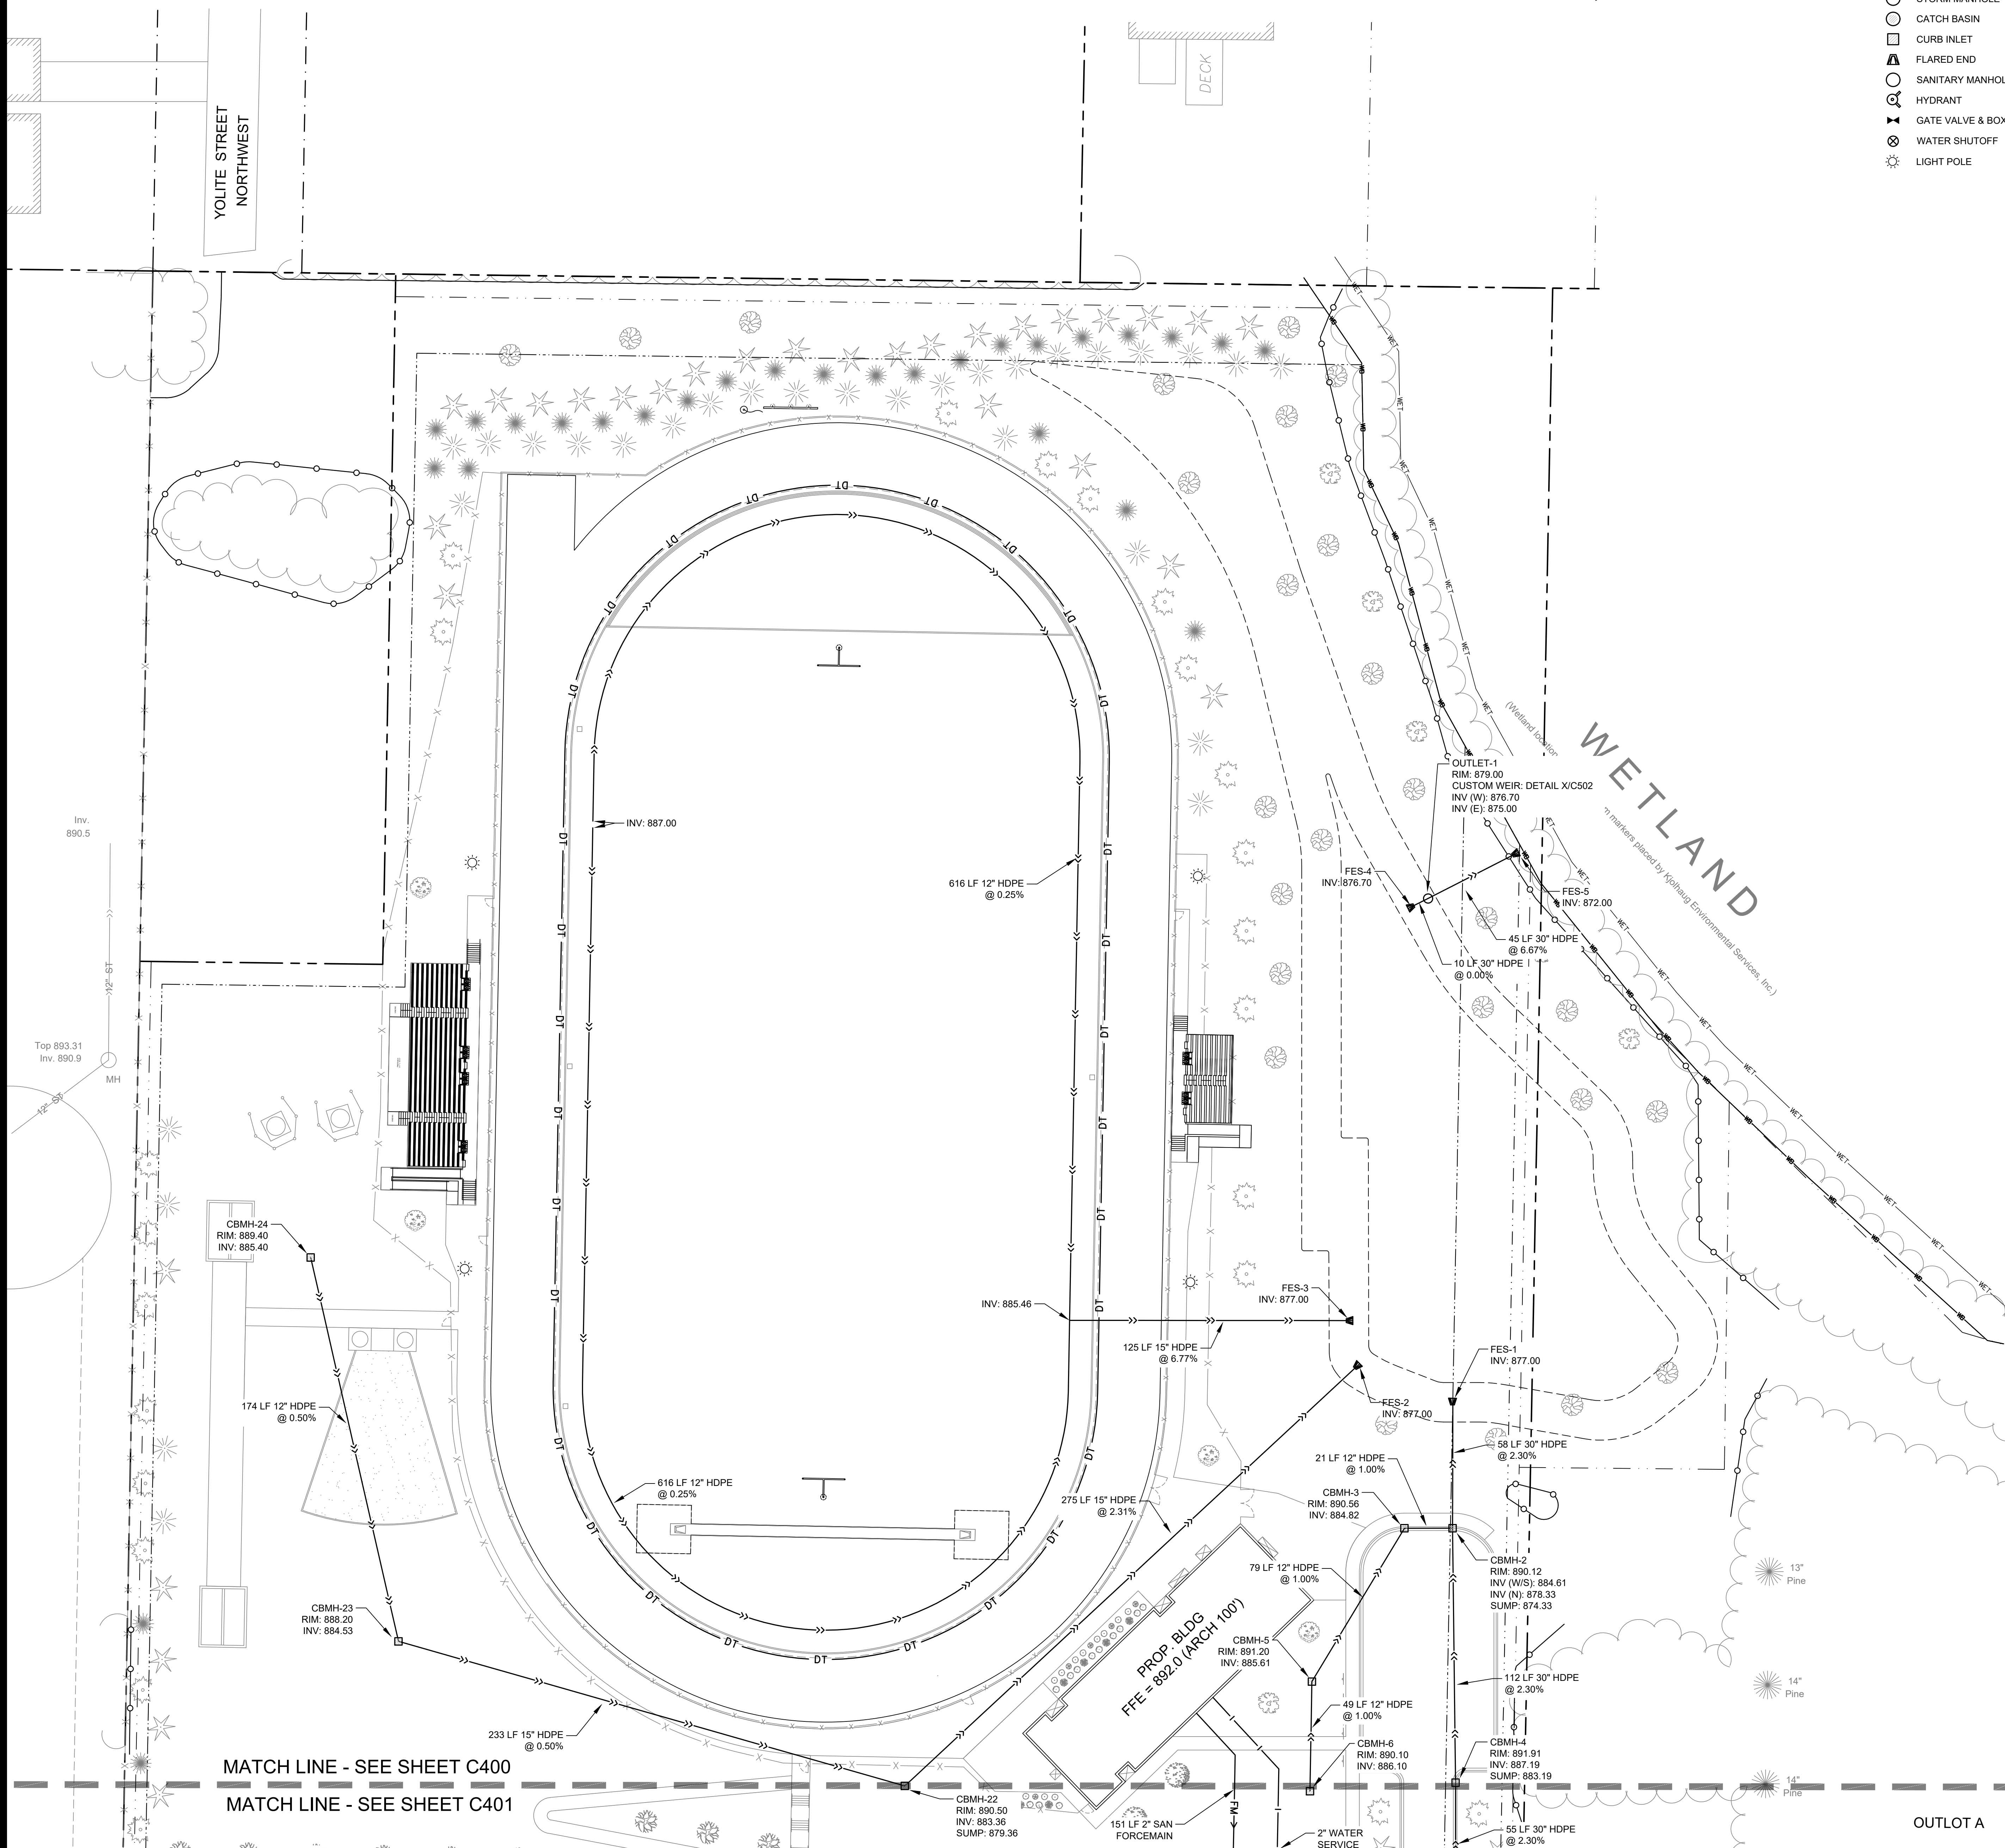

MATCH LINE - SEE SHEET C400  
MATCH LINE - SEE SHEET C401

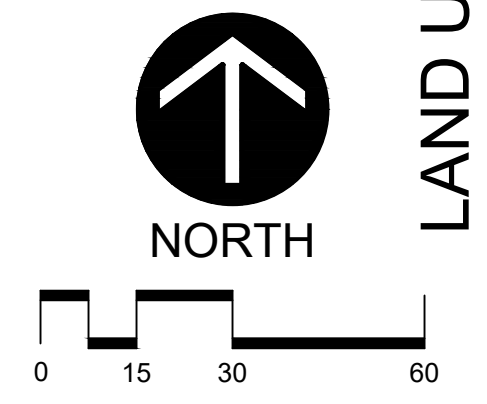

**POPE ARCHITECTS**

POPE ARCHITECTS, INC.  
767 NORTH EUSTIS ST., SUITE 190  
ST. PAUL, MN 55114  
(651) 642-9200 | FAX (651) 642-1101  
www.popearch.com

**PACT Charter School**

**Larson Engineering, Inc.**  
3524 Labore Road  
White Bear Lake, MN 55110  
651.481.9120 (F) 651.481.9201  
www.larsonengr.com  
© 2022 Larson Engineering, Inc. All rights reserved.

PACT CHARTER SCHOOL  
RAMSEY, MN

**UTILITY PLAN NORTH**

Issue of Revision:

NO.	DESCRIPTION	DATE
1	CITY RE-SUBMITTAL	6.10.2022

I hereby certify that this plan, specifications or report was prepared by me or under my direct supervision and that I am a duly Licensed Professional Engineer under the laws of the state of Minnesota.

*Eric G. Meyer*  
Eric G. Meyer, P.E.  
Date: 06.10.2022 Lic. No.: 44592

Revision No.	12216178
Drawn by	MTH
Checked by	EGM

SHEET  
**C401**

SCALE: 1" = 15'

LAND USE APPLICATION SET - NOT FOR CONSTRUCTION