

CITY OF RAMSEY

CONSTRUCTION PLANS FOR


LIFT STATION NO. 1 GENERATOR

CITY IMPROVEMENT PROJECT # 24-56
 GRADING, AGGREGATE BASE, CONCRETE GENERATOR PAD, ELECTRICAL, EROSION CONTROL
 MAY 2024

RESOURCE LIST

CITY OF RAMSEY

City Hall
 7550 Sunwood Drive NW.
 Ramsey, MN 55303

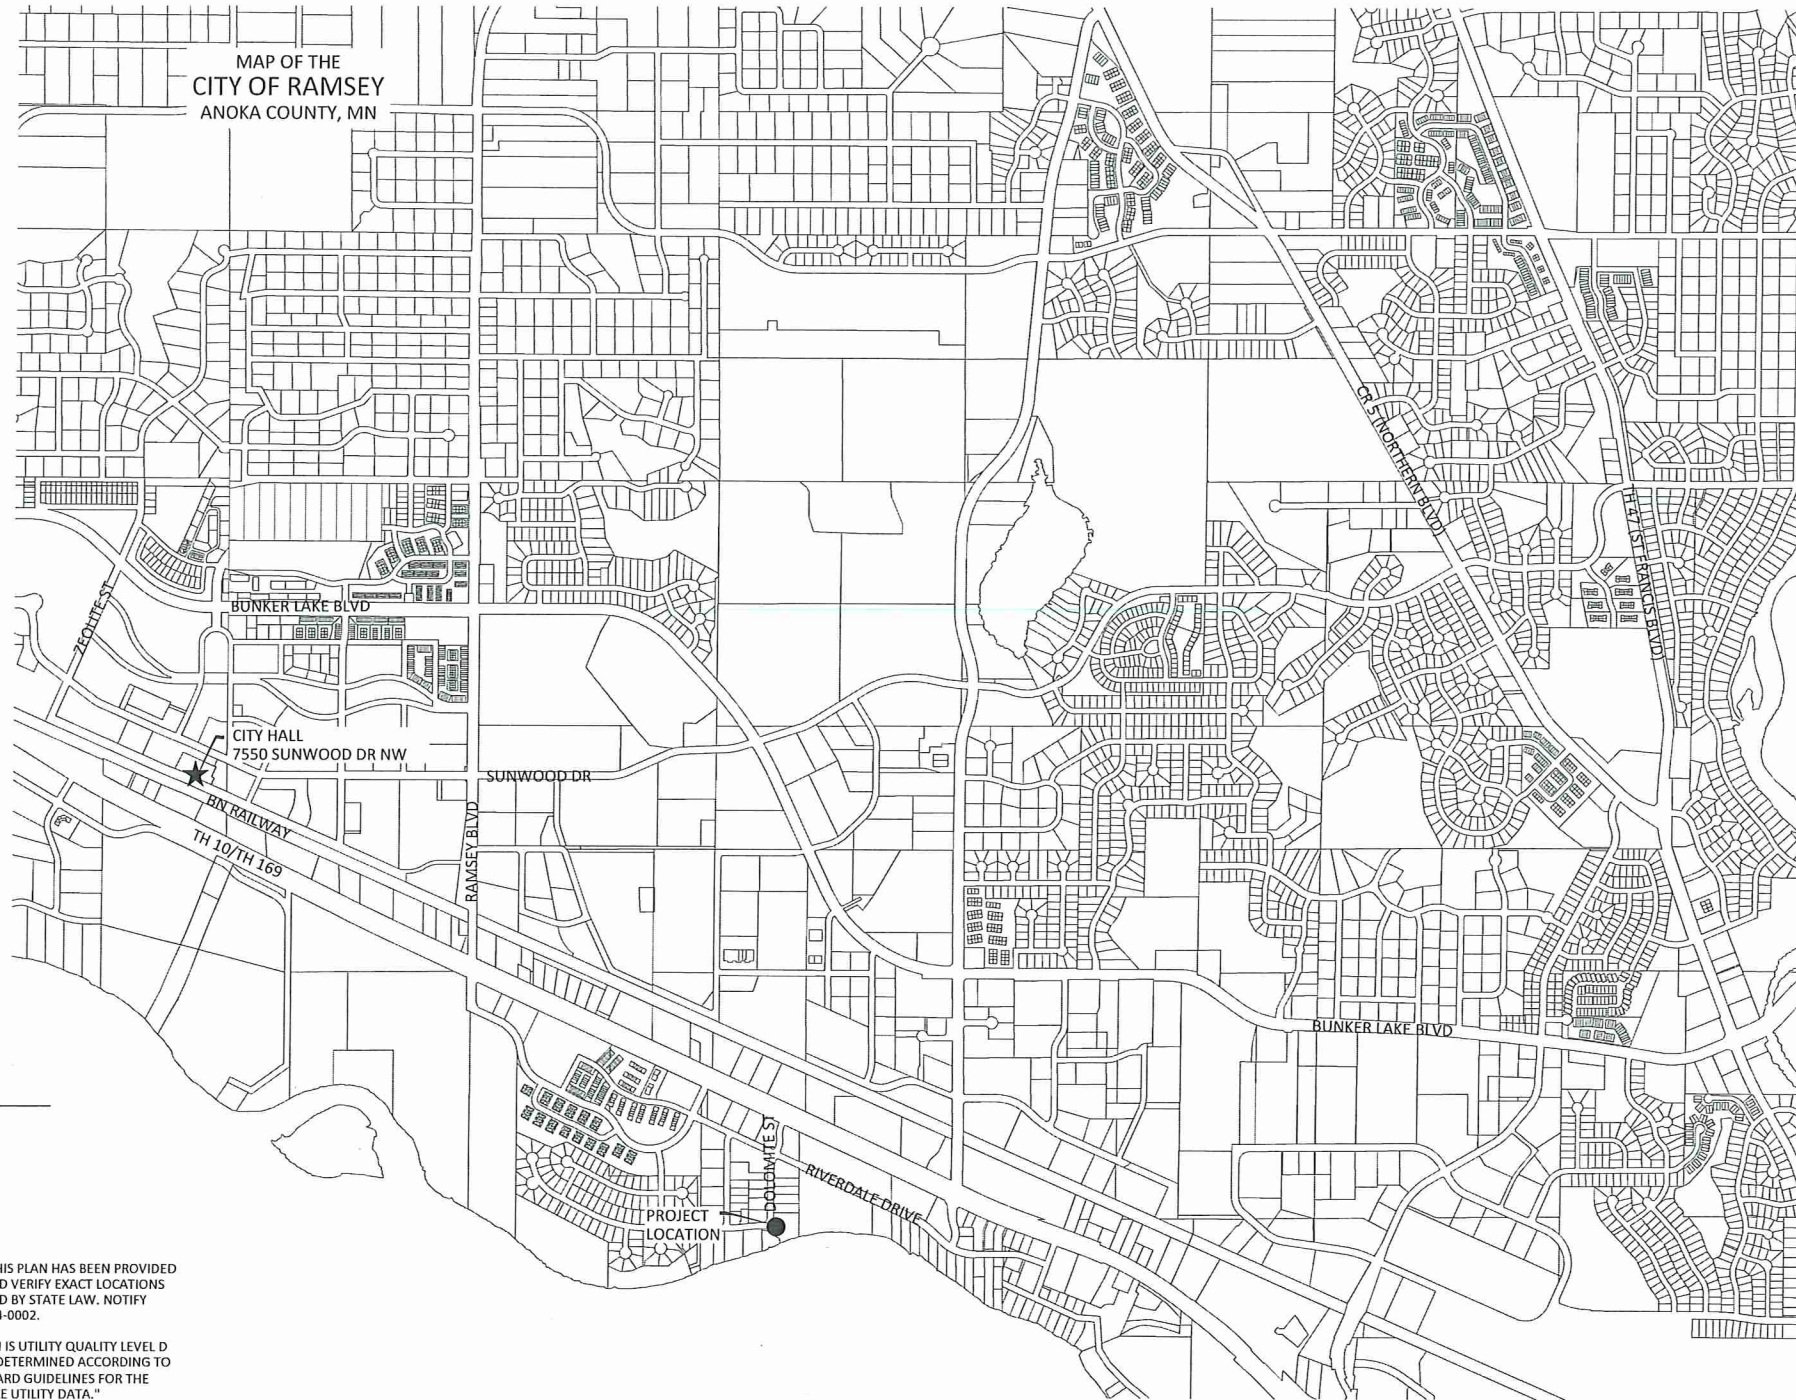

| SHEET NUMBER | SHEET TITLE |
|--------------|------------------|
| 1 | TITLE SHEET |
| 2 | LEGEND |
| 3 | SITE LAYOUT PLAN |
| 4 - 6 | ELECTRICAL PLAN |

THIS PLAN SET CONTAINS 6 SHEETS.


MAP LEGEND

- ★ RAMSEY CITY HALL
7550 SUNWOOD DRIVE NW
- PROJECT LOCATION
13659 137TH AVE NW

I HEREBY CERTIFY THAT THIS PLAN, SPECIFICATION, OR REPORT WAS PREPARED BY ME OR UNDER MY DIRECT SUPERVISION AND THAT I AM A DULY LICENSED PROFESSIONAL ENGINEER UNDER THE LAWS OF THE STATE OF MINNESOTA.

Zachary F. Wigg REG. NO. 56344 DATE: 05/31/2024
 ZACHARY F. WIGG, P.E.

REVIEWED & APPROVED *Brian W. [Signature]* DATE: 6/4/2024
 CITY OF RAMSEY ENGINEER / DIRECTOR OF PUBLIC WORKS

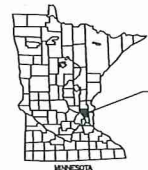

PROJECT LOCATION
 CITY OF RAMSEY
 ANOKA COUNTY, MN

NOTE: EXISTING UTILITY INFORMATION SHOWN ON THIS PLAN HAS BEEN PROVIDED BY THE UTILITY OWNER. THE CONTRACTOR SHALL FIELD VERIFY EXACT LOCATIONS PRIOR TO COMMENCING CONSTRUCTION AS REQUIRED BY STATE LAW. NOTIFY GOPHER STATE ONE CALL, 1-800-252-1166 OR 651-454-0002.

THE SUBSURFACE UTILITY INFORMATION IN THIS PLAN IS UTILITY QUALITY LEVEL D UNLESS OTHERWISE NOTED. THIS UTILITY LEVEL WAS DETERMINED ACCORDING TO THE GUIDELINES OF C/ASCE 38-02, ENTITLED "STANDARD GUIDELINES FOR THE COLLECTION AND DEPICTION OF EXISTING SUBSURFACE UTILITY DATA."

| PROJECT DATUM: | | RECORD DRAWING INFORMATION |
|----------------|--|----------------------------|
| HORIZONTAL: | ANOKA COUNTY COORDINATE SYSTEM NAD 83 (2011) | DRAWN: |
| VERTICAL: | NAVD 88 | CONTRACTOR: |
| | | DATE: |

7533 SUNWOOD DR NW, SUITE 206
 RAMSEY, MN 55303
 Phone: (763) 433-2851
 Email: Ramsey@bolton-menk.com
 www.bolton-menk.com

| DESIGNED | NO. | ISSUED FOR | DATE |
|------------------|----------|------------|------|
| TH | | | |
| DRAWN | SI | | |
| CHECKED | ZL | | |
| CLIENT PROJ. NO. | CP 24-56 | | |

| | | |
|---|--|-----------------------|
| CITY OF RAMSEY, MINNESOTA | | SHEET 1 OF 6 |
| LIFT STATION NO. 1 GENERATOR IMPROVEMENTS | | |
| TITLE SHEET | | |

© Bolton & Menk, Inc. 2024. All Rights Reserved.
 P:\Projects\2024\24-56\13659 137th Ave NW.dwg 5/31/2024 10:27:15 AM