





FINISH LEGEND		
Exterior Finish	Thin Brick Veneer	Endicott Thin Brick Veneer, stacked bond color: Manganese Ironspot smooth finish
Exterior Finish	Hardie Reveal Panel System WZ10, Smooth Finish	Painted to match Sherwin Williams "Skyline Steel" SW 1015
Exterior Finish	3.5" HardieTrim	Painted to match Sherwin Williams "Inkwell" SW 6992, Eggshell Finish
Window Frames	Dark Bronze Aluminum	
Door Frames	Insulated Hollow Metal Door and Frame	Painted to match Sherwin Williams "Inkwell" SW 6992, Eggshell Finish
Exterior Accents	Black 20 Gauge Metal	



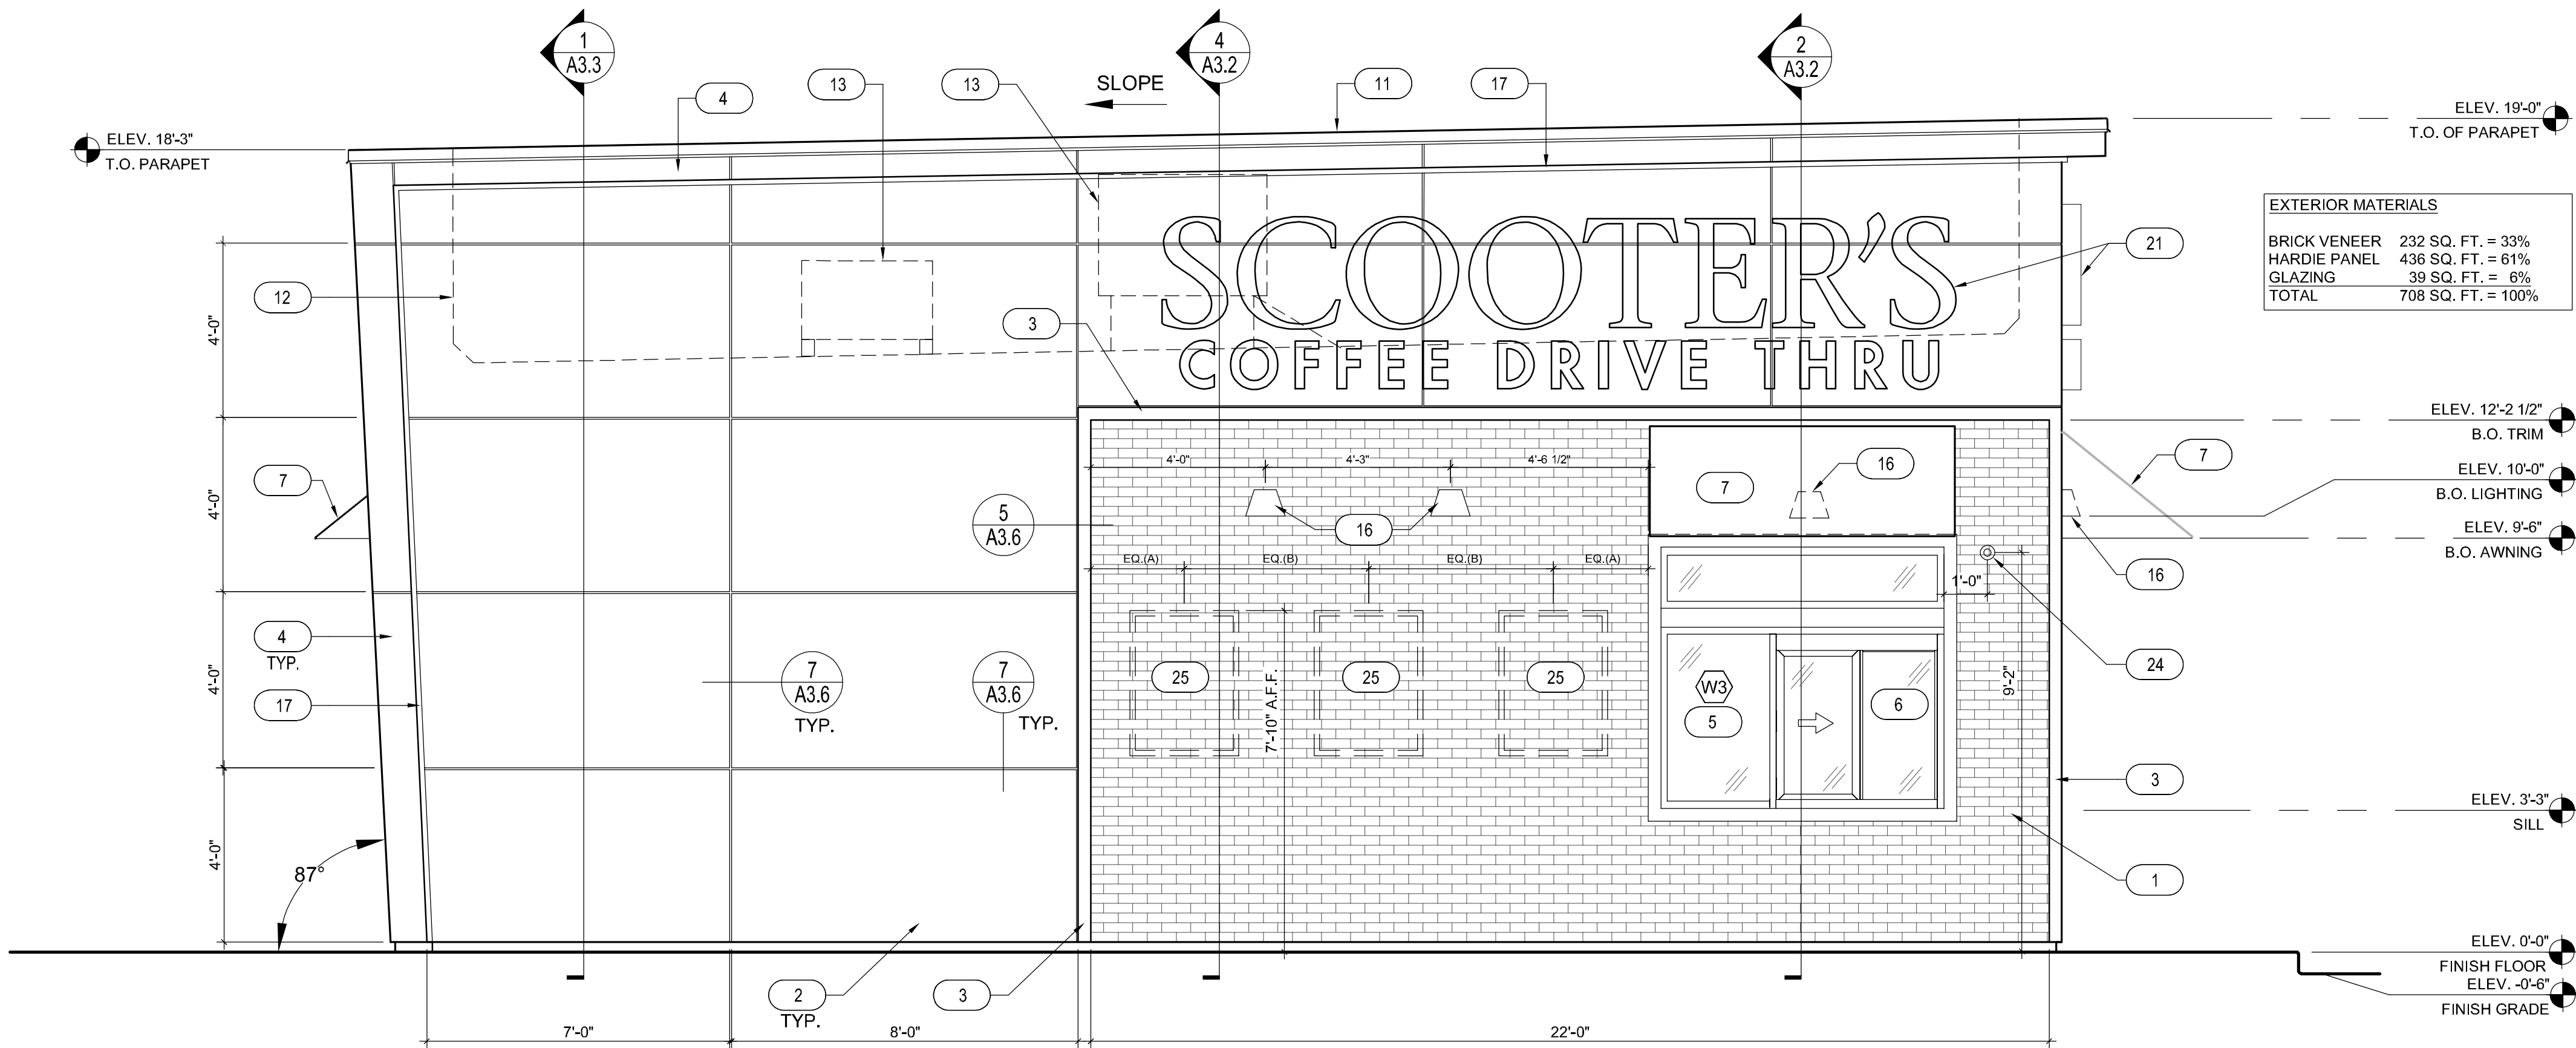

2 SOUTH ELEVATION
SCALE: 3/8" = 1'-0"

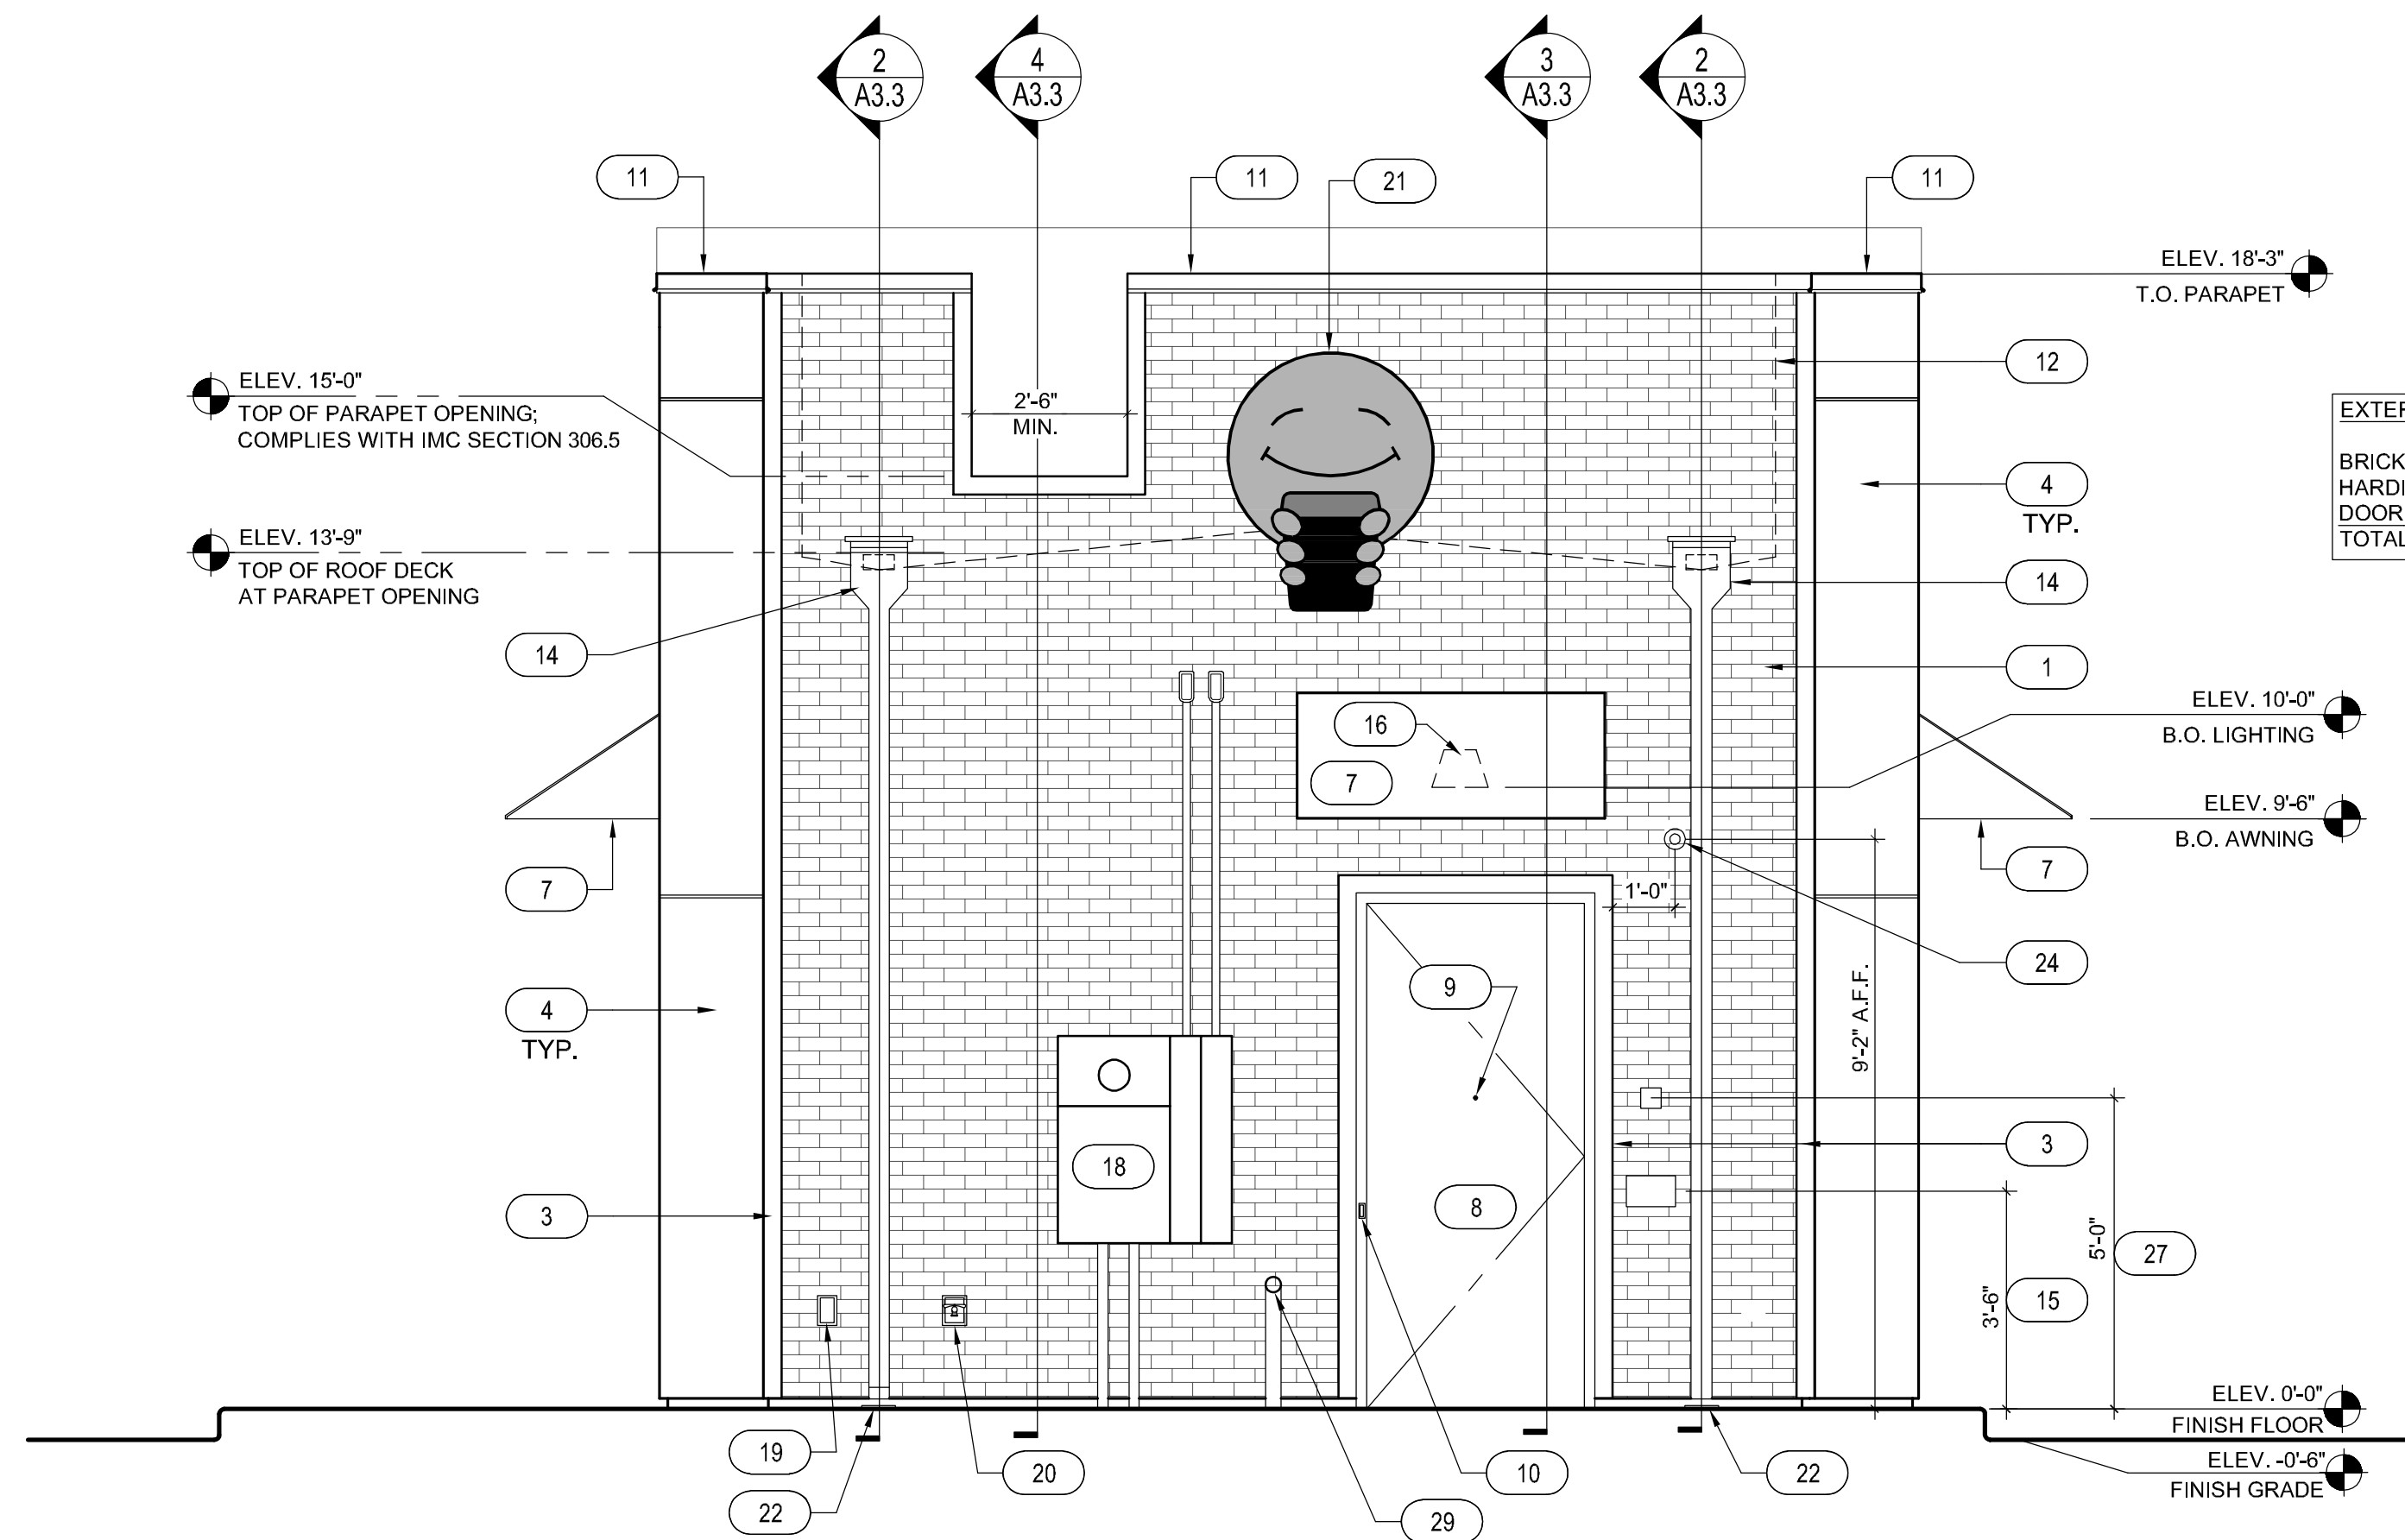

1 WEST ELEVATION
SCALE: 3/8" = 1'-0"

KEYNOTES

- ENDICOTT THIN BRICK VENEER, STACKED BOND - COLOR: MANGANESE IRONSPOT, SMOOTH FINISH. CLASS 1 MATERIAL PER FIGURE 152.392.01
- 4' x 8' HARDIE PANEL, SMOOTH FINISH, COLOR: SW 1015 SKYLINE STEEL. REFER TO SHEET A3.6 FOR HARDIE PANEL DETAILS
- 3 1/2" HARDIE TRIM, SEE HARDIE DETAIL SHEET A3.6. COLOR: SHERWIN WILLIAMS SW6992 INKWELL EGGSHELL FINISH. PRODUCT: SUPERPAINT STAIN.
- HARDIE PANEL FASCIA AND SOFFITS, COLOR: SW6992 INKWELL. REFER TO SHEET A3.6 FOR HARDIE PANEL DETAILS. ALLURA SIDING ACCEPTABLE ALTERNATE TO HARDIE BOARD.
- INSULATED DARK BRONZE ALUMINUM WINDOWS WITH DUAL PANE TEMPERED GLASS.
- QUIKSERV WINDOW - COLOR: DARK BRONZE; REFER TO DOOR SCHEDULE SHEET A5.1
- AWNING BY COOL PLANET - FABRIC: SUNBRELLA, COLOR: LOGO RED, PROVIDED AND INSTALLED BY G.C. (UNDER SEPARATE PERMIT, IF REQUIRED).
- INSULATED HOLLOW METAL DOOR AND FRAME - COLOR: SHERWIN WILLIAMS SW6992 INKWELL EGGSHELL FINISH. PRODUCT: PROINDUSTRIAL W/B ALKYD URETHANE - S/G.
- PEEP HOLE, BY DOOR MANUFACTURER
- DOOR BELL
- 20 GAUGE METAL PARAPET CAP - COLOR: MATTE BLACK
- LINE OF ROOF BEYOND
- ROOF TOP UNIT BEYOND, REFER TO MECHANICAL DRAWINGS
- ROOF SCUPPER AND DOWNSPOUT, REFER TO DETAIL 8/A3.4
- CONTRACTOR SHALL PROVIDE A BLACK MAILBOX APPROXIMATELY 15 INCHES WIDE BY 6 INCHES TALL. MAILBOX SHALL BE EQUAL TO GIBALTAR WALL MOUNTED METAL BOX
- WALL MOUNTED LIGHT FIXTURE, REFER TO ELECTRICAL DRAWINGS
- LED LIGHT BAND, REFER TO ELECTRICAL DRAWINGS
- ELECTRICAL SERVICE, REFER TO ELECTRICAL DRAWINGS
- ELECTRICAL OUTLET, SEE ELECTRICAL DRAWINGS
- HOSE BIBB, SEE PLUMBING DRAWINGS
- SIGNAGE BY OTHERS, UNDER A SEPARATE PERMIT
- SEE DETAIL 7/A3.4 FOR DOWNSPOUT TERMINATION & SPLASHBLOCK
- SPANDREL GLASS; REFER TO WINDOW SCHEDULE
- SECURITY CAMERA BY OTHERS
- OWNER PROVIDED SIGN PANELS.
- APPROVED SET OF NUMERALS, MINIMUM 4" HIGH WITH A STROKE WIDTH NOT LESS THAN 1/2 INCH, SHALL BE PLACED ON THE BUILDING. VERIFY SIZE AND REQUIREMENTS WITH FIRE MARSHAL.
- GAS METER; REFER TO PLUMBING PLANS.
- SCHIER GREASE TRAP PUMP-OUT PORT PP3, PAINT TO MATCH EXTERIOR FINISH.

REGISTRATION SEAL

NOT FOR
CONSTRUCTION



ARCVISION
ARCHITECTURE • ENGINEERING

1950 CRAIG ROAD, SUITE 300
ST. LOUIS, MO 63146
(314) 415-2400
WWW.ARCVY.COM



BY

DESCRIPTION

DATE

REV

1

2

3

4

5

6

7

8

9

TITLE:

EXTERIOR
ELEVATIONS

PROJECT ADDRESS:
SWC SUNWOOD DR. NW
& RAMSEY BLVD. NW,
RAMSEY, MN 55303
FRANCHISEE & STORE NUMBER:
SCOOTER'S COFFEE #2965
DANIEL & NATALIE DEWEY

KIOSK PROTOTYPE:
4.3 STANDARD PROTOTYPE
FEBRUARY 2026

ISSUE DATE:
07/XX/2026


PROJECT NO.
260351

DRAWN BY:
AGG


CHECKED BY:
MD

SHEET NO.

A2.1

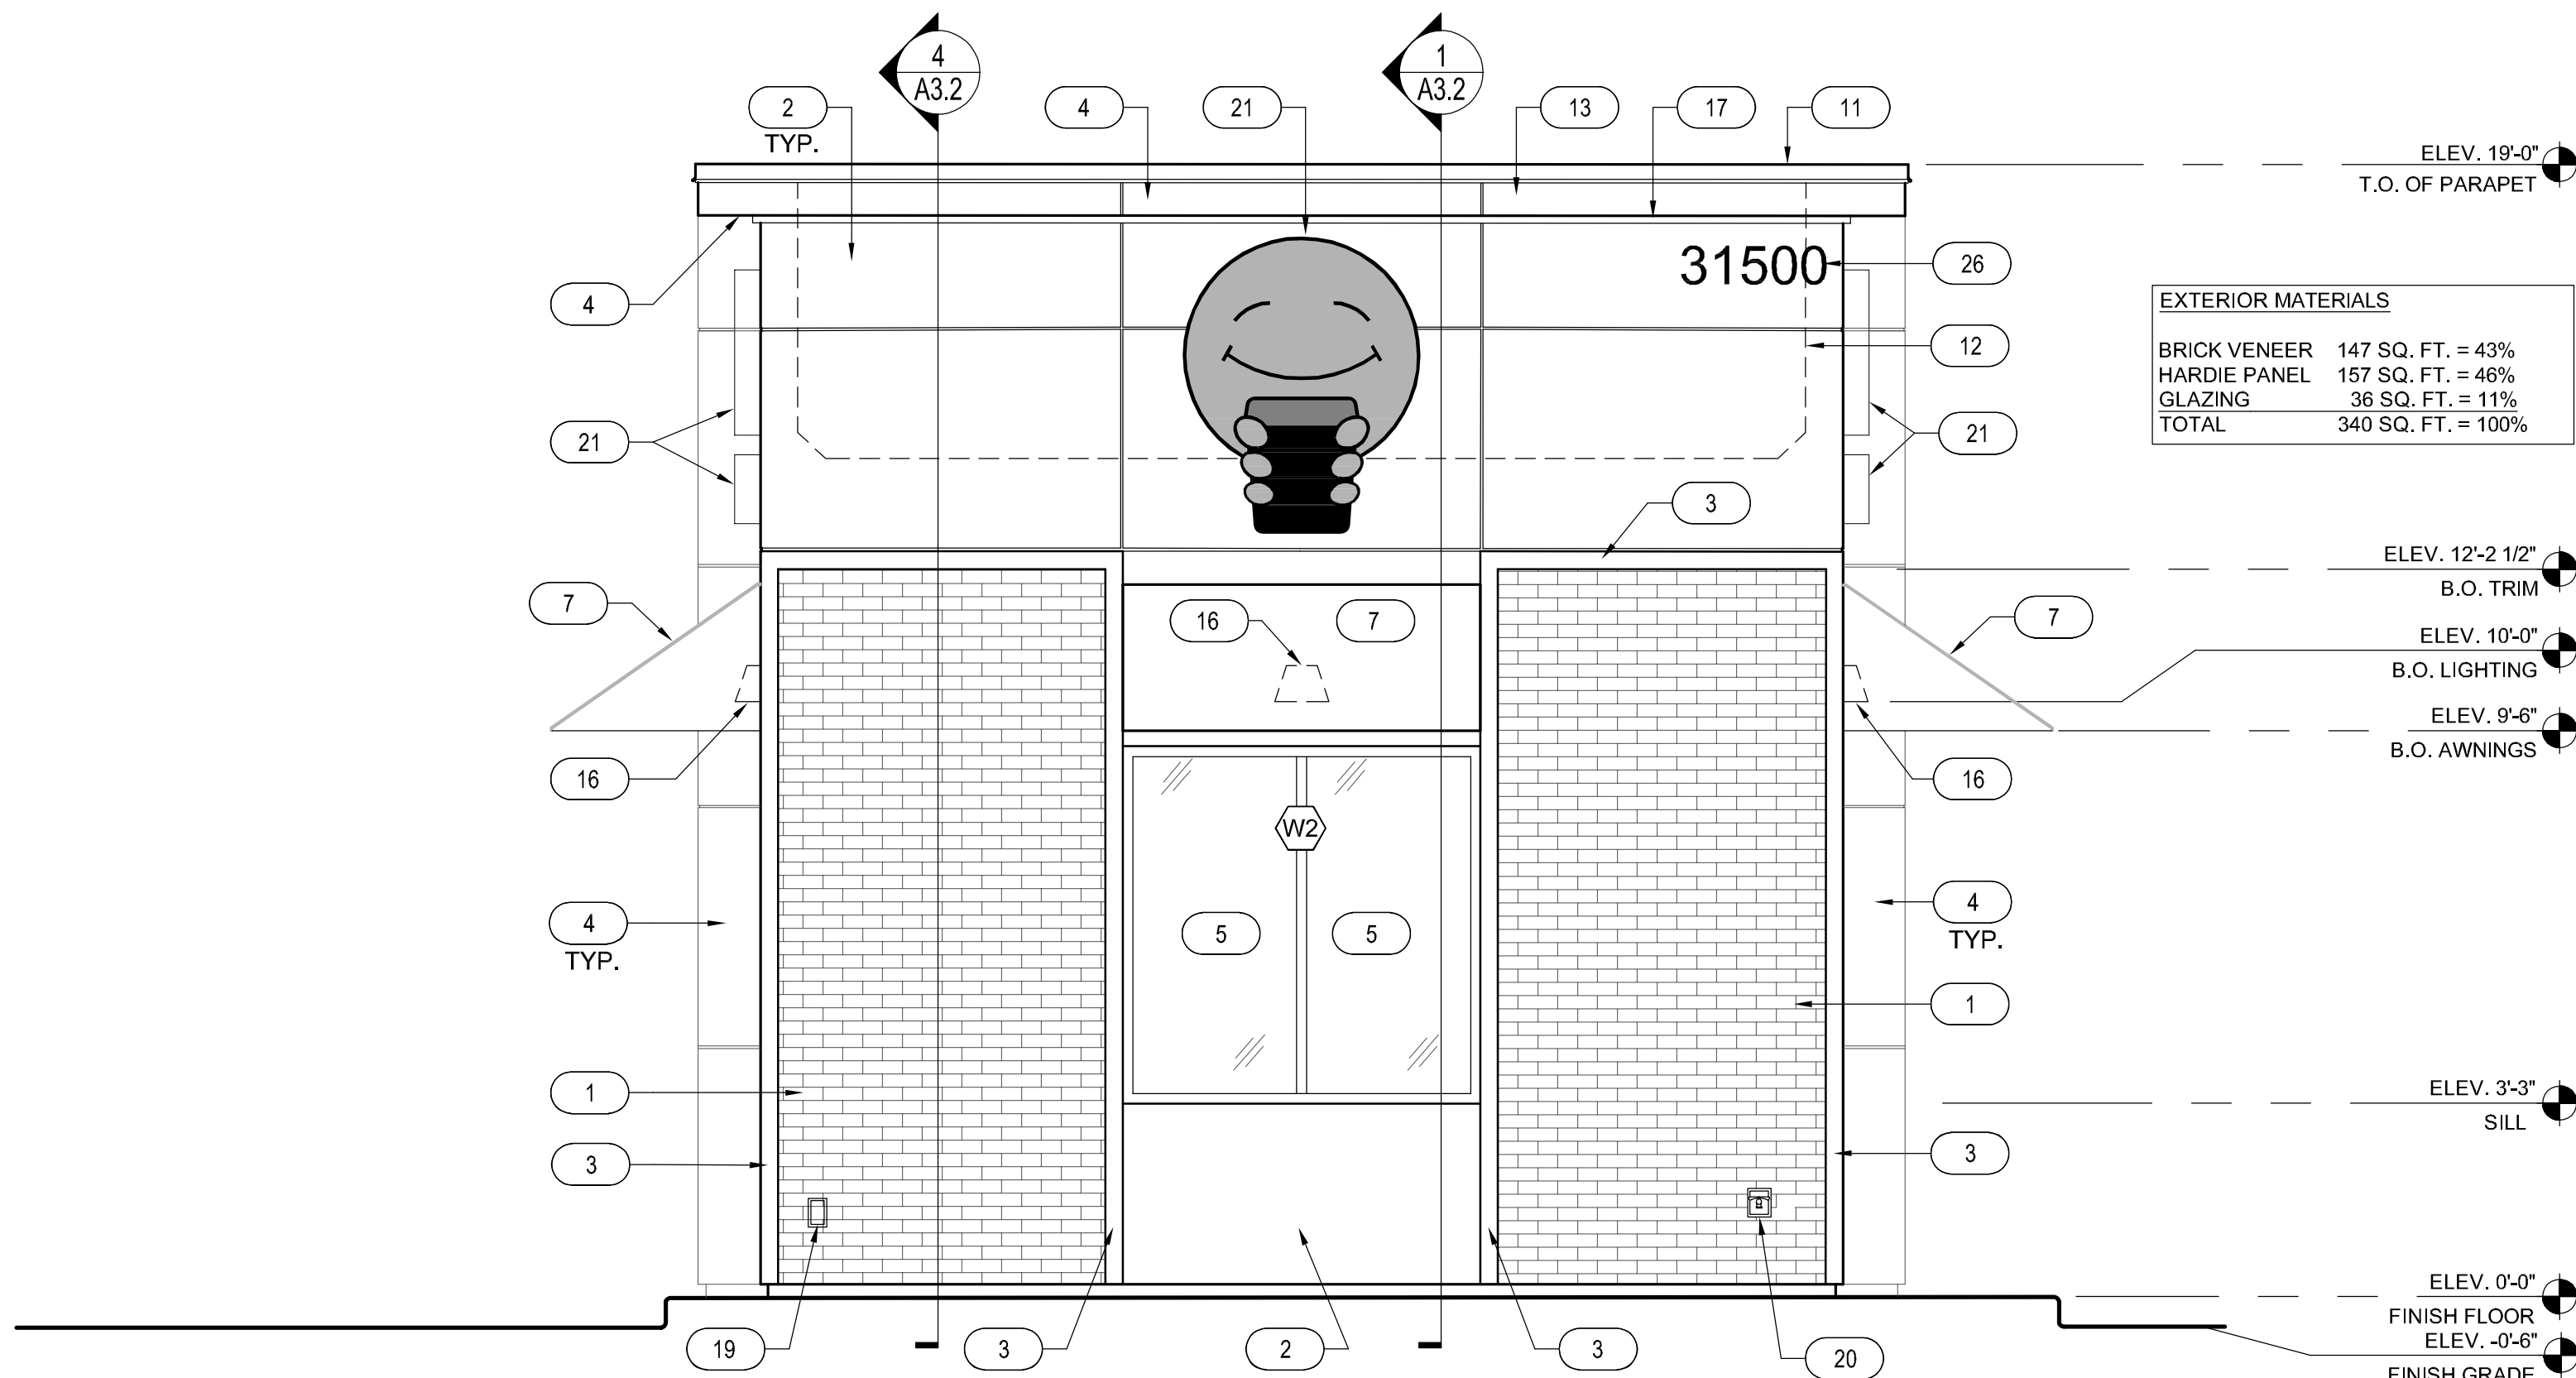

2 EAST ELEVATION
SCALE: 3/8" = 1'-0"

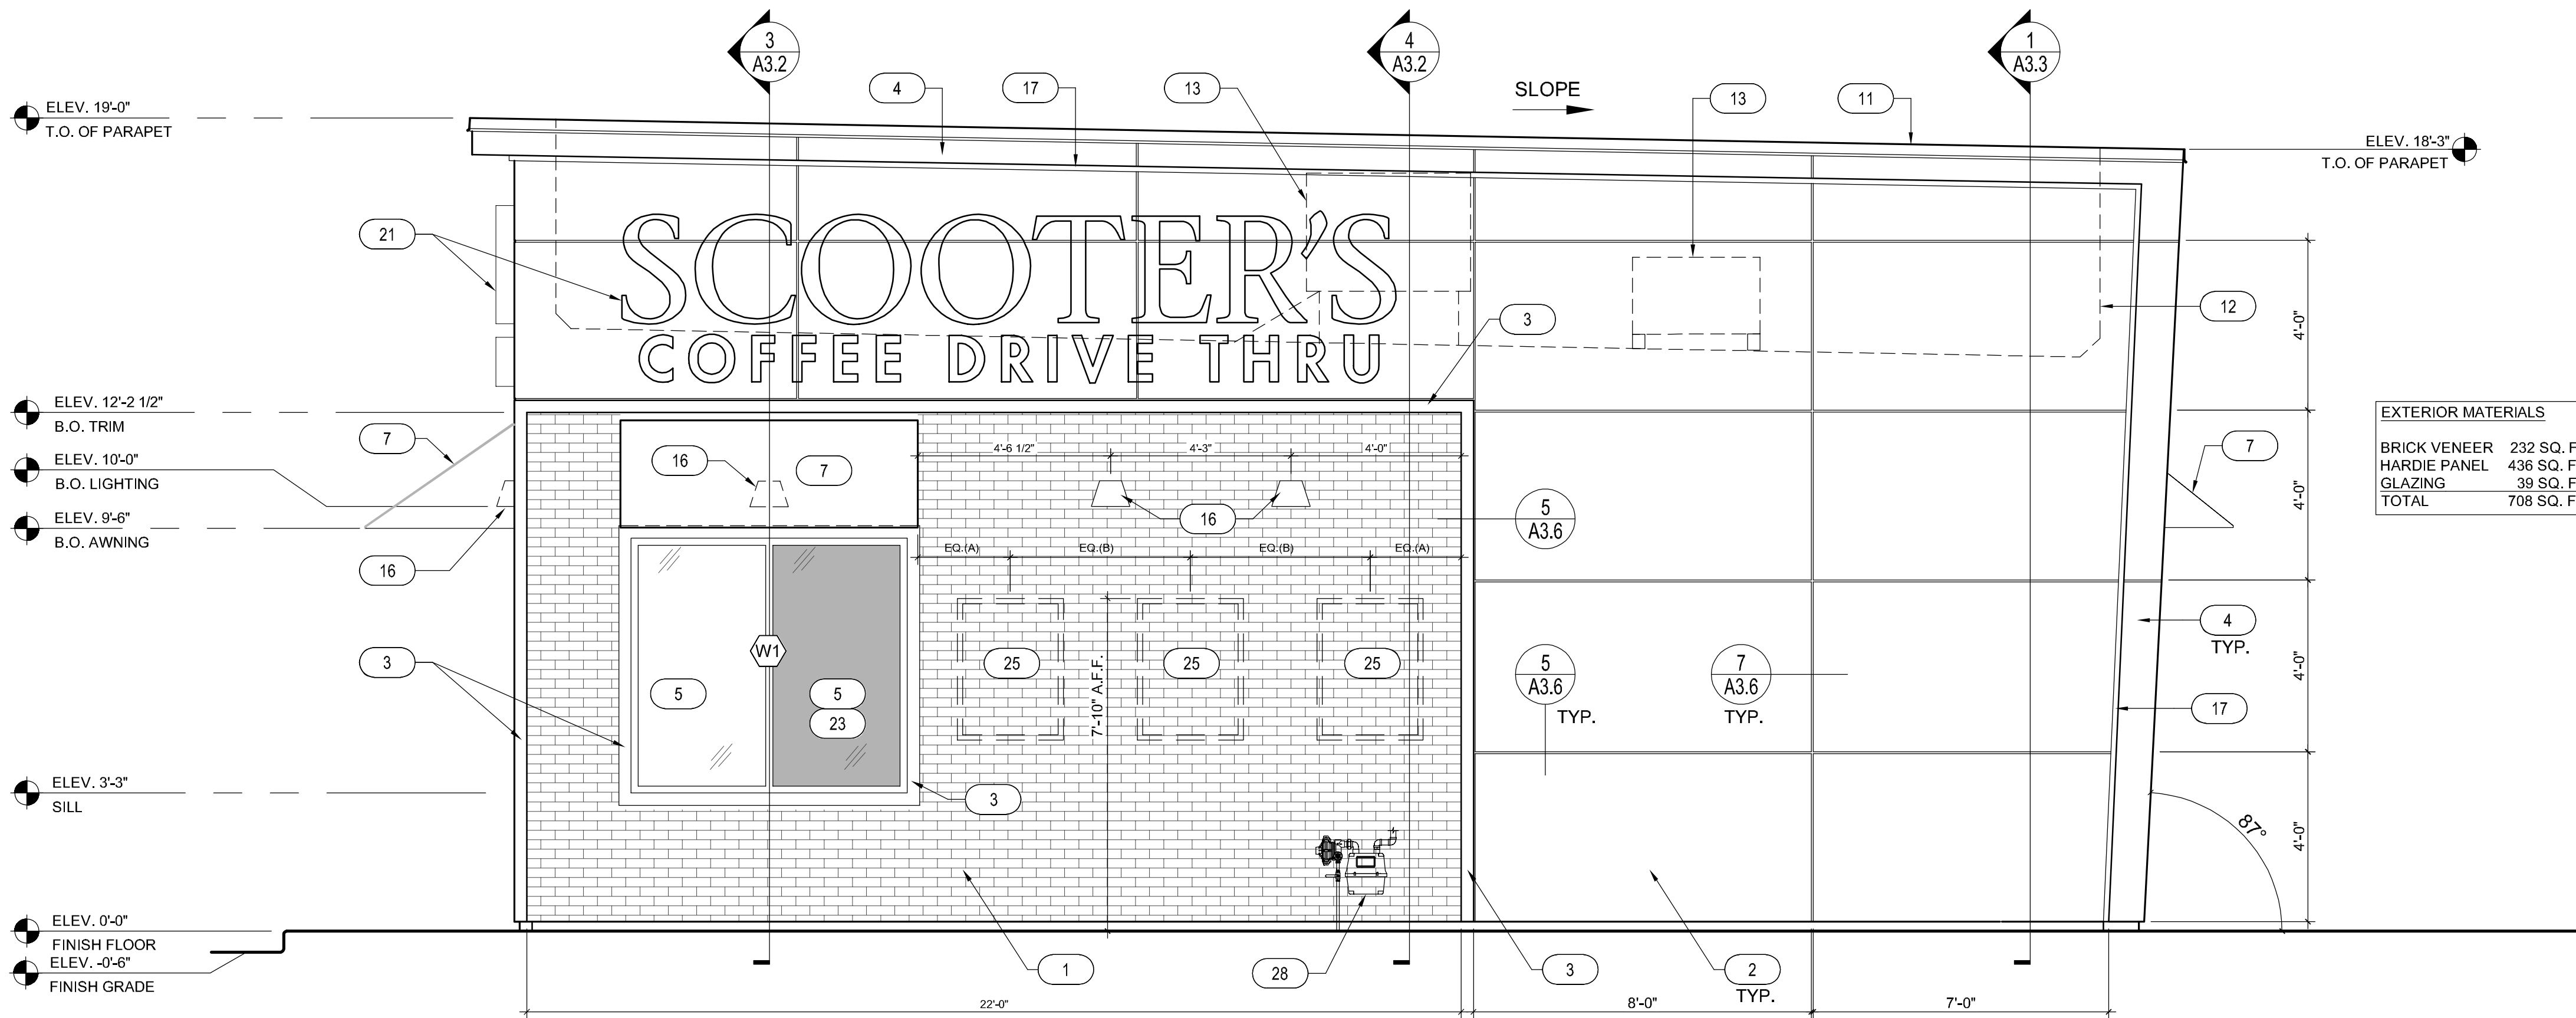

1 NORTH ELEVATION
SCALE: 3/8" = 1'-0"

KEYNOTES

1. ENDICOTT THIN BRICK VENEER, STACKED BOND - COLOR: MANGANESE IRONSPOT, SMOOTH FINISH, CLASS 1 MATERIAL PER FIGURE 152.392.01
2. 4' x 8' HARDIE PANEL, SMOOTH FINISH, COLOR: SW 1015 SKYLINE STEEL. REFER TO SHEET A3.6 FOR HARDIE PANEL DETAILS
3. 3 1/2" HARDIE TRIM. SEE HARDIE DETAIL SHEET A3.6
COLOR: SHERWIN WILLIAMS SW6992 INKWELL EGGSHELL FINISH. PRODUCT: SUPERPAINT STAIN.
4. HARDIE PANEL FASCIA AND SOFFITS, COLOR: SW6992 INKWELL. REFER TO SHEET A3.6 FOR HARDIE PANEL DETAILS. ALLURA SIDING ACCEPTABLE ALTERNATE TO HARDIE BOARD.
5. INSULATED DARK BRONZE ALUMINUM WINDOWS WITH DUAL PANE TEMPERED GLASS.
6. QUIKSERV WINDOW - COLOR: DARK BRONZE; REFER TO DOOR SCHEDULE SHEET A5.1
7. AWNING BY COOL PLANET - FABRIC: SUNBRELLA, COLOR: LOGO RED. PROVIDED AND INSTALLED BY G.C. (UNDER SEPARATE PERMIT, IF REQUIRED).
8. INSULATED HOLLOW METAL DOOR AND FRAME - COLOR: SHERWIN WILLIAMS SW6992 INKWELL EGGSHELL FINISH. PRODUCT: PROINDUSTRIAL W/B ALKYD URETHANE - S/G.
9. PEEP HOLE, BY DOOR MANUFACTURER
10. DOOR BELL
11. 20 GAUGE METAL PARAPET CAP - COLOR: MATTE BLACK
12. LINE OF ROOF BEYOND
13. ROOF TOP UNIT BEYOND, REFER TO MECHANICAL DRAWINGS
14. ROOF SCUPPER AND DOWNSPOUT, REFER TO DETAIL 8/A3.4
15. CONTRACTOR SHALL PROVIDE A BLACK MAILBOX APPROXIMATELY 15 INCHES WIDE BY 6 INCHES TALL. MAILBOX SHALL BE EQUAL TO GIBALTAR WALL MOUNTED METAL BOX
16. WALL MOUNTED LIGHT FIXTURE, REFER TO ELECTRICAL DRAWINGS
17. LED LIGHT BAND, REFER TO ELECTRICAL DRAWINGS
18. ELECTRICAL SERVICE, REFER TO ELECTRICAL DRAWINGS
19. ELECTRICAL OUTLET, SEE ELECTRICAL DRAWINGS
20. HOSE BIBB, SEE PLUMBING DRAWINGS
21. SIGNAGE BY OTHERS, UNDER A SEPARATE PERMIT
22. SEE DETAIL 7/A3.4 FOR DOWNSPOUT TERMINATION & SPLASHBLOCK
23. SPANDREL GLASS; REFER TO WINDOW SCHEDULE
24. SECURITY CAMERA BY OTHERS
25. OWNER PROVIDED SIGN PANELS.
26. APPROVED SET OF NUMERALS, MINIMUM 4" HIGH WITH A STROKE WIDTH NOT LESS THAN 1/2 INCH. SHALL BE PLACED ON THE BUILDING. VERIFY SIZE AND REQUIREMENTS WITH FIRE MARSHAL.
27. KNOX BOX AT 60" A.F.F. AS REQUIRED BY FIRE DEPARTMENT.
28. GAS METER; REFER TO PLUMBING PLANS.
29. SCHIER GREASE TRAP PUMP-OUT PORT PP3, PAINT TO MATCH EXTERIOR FINISH.

REGISTRATION SEAL

NOT FOR
CONSTRUCTION

ARCVISION
ARCHITECTURE • ENGINEERING
1950 CRAIG ROAD, SUITE 300
ST. LOUIS, MO 63146
(314) 415-2400
WWW.ARCV.COM



REV	DATE	DESCRIPTION	BY
1			
2			
3			
4			
5			
6			
7			
8			
9			

TITLE:
EXTERIOR
ELEVATIONS

PROJECT ADDRESS:
SWC SUNWOOD DR. NW
& RAMSEY BLVD. NW,
RAMSEY, MN 55303
FRANCHISEE & STORE NUMBER:
SCOOTER'S COFFEE #2965
DANIEL & NATALIE DEWEY

KIOSK PROTOTYPE:
4.3 STANDARD PROTOTYPE
FEBRUARY 2026
ISSUE DATE:
07/XX/2026
PROJECT NO.
260351
DRAWN BY:
AGG
CHECKED BY:
MD

SHEET NO.

A2.2